


UTILITY PLAN REFERENCE / NOTES:

- SEE CONTRACT NO. 3 LOWER FORE RIVER INTERCEPTOR PLAN SET BY CAMP, DRESSER & MCKEE, INC. PREPARED FOR PORTLAND WATER DISTRICT LAST REVISED 08.81 - REVISED FOR RECORD DRAWING. AVAILABLE FROM PORTLAND WATER DISTRICT.
- ALL UTILITY LOCATIONS ON THIS PLAN SHALL BE CONSIDERED APPROXIMATE AND SHALL BE CONFIRMED IN THE FIELD BY THE SERVING UTILITY. NORTHERN UTILITIES SHALL CONFIRM LOCATION AND CONDITION OF OLD GAS MAINS IN THE PROJECT VICINITY.
- EXACT LOCATION OF NEW YARD POWER / COMMUNICATIONS / CABLE SERVICE TO BE COORDINATED WITH MEDOT. ADDITIONAL UTILITY MANHOLES FOR TELECOMMUNICATIONS MAY BE REQUIRED.

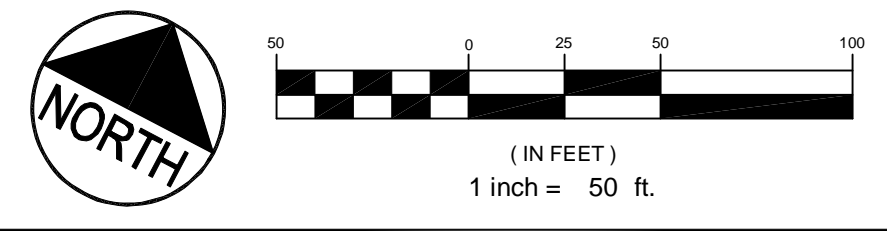

| | | | |
|---|---|---|--|
| | | PROJECT CANAL LANDING AMENDED SITE PLAN SHEET TITLE AMENDED UTILITY PLAN | DRAWN: CMW DESIGNED: SRB CHECKED: SRB FILE NAME: 3091.03-UTILITY SHEET C-4.1 |
| CLIENT NEW YARD LLC 58 FORE STREET PORTLAND, ME 04101 | DATE: JUNE 2014 SCALE: 1" = 50' JOB NO. 3091.03 | PROJECT FAY, SPOFFORD & THORNDIKE ENGINEERS - PLANNERS - SCIENTISTS 778 MAIN ST., SUITE 8, SOUTH PORTLAND, ME 04106 | |
| REV. DATE DESCRIPTION REVISIONS 1 07.02.14 AMENDED SITE PLAN TO CITY OF PORTLAND P.E. STEPHEN BUSHEY LIC. # 7429 | | | |