





75 York Street
Portland, Maine 04101
simonsarchitects.com
207.772.4656


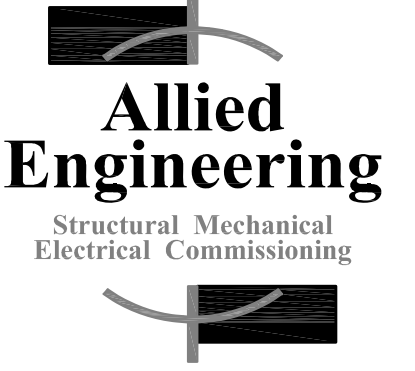


160 Veranda Street
Portland, Maine 04103
T: 207.221.2260
F: 207.221.2266
Web: www.allied-eng.com

Allied Project No: 15051
Cad File: 15051M.dwg

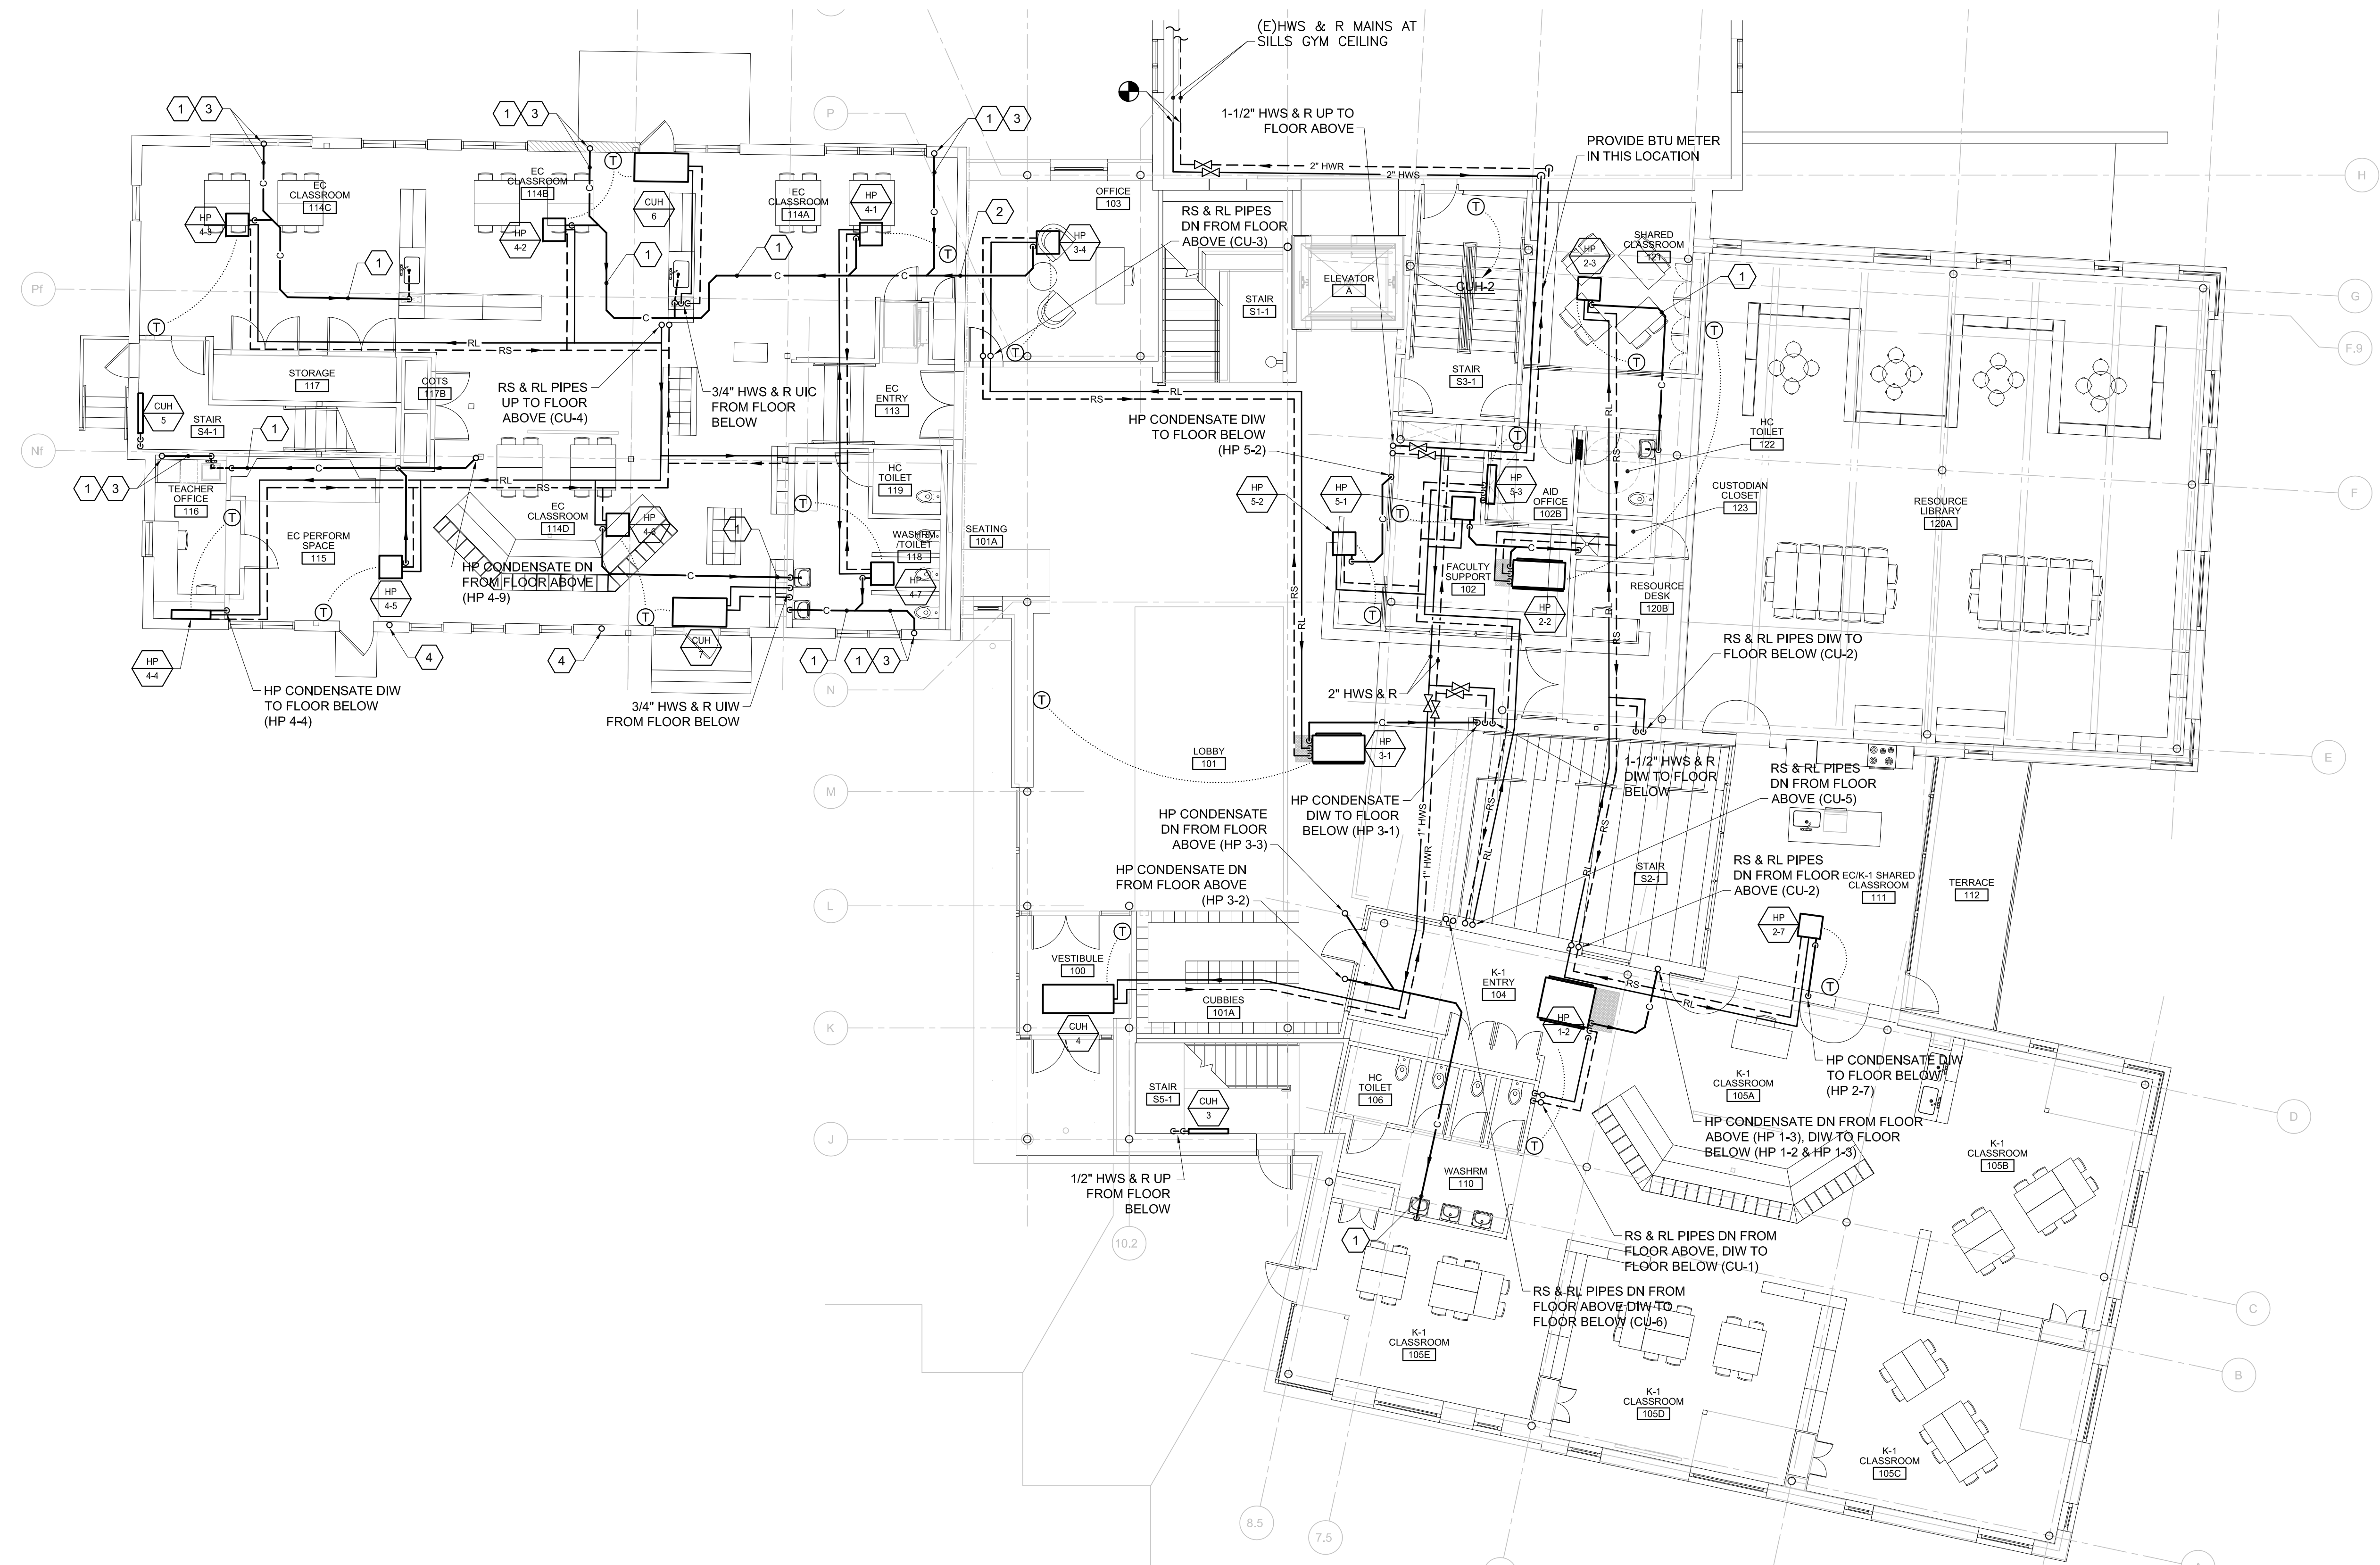

- KEYED NOTES:**
- 1 ROUTE HEAT PUMP CONDENSATE LINE TO TAILPIECE CONNECTION AT SINK. FOR DETAIL SEE A1 - SHEET MP101
 - 2 PROVIDE PIPE EXPANSION LOOP AT BUILDING EXPANSION JOINT.
 - 3 CONDENSATE DRAIN DOWN IN EXTERIOR WALL FROM FLOOR ABOVE. ROUTE ON WARM SIDE OF BUILDING INSULATION.
 - 4 CONDENSATE DRAIN DOWN IN EXTERIOR WALL FROM FLOOR ABOVE ON WARM SIDE OF BUILDING INSULATION, DOWN TO FLOOR BELOW.

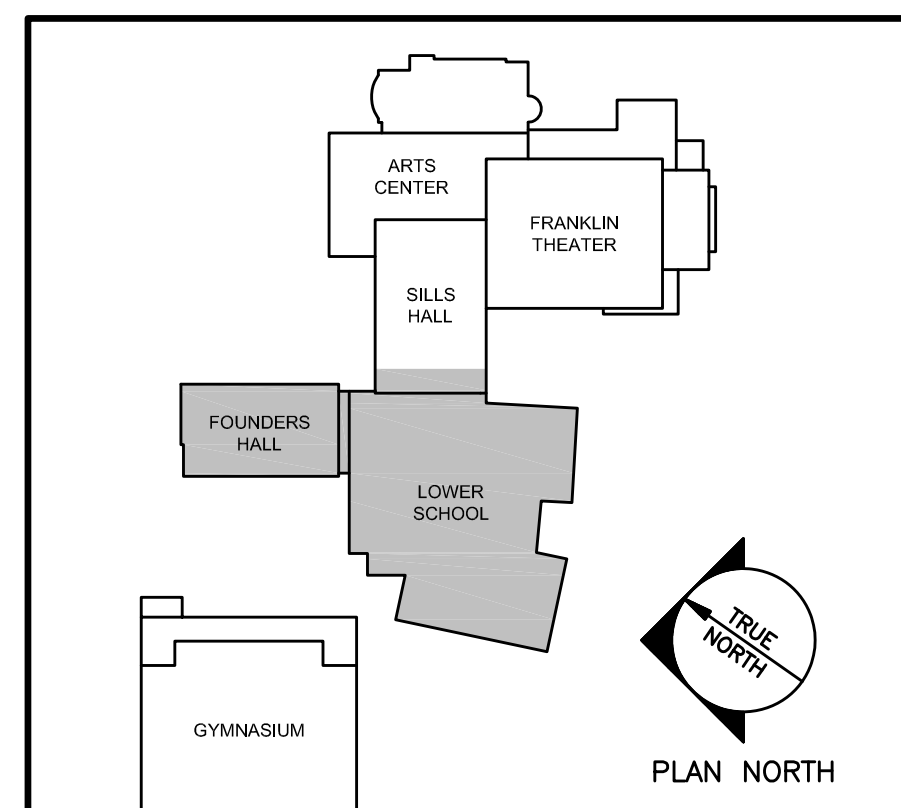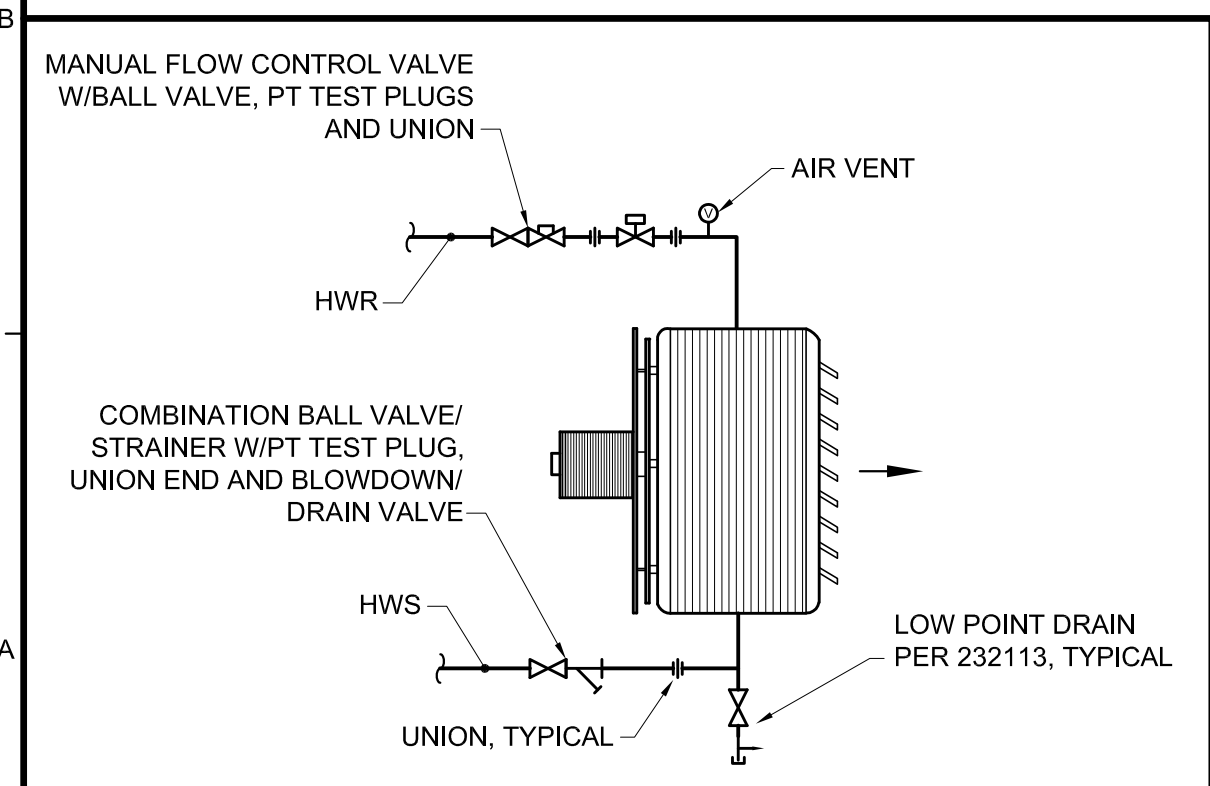

PROJECT NAME:
WAYNFLETE LOWER SCHOOL
ADDITION & RENOVATIONS

WAYNFLETE SCHOOL
360 SPRING STREET
PORTLAND, MAINE 04102



THIS DRAWING IS THE PROPERTY OF SCOTT SIMONS ARCHITECTS (SSA) AND IS NOT TO BE COPIED OR REPRODUCED IN PART OR WHOLE.
2015 © SCOTT SIMONS ARCHITECTS, LLC

REVISION:

NO.	DATE
1	DATE
2	DATE
3	DATE
4	DATE
5	DATE
6	DATE

DATE OF ISSUE: 12 JANUARY 2017
PROJECT NUMBER: 2013-0050
STATUS: ISSUED FOR BID

MECHANICAL PIPING PLAN ~ MAIN LEVEL

MP102

N:\Projects\2015\15051 - Waynflete School\00 Drawing Files\15051M.dwg Jan 11, 2017 - 10:00am

A1 DETAIL ~ UNIT HEATER PIPING
NOT TO SCALE

A3 MECHANICAL PIPING PLAN ~ MAIN LEVEL
1/8" = 1'-0"

A9 KEYED PLAN
NOT TO SCALE