





75 York Street
Portland, Maine 04101
simonsarchitects.com
207.772.4656

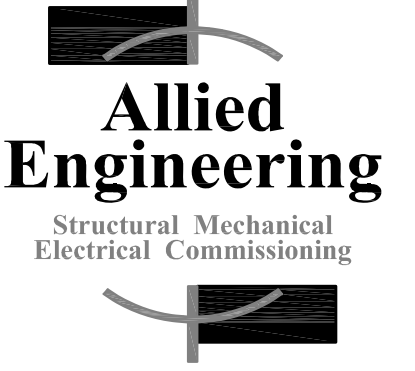


160 Veranda Street
Portland, Maine 04103
T: 207.221.2260
F: 207.221.2266
Web: www.allied-eng.com

Allied Project No: 15051
Cad File: 15051M.dwg

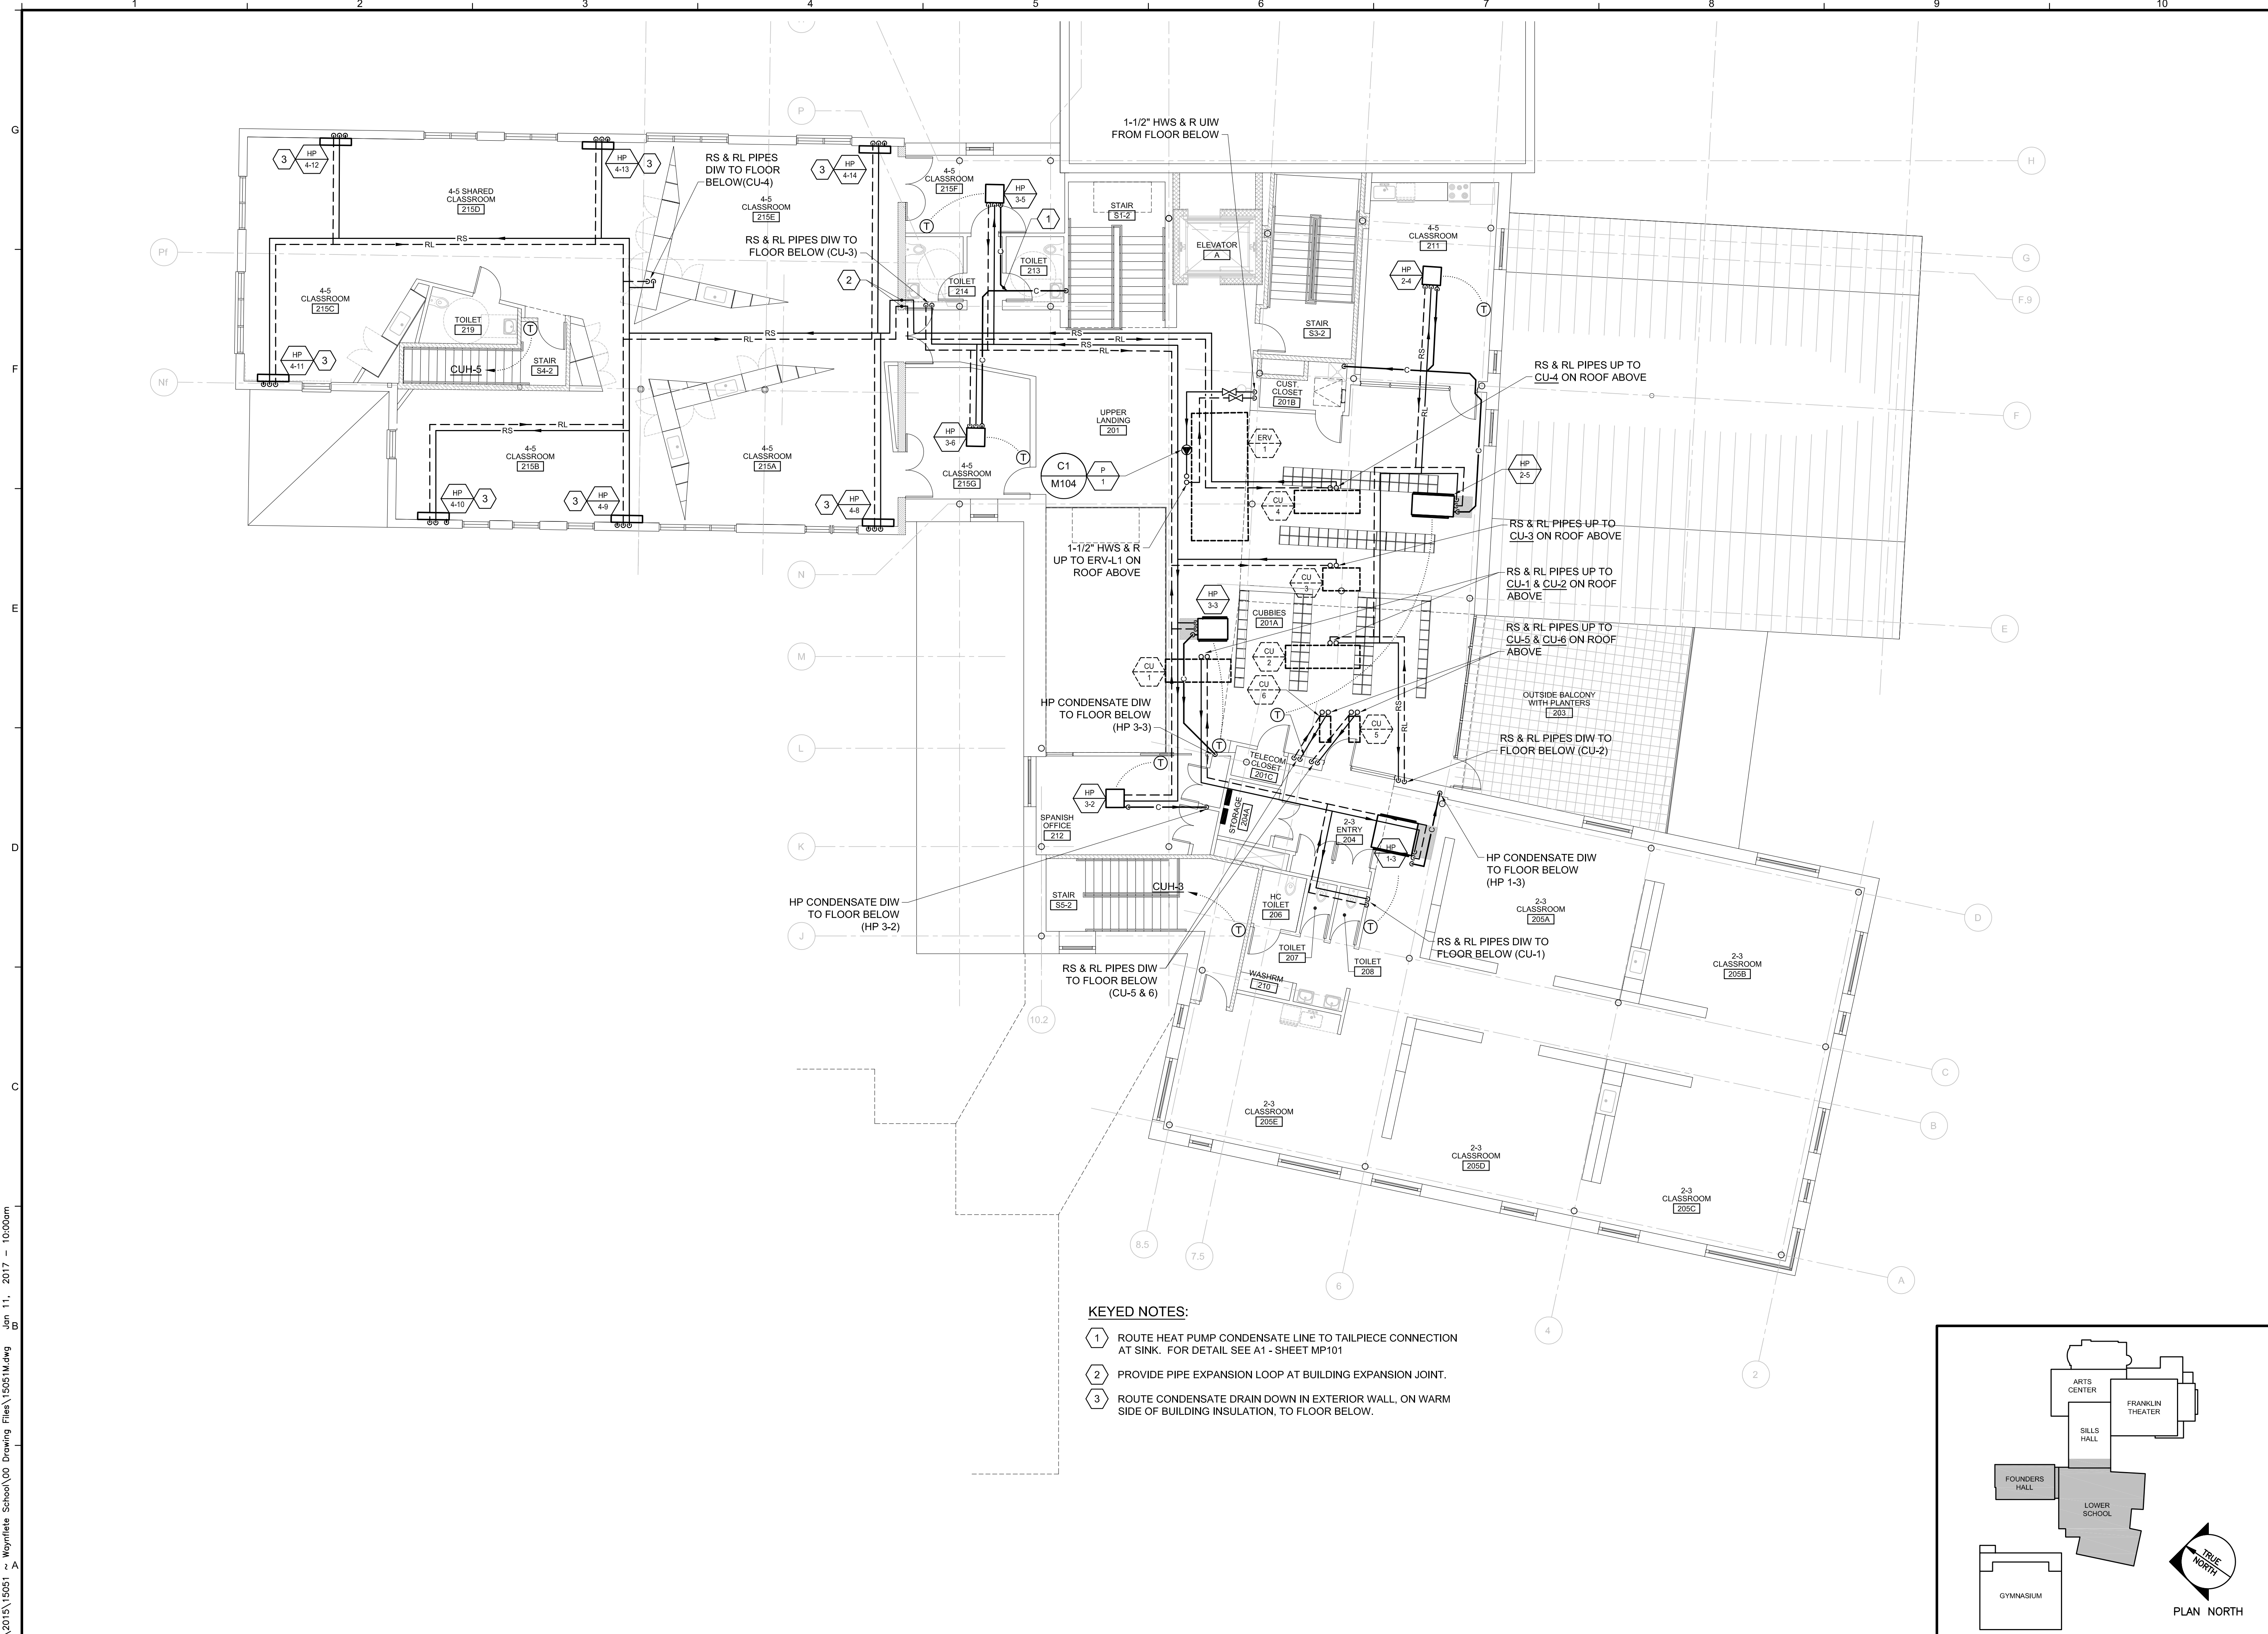

- KEYED NOTES:**
- 1 ROUTE HEAT PUMP CONDENSATE LINE TO TAILPIECE CONNECTION AT SINK. FOR DETAIL SEE A1 - SHEET MP101
 - 2 PROVIDE PIPE EXPANSION LOOP AT BUILDING EXPANSION JOINT.
 - 3 ROUTE CONDENSATE DRAIN DOWN IN EXTERIOR WALL, ON WARM SIDE OF BUILDING INSULATION, TO FLOOR BELOW.

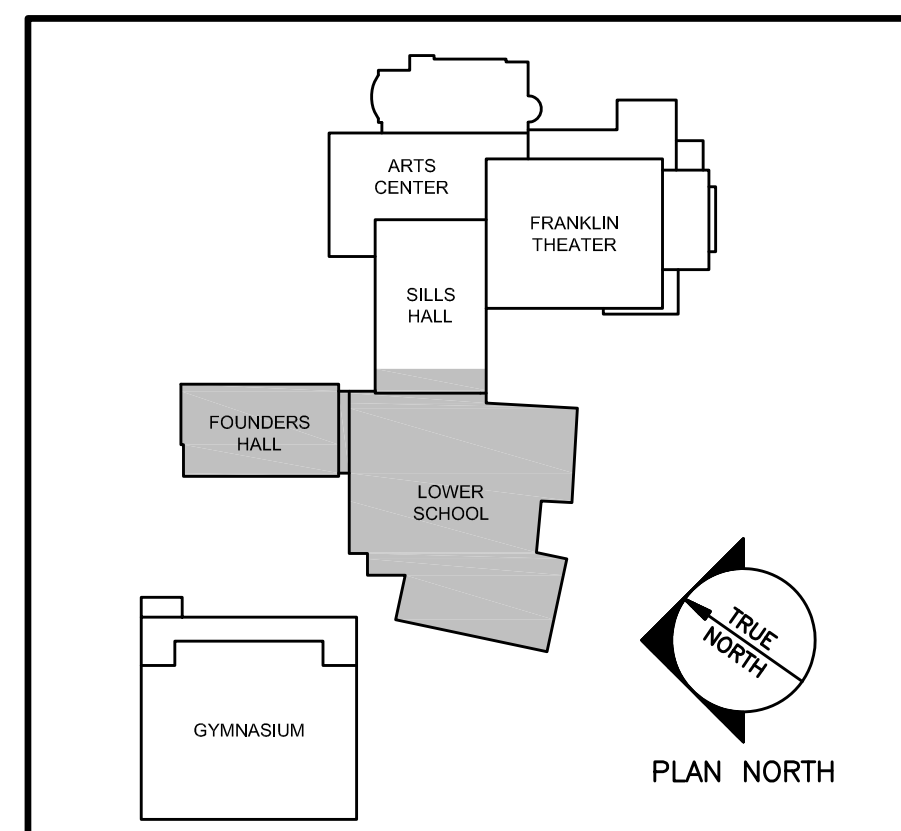

PROJECT NAME:
WAYNFLETE LOWER SCHOOL
ADDITION & RENOVATIONS

WAYNFLETE SCHOOL
360 SPRING STREET
PORTLAND, MAINE 04102



THIS DRAWING IS THE PROPERTY OF SCOTT SIMONS ARCHITECTS (SSA) AND IS NOT TO BE COPIED OR REPRODUCED IN PART OR WHOLE.
2015 © SCOTT SIMONS ARCHITECTS, LLC

REVISION:

NO.	DATE
1	DATE
2	DATE
3	DATE
4	DATE
5	DATE
6	DATE

DATE OF ISSUE: 12 JANUARY 2017
PROJECT NUMBER: 2013-0050
STATUS: ISSUED FOR BID

MECHANICAL PIPING PLAN ~ UPPER LEVEL

MP103

A1	MECHANICAL PIPING PLAN ~ UPPER LEVEL	A9	KEYED PLAN
1/8" = 1'-0"		NOT TO SCALE	

N:\Projects\2015\15051 - Waynflete School\00 Drawing Files\15051M.dwg Jan 11, 2017 - 10:00am