


REVISION:

NO.	DATE
1	DATE
2	DATE
3	DATE
4	DATE
5	DATE
6	DATE

DATE OF ISSUE: 12 JANUARY 2017  
PROJECT NUMBER: 2013-0050  
STATUS: ISSUED FOR BID



**SANITARY  
PIPING PLAN ~  
MAIN LEVEL**

**PL102**

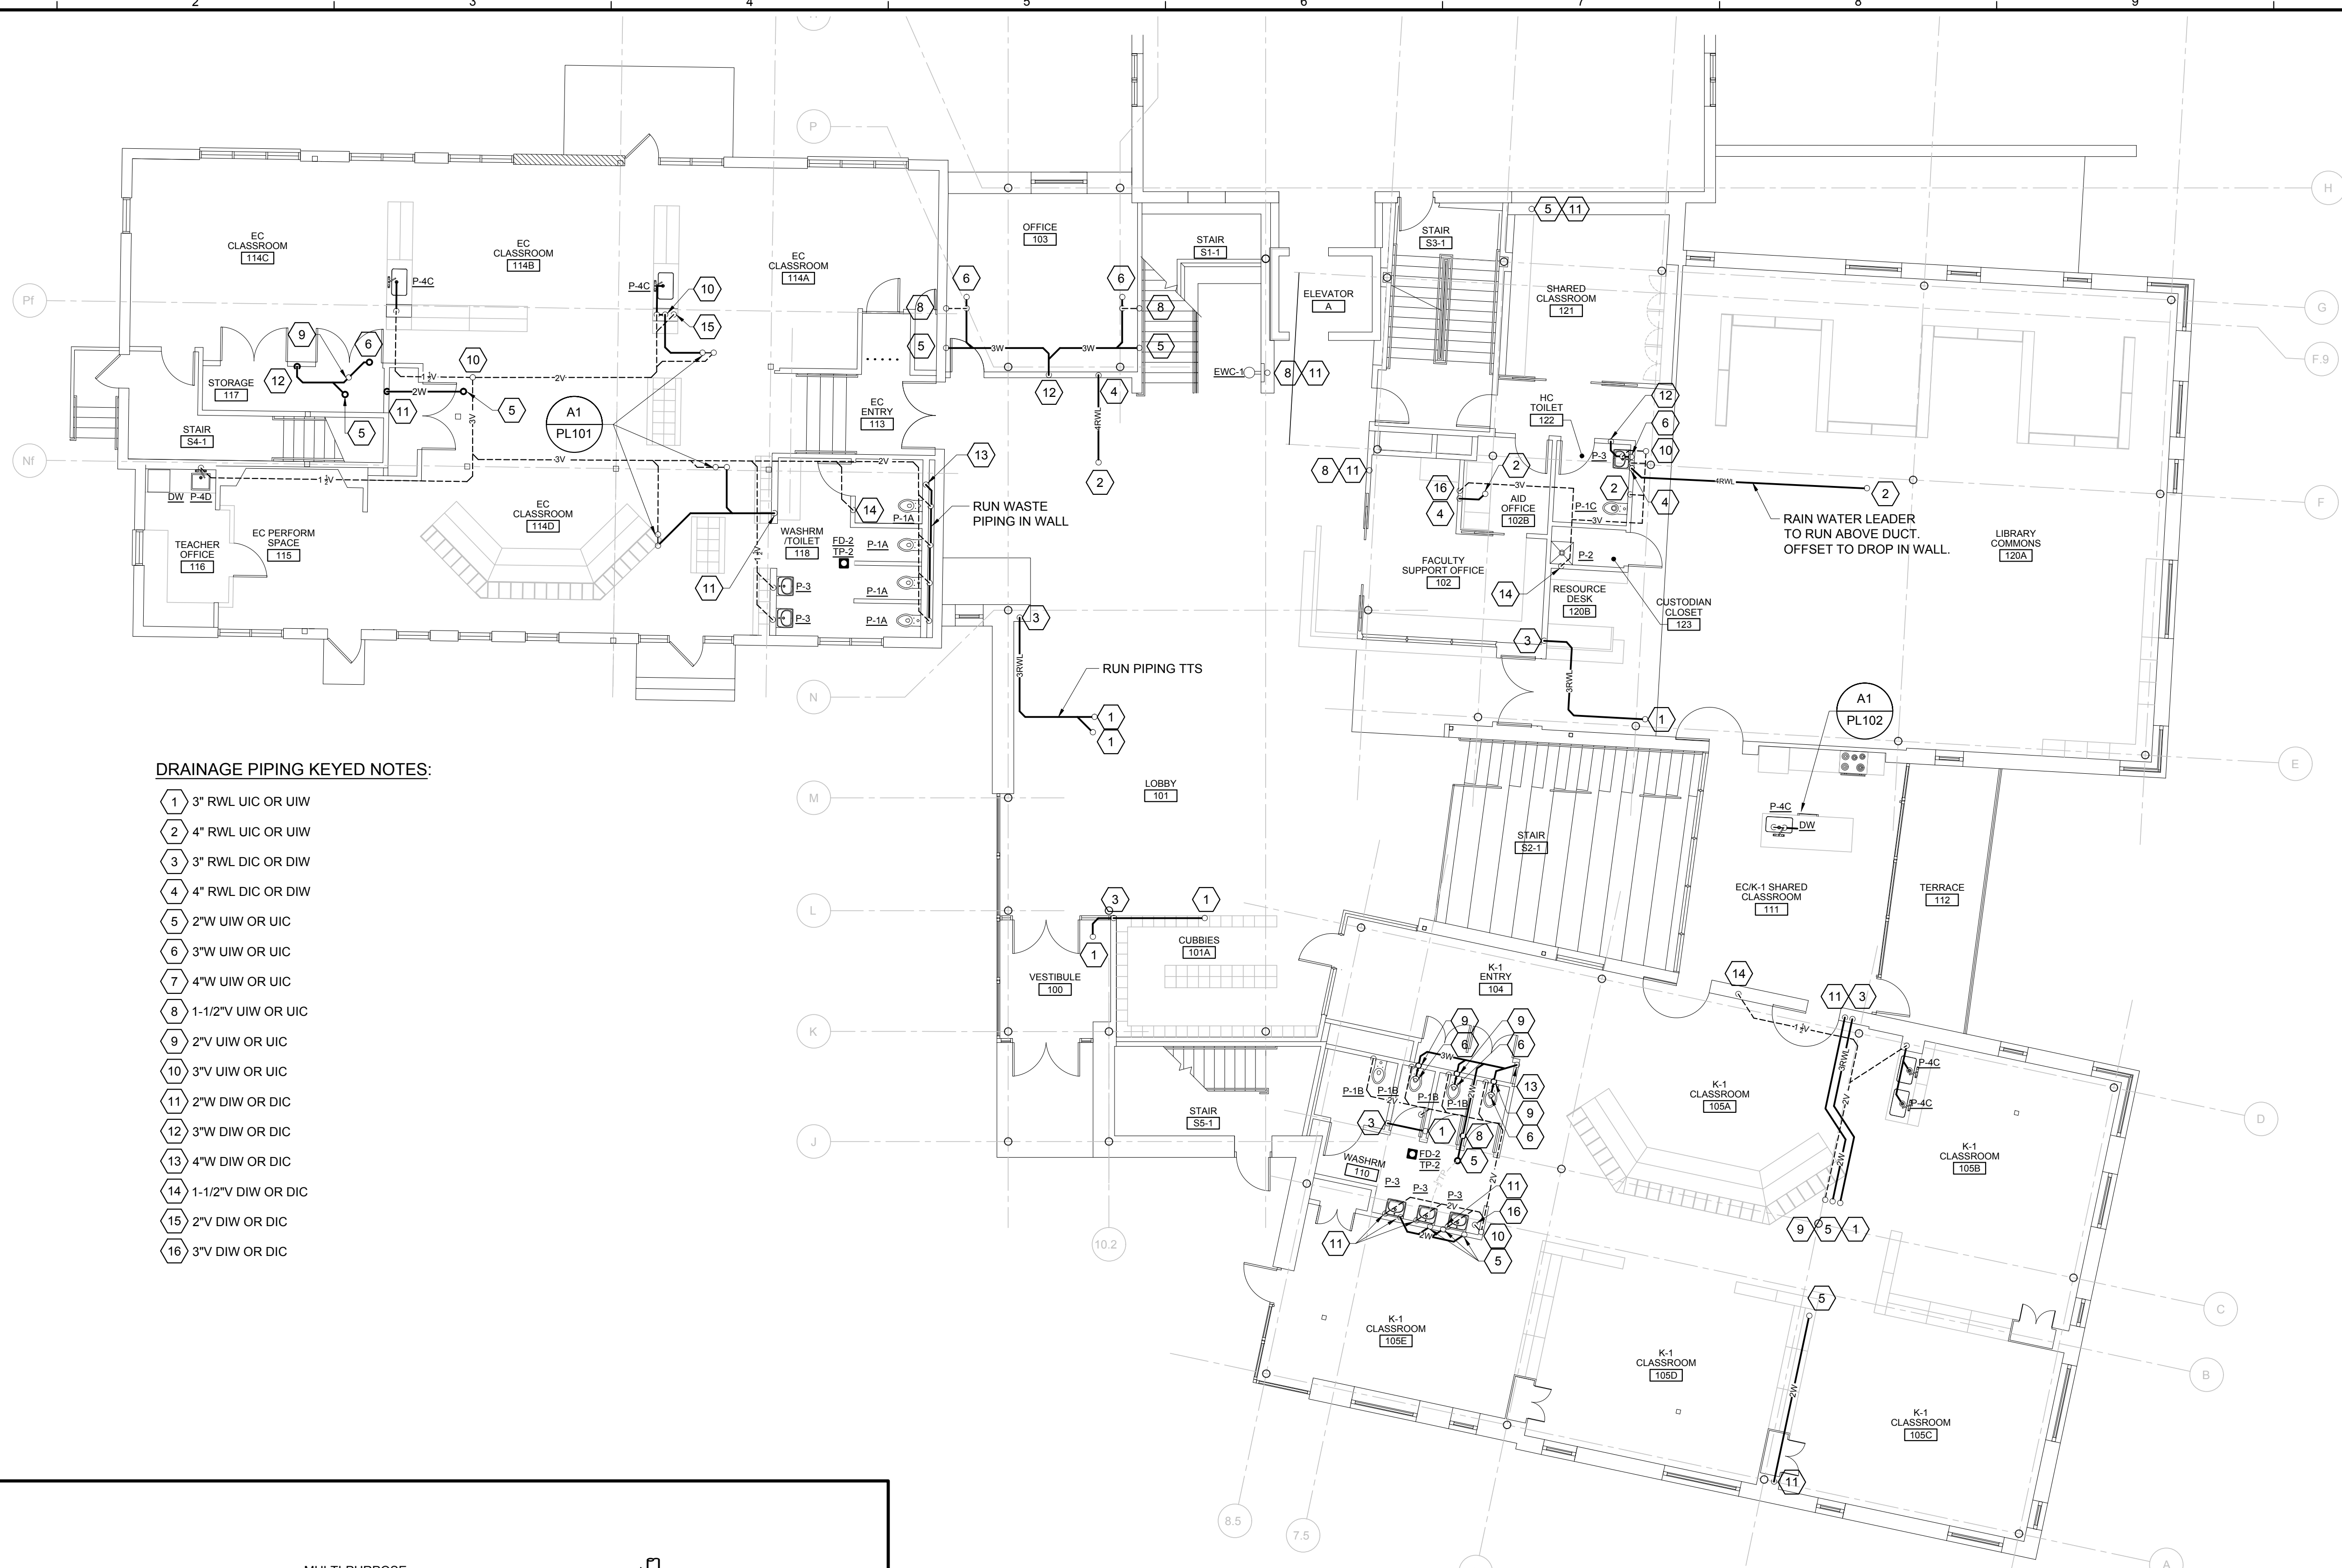

**DRAINAGE PIPING KEYED NOTES:**

- 1 3" RWL UIC OR UIW
- 2 4" RWL UIC OR UIW
- 3 3" RWL DIC OR DIW
- 4 4" RWL DIC OR DIW
- 5 2"W UIW OR UIC
- 6 3"W UIW OR UIC
- 7 4"W UIW OR UIC
- 8 1-1/2"V UIW OR UIC
- 9 2"V UIW OR UIC
- 10 3"V UIW OR UIC
- 11 2"W DIW OR DIC
- 12 3"W DIW OR DIC
- 13 4"W DIW OR DIC
- 14 1-1/2"V DIW OR DIC
- 15 2"V DIW OR DIC
- 16 3"V DIW OR DIC

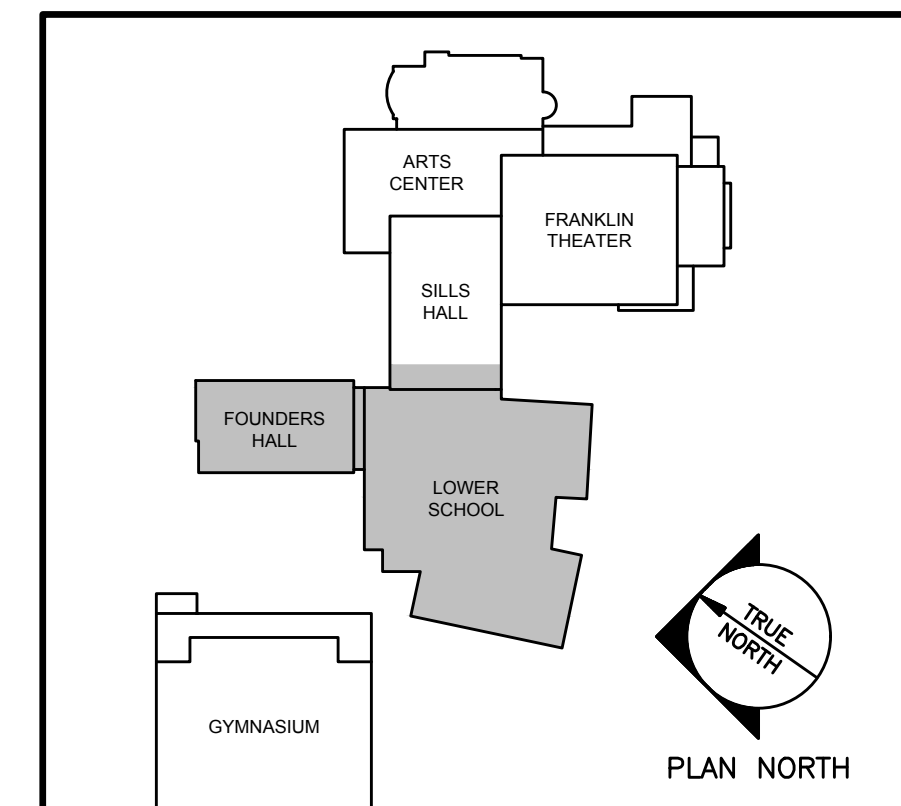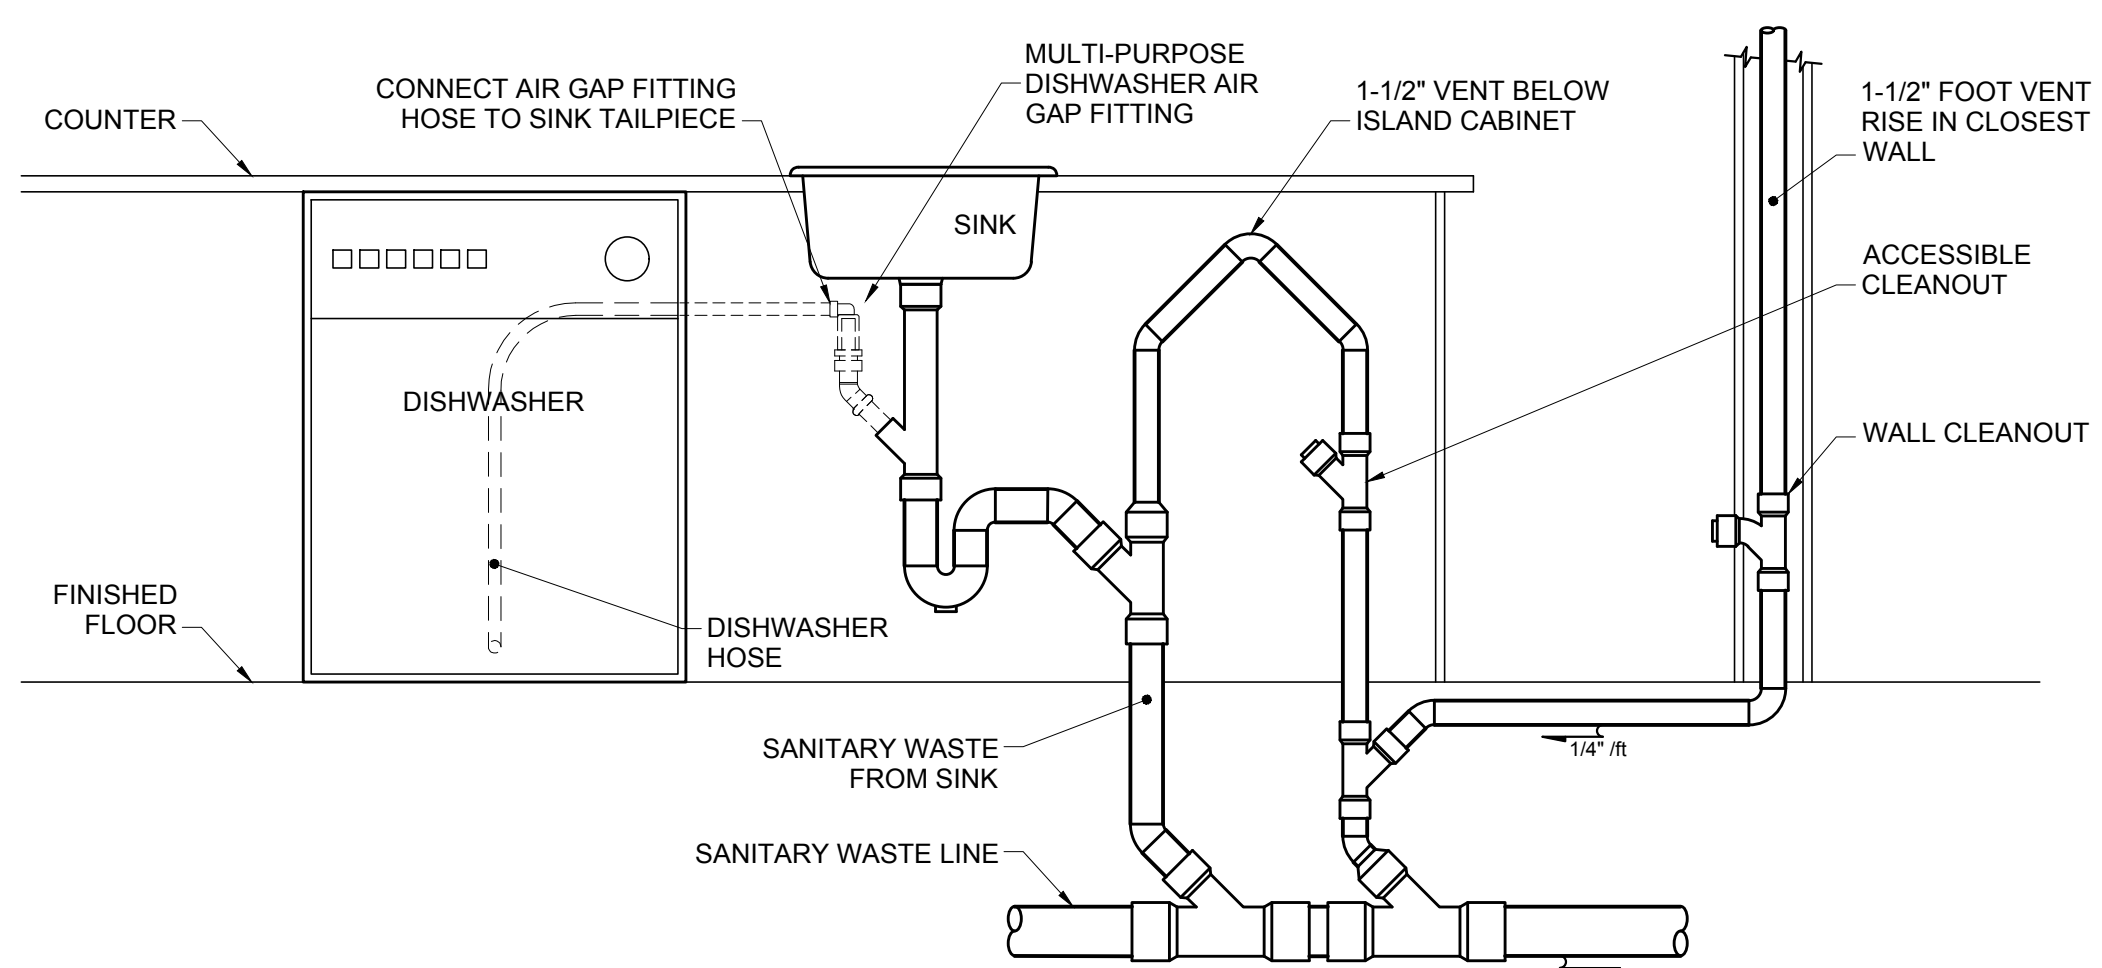

N:\Projects\2015\15051 - Waynflete School\00 Drawing Files\15051P.dwg Jan 11, 2017 - 10:24am

A1	DETAIL ~ DISHWASHER AND SINK ISLAND PIPING	A5	SANITARY PIPING PLAN ~ MAIN LEVEL	A9	KEYED PLAN
NOT TO SCALE		1/8" = 1'-0"		NOT TO SCALE	