

**GYM NOTES:**  
 1) PROVIDE FULL WIRE GUARDS FOR ALL DEVICES IN GYM, TYPICAL.  
 2) WIRING ON GYM WALLS TO BE INSTALLED IN SURFACE MOUNTED WIREMOLD TYPE RACEWAY.

**ALTERNATE #18 - H-1 HUMIDIFIER**  
 SUSPENDED FROM BAR JOISTS. COORDINATE WITH OTHER TRADES.  
 COORDINATE EXACT LOCATION OF UNIT WITH MECHANICAL DRAWINGS.


**ALTERNATE #14 - GYM AC**  
 COORDINATE EXACT LOCATION OF UNIT WITH MECHANICAL DRAWINGS.  
 VAV-1 VAV-2 VAV-3 VAV-4

**ALTERNATE #11 - DCU-1 CONDENSER FOR DRAMA ROOM**  
 #114 AIR CONDITIONING SYSTEM. COORDINATE EXACT LOCATION OF UNITS WITH MECHANICAL DRAWINGS.  
**ALTERNATE #12 - DCU-2 CONDENSER FOR MUSIC ROOM**  
 #114 AIR CONDITIONING SYSTEM. COORDINATE EXACT LOCATION OF UNITS WITH MECHANICAL DRAWINGS.

**ALTERNATE #12 - DAC-2, MUSIC ROOM**  
 #114, DUCTLESS SPLIT AIR CONDITIONING SYSTEM. COORDINATE WITH OTHER TRADES.  
**HEAT EXCHANGER HX-2**  
 COORDINATE LOCATION AND REQUIREMENTS WITH OTHER TRADES.

**POWER AND SYSTEMS DRAWING KEY NOTES:**

- 1) PROVIDE (4) 3/4" CONDUITS IN SLAB AND UP WALL TO CONTROL ROOM. SEE SHEET E1.6 FOR CONTINUATION.
- 2) CONNECT TO JUNCTION BOX FOR SEATING AREA END OF ROW LIGHTING. COORDINATE WITH SEATING SUPPLIER AND INSTALLER. SEE DETAIL THIS SHEET, TYPICAL.
- 3) MOUNT BATTERY UNITS AT 6'-6" AFF TO BOTTOM OF UNITS. (TYP)
- 4) LIGHTING CONTROL RELAY PANEL. SEE DETAIL ON DRAWING E-1.10
- 5) THREE COMPARTMENT FLOOR BOX. MOUNT FLUSH IN LAST POURED FLOOR SECTION IN CENTER. PROVIDE POWER RECEPTACLE, MIC JACK, DMX STAGE LIGHTING JACK AND SOUND BOARD JACK.
- 6) CONNECT ALL NEW EXIT SIGNS ON FIRST FLOOR TO PANEL PP4 CIRCUIT #5, TYPICAL.

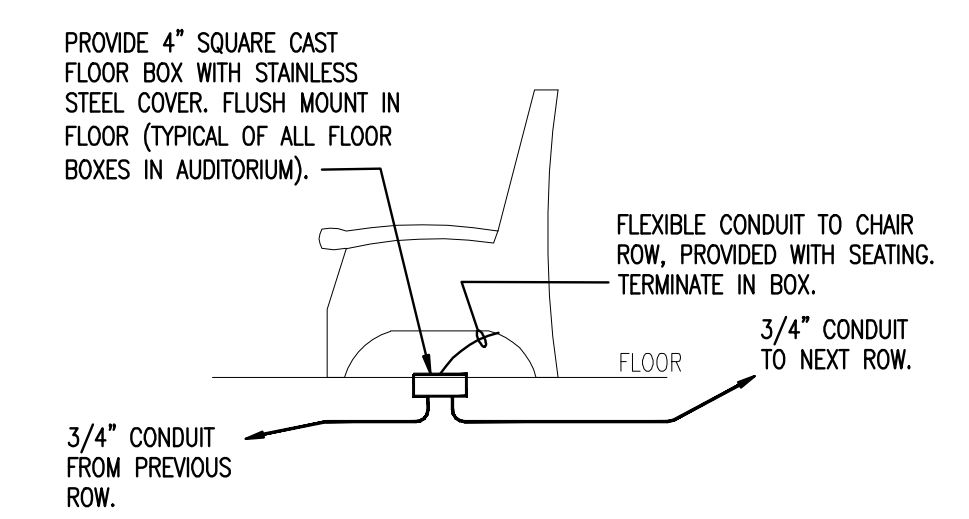

**AUDITORIUM SEATING DETAIL**  
 N.T.S.



THIS DRAWING IS THE PROPERTY OF SCOTT SIMONE ARCHITECTS AND IS NOT TO BE COPIED OR REPRODUCED IN PART OR WHOLE.

**PROJECT**  
**WAYNFLETE ARTS CENTER**  
**PHASE TWO**

**ADDITION/ RENOVATION**  
**360 SPRING STREET**  
**PORTLAND, ME**

**TITLE**  
**ELECTRICAL**  
**POWER & SYSTEMS**  
**FIRST FLOOR PLAN**

**STATUS:** ISSUED FOR BIDDING

DATE: 08/27/2007	REVISION /DATE:
SCALE: 1/8" = 1'-0"	
PROJECT NO. 2005-0040.00	
DRAWN BY: FLB/PJR	2004 © Scott Simone Architects
DWG NO.	

**E-1.4**