


A1 ELECTRICAL SITE PLAN
SCALE: 1"=10'-0"

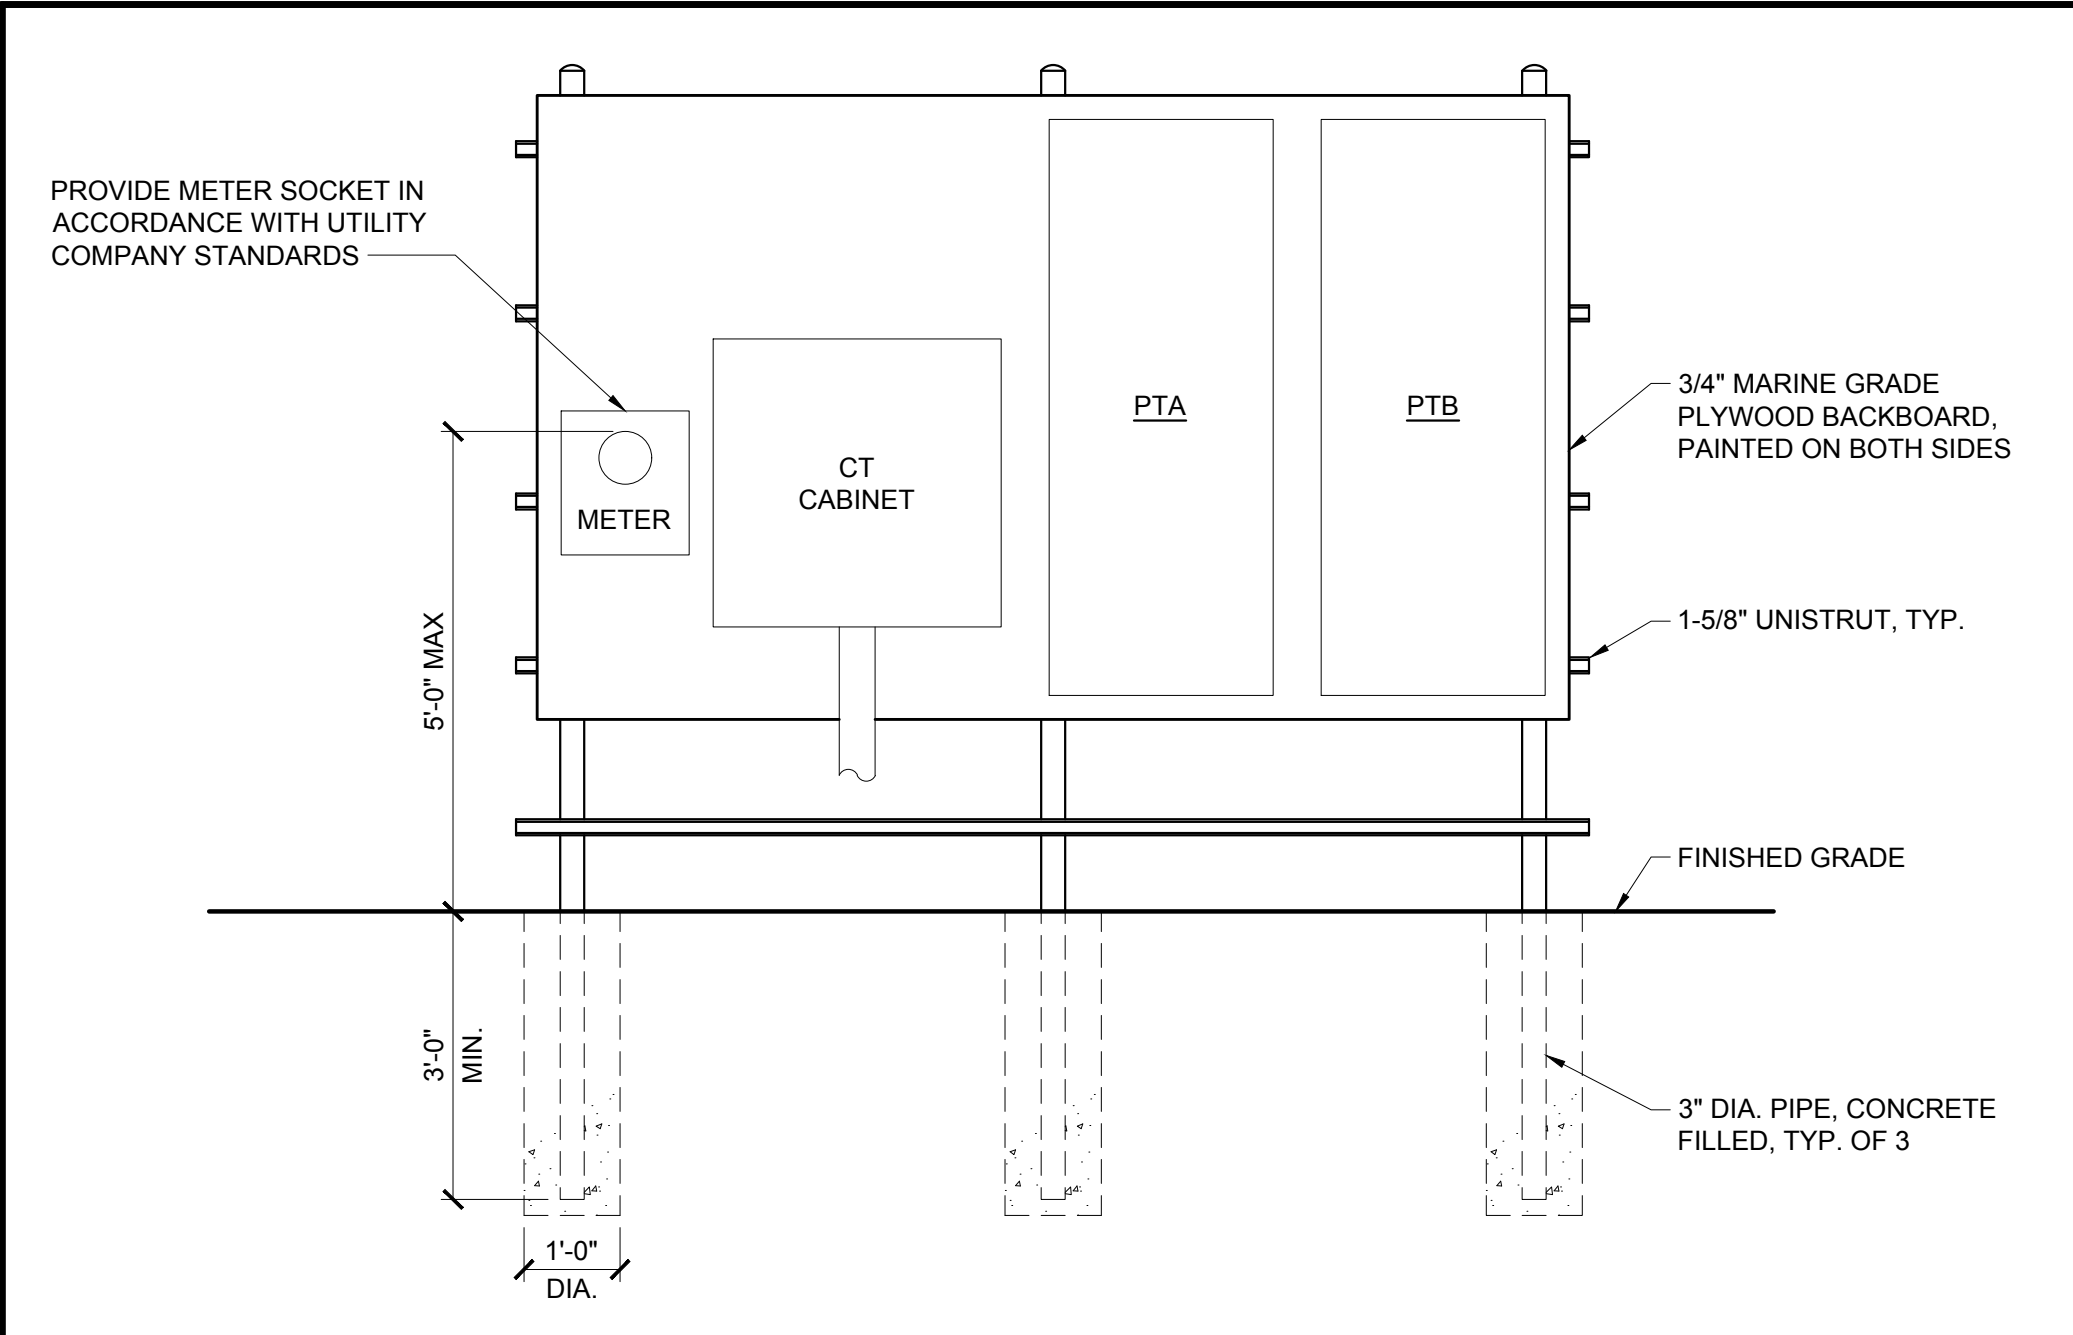

A3 BACKBOARD DETAIL
NO SCALE

B7 KEYNOTES
NO SCALE

(1) PROVIDE (3) DATA OUTLETS AND (1) DATA OUTLET FOR A WIRELESS ACCESS POINT. COORDINATE OUTLET LOCATIONS WITH OWNER.

A7 CONDUIT KEY
NO SCALE

(A) POWER - (1) 2" C
(B) SERVICE ENTRANCE - (2) 3" C
(C) FIRE ALARM - (1) 1 1/2" C
(D) TELECOM - (1) 2" C WITH HORIZONTAL CABLING FOR (3) DATA OUTLETS AND (1) WIRELESS ACCESS POINT - TERMINATE HORIZONTAL CABLING AT EXISTING DATA RACK IN EMERY HALL. COORDINATE WITH OWNER.

B9 ELECTRICAL LEGEND
NO SCALE

—	OVERHEAD WIRING	—	EXISTING ITEM TO REMAIN
---	UNDERGROUND OR UNDERSLAB WIRING	(R)	REMOVE ITEM AND DISPOSE OF PROPERLY
⊙	UTILITY POLE	(ER)	RELOCATED ITEM AT NEW LOCATION
■	PANELBOARD	(RL)	REMOVE AND RELOCATE
⊙	JUNCTION BOX, WALL MOUNTED		
[M]	METER & CT CABINET, PEDESTAL MOUNTED		
[H]	HANDHOLE, MINIMUM 18"x36"x24", SIZE PER NEC FOR NUMBER OF CONDUITS INSTALLED		
(A1)	DETAIL CALL-OUT		

A9 ABBREVIATIONS
NO SCALE

AFF	ABOVE FINISHED FLOOR	(E)	EXISTING ITEM TO REMAIN
AFG	ABOVE FINISHED GRADE	(R)	REMOVE ITEM AND DISPOSE OF PROPERLY
CB	CIRCUIT BREAKER	(ER)	RELOCATED ITEM AT NEW LOCATION
P/O	PART OF	(RL)	REMOVE AND RELOCATE
MT	MOUNT		
NEC	NATIONAL ELECTRICAL CODE		
OH	OVERHEAD		
TEL	TELEPHONE		
UNO	UNLESS NOTED OTHERWISE		
WP	WEATHERPROOF		

PROJECT NAME:
WAYNFLETE LOWER SCHOOL
ADDITION & RENOVATIONS

WAYNFLETE SCHOOL
360 SPRING STREET
PORTLAND, MAINE 04102



THIS DRAWING IS THE PROPERTY OF SCOTT SIMONS ARCHITECTS (SSA) AND IS NOT TO BE COPIED OR REPRODUCED IN PART OR WHOLE.
2015 © SCOTT SIMONS ARCHITECTS, LLC

REVISION:

1	DATE
2	DATE
3	DATE
4	DATE
5	DATE
6	DATE

DATE OF ISSUE: _____
PROJECT NUMBER: _____
STATUS: _____

MODULAR BUILDINGS ELECTRICAL SITE PLAN

ES101M

N:\Projects\2015\15051 Waynflete School\00 Drawing Files\Temporary Modular\15051E-TRAILERS.dwg Apr 28, 2017 10:48am

ISSUED FOR PERMIT ~ NOT FOR CONSTRUCTION ~ APRIL 28, 2017