

Copyright Reserved

The Contractor shall verify and be responsible for all dimensions. DO NOT scale the drawing - any errors or omissions shall be reported to Stantec without delay. The Copyrights to all designs and drawings are the property of Stantec. Reproduction or use for any purpose other than that authorized by Stantec is forbidden.


Consultants

ARCHITECT
ARCHETYPE
LANDSCAPE ARCHITECT
MOHR & SEREDIN
SURVEYOR
OWEN HASKELL
CONTRACTOR
CIANBRO


Notes

Revision	By	Date
4	SRB	17.10.20
3	SRB	17.10.10
2	SRB	17.09.26
1	SRB	17.08.09


4 ISSUED FOR CONSTRUCTION/UTILITY PLANS
3 REVISED PER CONDITIONS OF APPROVAL/RELEASED FOR BIDDING
2 REVISED FOR FINAL SITE PLAN REVIEW PRIOR TO OCT. 4, 2017 PUBLIC HEARINGS
1 FINAL SITE PLAN REVIEW

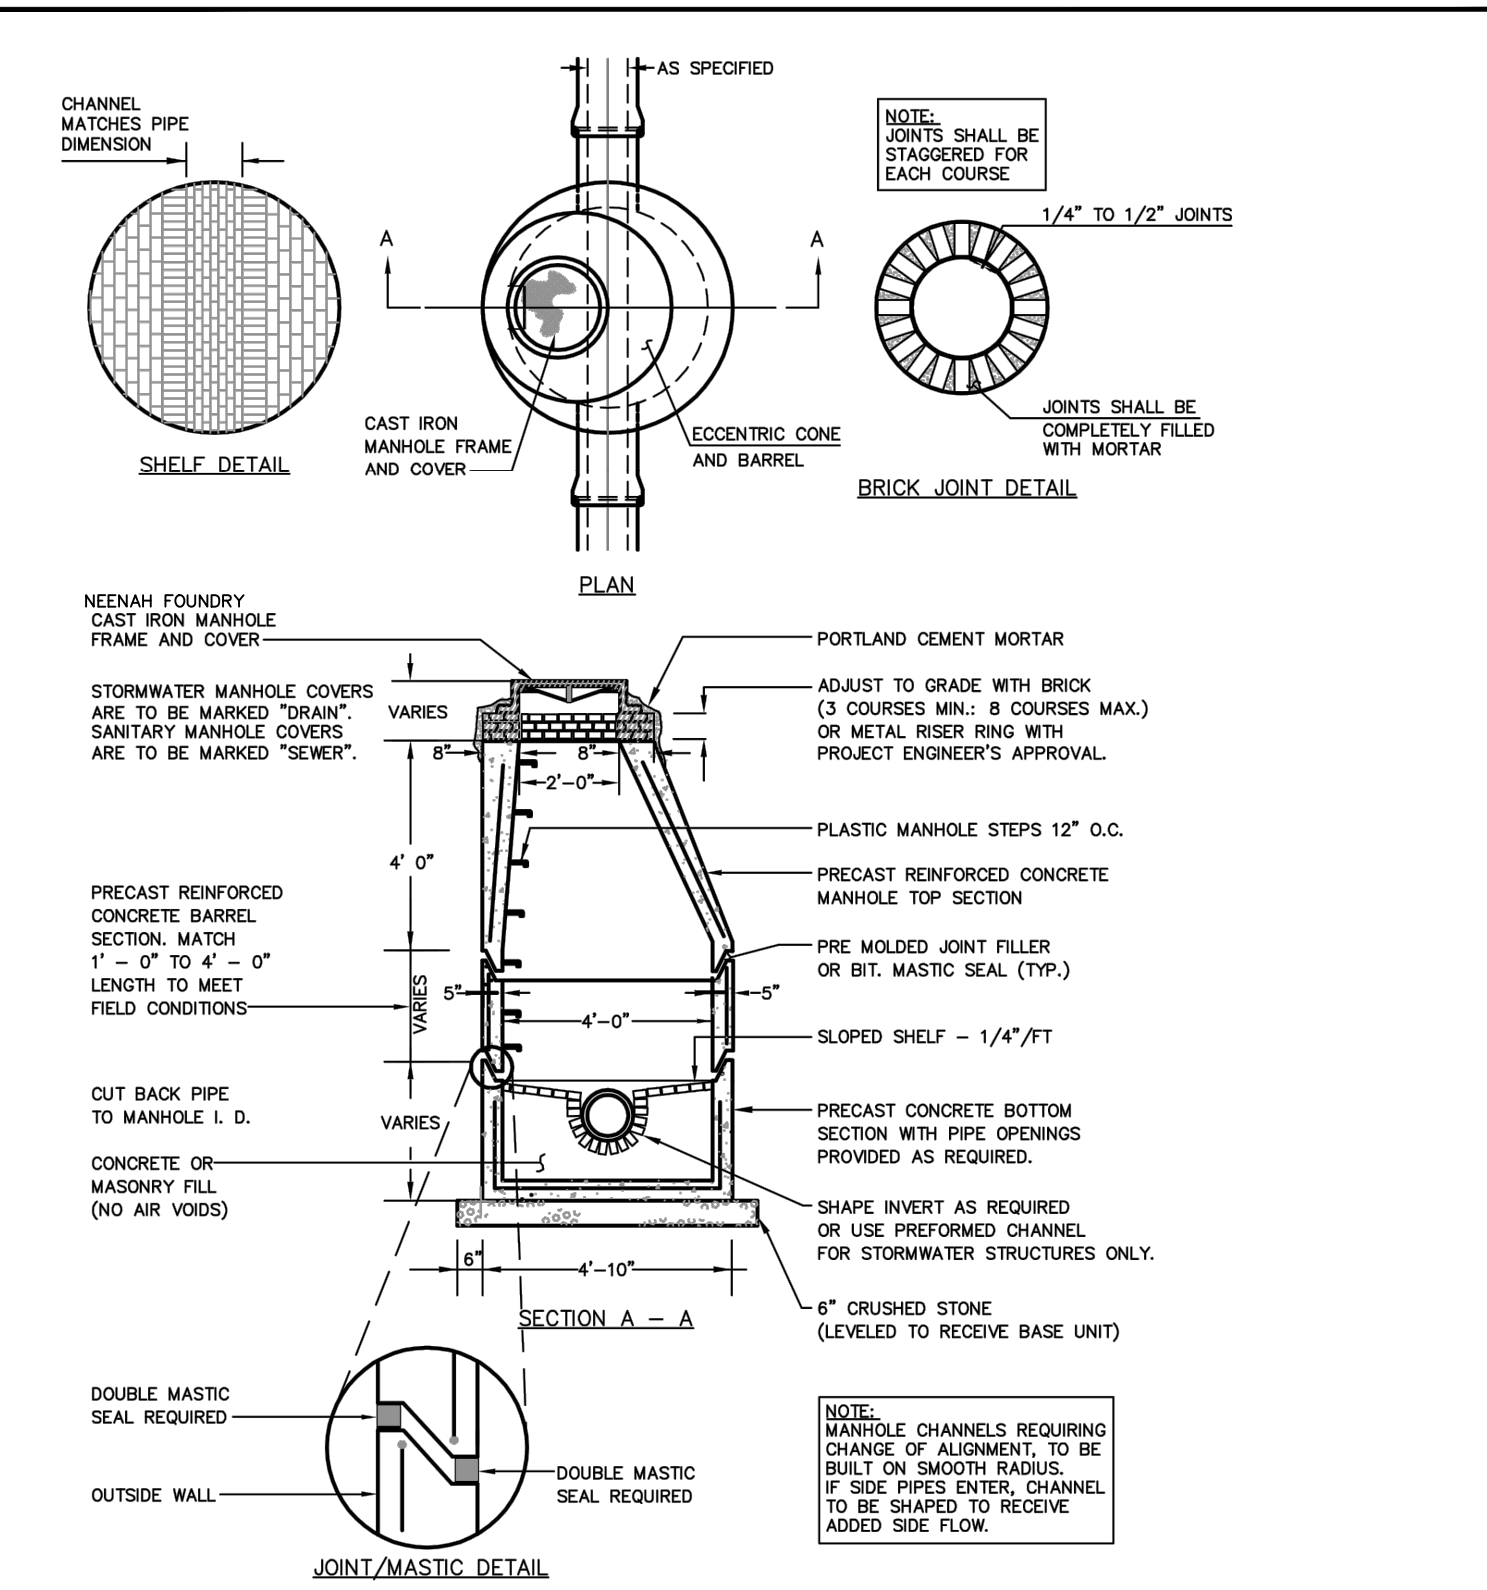


A PRECAST CONCRETE MANHOLE
N.T.S. AS OBTAINED FROM THE CITY OF PORTLAND "TECHNICAL MANUAL"

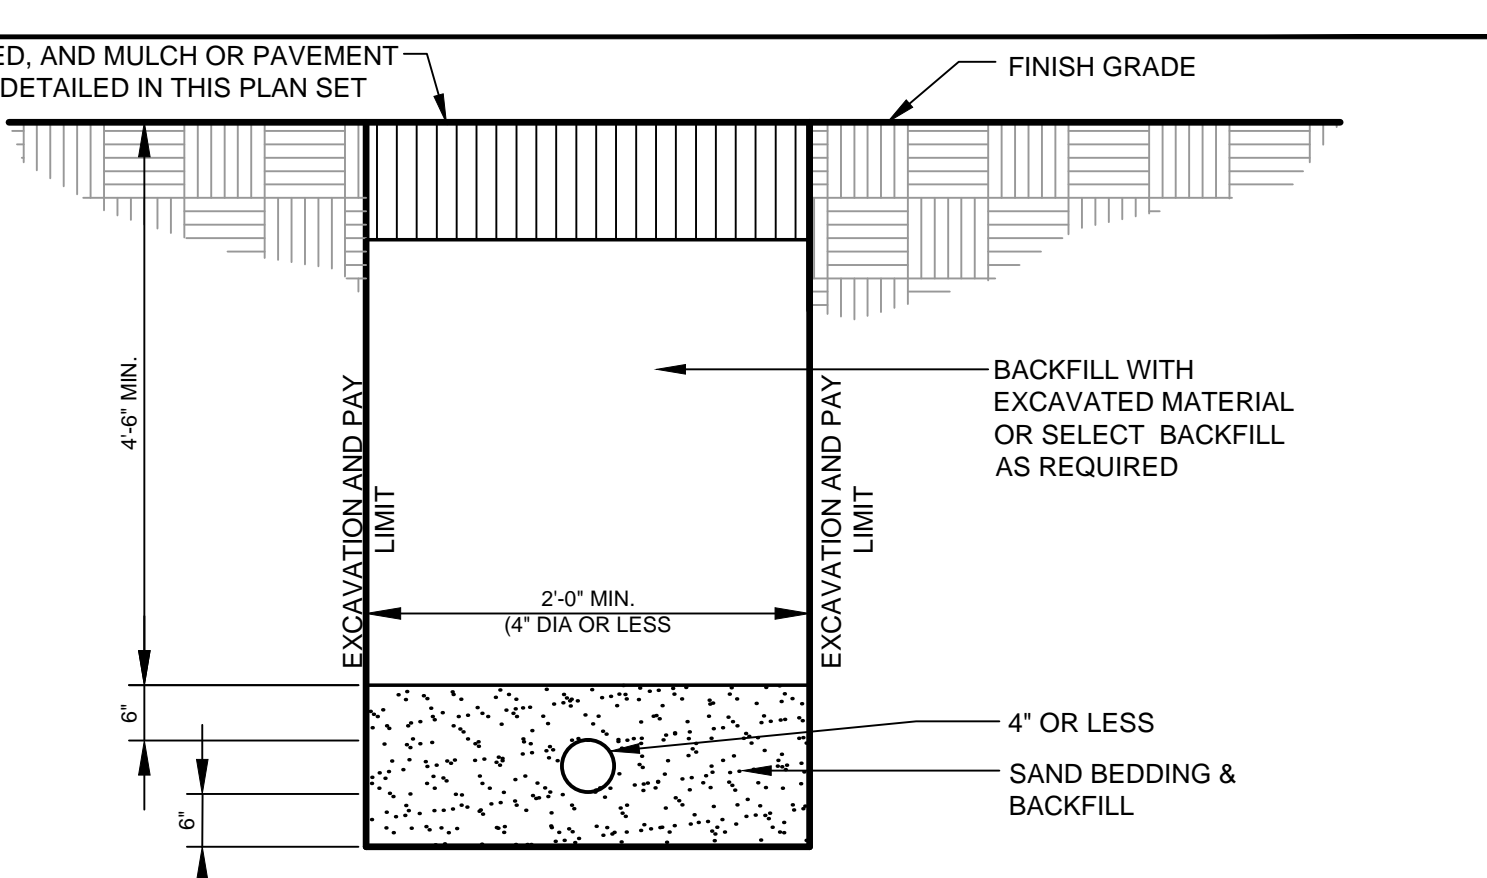


B WATER SERVICE TRENCH DETAIL
N.T.S.

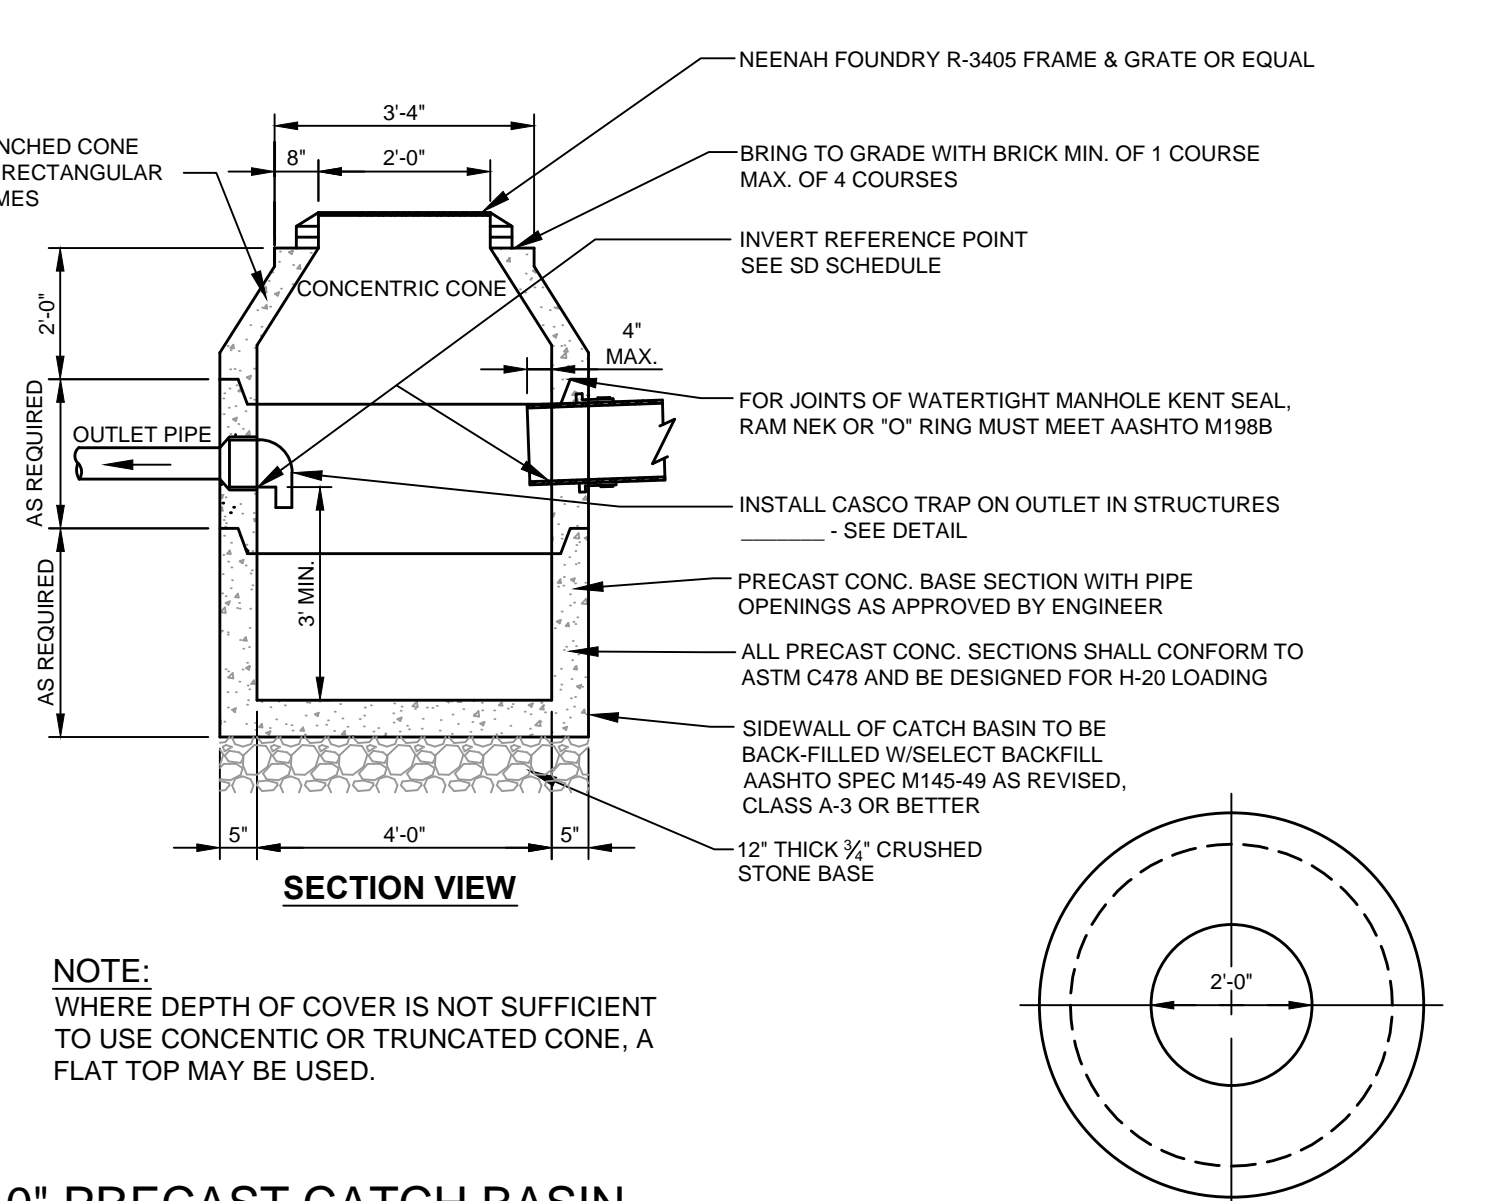


C 4'-0" PRECAST CATCH BASIN
N.T.S.

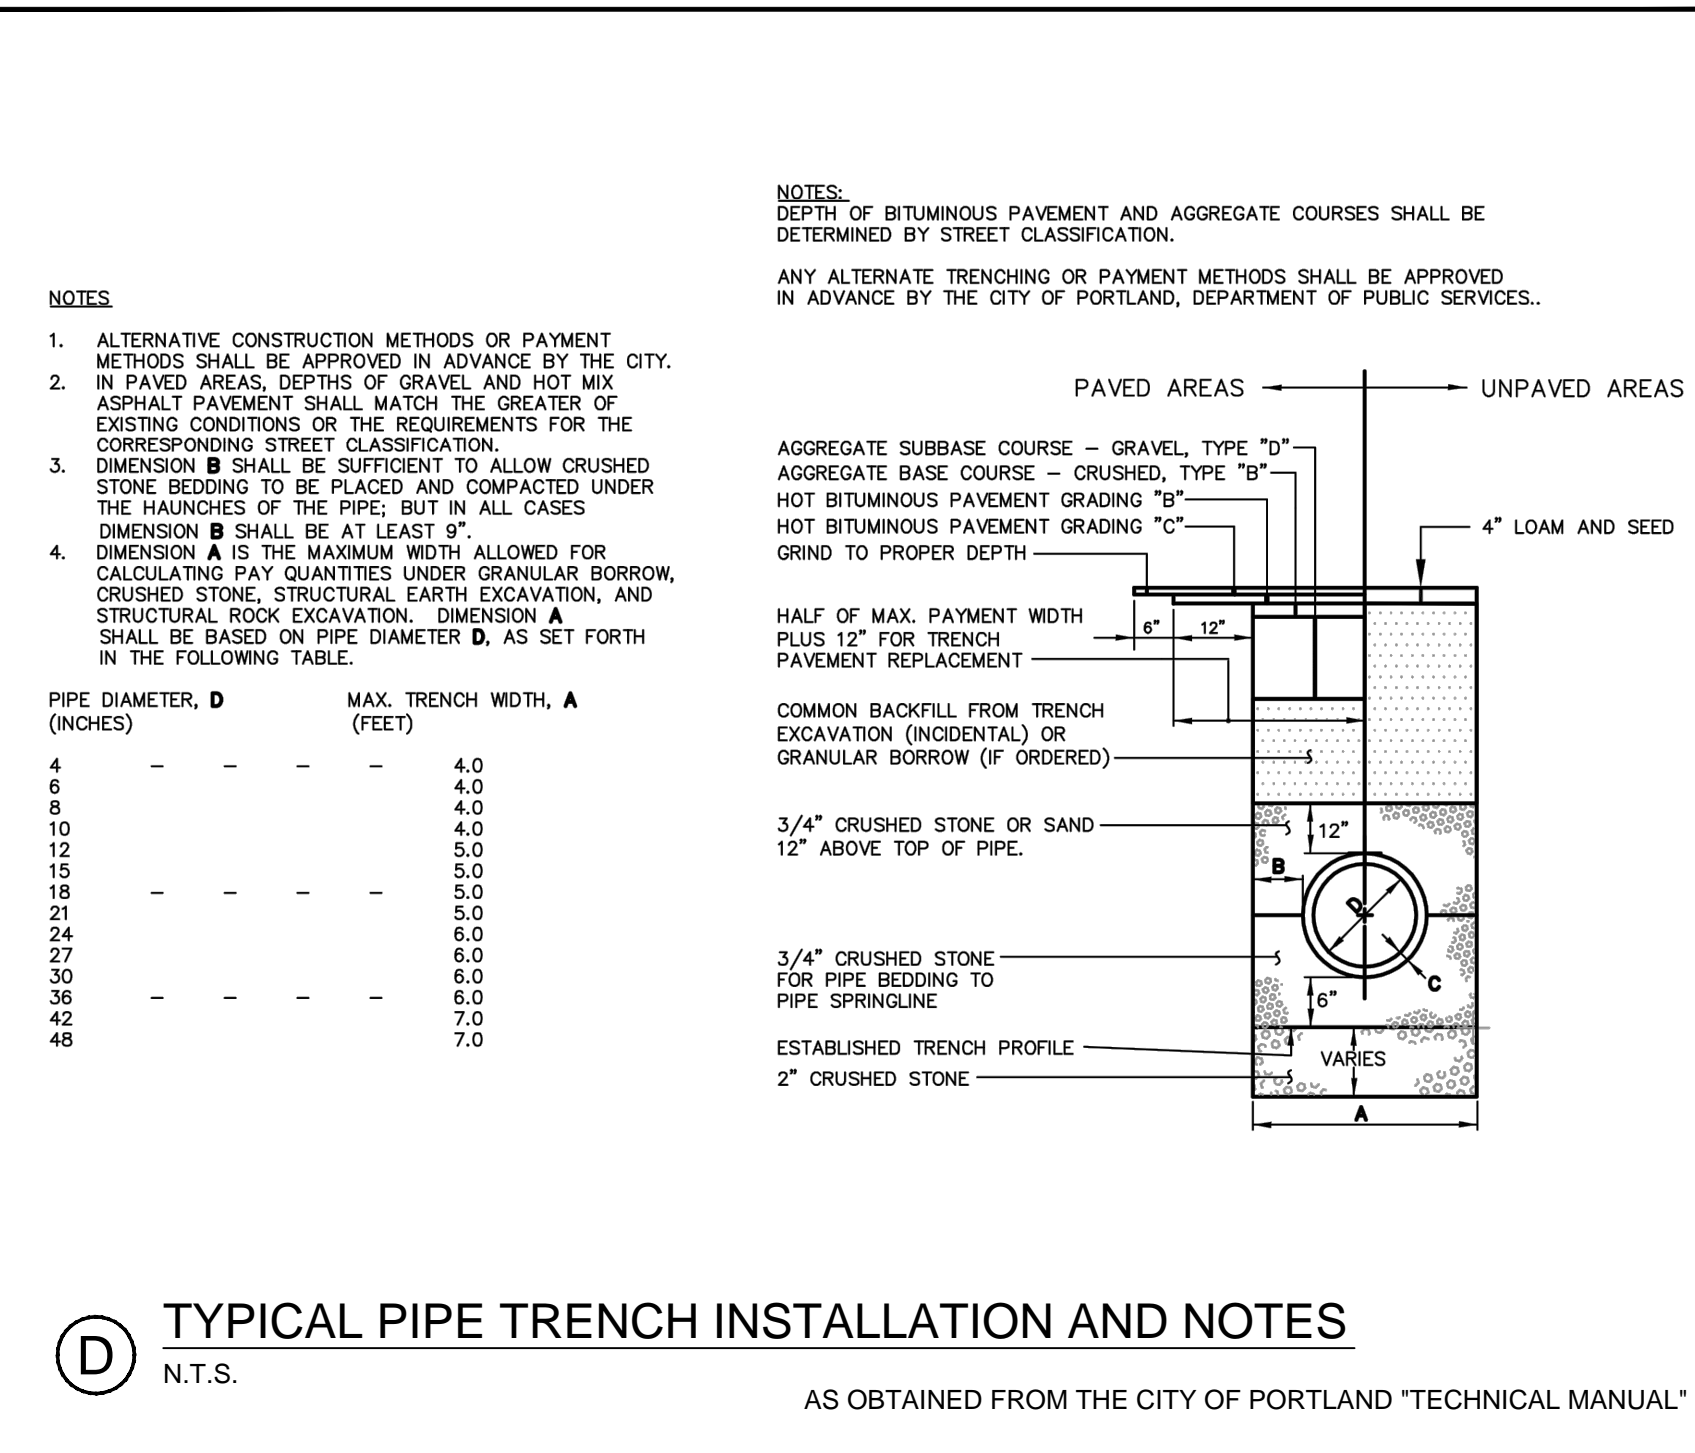


D TYPICAL PIPE TRENCH INSTALLATION AND NOTES
N.T.S. AS OBTAINED FROM THE CITY OF PORTLAND "TECHNICAL MANUAL"

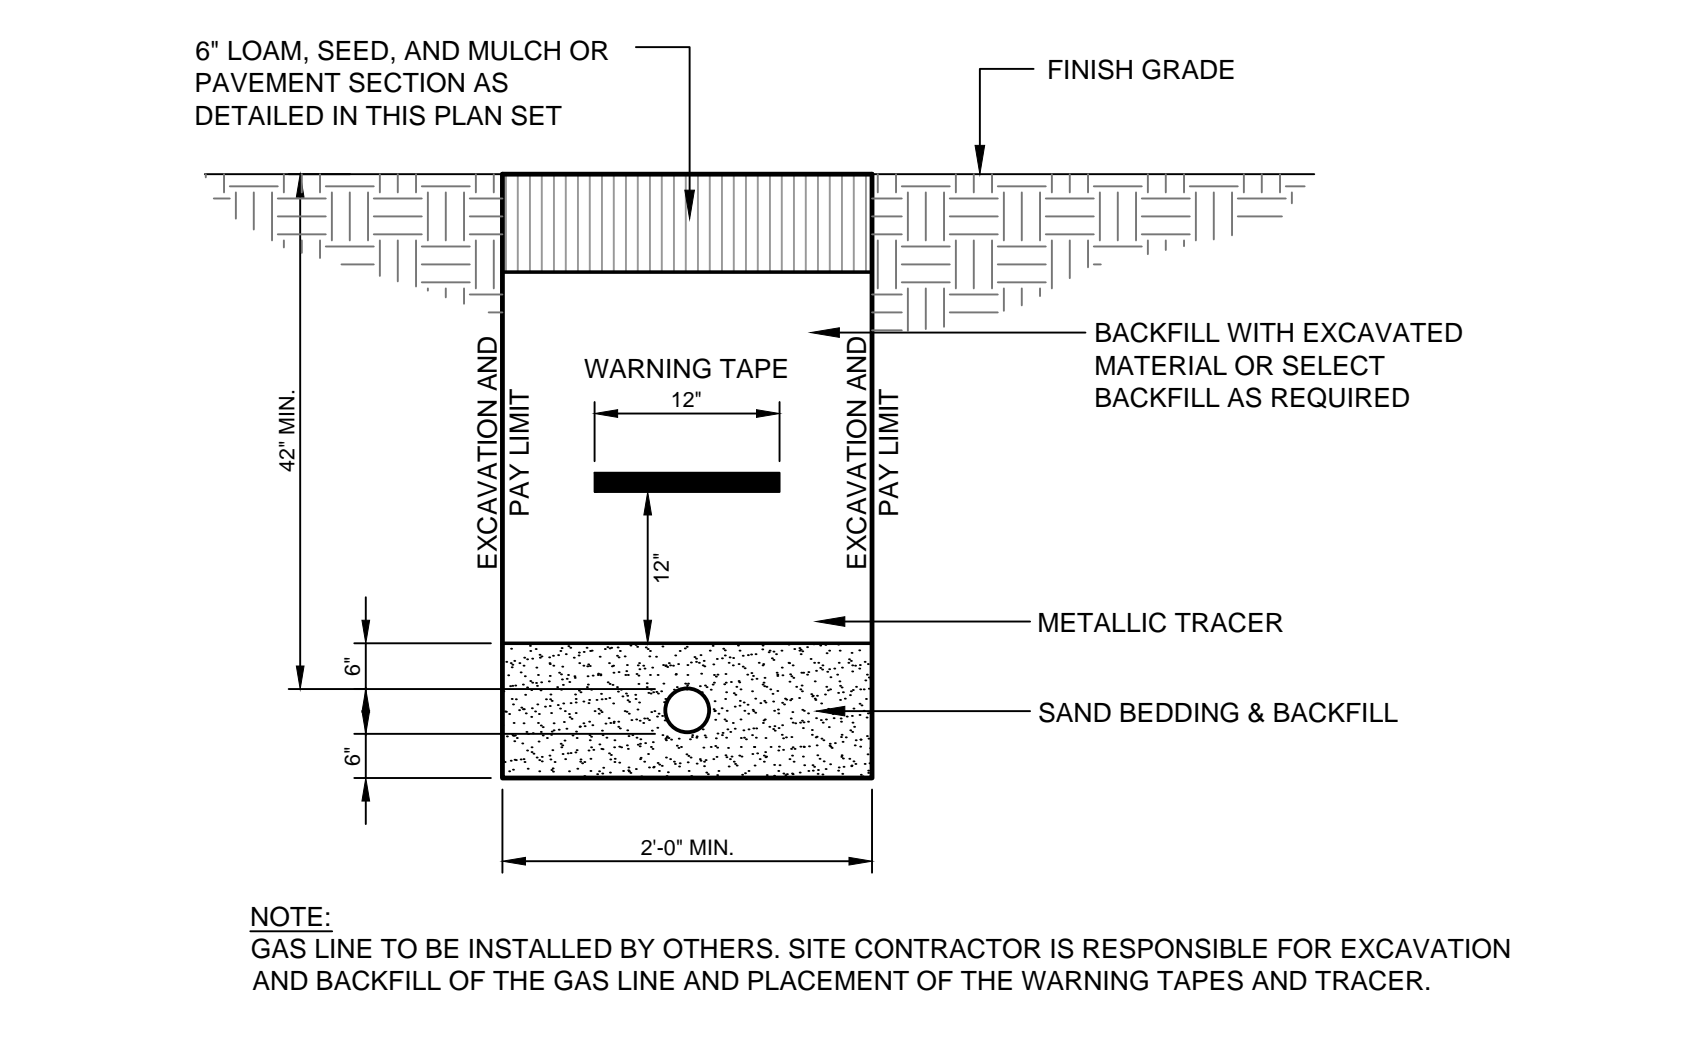


E GAS SERVICE TRENCH SECTION
N.T.S.

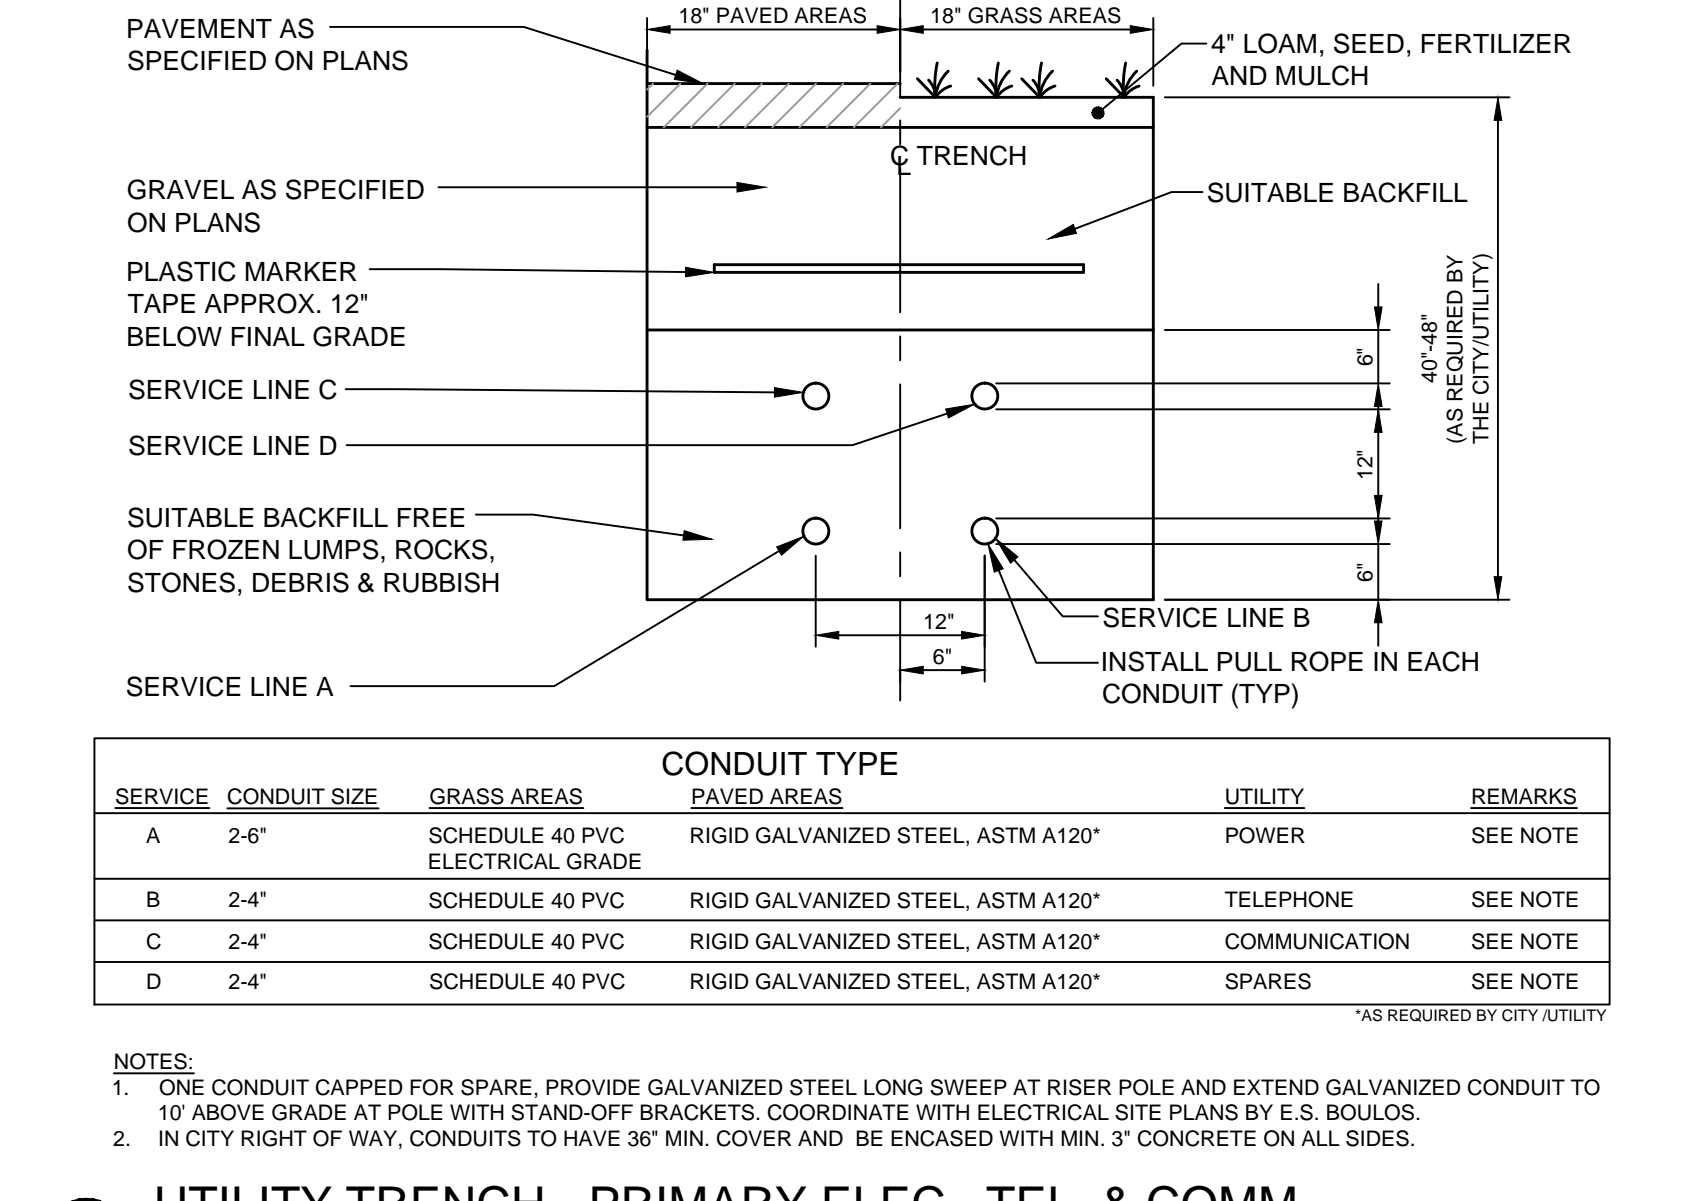


F UTILITY TRENCH - PRIMARY ELEC., TEL. & COMM.
N.T.S.

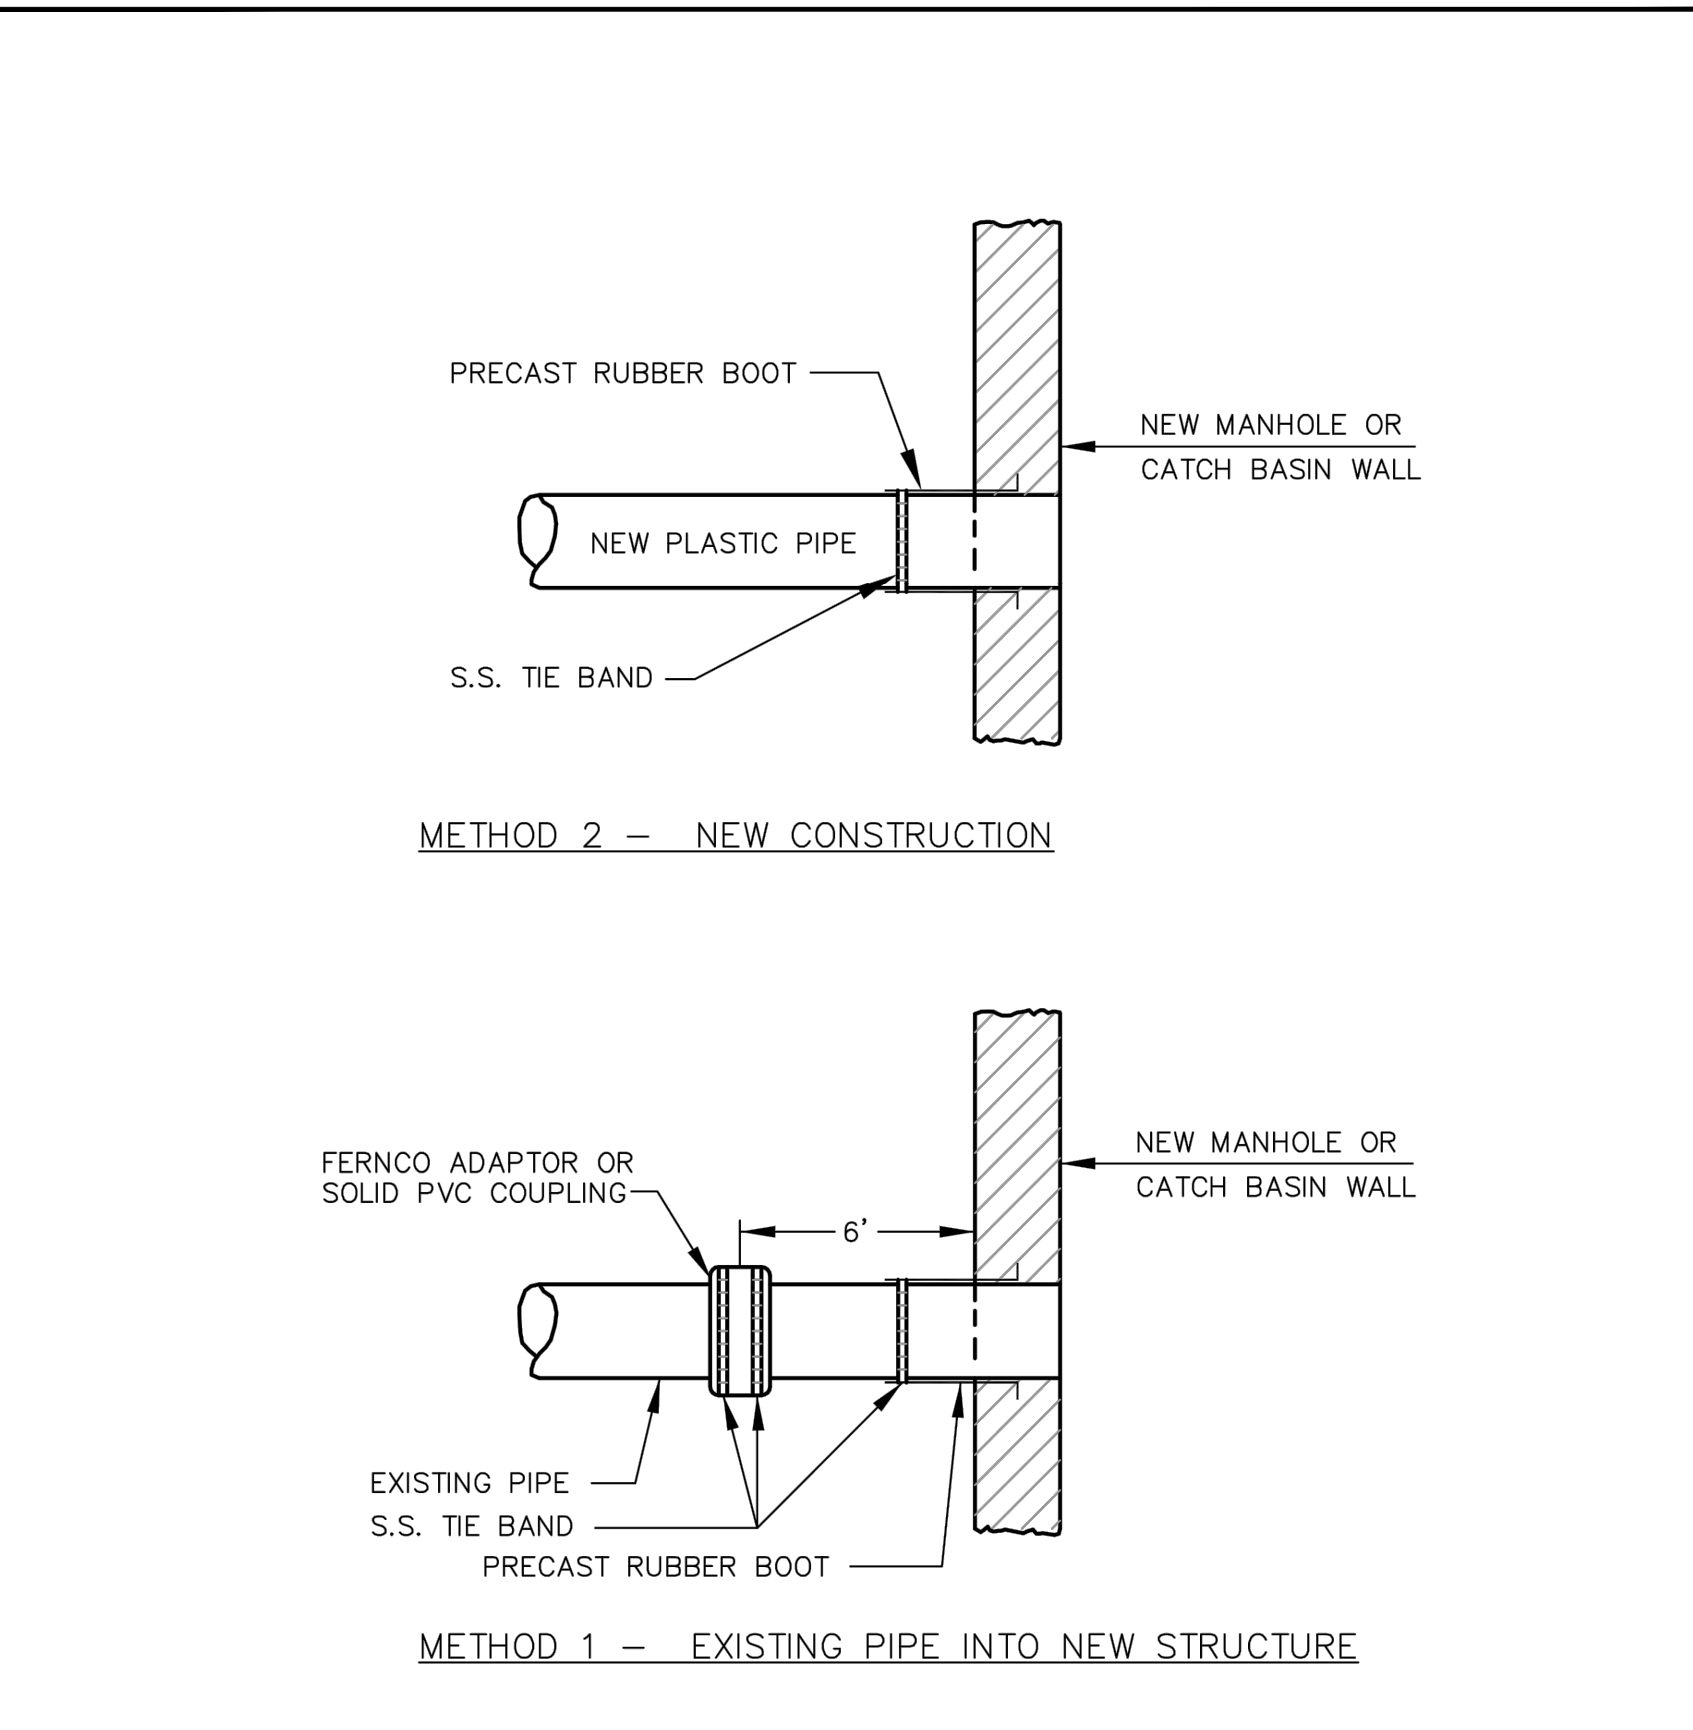

G PLASTIC PIPE CONNECTIONS
NOT TO SCALE

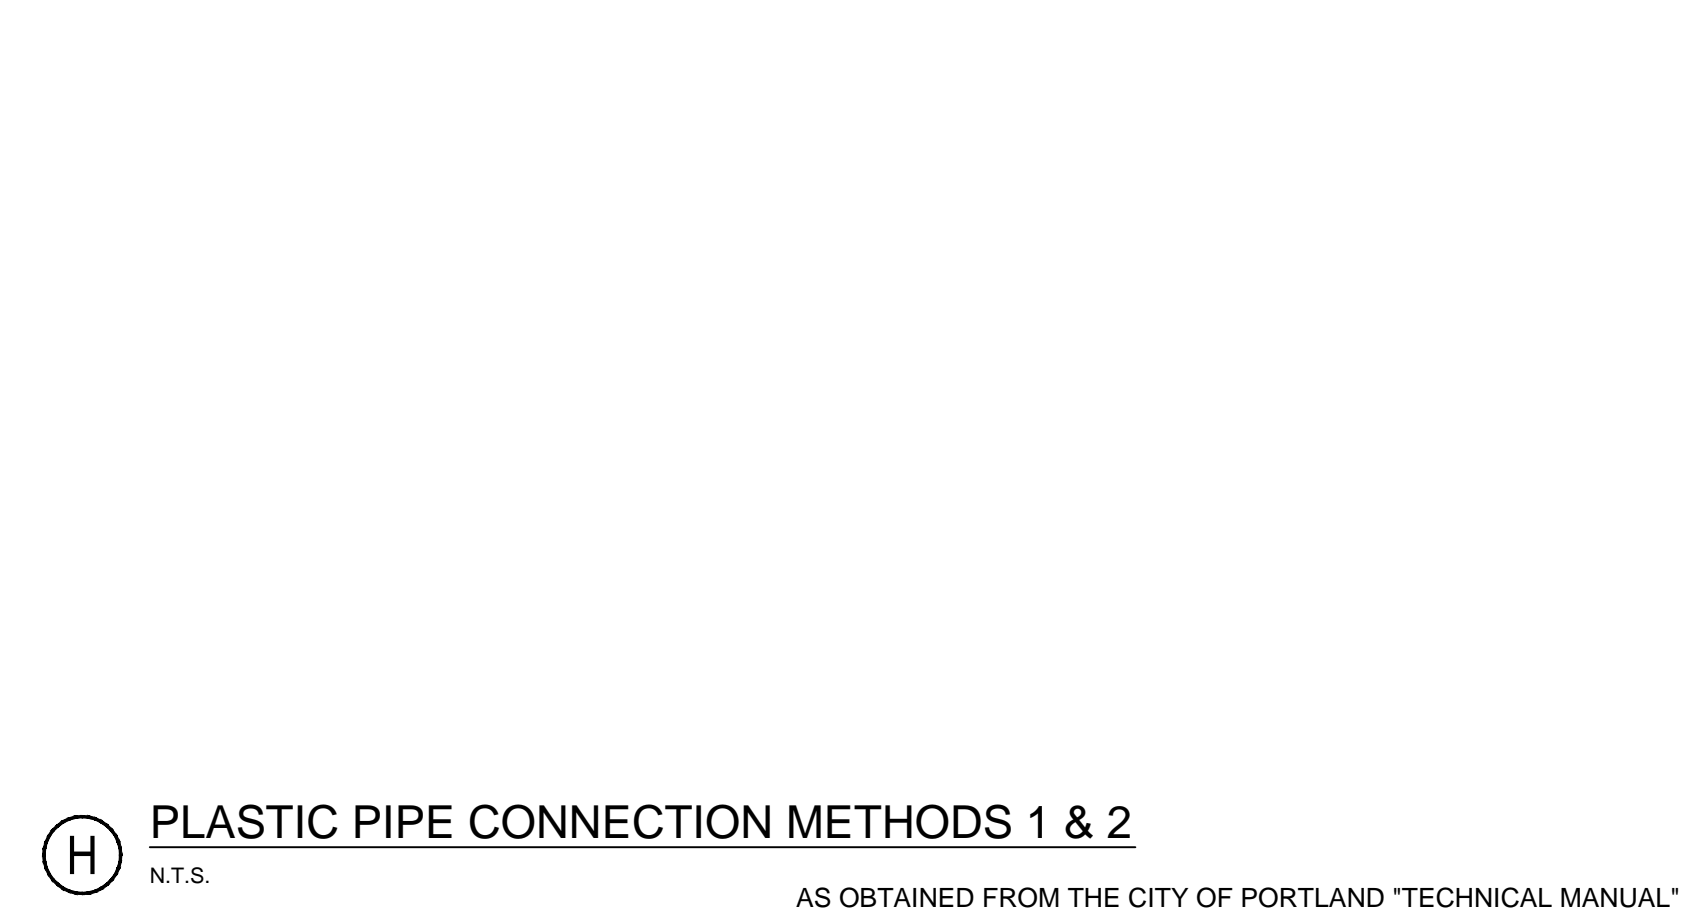

H PLASTIC PIPE CONNECTION METHODS 1 & 2
N.T.S. AS OBTAINED FROM THE CITY OF PORTLAND "TECHNICAL MANUAL"

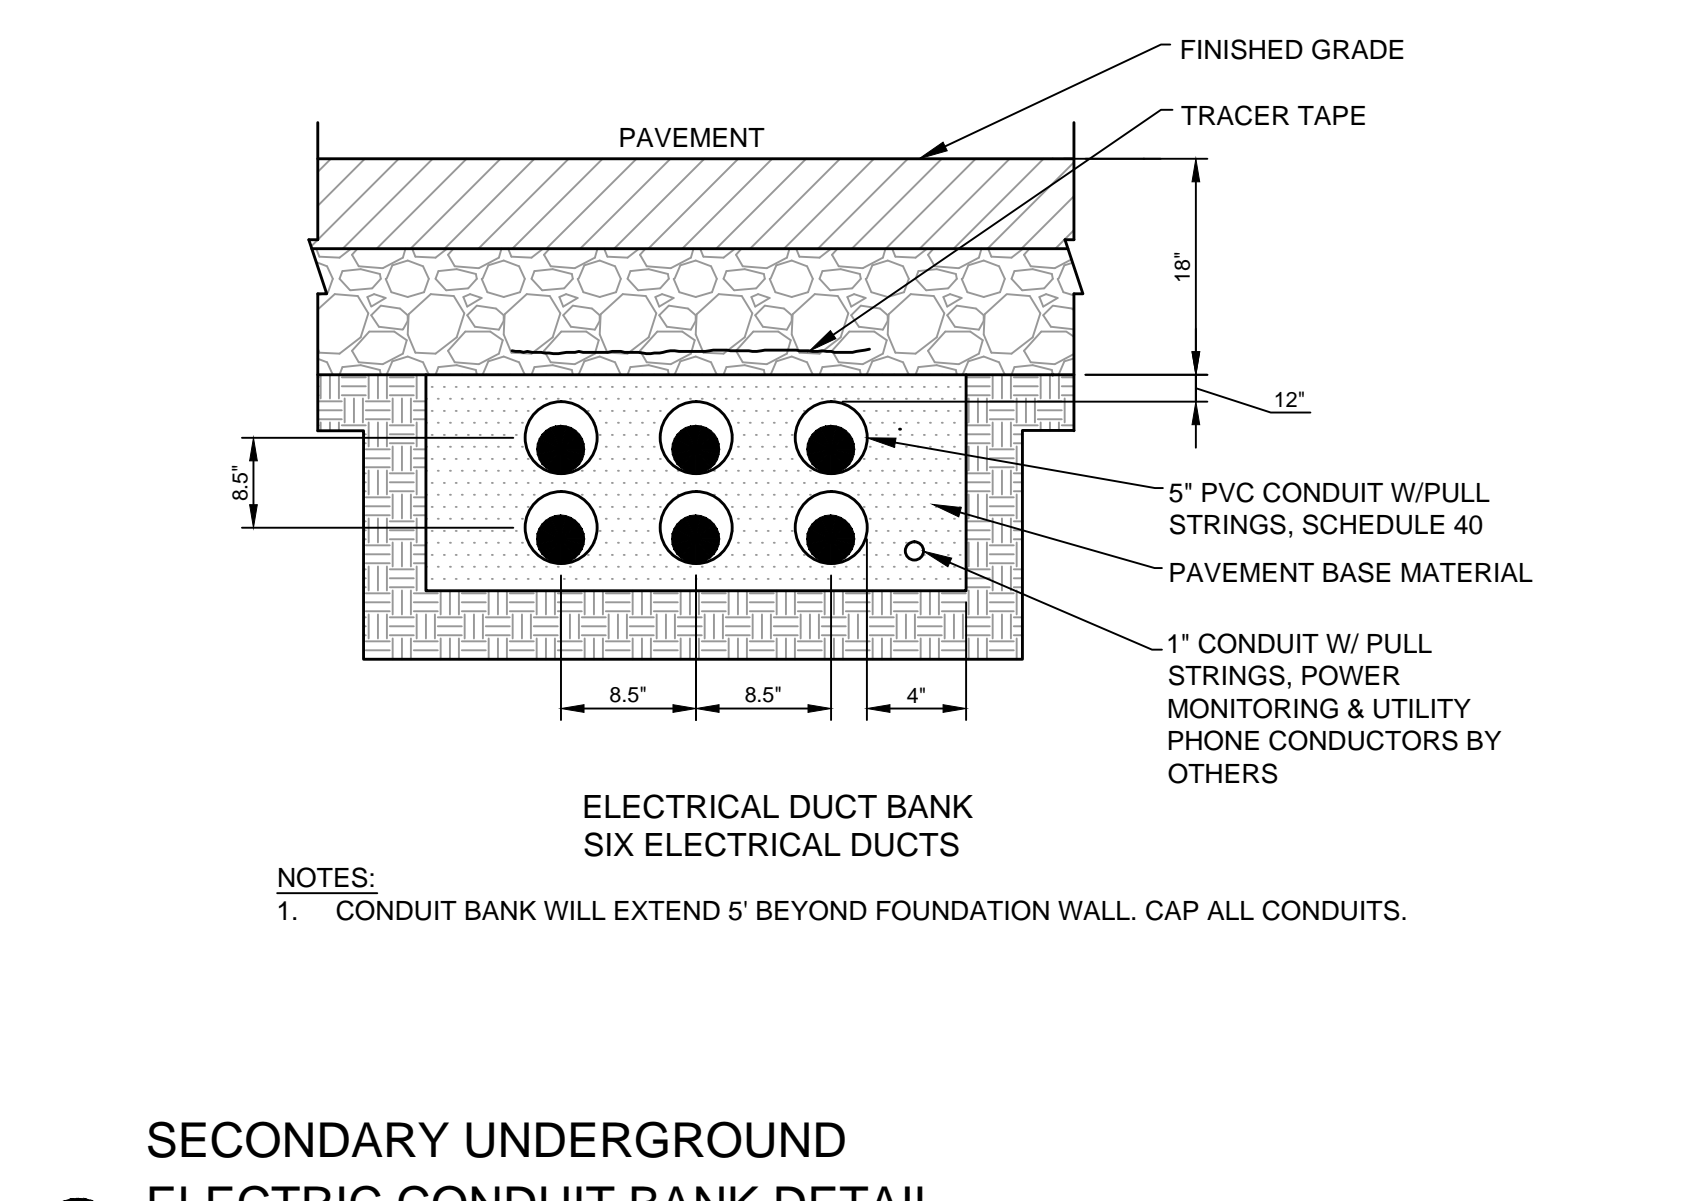

I SECONDARY UNDERGROUND ELECTRIC CONDUIT BANK DETAIL
N.T.S.

File Name:	LA	DBS	SRB	17.07.12
195350450_det	DWN.	CHKD.	DSGN.	DATE

Permit-Seal



Client/Project
0 HANCOCK STREET LLC

THAMES STREET SITE
PORTLAND, MAINE

Title
STORMDRAIN AND UTILITY DETAILS

Project No. 195350450
Scale N.T.S.
Sheet

V:\195350450\195350450\195350450.dwg; pflintenc; 10/20/2017 3:07 PM