




1 Floor Plan
1/4" = 1'-0"

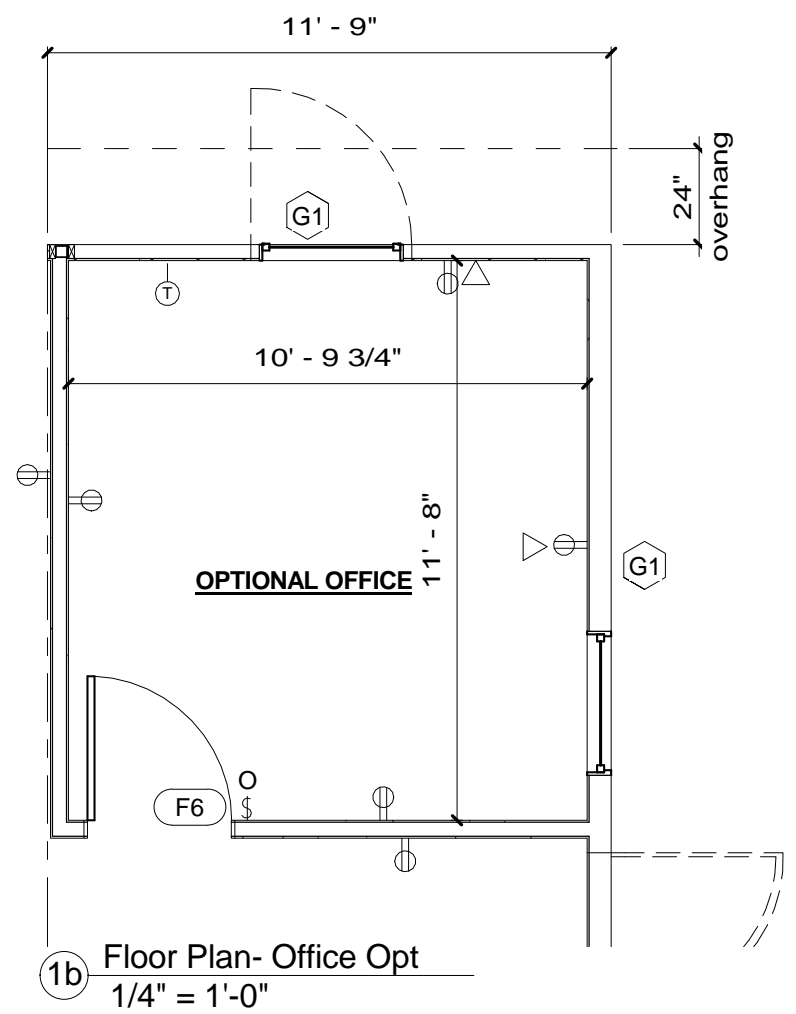


1b Floor Plan- Office Opt
1/4" = 1'-0"

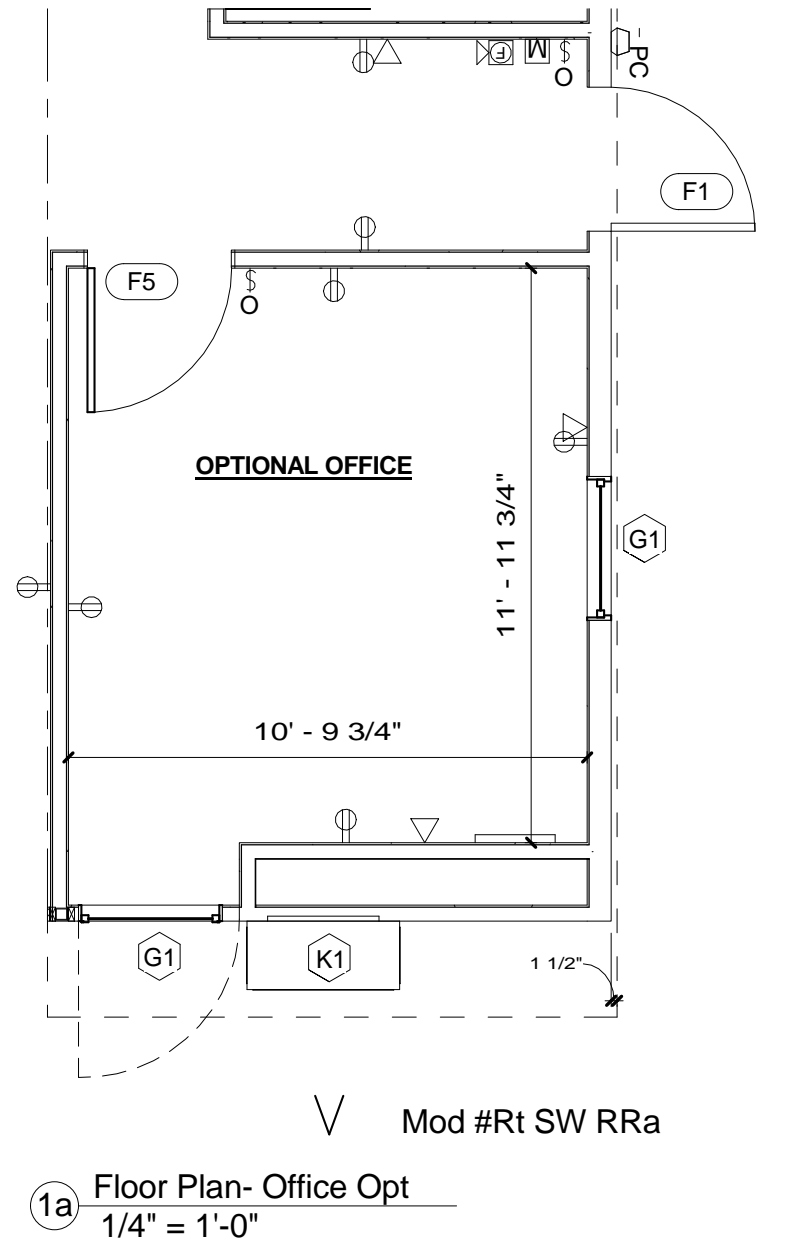


1a Floor Plan- Office Opt
1/4" = 1'-0"

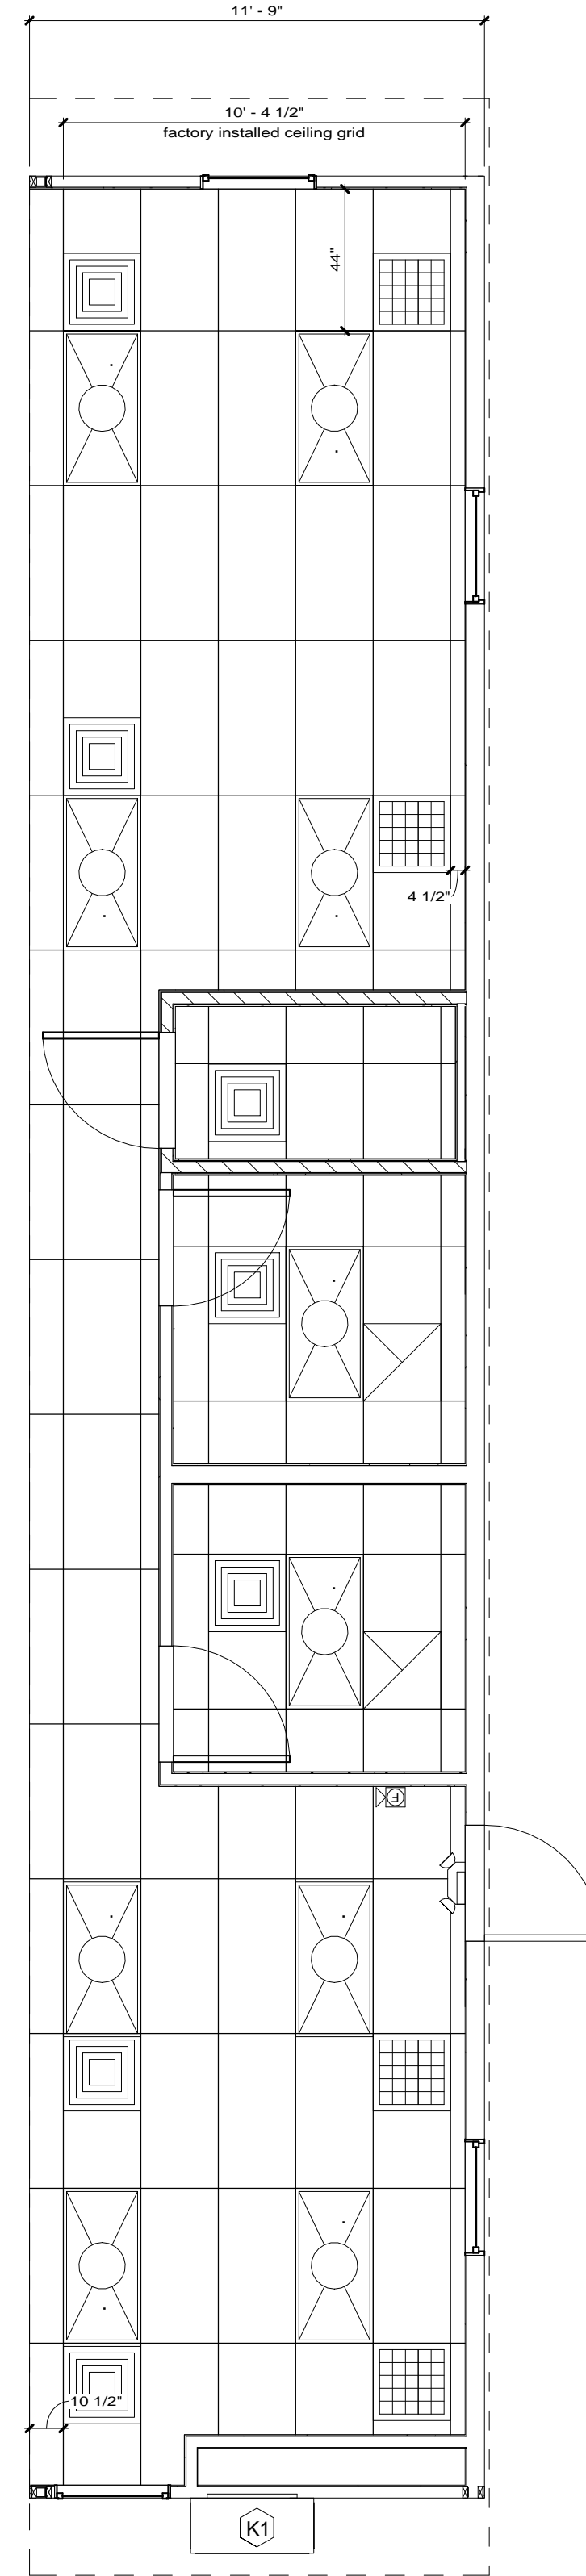


3 Ceiling Plan
1/4" = 1'-0"

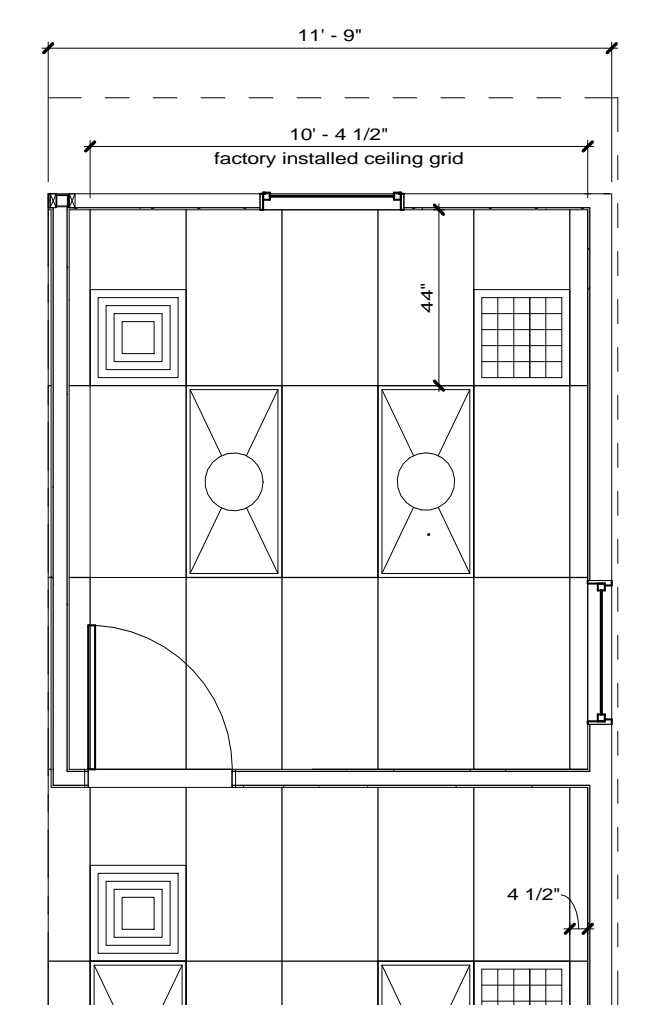


2b Ceiling Plan Office Opt 2
1/4" = 1'-0"

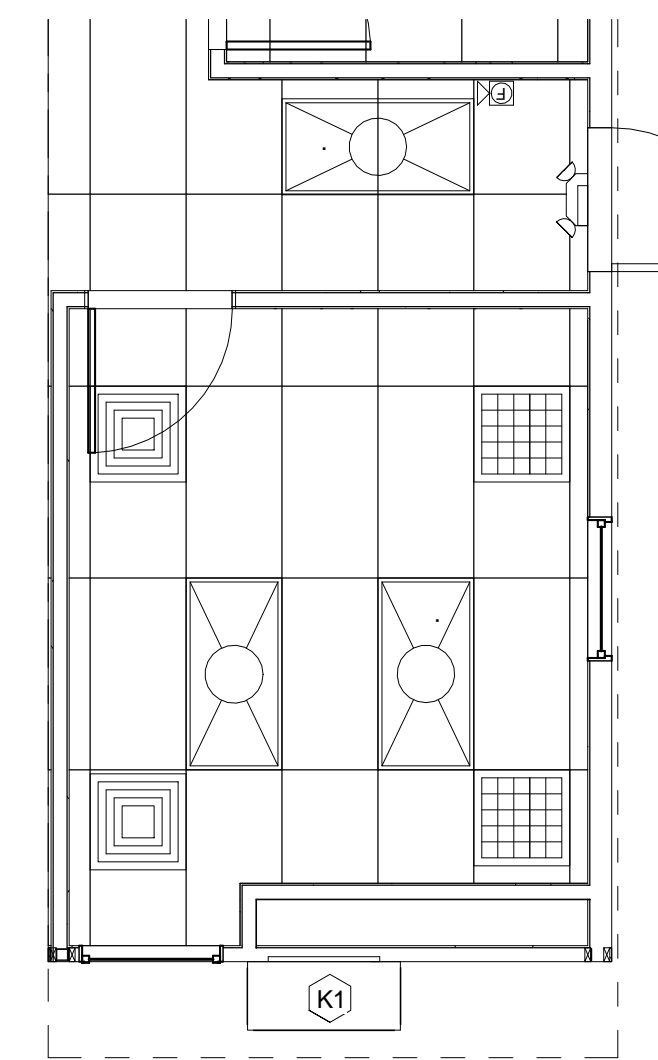

2a Ceiling Plan Office Opt 1
1/4" = 1'-0"

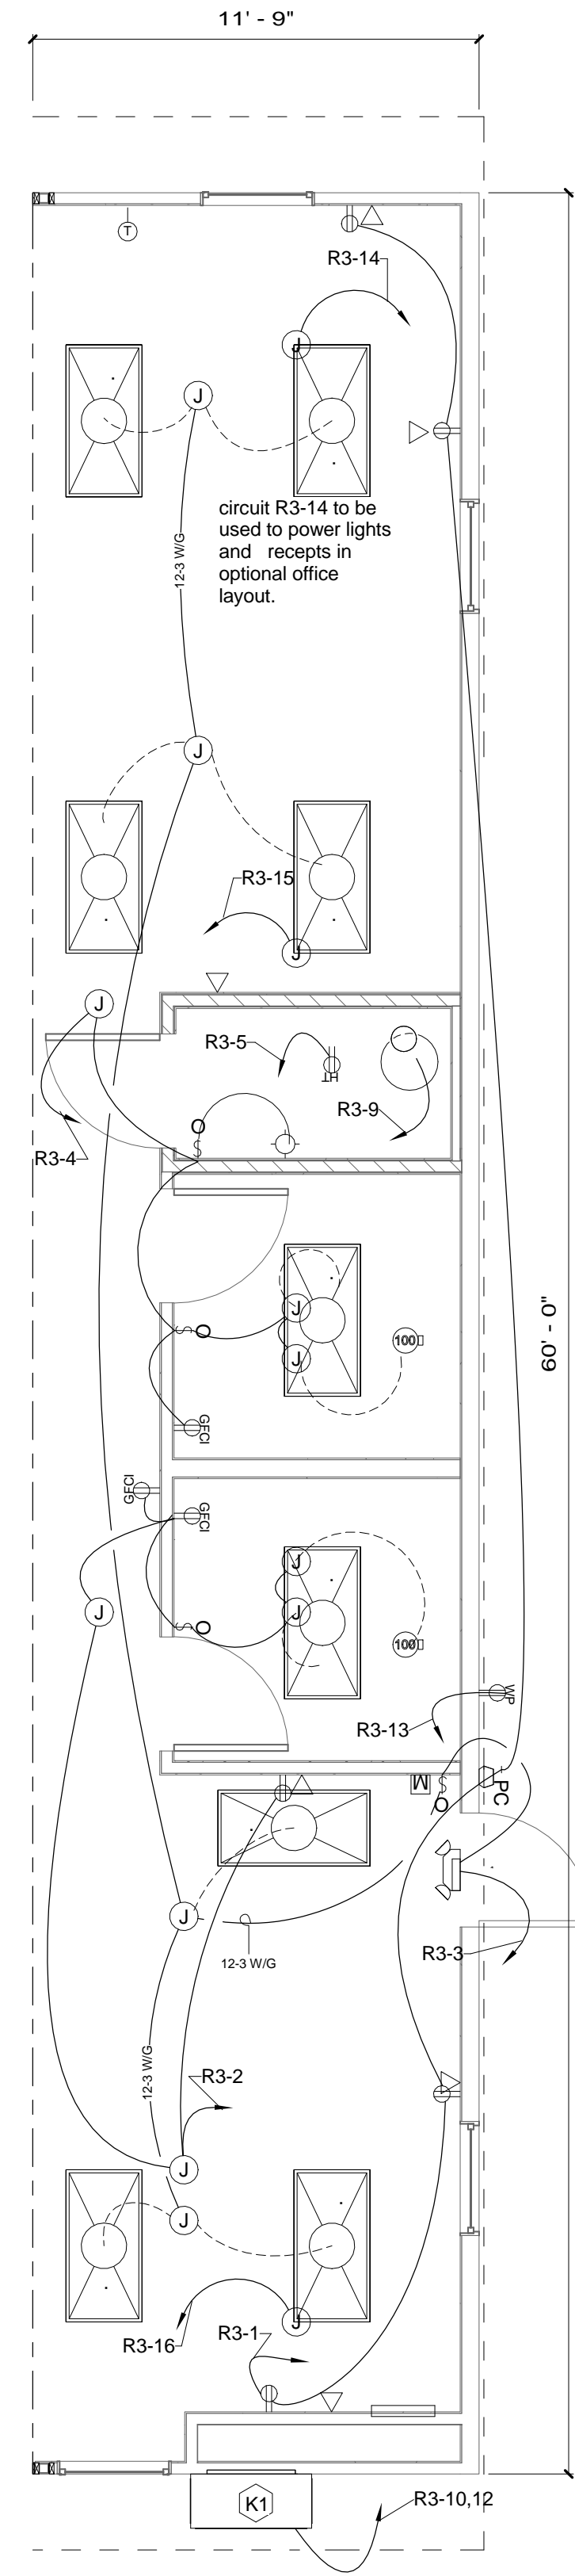


2 Electrical Plan
1/4" = 1'-0"

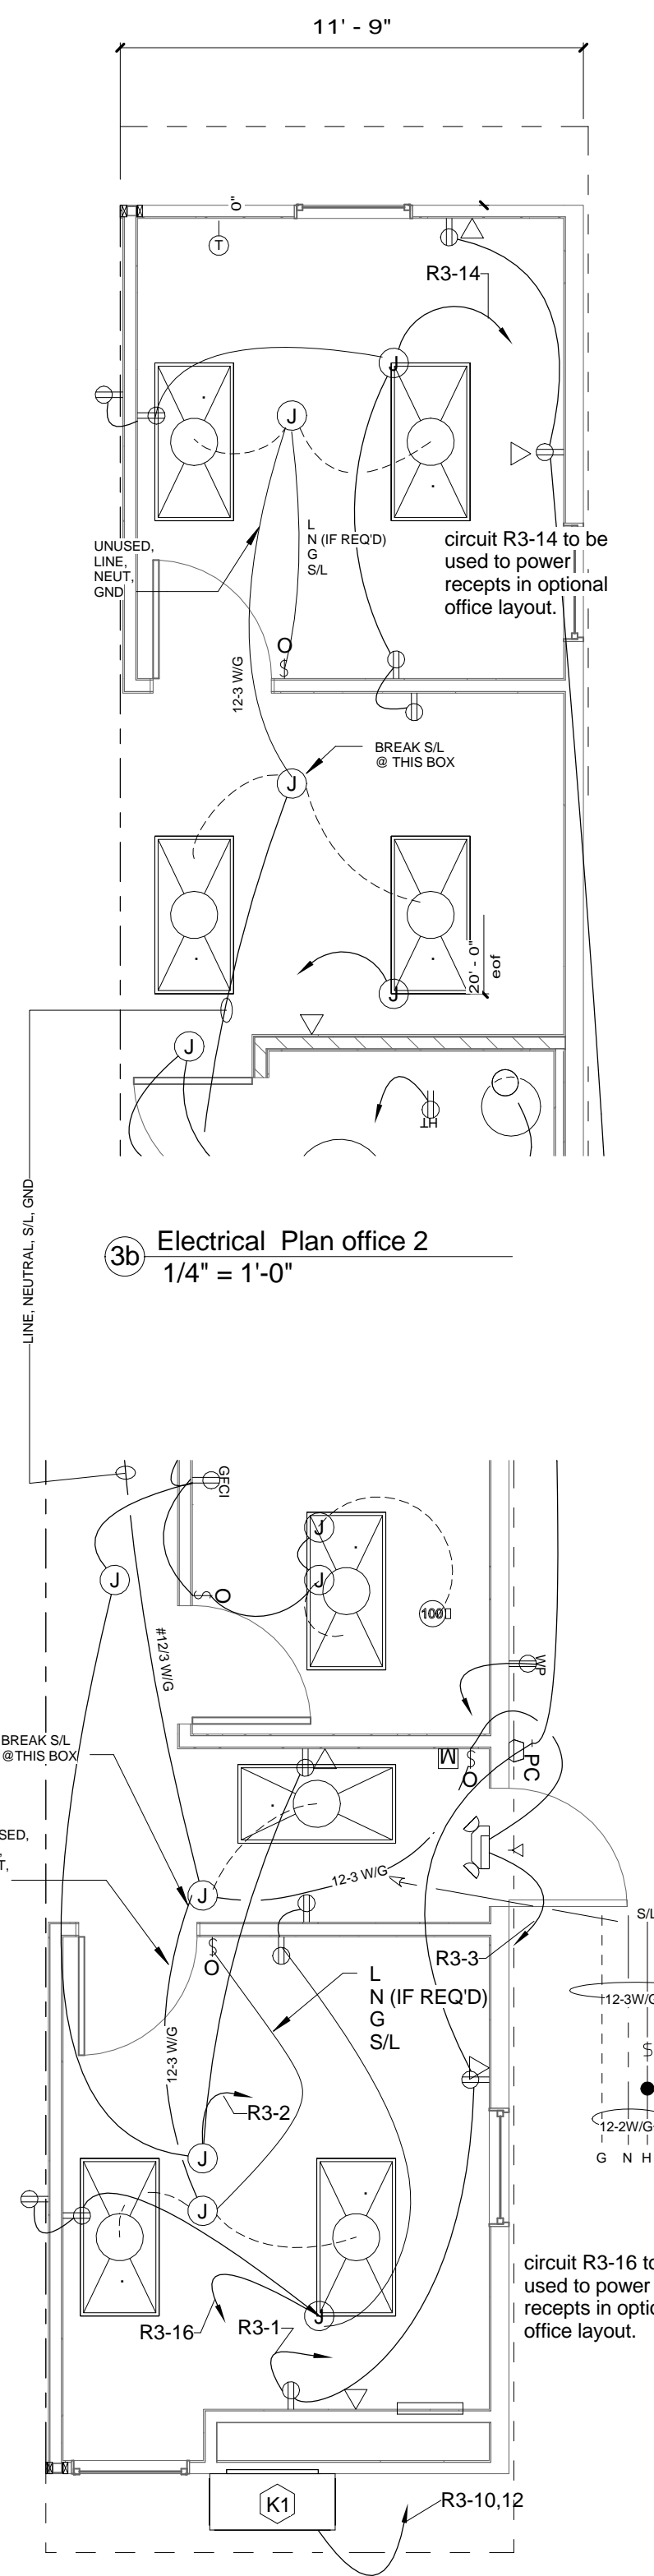


3b Electrical Plan office 2
1/4" = 1'-0"

3a Electrical Plan Office 1
1/4" = 1'-0"

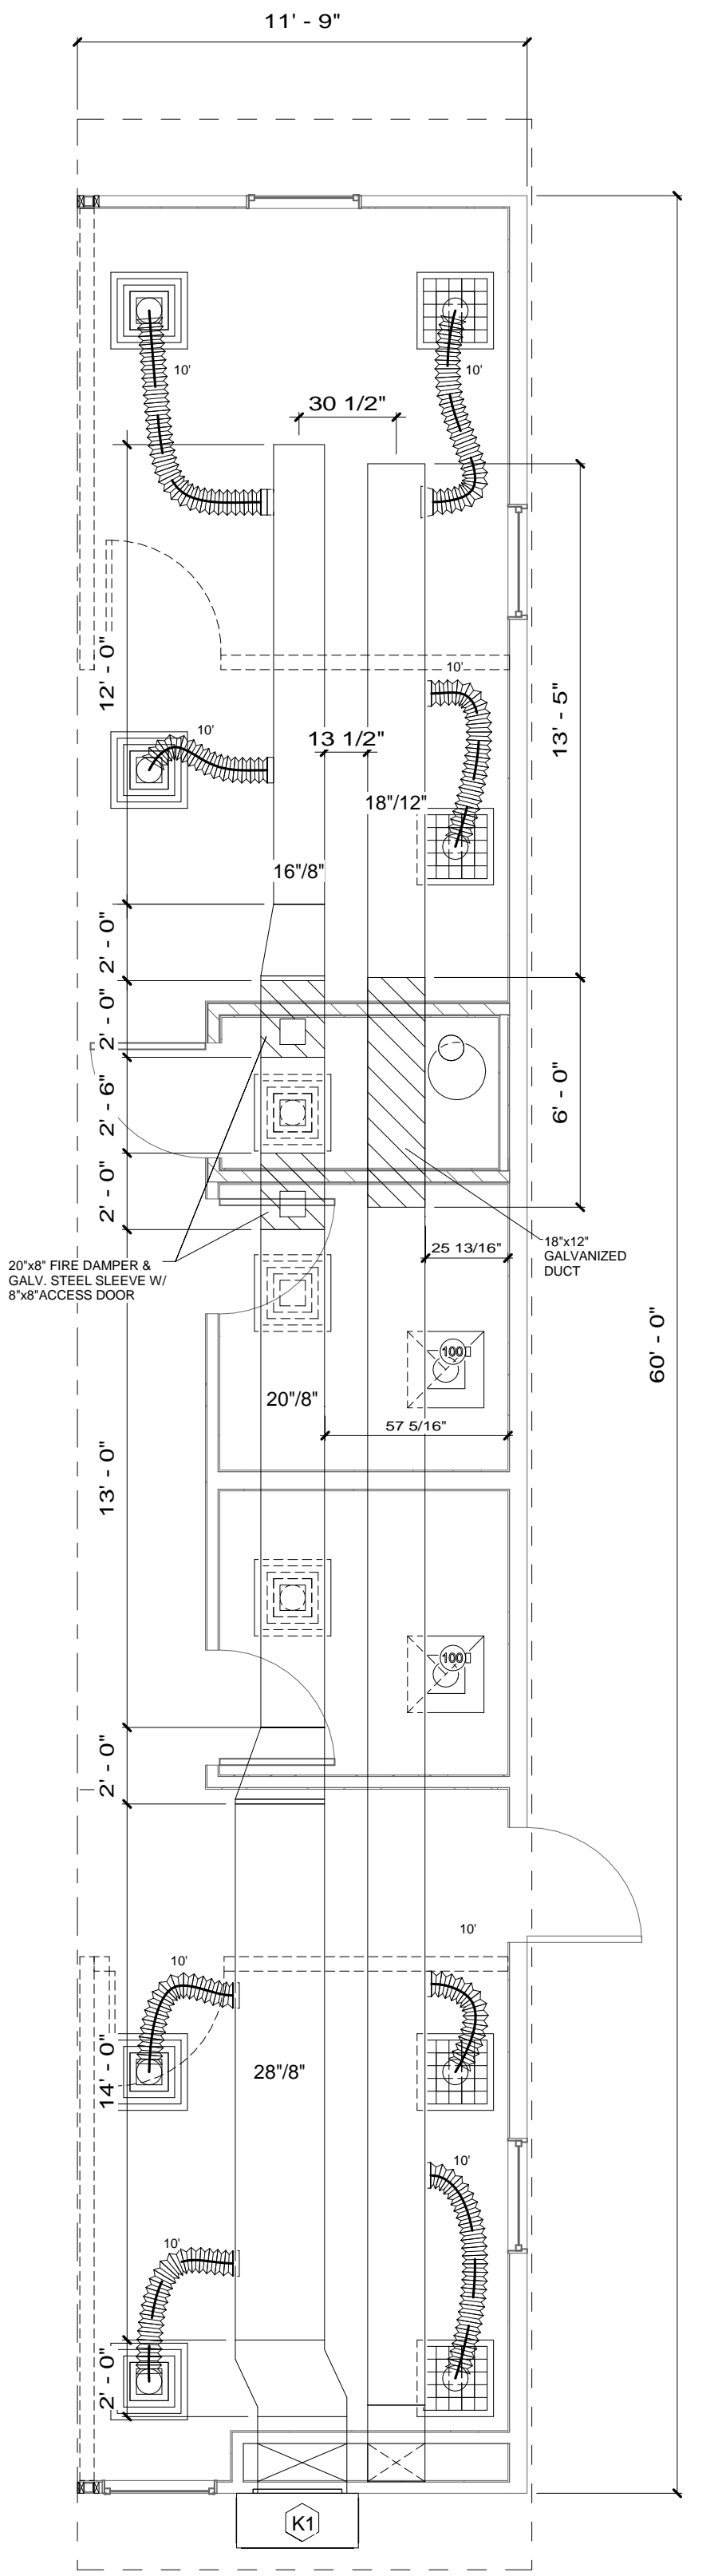

4 Mechanical Plan
1/4" = 1'-0"

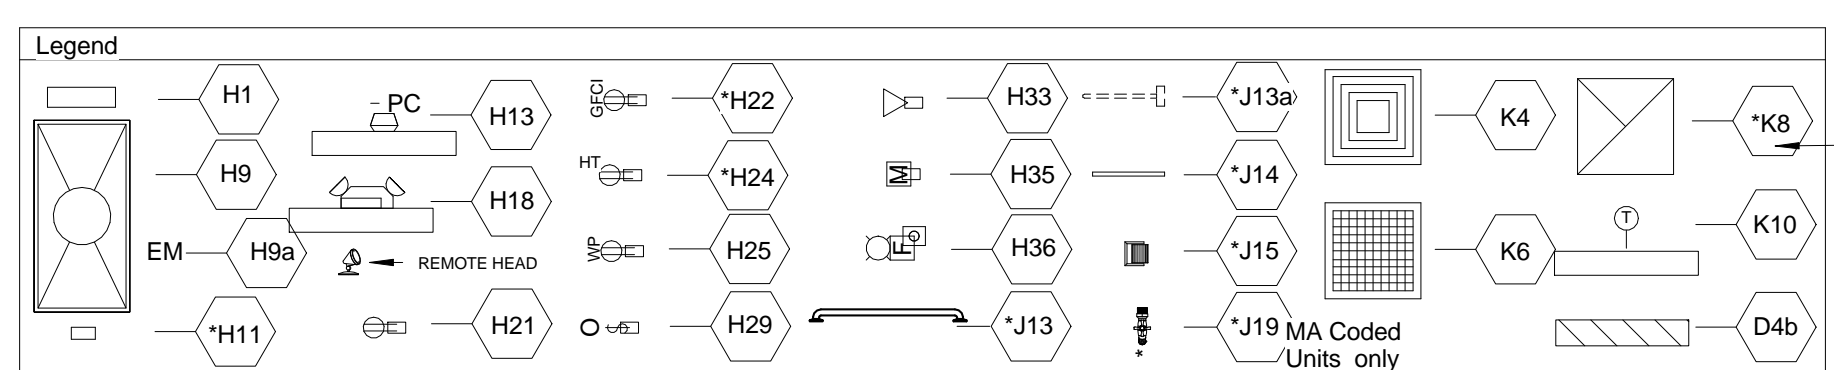

Note: Identification hexagons on the drawings and in the symbol legend correspond to the project specifications. The letter in the hexagon matches the specification section, the number in the hexagon matches the section number. * denotes items only in right sidewall modules with restrooms

GA FILE NO. WP 3341
GYPSUM WALLBOARD, WOOD STUDS
Base layer 1/4" gypsum wallboard applied parallel to each side of 2 x 4 wood studs 16" o.c. with 4d coated nails, 1 1/2" long, 0.099" shank, 1/4" heads, 12" o.c. Joints staggered 16" on opposite sides. Face layer 1/2" type X plain or predecorated gypsum wallboard or gypsum veneer base applied parallel to each side with 1/4" beads of adhesive 2" o.c. and 6d coated nails, 1 7/8" long, 0.0915" shank, 1/4" heads, 6" o.c. at top and bottom plates only. Offset joints 24" from base layer joints.
(LOAD-BEARING)

No.	Description	Date	No.	Description	Date
1	revised per third party deviation	6-15-15			

THIS DRAWING AND ALL INFORMATION CONTAINED HEREON IS THE PROPERTY OF WHITLEY MFG. CO. AND IS NOT TO BE REPRODUCED WITHOUT THE EXPRESS PERMISSION OF WHITLEY MFG. CO., INC. ASSUMES NO RESPONSIBILITY FOR UNAUTHORIZED USE OF THIS DRAWING.



2756 FORT WAYNE ROAD
P.O. BOX 505
ROCHESTER, IN 46785
PHONE: 574.223.4824
FAX: 574.223.8779

64 HESS ROAD
LEOLA, PA 17540
PHONE: 717.656.2081
FAX: 717.656.8149

Drawn By:
LRS-SUB
Checked By:
PG
Rev:
1

RIGHT SIDEWALL- SINGLE OCCUPANT RESTROOM OPTION
FLOOR/REFLECTED CEILING/ELECTRICAL/MECHANICAL PLAN

Model# 7111
64'x12' (60'-0"x11'-9" module)

Serial No.	Date:
	3-10-15
Quote No.	Scale:
	As indicated
Model No.	Page No.
7111	
Job No.	Job No.
	A2.1.Ra

7/6/2015 6:50:05 AM