



**2 THEATER CEILING PANEL SECTION**  
SCALE: 1/2" = 1'-0"

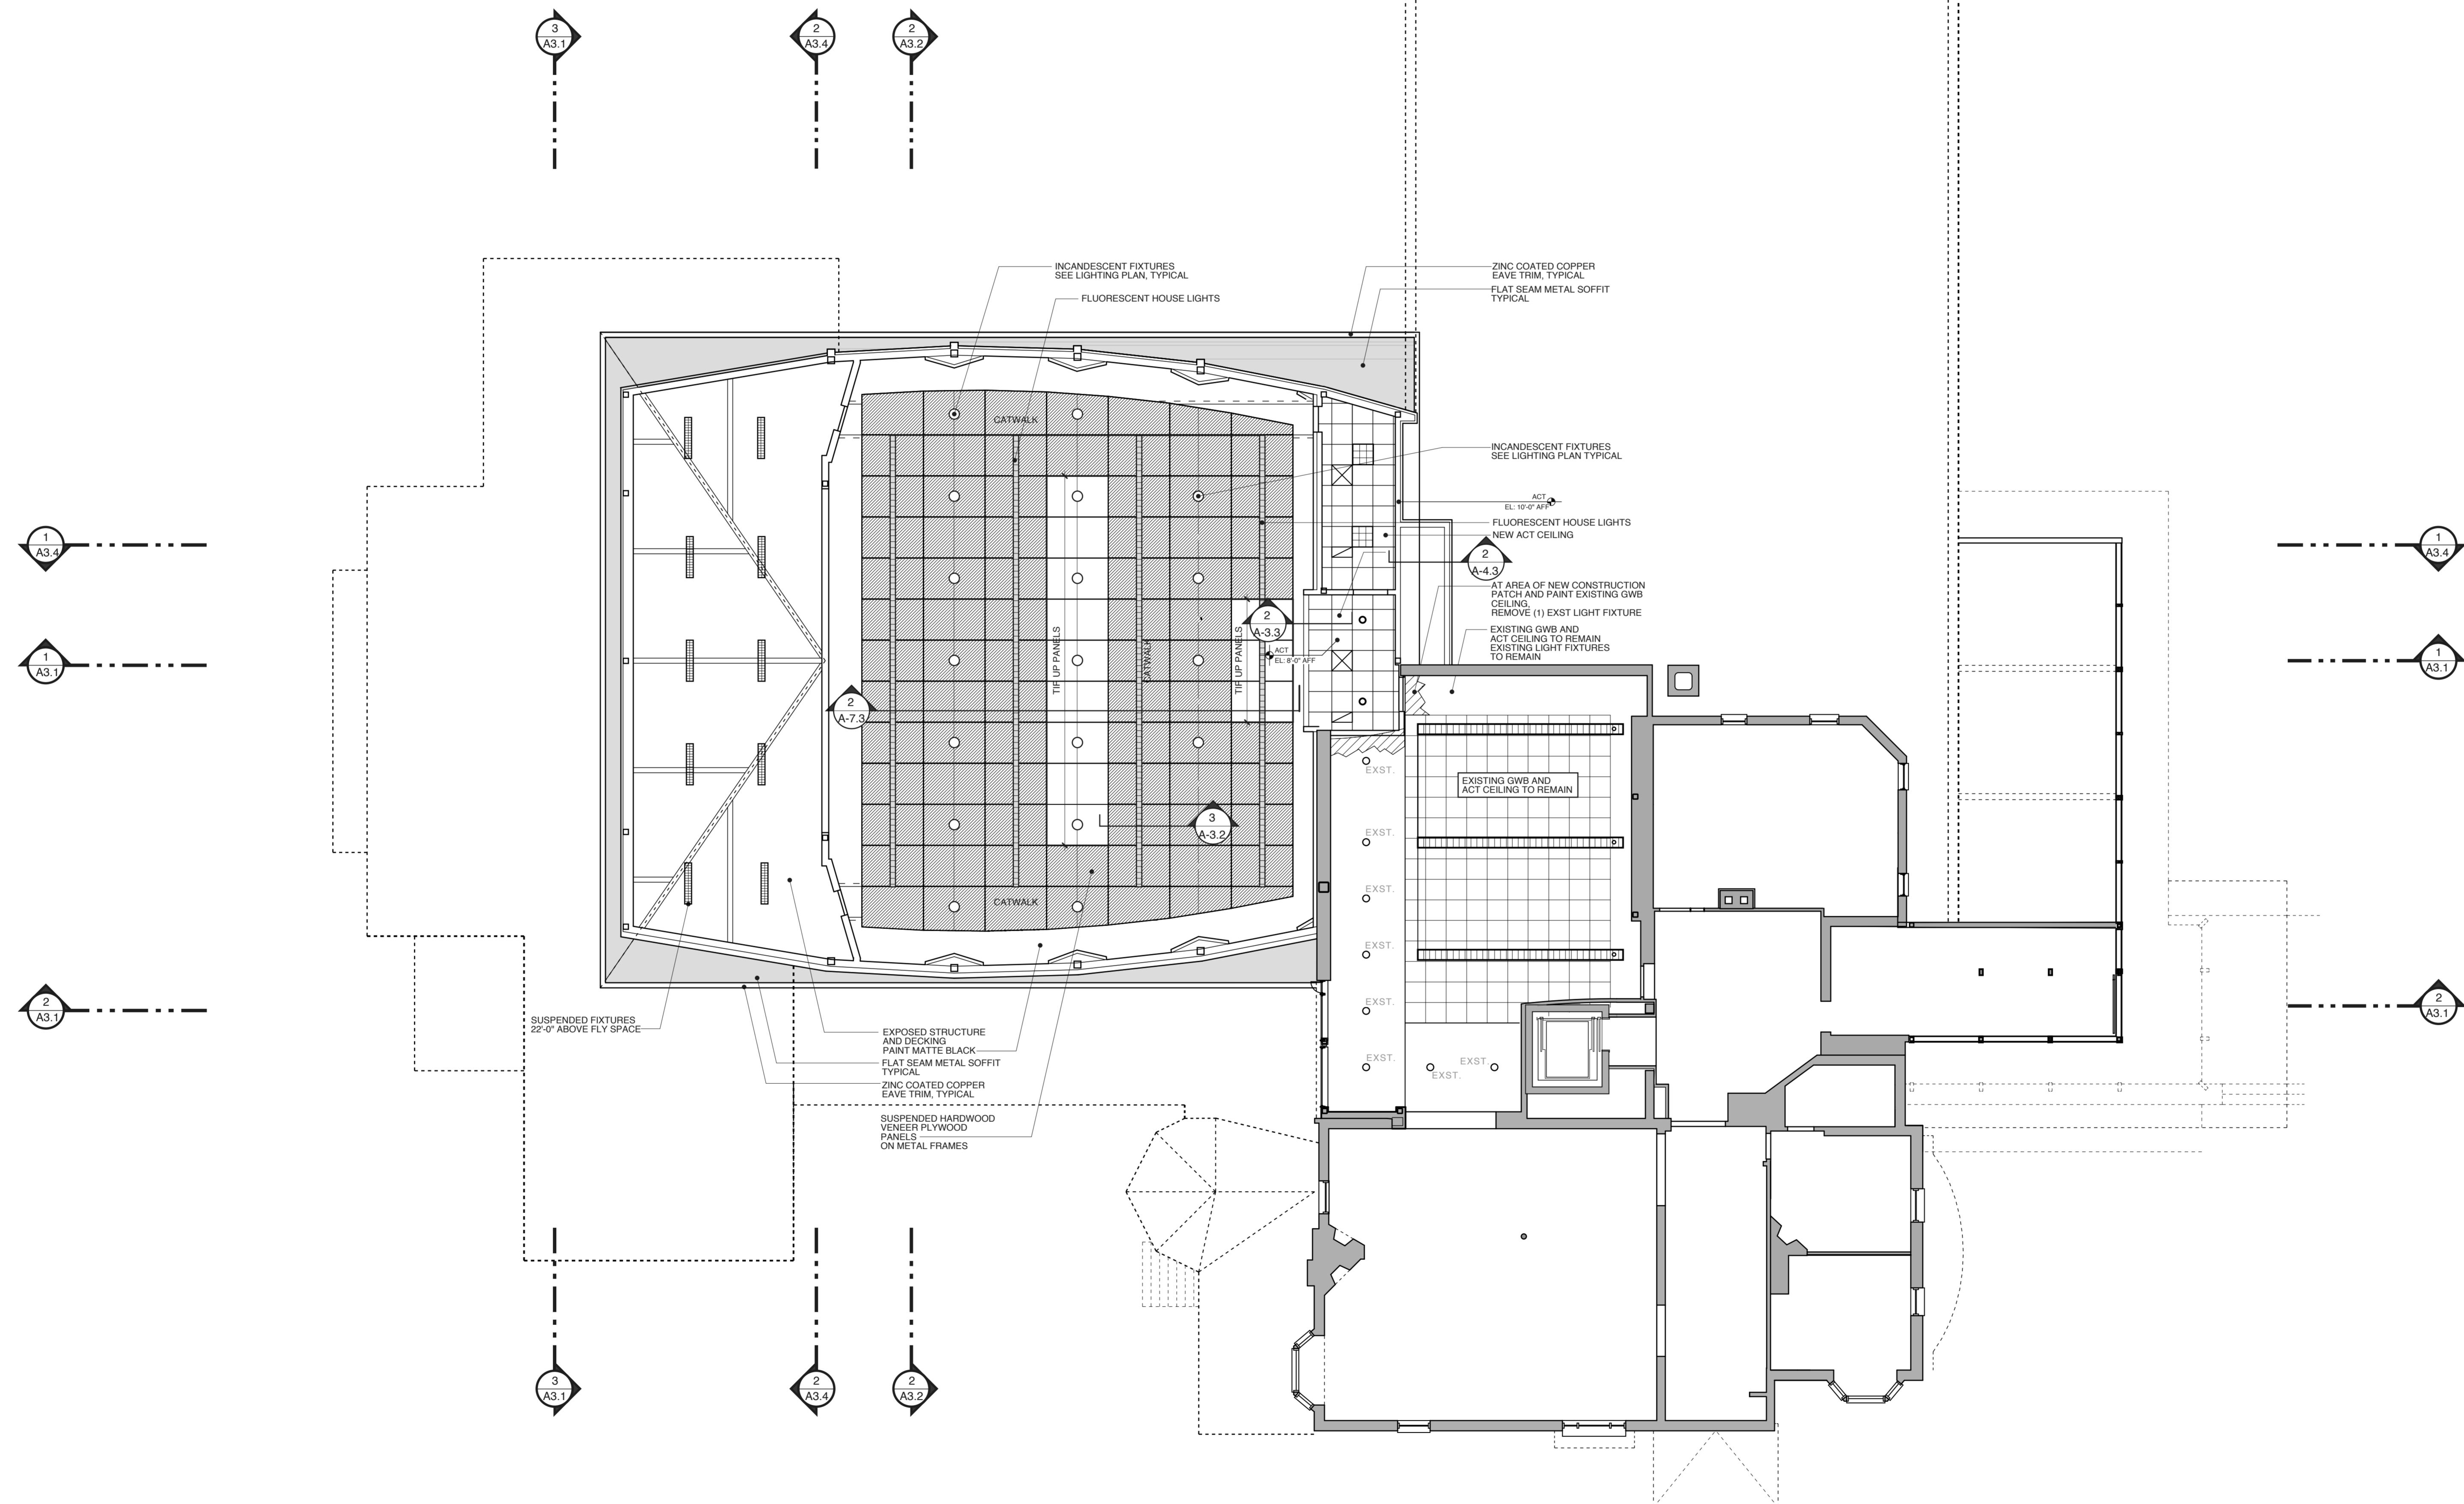

**1 UPPER FLOOR REFLECTED CEILING PLAN**  
SCALE: 1/8" = 1'-0"

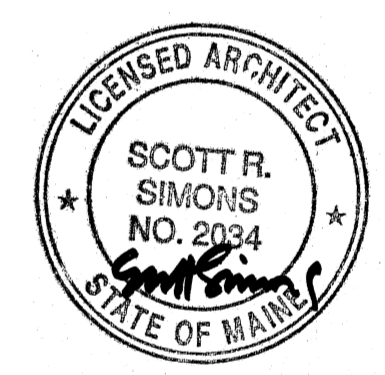

**SSI**  
Scott Simons Architects  
75 York Street  
Portland, Maine 04101  
phone 207 772 4656  
fax 207 828 4656

THIS DRAWING IS THE PROPERTY OF SCOTT SIMONS ARCHITECTS AND IS NOT TO BE COPIED OR REPRODUCED IN PART OR WHOLE.

PROJECT  
**WAYNFLETE ARTS CENTER PHASE TWO**  
ADDITION/ RENOVATION  
360 SPRING STREET  
PORTLAND, ME

TITLE  
**SECOND FLOOR RCP**

STATUS:  
**ISSUED FOR BIDDING**  
CONSTRUCTION DOCUMENTS

DATE: 09.07.2007 REVISION /DATE:

PROJECT NO. 2003-0040.00  
DRAWN BY:

DWG NO. 2007 © Scott Simons Architects  
**A-7.3**