


LIGHTING KEY NOTES:

- ① WATERPROOFING/LIGHTING CONTROLS TO INCLUDE:
 - 1) LS-E8 JUNCTION BOX
 - 2) LS-203 DIMMING CONTROLLER
 - 3) LS-200 SERIES WALL MOUNT OCCUPANCY SENSOR
 - 4) BT-200 SERIES WALL MOUNT PHOTOCELL
 - 5) LS-290C CEILING MOUNT PHOTOCELL
 - 6) LS-4C WALL SWITCH AND INSTALL LS-E8 L-BOX ABOVE CEILING AT ENTRANCE TO ROOM BEING SERVED. INSTALL LS-203 AND BT-203 IN SPECIFIC MOUNTING AND OPERATIONAL INDICATIONS.
 - ② ULTRASOUND OCCUPANCY SENSOR SET FOR MAXIMUM TIME INSTALL PER SPEC. L. WALL SWITCH OVERHEAD AND SENSORS
 - ③ MOUNT OCCUPANCY SENSORS 4" BELOW BOTTOM OF LIGHT FIXTURES.
 - ④ FIXTURES WITH EMERGENCY BALLAST REQUIRE AND ADDITIONAL WIRE AS THE 66 BALLAST.
 - ⑤ SEE ELEVATIONS ON ARCHITECTURAL DRAWING A-2.1 FOR MOUNTING LOCATION AND DIRECTIONS.

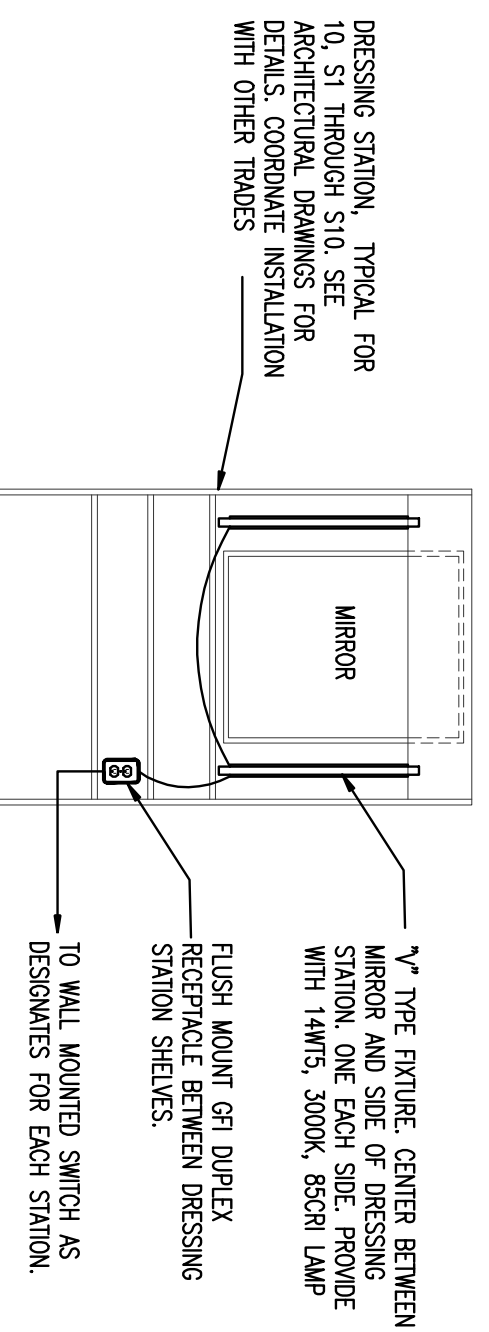

TYPICAL DRESSING STATION POWER & LIGHTING DETAIL

TYPICAL FOR 10 STATIONS - ST THRU S10
1/15

<p>SS&A Scott Simon Architects 73 York Street Portland, Maine 04101 Tel: 603.778.8888 Fax: 603.778.8888</p>	<p>Will and Gunter OLD FLE MARKET</p>	<p>PROJECT WAYNFLETE ARTS CENTER PHASE TWO</p> <p><input type="checkbox"/> ADDITION/RENOVATION 390 SPRING STREET PORTLAND, ME</p>
<p>TITLE ELECTRICAL LIGHTING GROUND FLOOR PLAN</p>		
<p>STATUS ISSUED FOR BIDDING</p>		
<p>DATE 08/27/2024</p> <p>SCALE 1/8" = 1'-0"</p> <p>PROJECT NO. 2024-004-01</p> <p>DRAWN BY: NS</p> <p>DWG NO. E-1.3</p>		