


STAGE SOUND SYSTEM RISER

N.T.S. - ALTERNATE #7

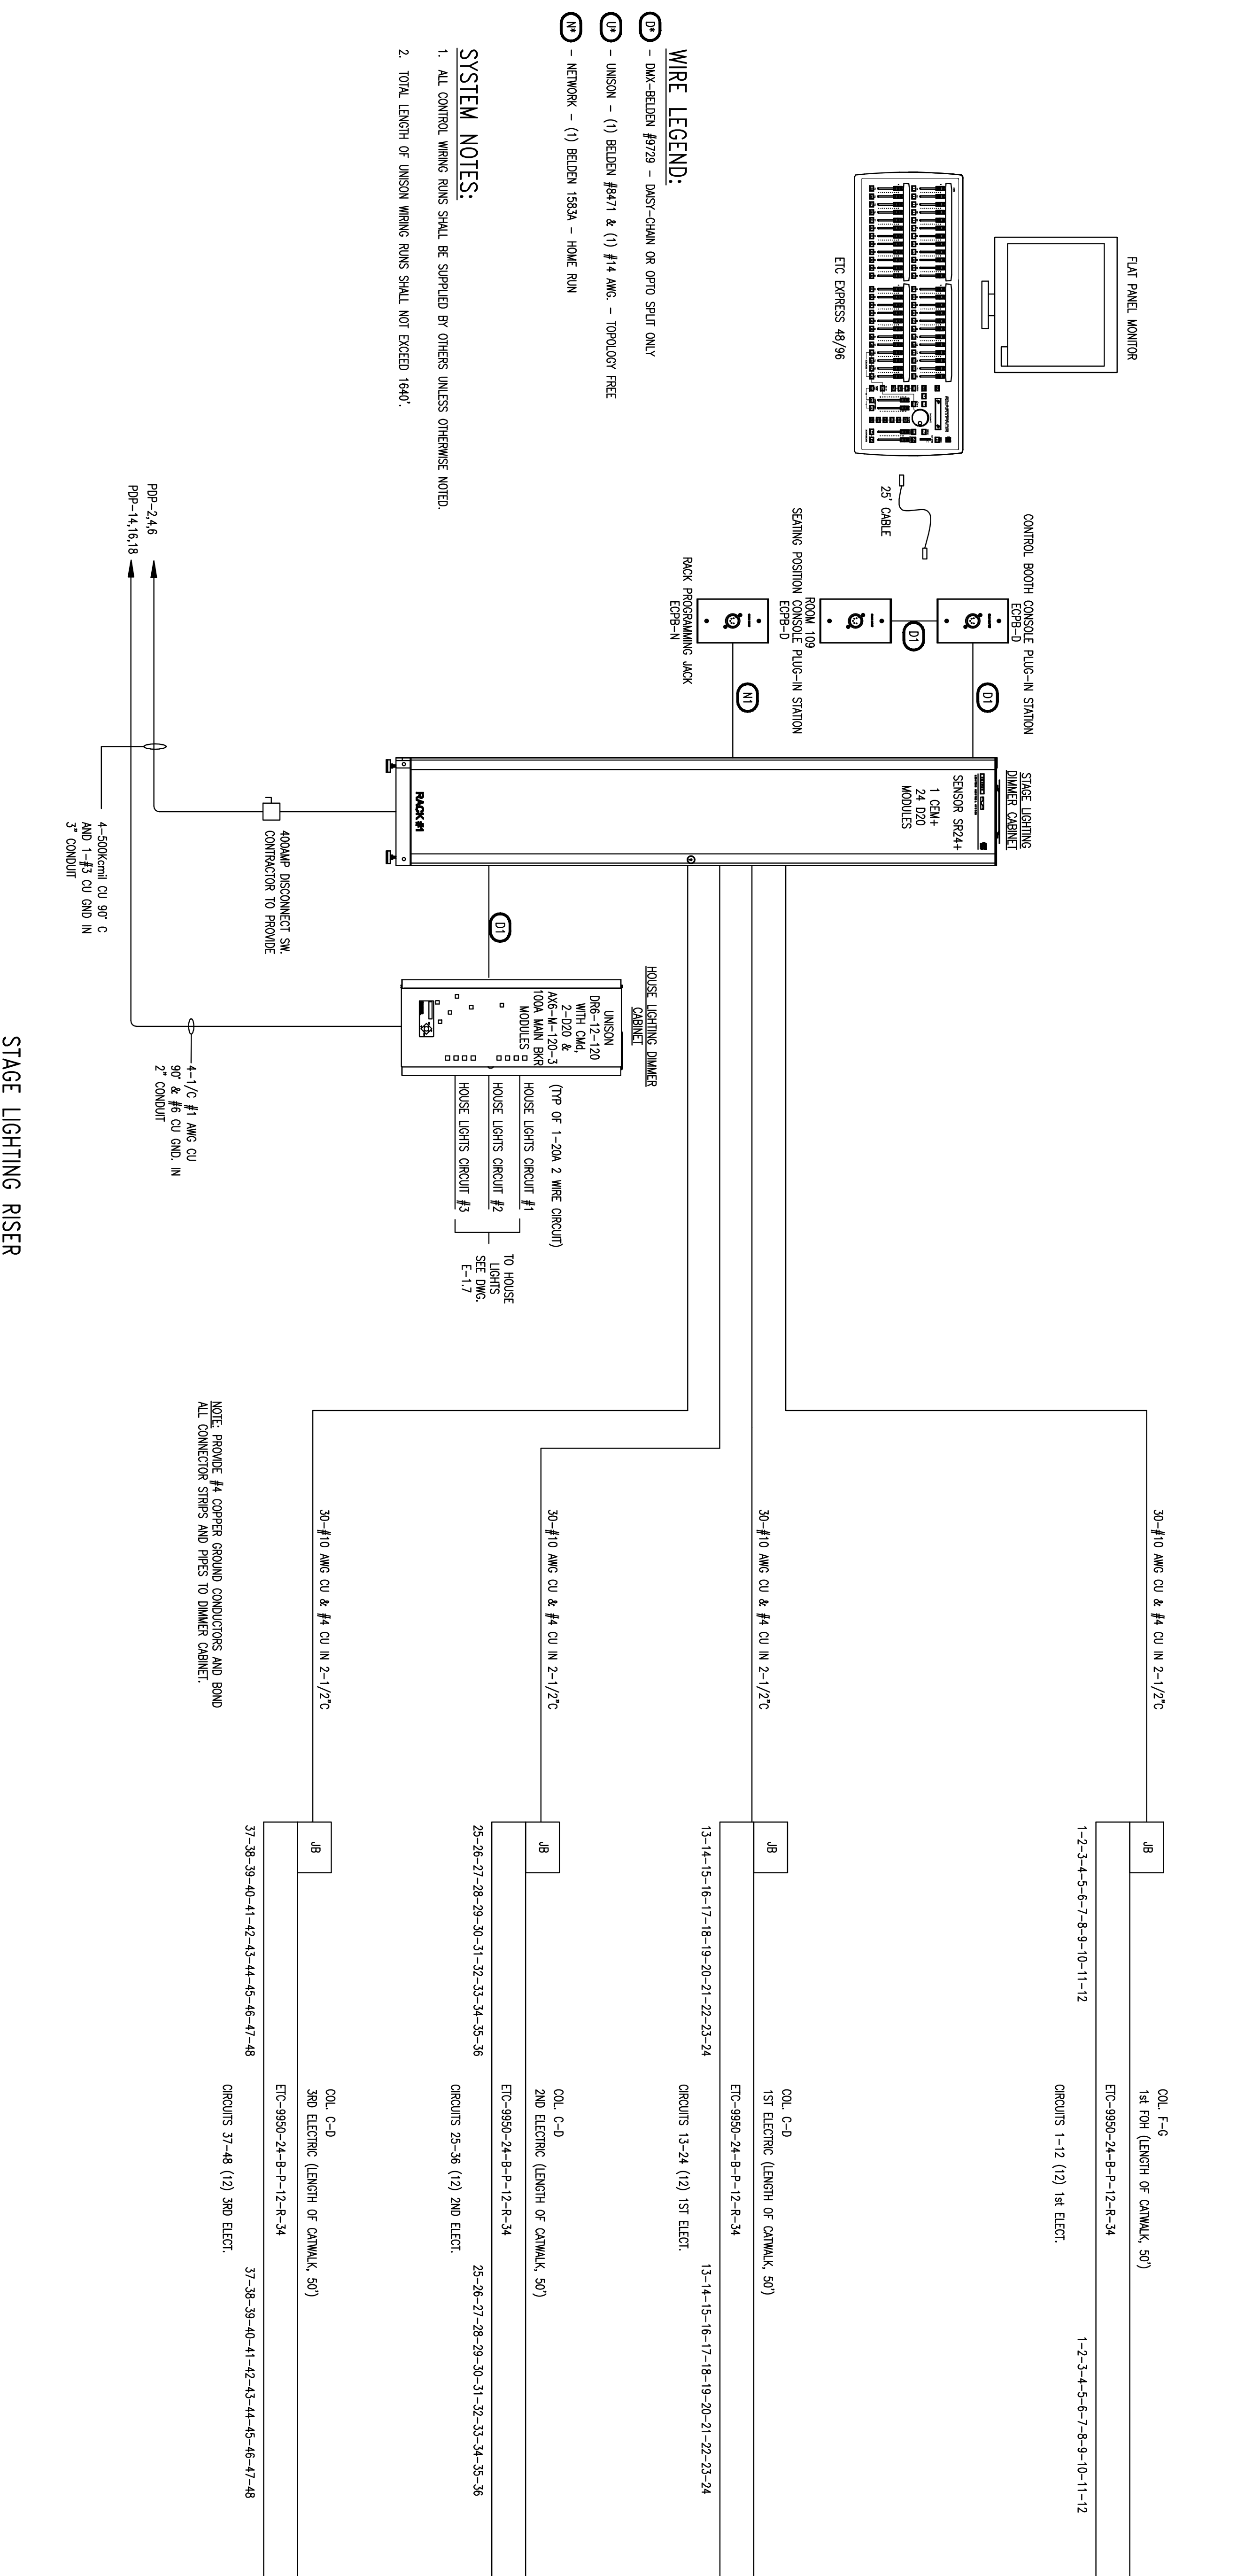

STAGE LIGHTING RISER


N.T.S.

- WIRE LEGEND:**
- (1) - DIM-BELEN #879 - DIST-CHAIN OR OPTO SPLIT ONLY
 - (1) - JINSON - (1) BELEN #871 & (1) #14 MC - TORQUOY FREE
 - (1) - NETWORK - (1) BELEN 183A - HOME RUN

SYSTEM NOTES:

1. ALL CONTROL WIRING SHALL BE SUPPLIED BY OTHERS UNLESS OTHERWISE NOTED.
2. TOTAL LENGTH OF JINSON WIRING SHALL NOT EXCEED 1940'

NOTE: PROVIDE #4 COPPER GROUND CONDUCTORS AND BOND ALL CONNECTION STRIPS AND PESS TO DIMMER CABINET

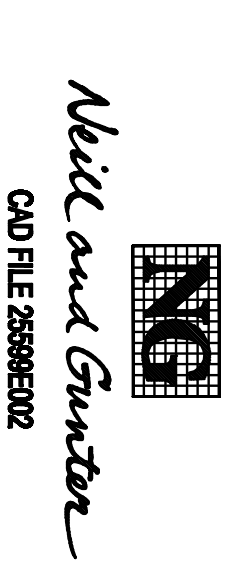 <p>Will and Gunter CAD FILE #2886202</p>	<p>73 York Street Portland, Maine 04101 Tel: 877 878 8888</p> <p>Scott Stone Architects 330 State Avenue Portland, Maine 04101 Tel: 877 878 8888</p>	<p>THIS DRAWING IS THE PROPERTY OF SCOTT STONE ARCHITECTS AND IS NOT TO BE COPIED OR REPRODUCED IN WHOLE OR IN PART.</p>
<p>PROJECT</p> <p>WAYNFLETE ARTS CENTER PHASE TWO</p> <p><input type="checkbox"/> ADDITION/RENOVATION 390 SPRING STREET PORTLAND, ME</p>		
<p>TITLE</p> <p>ELECTRICAL STAGE LIGHTING AND SOUND SYSTEM RISER DIAGRAMS</p>		
<p>STATUS</p> <p>ISSUED FOR BIDDING</p>		
<p>DATE 2007 SCALE NAME PROJECT NO. 2005-000-010 DRAWN BY: RABER DATE 2006</p>		
<p>DWG NO. E-1.8</p>		