



ALTERNATE #M1
 DRAWING NO. 4. DUCTLESS SPLIT AIR CONDITIONING SYSTEM
 DUCTLESS SPLIT SYSTEM WITH WIRELESS REMOTE CONTROL
 15 AMP FUSE, 65V/10V/1.4" HIGH, 62 LBS.
 DUCT-1, OUTDOOR SECTION #10-KASHIMA, 2002301162, 25 MCH, 40 AMP FUSE, 50P
 * 30P (VERT) REFRIGERANT PIPING, 3/4" DRAIN, 28V/15/30P HIGH, 74 POUNDS.
 * 30P IN REFRIGERANT PIPING * DRAIN UNDER SPACE BID

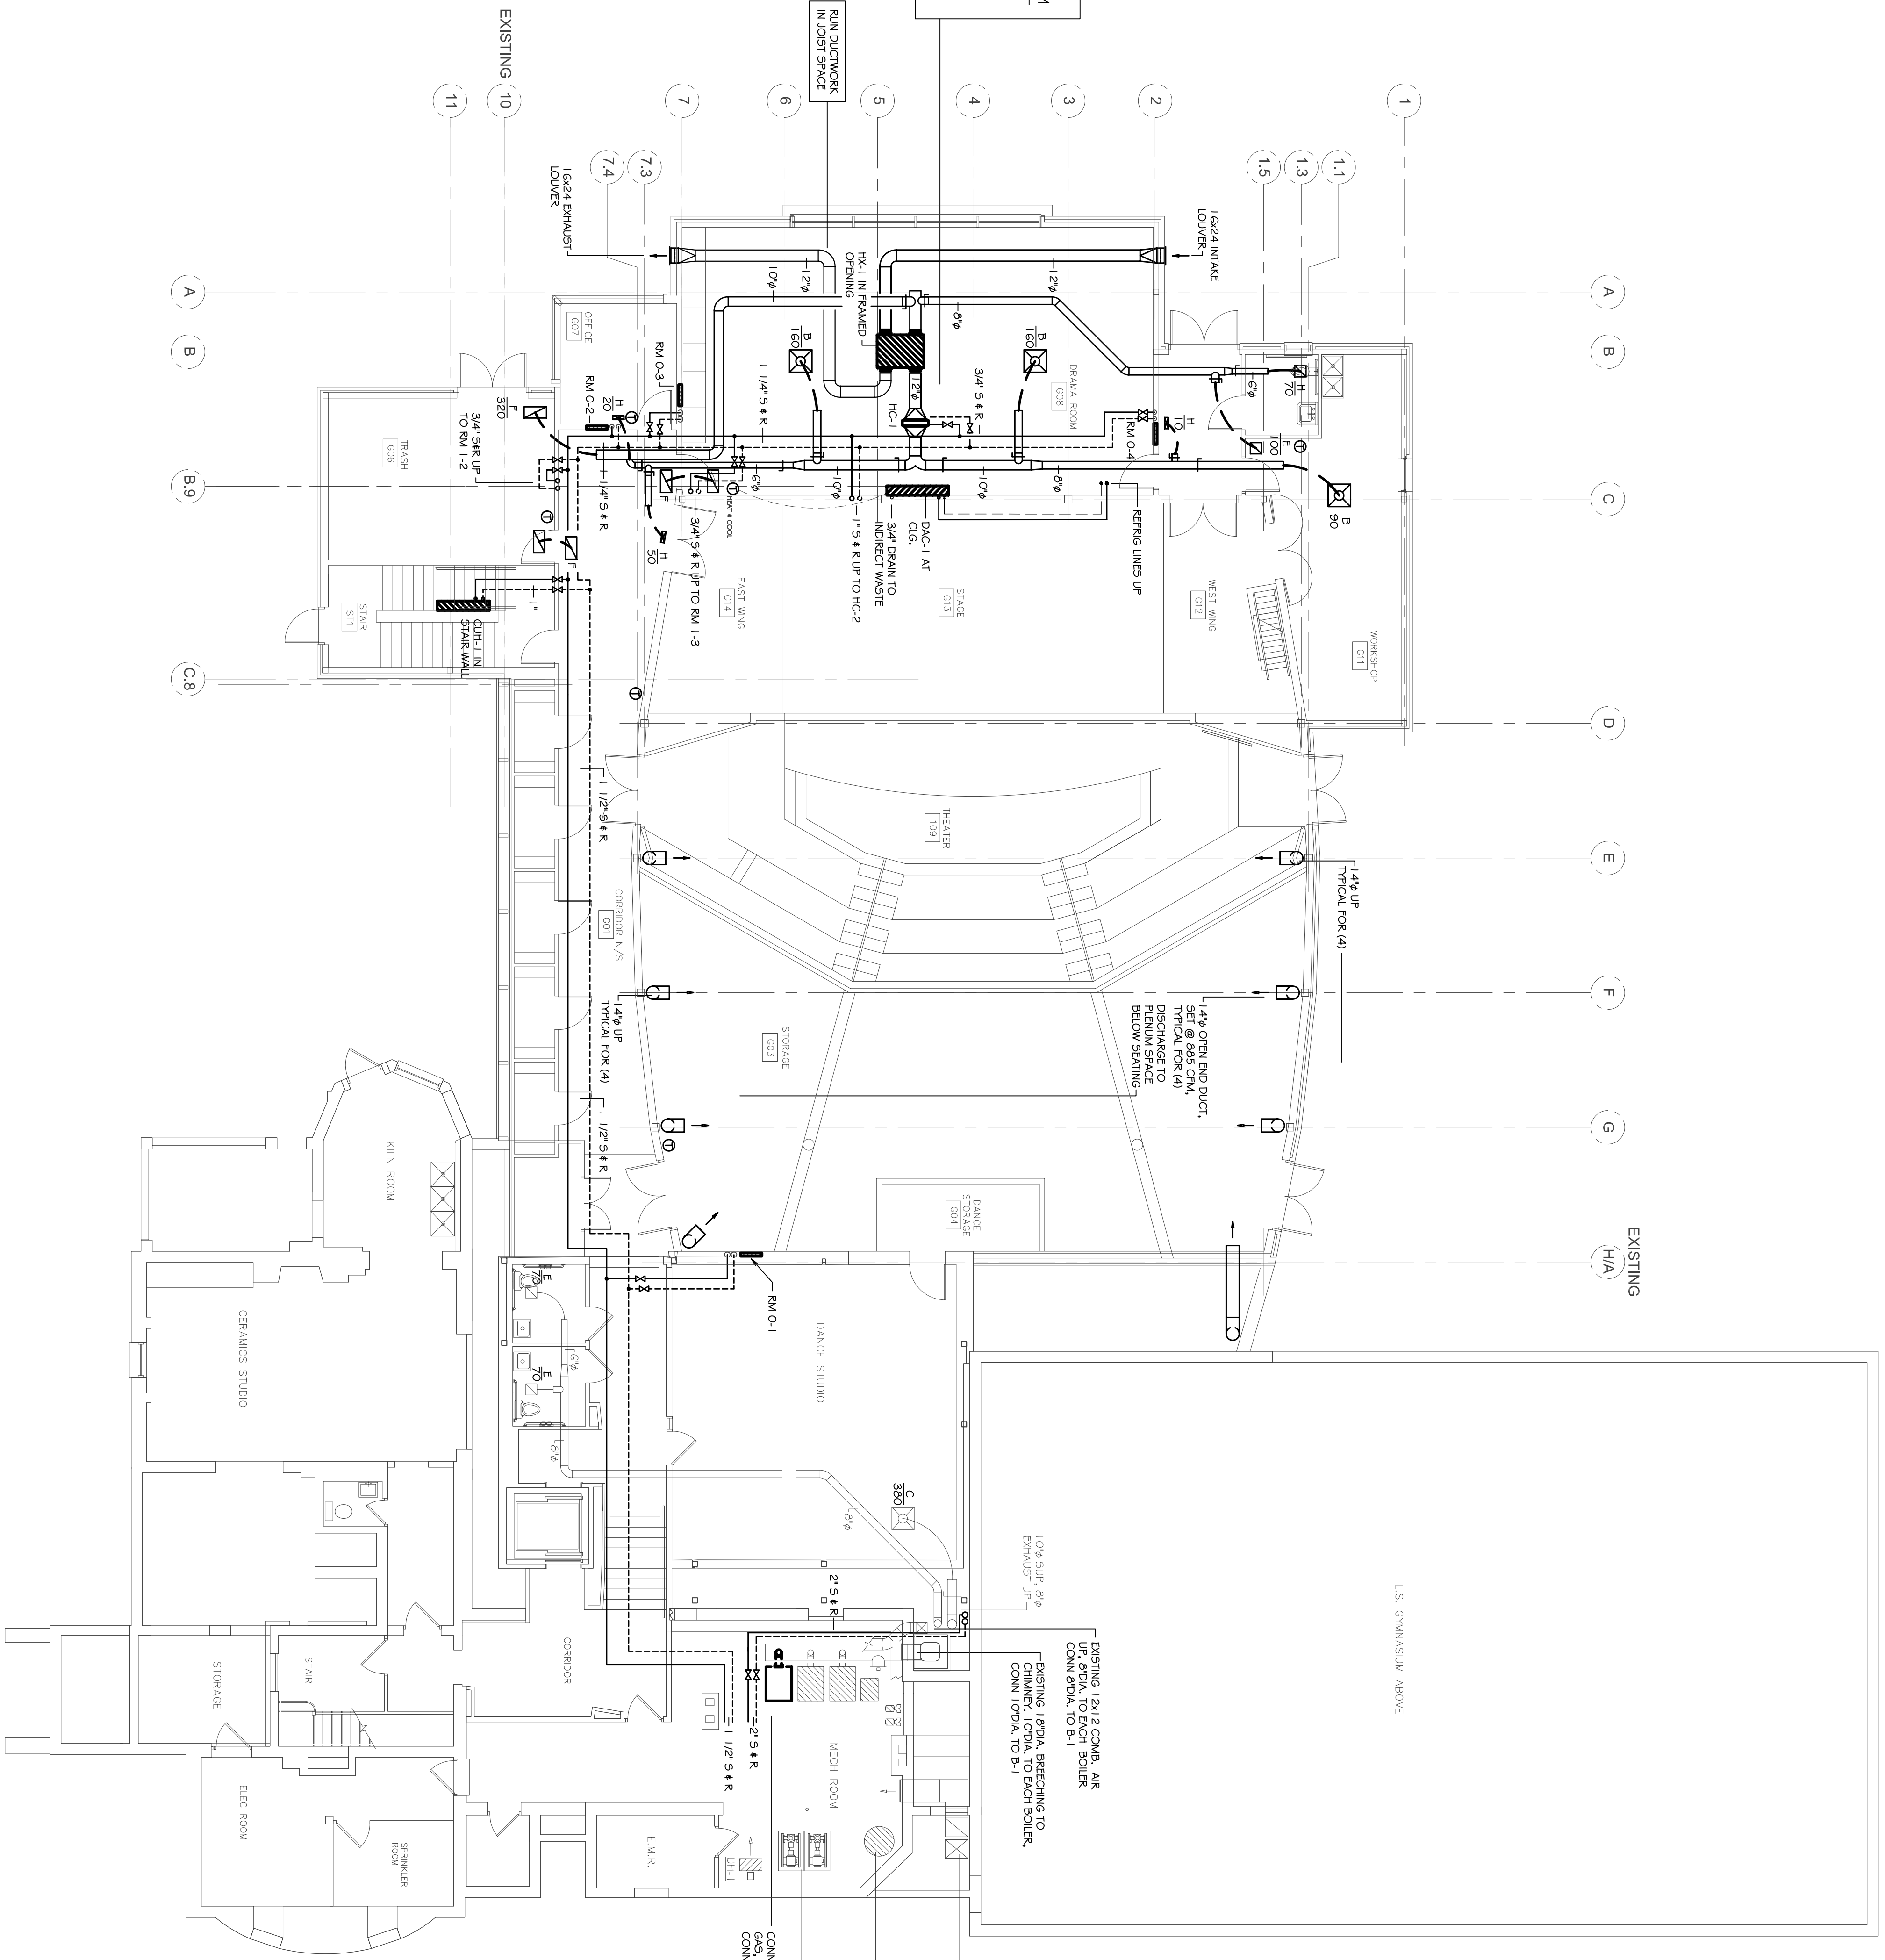

BASEMENT FLOOR PLAN
 SCALE 1/8"=1'-0"

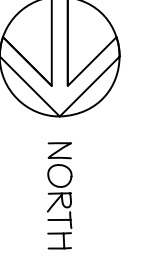

- THINGS TO DO & COORDINATE
1. MECH ALTERNATES #1, 2, 3, 4, 4B
 2. COIL LOADS #1, 60 & 750
 3. CO2 SENSORS #1, 60 & 750
 4. DYNAMIC FILTERS ON HX-1 THRU 3P
 5. (4) VAVS RECD IN GYM NOTT (2)
 6. FIRE DAMPERS?
 7. FIRE DAMPERS?
 8. FIRE DAMPERS?
 9. FIRE DAMPERS?
 10. FIRE DAMPERS?
 11. ROOM 201 & 202 INTERNAL LOADS?
 12. NEW HEAT LOADS
- ADDITION, 950 MBH
 GMV OA, 200 MBH
 EX. OA, 100 MBH
 GMV EXHST. ZONE, 280 MBH