



TO DO:

1. HOSE BIBB LOCATIONS?

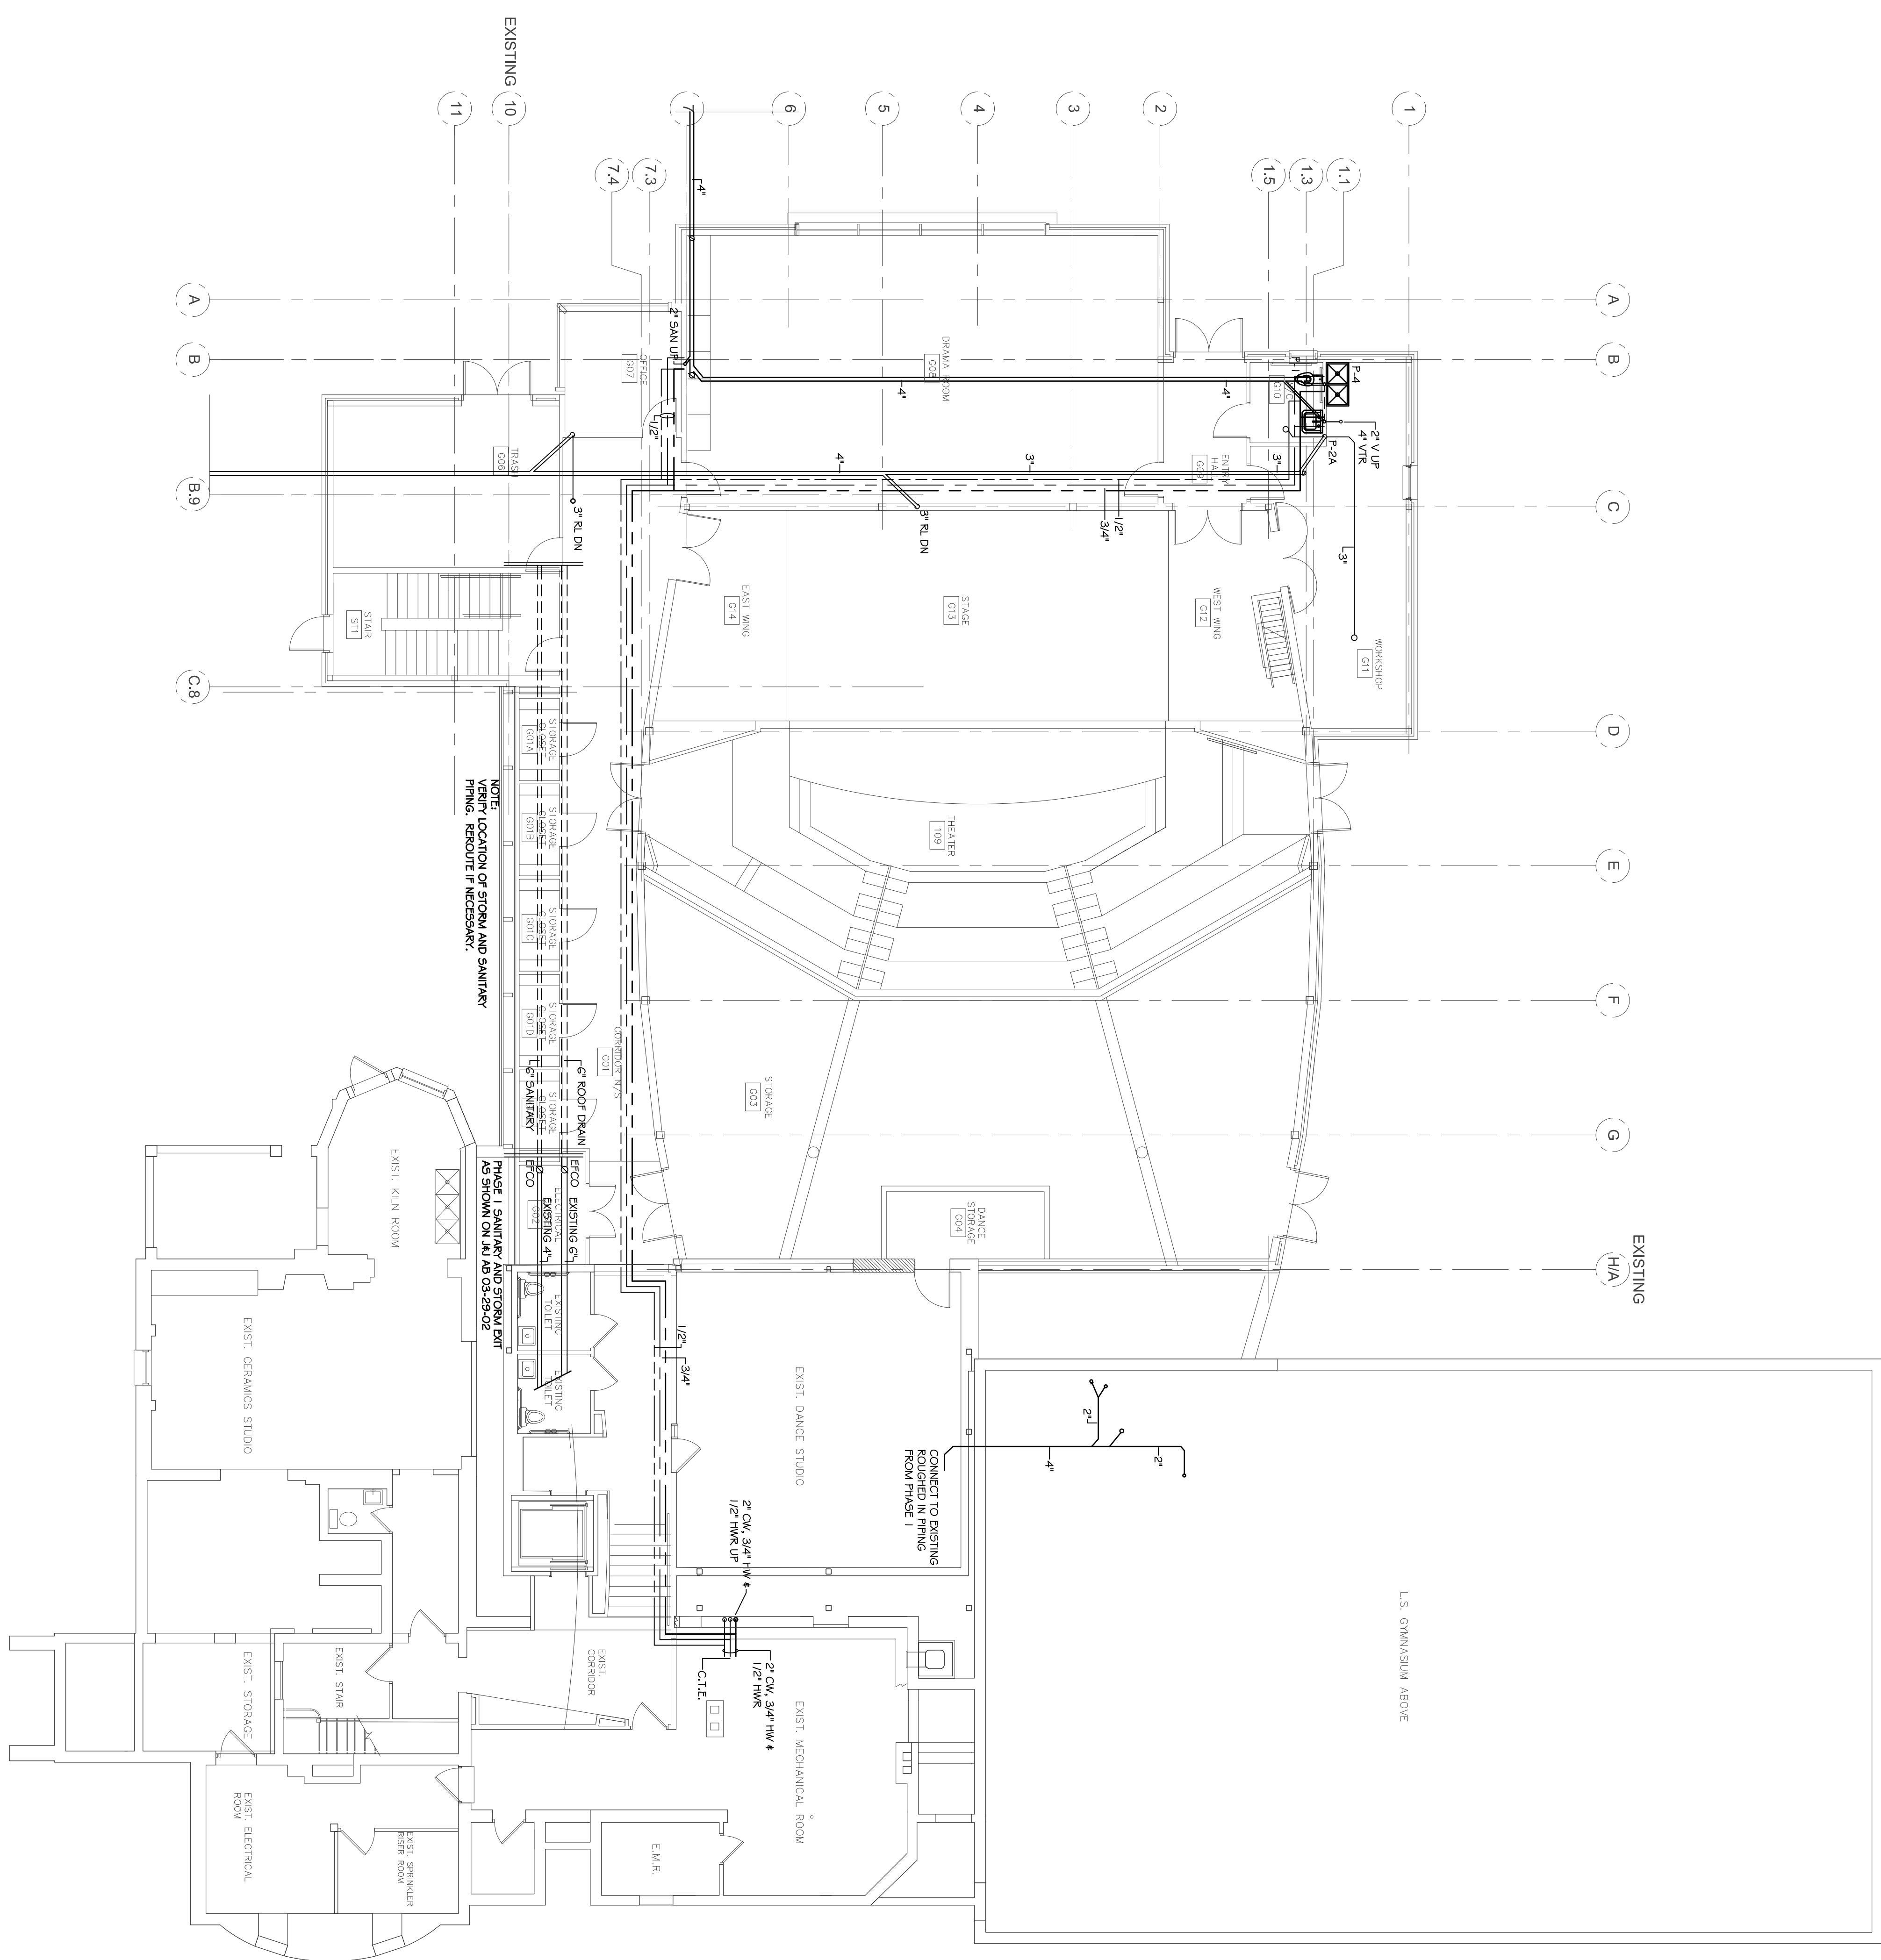

BASEMENT FLOOR PLAN

SCALE 1/8"=1'-0"

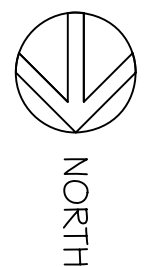

SHEET #

M-6

OF 8

PROJECT:

WAYNFLETE ART CENTER

PORTLAND, ME.

DRAWN:

MPJ

CHECKED:

MPJ

SCALE:

1/8"=1'-0"

DATE:

08-03-07

PROJECT #

07144

DRAWINGS THIS SHEET

BASEMENT PLUMBING PLANS & DETAILS

REVISIONS:

ISSUED FOR BIDDING  
09-07-2007

**JOHNSON & JORDAN**  
MECHANICAL CONTRACTORS  
18 MUSSEY ROAD  
SCARBOROUGH, MAINE 04074  
TEL (207) 883-8345 \* FAX (207) 883-8619

