

REVISION	DESCRIPTION	DATE
0	ISSUED FOR REVIEW & APPROVAL	4/19/2016
1	REVISED PER FULL SPRINKLER SYSTEM	8/4/2016


RESERVED FOR CITY STAMP

CUNNINGHAM
 Security Systems
 10 Princes Point Road, Yarmouth, Maine 04096
 Office: 207.846.3350 • Fax: 207.846.6080

**32 THOMAS STREET APARTMENTS
 PORTLAND, MAINE 04102
 THIRD FLOOR FIRE ALARM PLAN**

DRAWN	JPB UNICAD JOB #16190
CHECKED	WAYNE B. HAWES NCET # 90496
DATE	4/19/2016
REVISION	1
SCALE	AS NOTED

FA-4

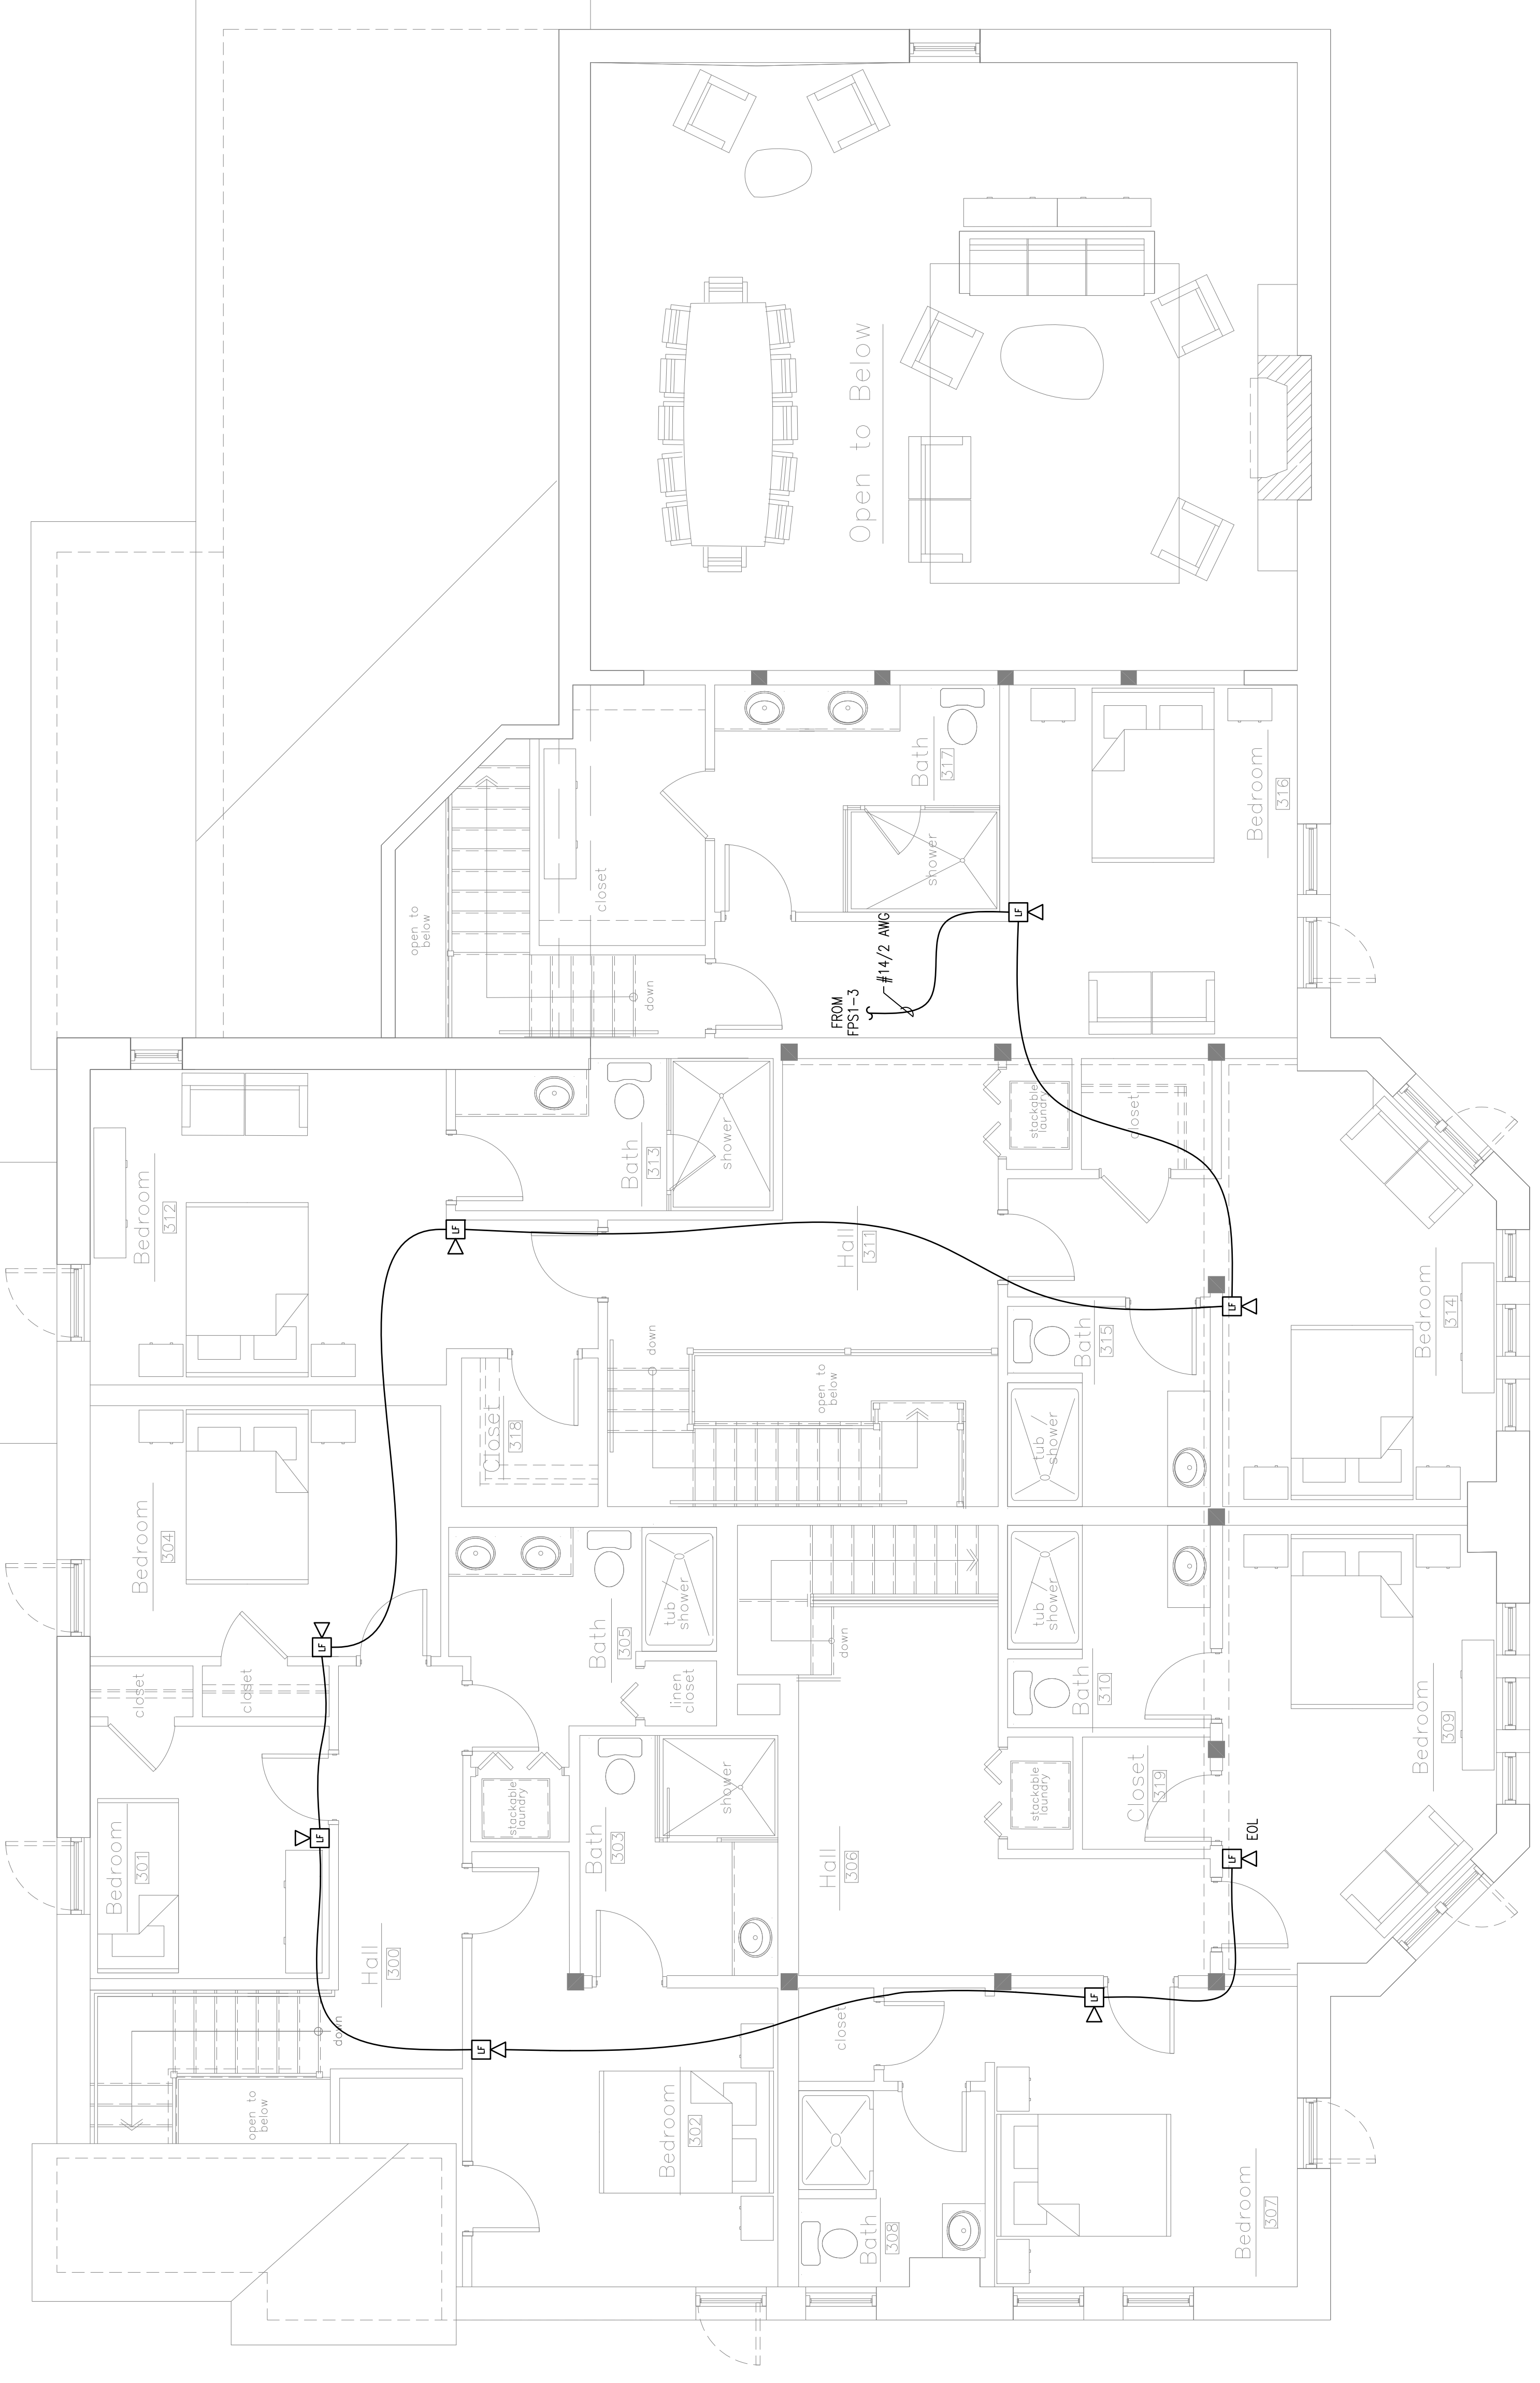

THIRD FLOOR FIRE ALARM PLAN
 SCALE: 1/4"=1'-0"

