

Basement
1/4" = 1'-0"


First Floor
1/4" = 1'-0"

| DESIGN AREA NO. | |
|---|-------|
| Location | _____ |
| 1. Density (lb/sq ft) | _____ |
| 2. Area (sq ft) | _____ |
| 3. No. of Sprinklers | _____ |
| 4. Classification | _____ |
| 5. Max storage height (ft) | _____ |
| Demand | |
| 1. Water flow rate (gpm) | _____ |
| 2. Residual pressure at the base of the riser (psi) | _____ |
| 3. Hose Stream allowance (gpm) | _____ |

| DESIGN AREA NO. | |
|---|-------|
| Location | _____ |
| 1. Density (lb/sq ft) | _____ |
| 2. Area (sq ft) | _____ |
| 3. No. of Sprinklers | _____ |
| 4. Classification | _____ |
| 5. Max storage height (ft) | _____ |
| Demand | |
| 1. Water flow rate (gpm) | _____ |
| 2. Residual pressure at the base of the riser (psi) | _____ |
| 3. Hose Stream allowance (gpm) | _____ |

Design Standard: _____
 Variations: _____
 Log: _____

GENERAL NOTES
 ALL DIMENSIONS SHOWN ARE CENTER TO CENTER.
 ALL PIPES AND HANGERS ARE TO BE INSTALLED PER _____
 HANGERS ARE TO BE U.L. LISTED AND F.M. APPROVED.
 OWNER SHALL PROVIDE ADEQUATE HEAT TO PREVENT WET-PIPE SPRINKLER PIPING FROM FREEZING. OWNER SHALL MAINTAIN SPRINKLER SYSTEM IN ACCORDANCE WITH NFPA 25 AND ALL APPLICABLE FEDERAL, STATE, AND LOCAL LAWS.
 THIS SYSTEM HAS BEEN DESIGNED BY AND SHALL BE INSTALLED BY MAINE FIRE PROTECTION SYSTEMS AND USE OF THESE DRAWINGS FOR OTHER PURPOSES IS STRICTLY PROHIBITED.

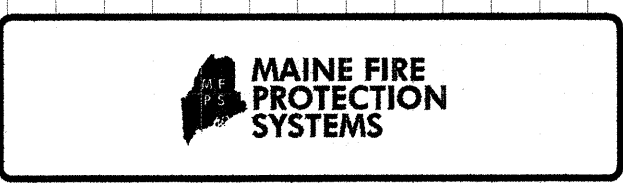

| SPRINKLER SYSTEM # | LOCATION | QTY | ORIFACE | MAKE | MODEL | TEMP | FINISH | NOTES |
|--------------------|----------|-----|---------|------|-------|------|--------|-------|
| | | | | | | | | |
| | | | | | | | | |
| | | |
|-------------------------|---|-------------|
| DRAWN BY <i>R.T.</i> | DATE <i>5-12-11</i> | APPROVAL BY |
| FILE NAME | CONTRACTOR | |
| JOB NO. | MAINE FIRE PROTECTION 6 DOWD ROAD BANGOR, ME 04401 | |
| JOB NAME | Charles DeRouche 19 Bramhall Street Portland, Maine | |
| 1/4" GRAPH 24"x36" | SHEET 1 of 2 | |