



NORTH

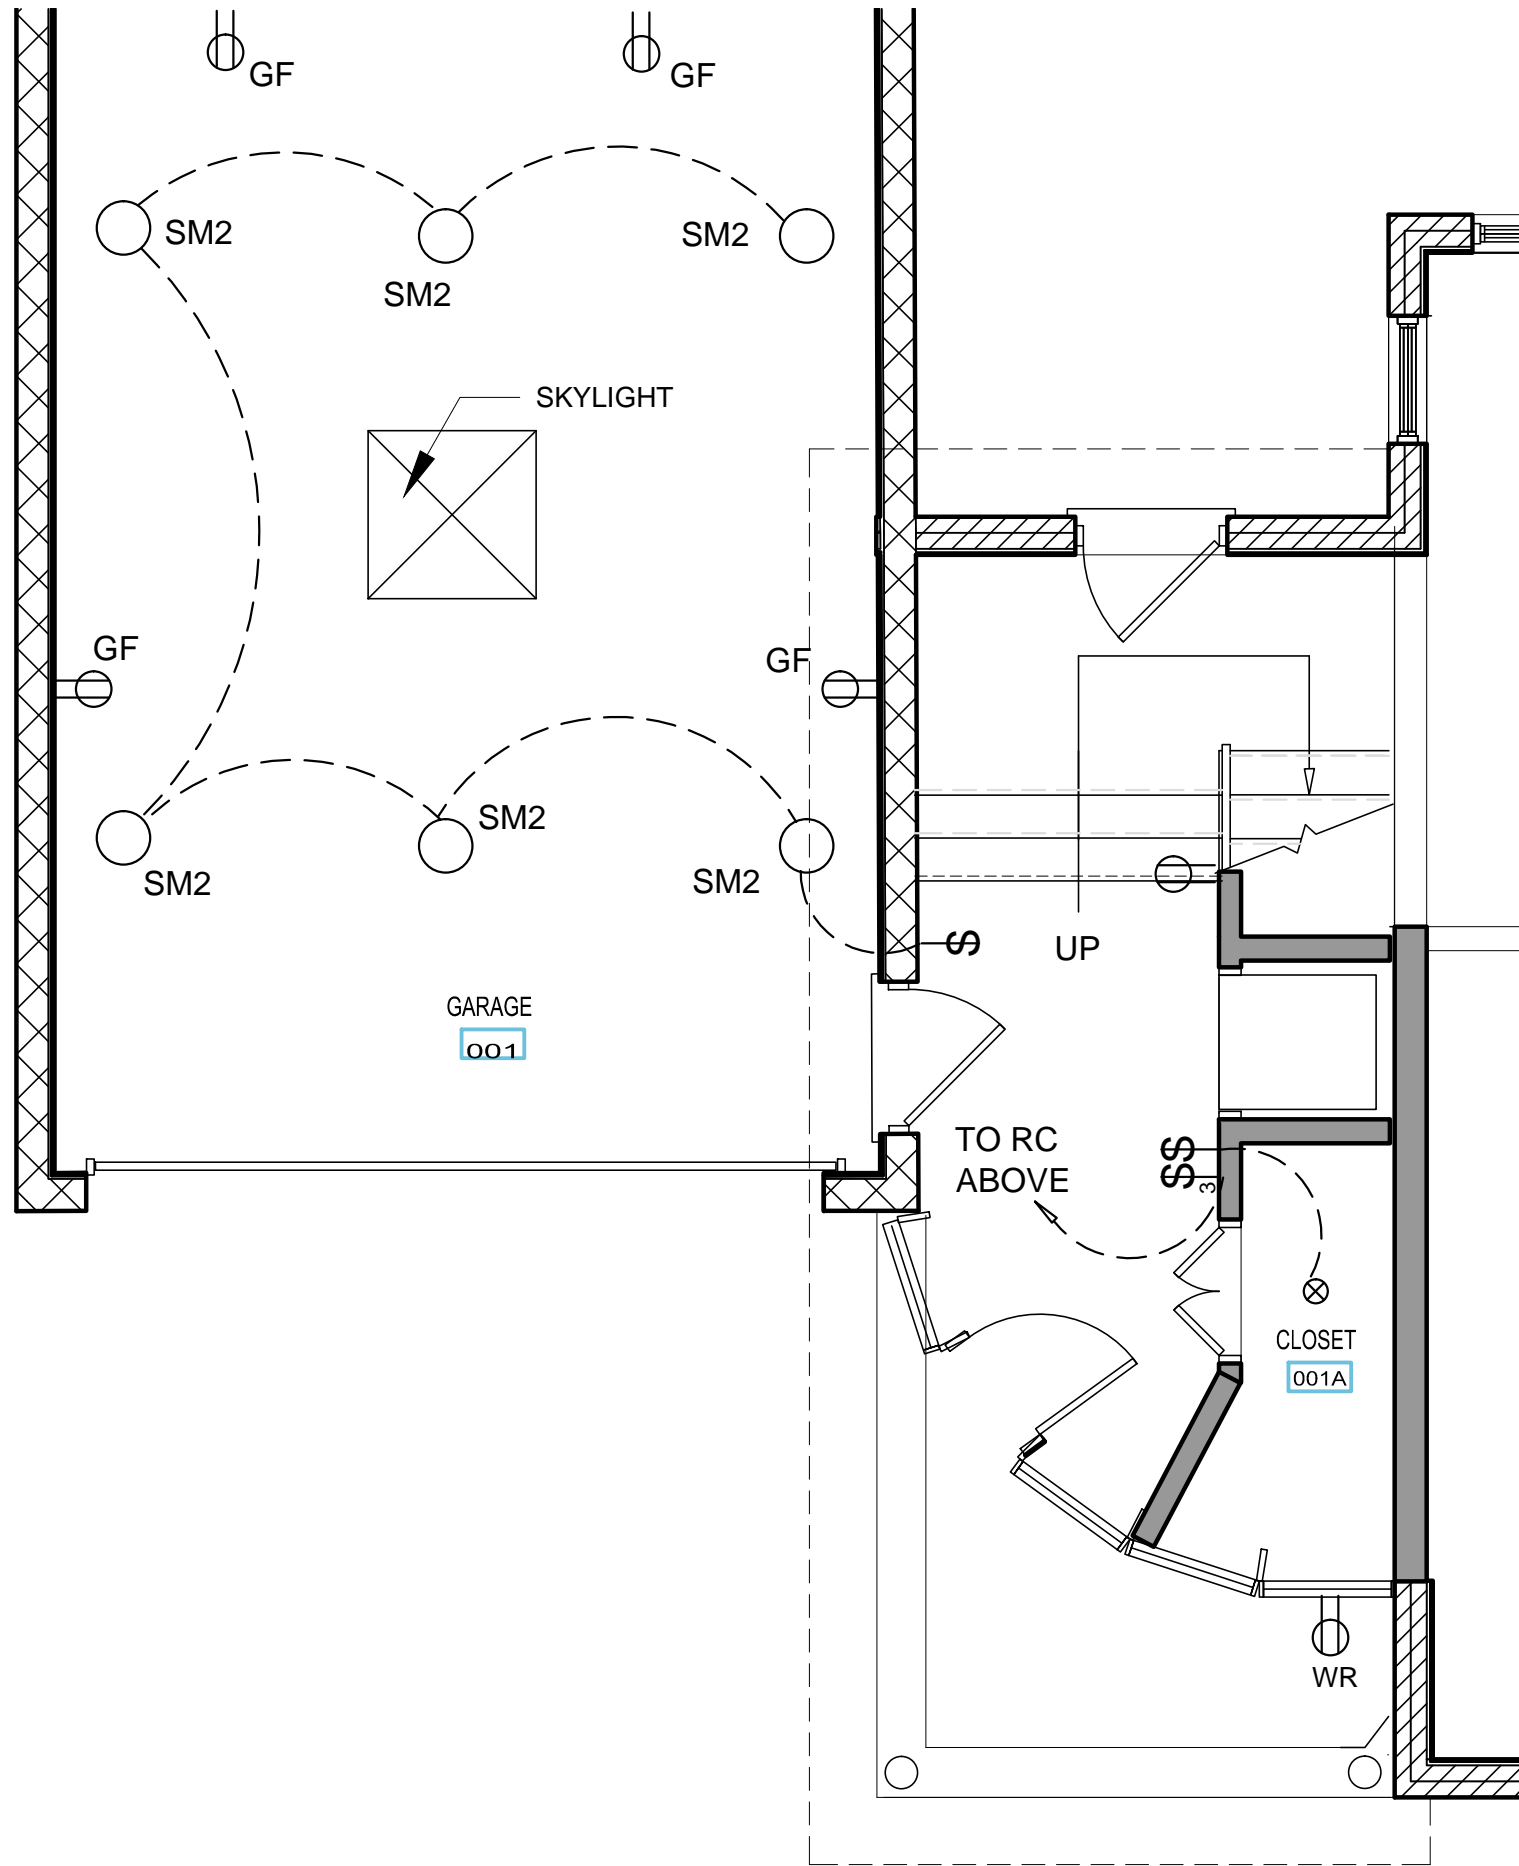

### LIGHT FIXTURE SCHEDULE

SYMBOL	NUMBER	DESCRIPTION
○	RC	RECESSED
⊖	SL	LOW VOLTAGE MARINE STEP LIGHTS MOUNTED IN --
⊗	SM	PENDANT
○	P-1	RECESSED? PENDANT?
⊗	S-0	SURFACE-MOUNTED FLUORESCENT
○	SM2	SURFACE MOUNT GARAGE
▭	S-1	LOW VOLTAGE MARINE STEP LIGHTS MOUNTED IN --
▭	UC	UNDERCABINET MOUNT
●	WC	RECESSED WALL WASHER
⌚		WALL SWITCH
▭		UNDERCABINET MOUNT
⊖		RECEPTACLE

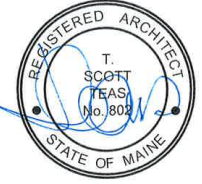

104 WEST STREET FORSYTH RESIDENCE

**GROUND FL POWER & LIGHTING PLAN  
 FIXTURE SCHEDULE**

scale	1/4" = 1'-0"
date	19 JULY 2016
project #	1507
drawn by	-
checked by	-

**E 1.0**