








-  Smoke Detector
-  Heat Detector
-  CO Detector
-  Horn/strobe
-  Fire Panel
-  Annunciator
-  Manual Pull Station



40-42 WEST STREET BASEMENT FLOOR
SCALE: N.T.S.

DRAFTSMAN:
Stephen S. Andrews
23 Printer Row
Portland, Maine 04071
207-415-5055

WEST ST. APARTMENTS


40-42 West Street Portland, Maine

PROJECT NAME:


REV.	DATE	DESCRIPTION	BY	DATE

CODE:	TOWN: Portland, Me
DATE:	09-26-18
SCALE:	
DESIGNED:	SSA
DRAWN:	SSA
TITLE:	BASEMENT FLOOR PLAN
FILE:	
SHEET:	A-1

PROJECT NAME: WEST ST. APARTMENTS		REV	DATE	BY
40-42 West Street Portland, Maine		DESCRIPTION		
DRAWN BY: Stephen S. Andrews		REV	DATE	BY
23 Printer Pond Pines Rd. Raymond, Maine 04071 207-475-5065		DESCRIPTION		
DATE: 09-28-16		REV	DATE	BY
TOWN: Portland, Me		DESCRIPTION		
CODE: 09-28-16		REV	DATE	BY
SCALE: SSA		DESCRIPTION		
DESIGNED: SSA		REV	DATE	BY
DRAWN: SSA		DESCRIPTION		
TITLE: 1st Floor Plan		REV	DATE	BY
FILE:		DESCRIPTION		
SHEET: FPI		REV	DATE	BY

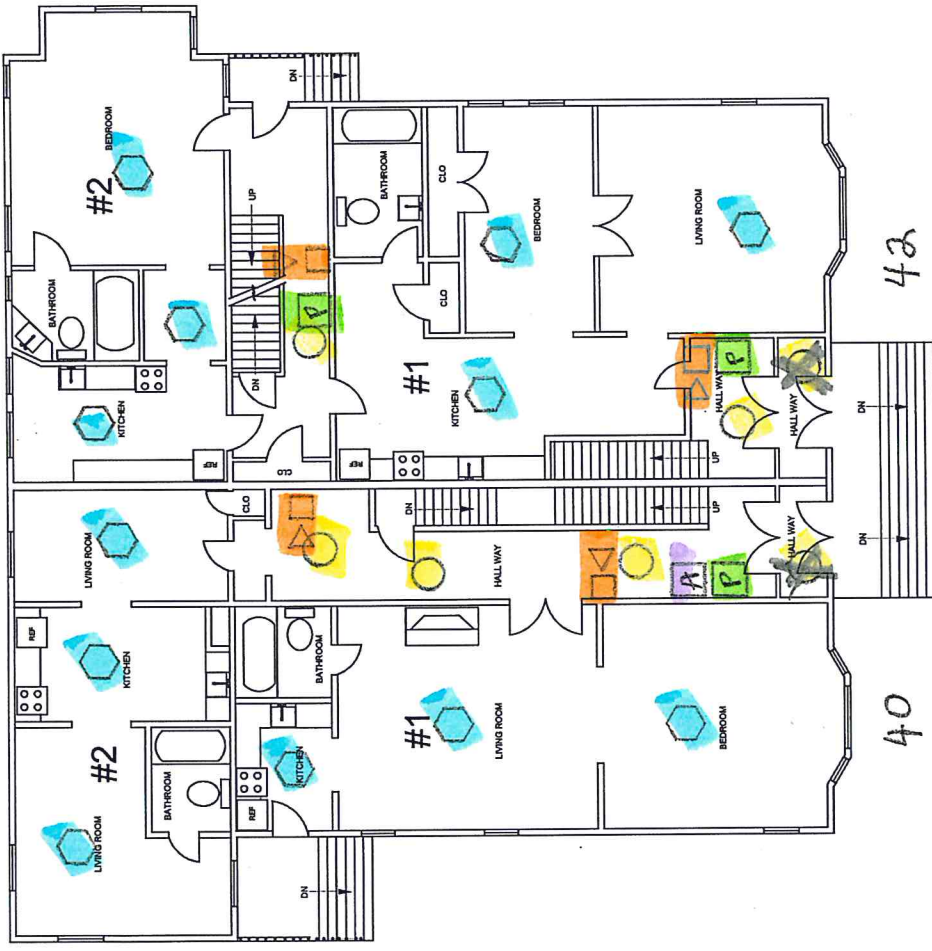

WEST STREET APARTMENTS 1ST FLOOR PLAN
SCALE: N.T.S.

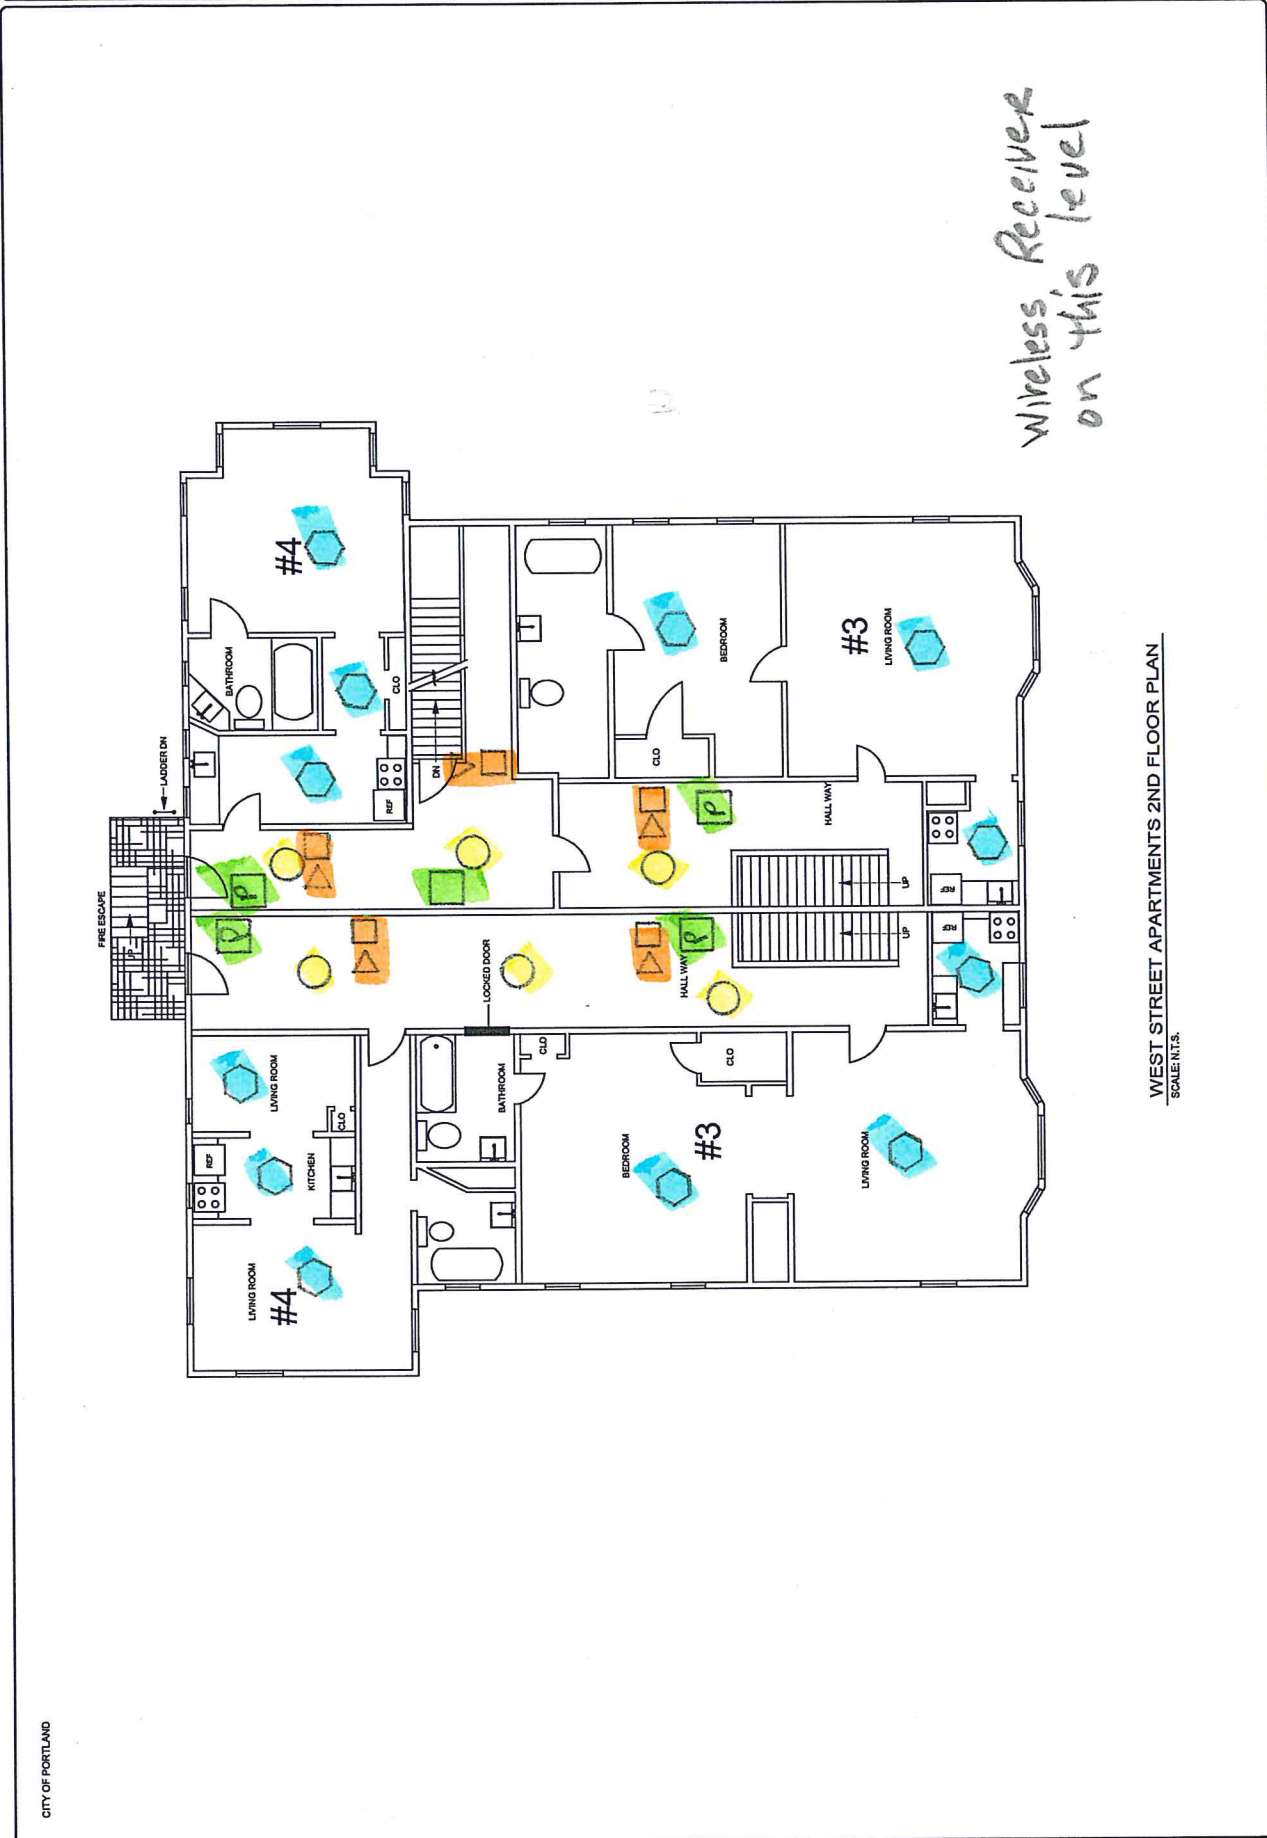

*Wireless Receiver
on this level*

WEST STREET APARTMENTS 2ND FLOOR PLAN
 SCALE: N.T.S.

DRAFTSMAN
 Stephen S. Andrews
 23 Parker Pond Drive Rd.
 Raymond, Maine 04071
 207-415-5065


WEST ST. APARTMENTS

40-42 West Street Portland, Maine

PROJECT NAME:

REV.	DESCRIPTION	BY	DATE

CODE:	TOWN:	DATE:	SCALE:	DESIGNED:	DRAWN:	TITLE:
	Portland, Me	09-20-16		SSA	SSA	3RD Floor Plan
FILE:	SHEET: FFS					

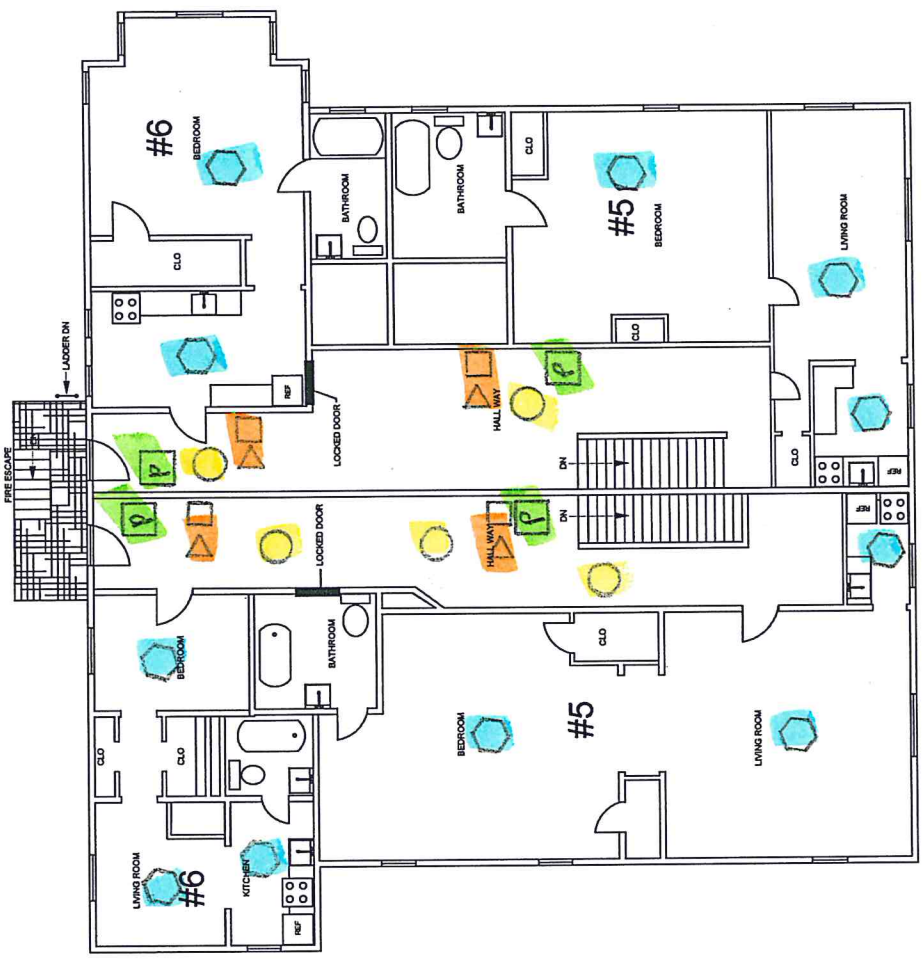

WEST STREET APARTMENTS 3RD FLOOR PLAN
 SCALE: N.T.S.