


| LIGHTING FIXTURE SCHEDULE | |
|---|---|
| A | LITHONIA #WL4-40L-EZB-LP835 5"X48" LED FIXTURE HAVING ACRYLIC DIFFUSER, WALL MOUNTED. PROVIDE WITH 4124 LUMEN, 3500 DEGREE KELVIN, 39.5W LED ARRAY, AND 120/277 V DRIVER, 0-10V DIMMABLE. EQUAL FIXTURES BY COLUMBIA SHALL BE ACCEPTED. |
| AE | SAME AS TYPE "A" BUT WITH ADDITIONAL BATTERY BACKUP EMERGENCY BALLAST. EMERGENCY BALLAST TO OPERATE ON LOSS OF AC POWER. FIXTURE SHALL OPERATE ON BATTERY FOR A MINIMUM OF 90 MINUTES AT 1400 LUMENS LIGHT OUTPUT. UNIT SHALL HAVE TEST SWITCH AND INDICATOR LIGHT. CONNECT EMERGENCY BALLAST TO UNSWITCHED LIGHTING CIRCUIT. |
| B | LITHONIA #VG03C-25LED-MVOLT-DDBT OUTDOOR LED FIXTURE, BRONZE COLOR, POLYCARBONATE LENS, DIE CAST ALUMINUM HOUSING, WALL MOUNTED. PROVIDE WITH 595 LUMEN, 3500 DEGREE KELVIN, 25W LED ARRAY, AND 120/277 V, DRIVER, PHOTOCELL. EQUAL FIXTURES BY COLUMBIA SHALL BE ACCEPTED. |
| C | LITHONIA #ASW1LED-42C-350-40K-SR3-MVOLT-DMG OUTDOOR LED AREA LIGHTING TYPE iii FIXTURE, BRONZE COLOR, DIE CAST ALUMINUM HOUSING, WALL MOUNTED. PROVIDE WITH 4000 LUMEN, 4000 DEGREE KELVIN, 49W LED ARRAY, AND 120/277 V, 350mA DRIVER, 0-10V DIMMABLE, PHOTOCELL. EQUAL FIXTURES BY COLUMBIA SHALL BE ACCEPTED. |
| X | LITHONIA #LHQM-LED-R QUANTUM SERIES EXIT SIGN. UNIT SHALL HAVE RED LIGHT EMITTING DIODES FOR ILLUMINATION WITH WHITE STENCIL AND HOUSING. CONSTRUCTION SHALL BE THERMO-PLASTIC. UNIT SHALL HAVE 90 MINUTE MINIMUM EMERGENCY OPERATION WITH 120/277V CONSTANT CURRENT BATTERY CHARGER AND MAINTENANCE FREE NI-CAD BATTERY. BATTERY SHALL DISCONNECT AUTOMATICALLY WHEN DISCHARGED BELOW 80% NOMINAL VOLTAGE. PROVIDE WITH THE NUMBER OF FACES, MOUNTING STYLE, AND DIRECTIONAL ARROWS (CHEVRONS) AS SHOWN ON PLANS. EQUAL FIXTURES BY DUAL-LITE SHALL BE ACCEPTED. |
| LIGHTING FIXTURE SCHEDULE NOTES: 1. FIXTURES SHALL BE APPROVED BY UTILITY COMPANY FOR USE IN LIGHTING REBATE PROGRAM. 2. UNLESS OTHERWISE SPECIFIED, ALL FIXTURES SHALL BE BY HUBBELL/COLUMBIA OR LITHONIA. EQUAL FIXTURE APPROVAL SHALL BE AS JUDGED BY ENGINEER. 3. PROVIDE FIXTURES WITH HARDWARE SUITABLE FOR INSTALLATION ON GYP. BOARD, STRUCTURAL, OR SUSPENDED CEILINGS. SEE ARCHITECTURAL PLANS. 4. PROVIDE A DISCONNECTING MEANS FOR ALL BALLAST SUPPLY CONDUCTORS, INTEGRAL TO EACH FIXTURE. INSTALLATION SHALL MEET THE REQUIREMENTS OF NEC ARTICLE 410.73. 5. ALL FIXTURES ARE SPECIFIED WITH 0-10V DIMMING FOR FUTURE USE. | |

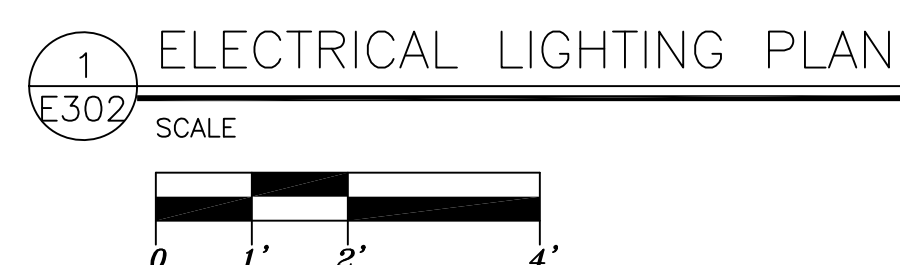

**CONSTRUCTION DOCUMENT
SUBMISSION (BID SET)**

AMES & WHITAKER Architects
 MEMBERS OF THE AMERICAN INSTITUTE OF ARCHITECTS
 31 Liberty Street, Suite 208 Southington, Connecticut 06489 (860) 621-8944 Fax (860) 621-0957

CPS ENGINEERING, INC.
 MECHANICAL AND ELECTRICAL ENGINEERS
 90 NATIONAL DRIVE, GLASTONBURY, CT 06033
 Tel. 860-657-8118 Fax 860-657-8999

2015.01.083

REVISIONS / AUTHORIZATIONS

| NO. | REVISIONS / AUTHORIZATIONS | DATE |
|-----|----------------------------|----------|
| | BID SET | 08/30/17 |
| | | |
| | | |
| | | |
| | | |
| | | |

PROPRIETARY AT&T INFORMATION
 NOT FOR GENERAL USE OR DISCLOSURE OUTSIDE OF AT&T
 THIS INFORMATION MAY ONLY BE USED BY AUTHORIZED
 PERSONNEL OF THE LOCAL GOVERNMENT AGENCY IN CONNECTION
 WITH APPLICATION FOR PERMITS AND AUTHORIZATIONS FOR
 BUILDINGS, CONSTRUCTION, AND/ OR ZONING CHANGES.

DRAWINGS PREPARED FOR
AT&T CORPORATE REAL ESTATE

PROJECT TITLE:
TELECOMMUNICATIONS HUT
 UNION STATION PLAZA
 240-280 SAINT JOHN ST
 PORTLAND

PTLFME01 Archoid AAB7WI

SHEET TITLE:
ELECTRICAL LIGHTING PLAN

| | | |
|---------------------------------------|----------------------------|--------------------------|
| AT&T PROJECT NUMBER: E15823 | DATE: 08/30/2017 | SCALE: AS NOTED |
| AT&T AUTHORIZATION: | DRAWN BY: JAP | CHECKED BY: SJM |
| GREGG MIRANDO | SHEET: 7 | OF: 15 SHEETS |
| | AT&T DRAWING NO.: | SHEET NO. E302 |