


REVISIONS		
#	DATE	DESCRIPTION
1	4.03.07	CONTRACT ZONE SUBMISSION
2	5.01.07	CONTRACT ZONE SUBMISSION
3	7.10.07	CONTRACT ZONE SUBMISSION
4	9.04.07	SITE PLAN AND SUBDIVISION REVIEW
5	10.02.07	FINAL SITE PLAN REVIEW
6	11.15.07	50% MAINE HOUSING REVIEW SET
7	12.04.07	50% MAINE HOUSING REVIEW SET
8	05.02.08	50% MAINE HOUSING REVIEW SET
9	07.31.08	100% MAINE HOUSING REVIEW SET
10	09.02.08	100% BID DOCUMENTS


DATE:	09/02/08
PROJECT #	100405
DRAWN BY:	JMV
CHECKED BY:	SPD
DRAWING SCALE	AS NOTED

SHEET TITLE  
MECHANICAL DETAILS


M303

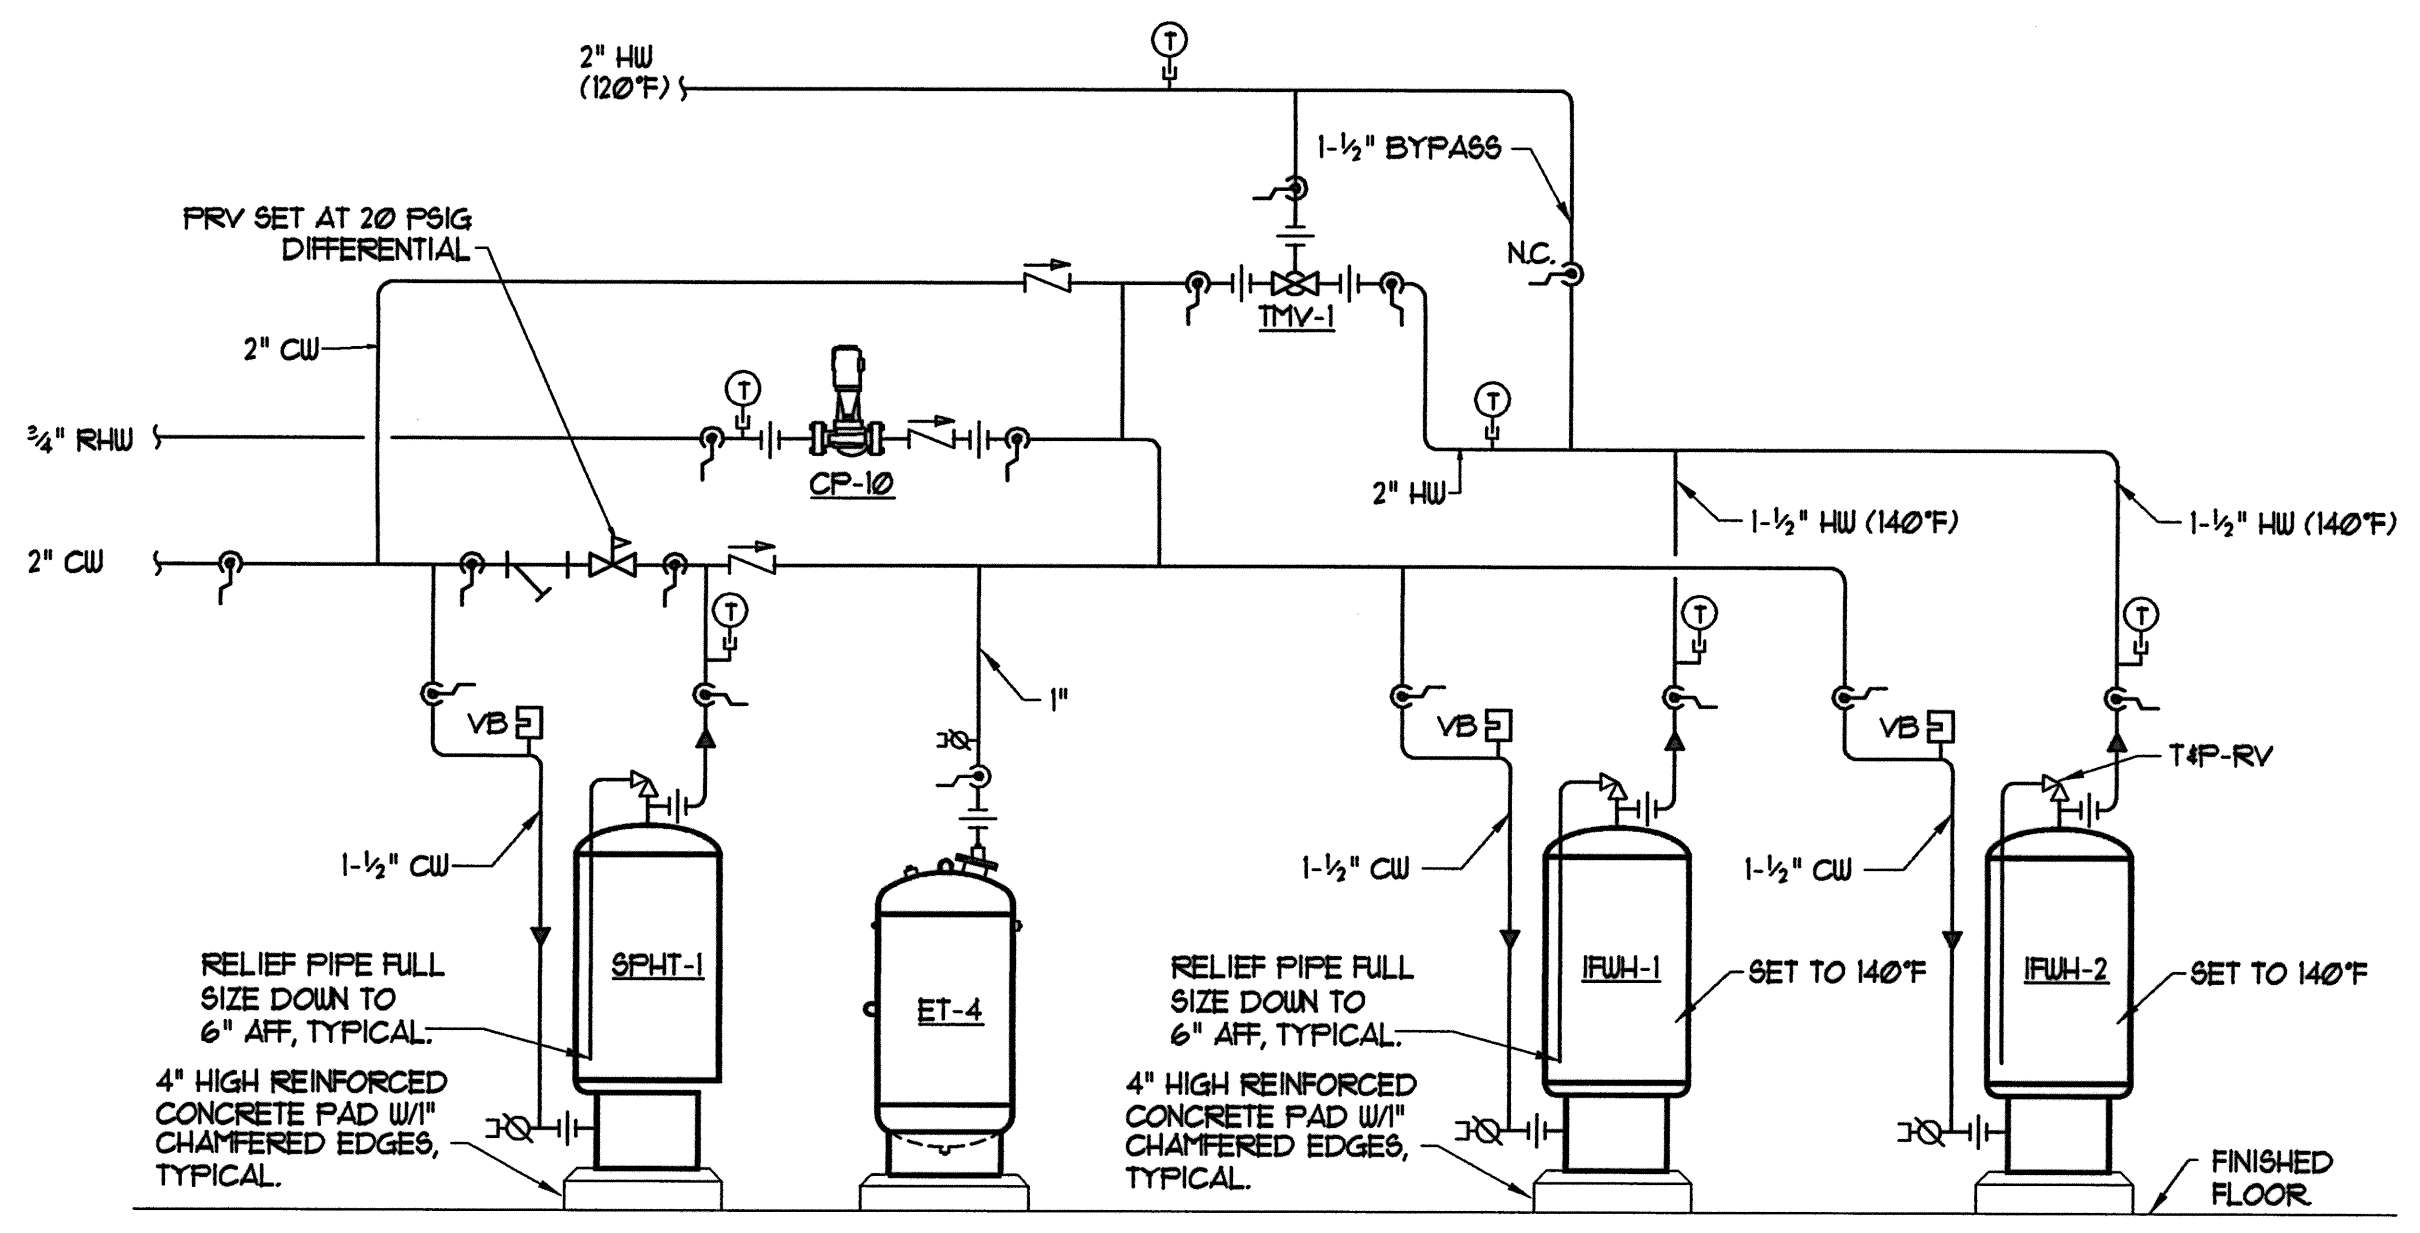


**DOMESTIC HOT WATER PIPING SCHEMATIC**  
NTS

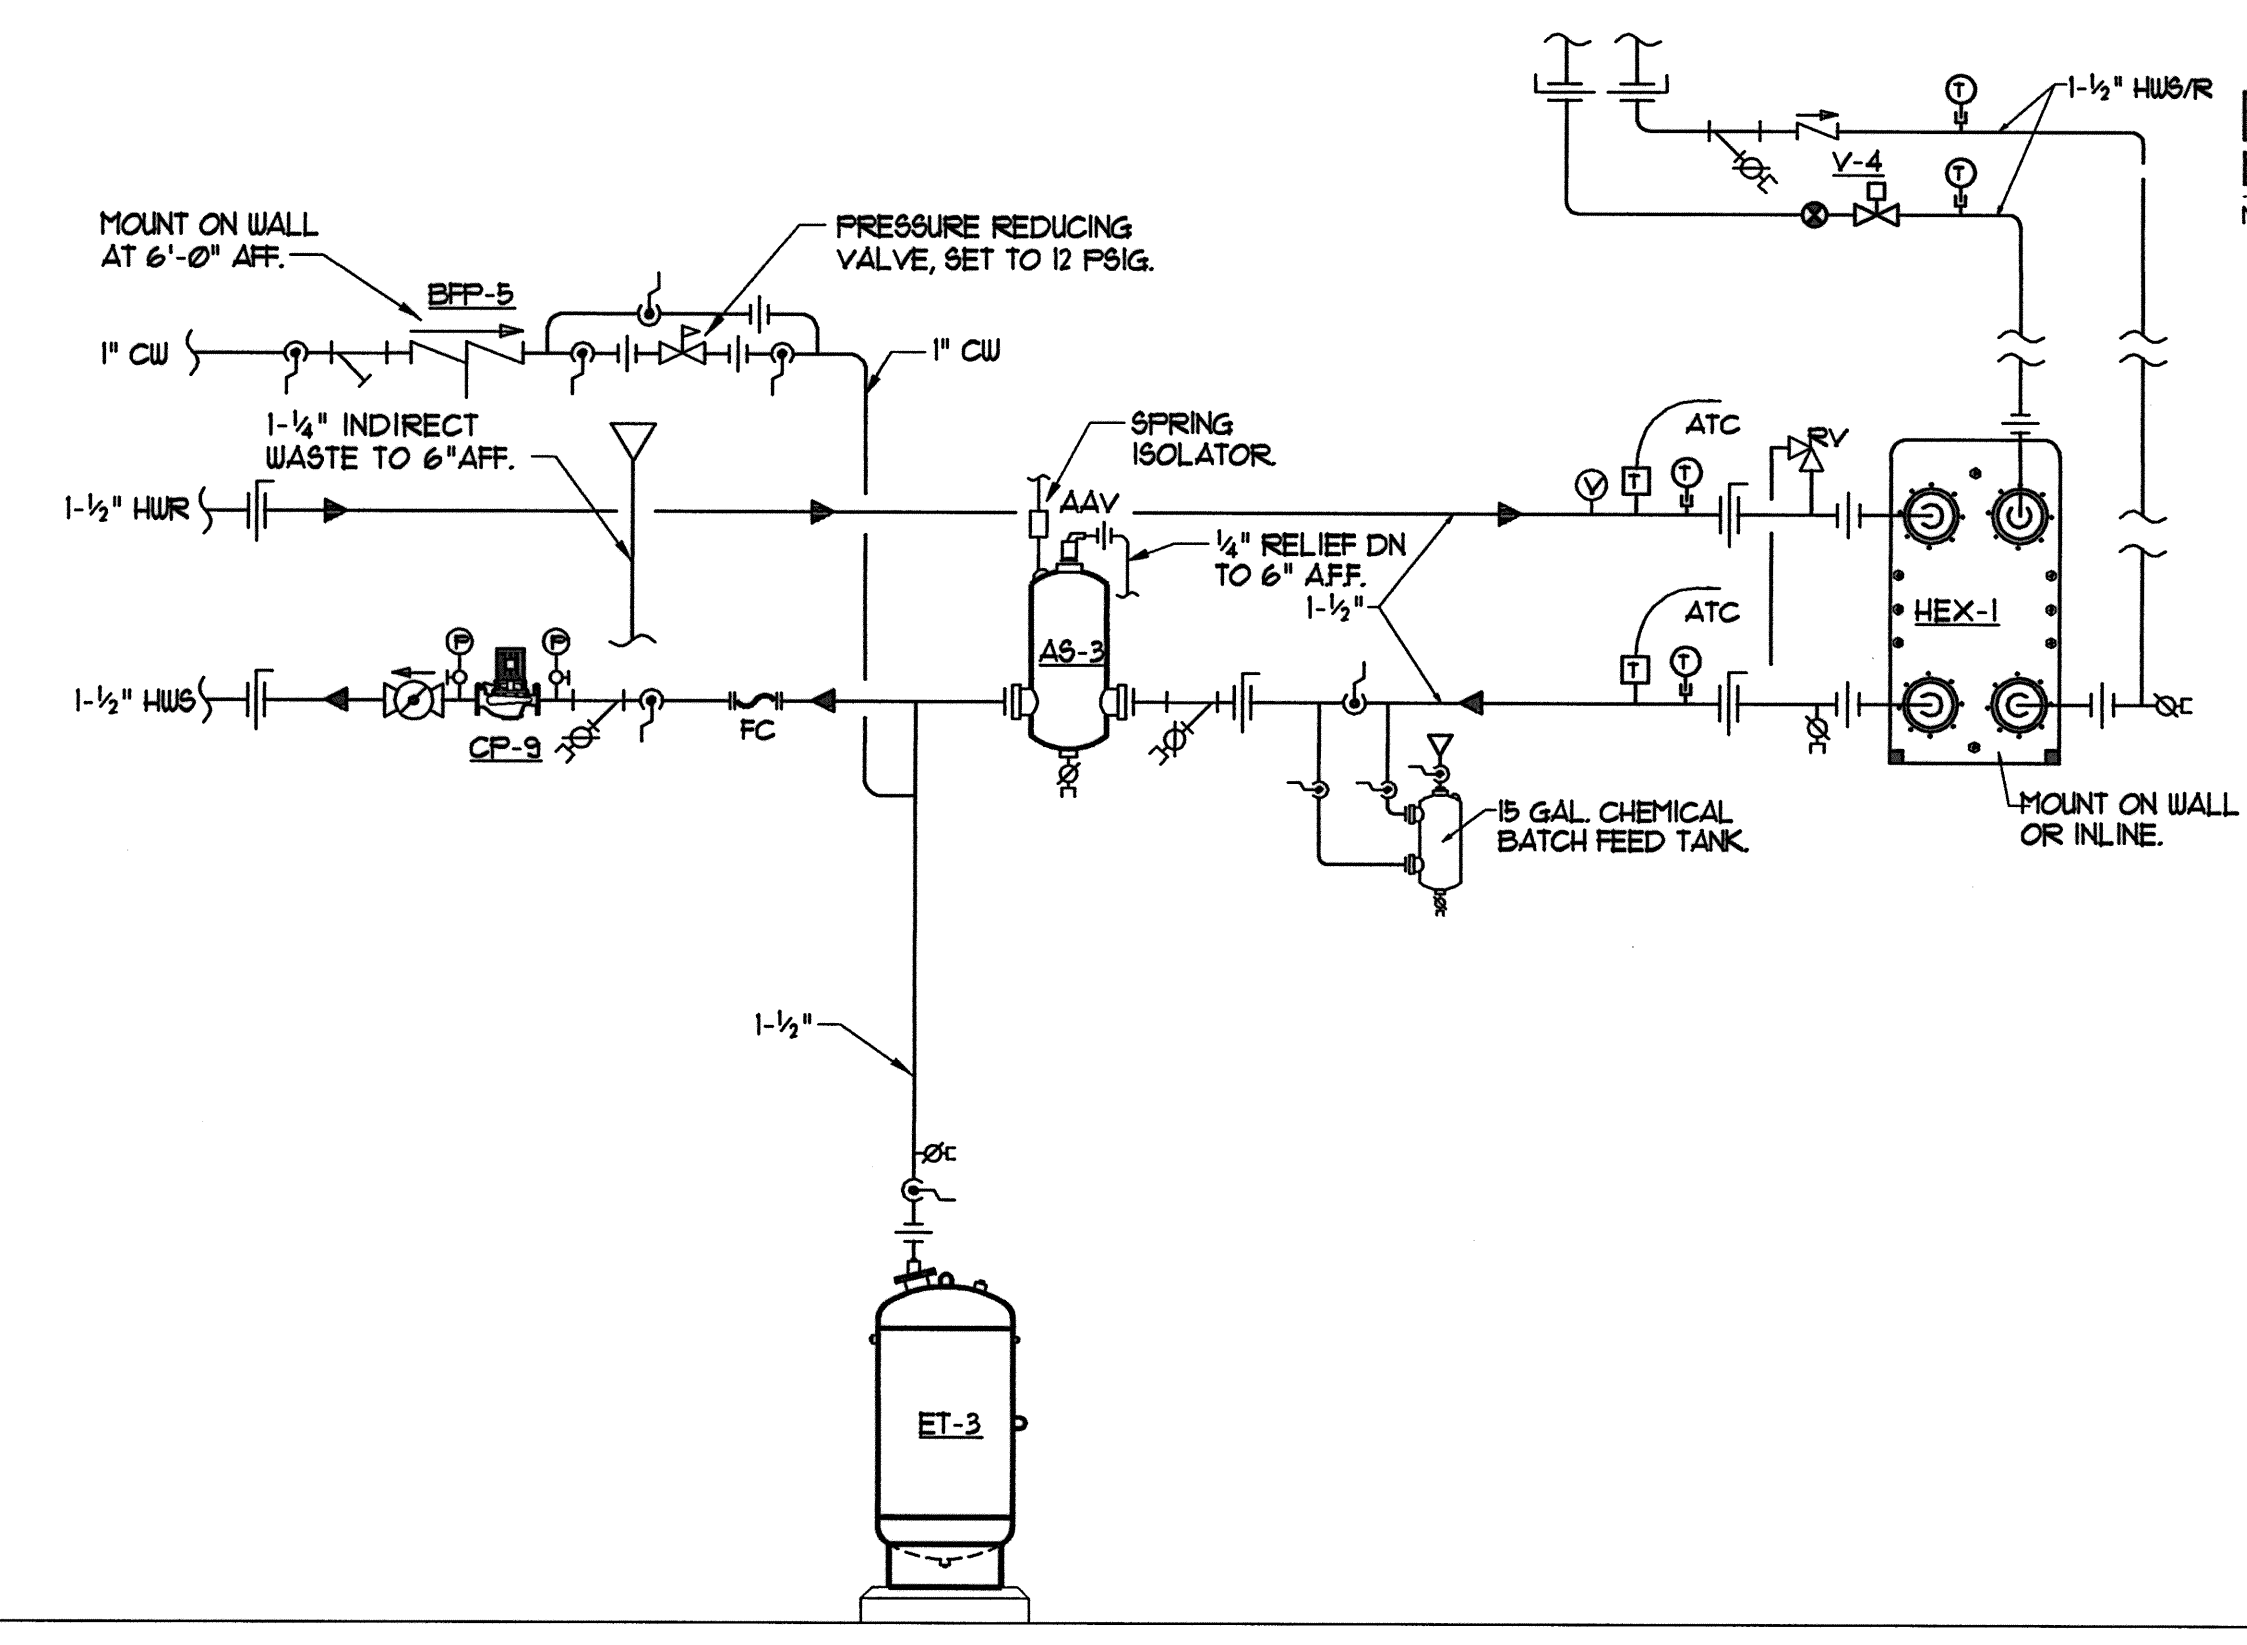

**HEAT EXCHAGER PIPING SCHEMATIC**  
NTS

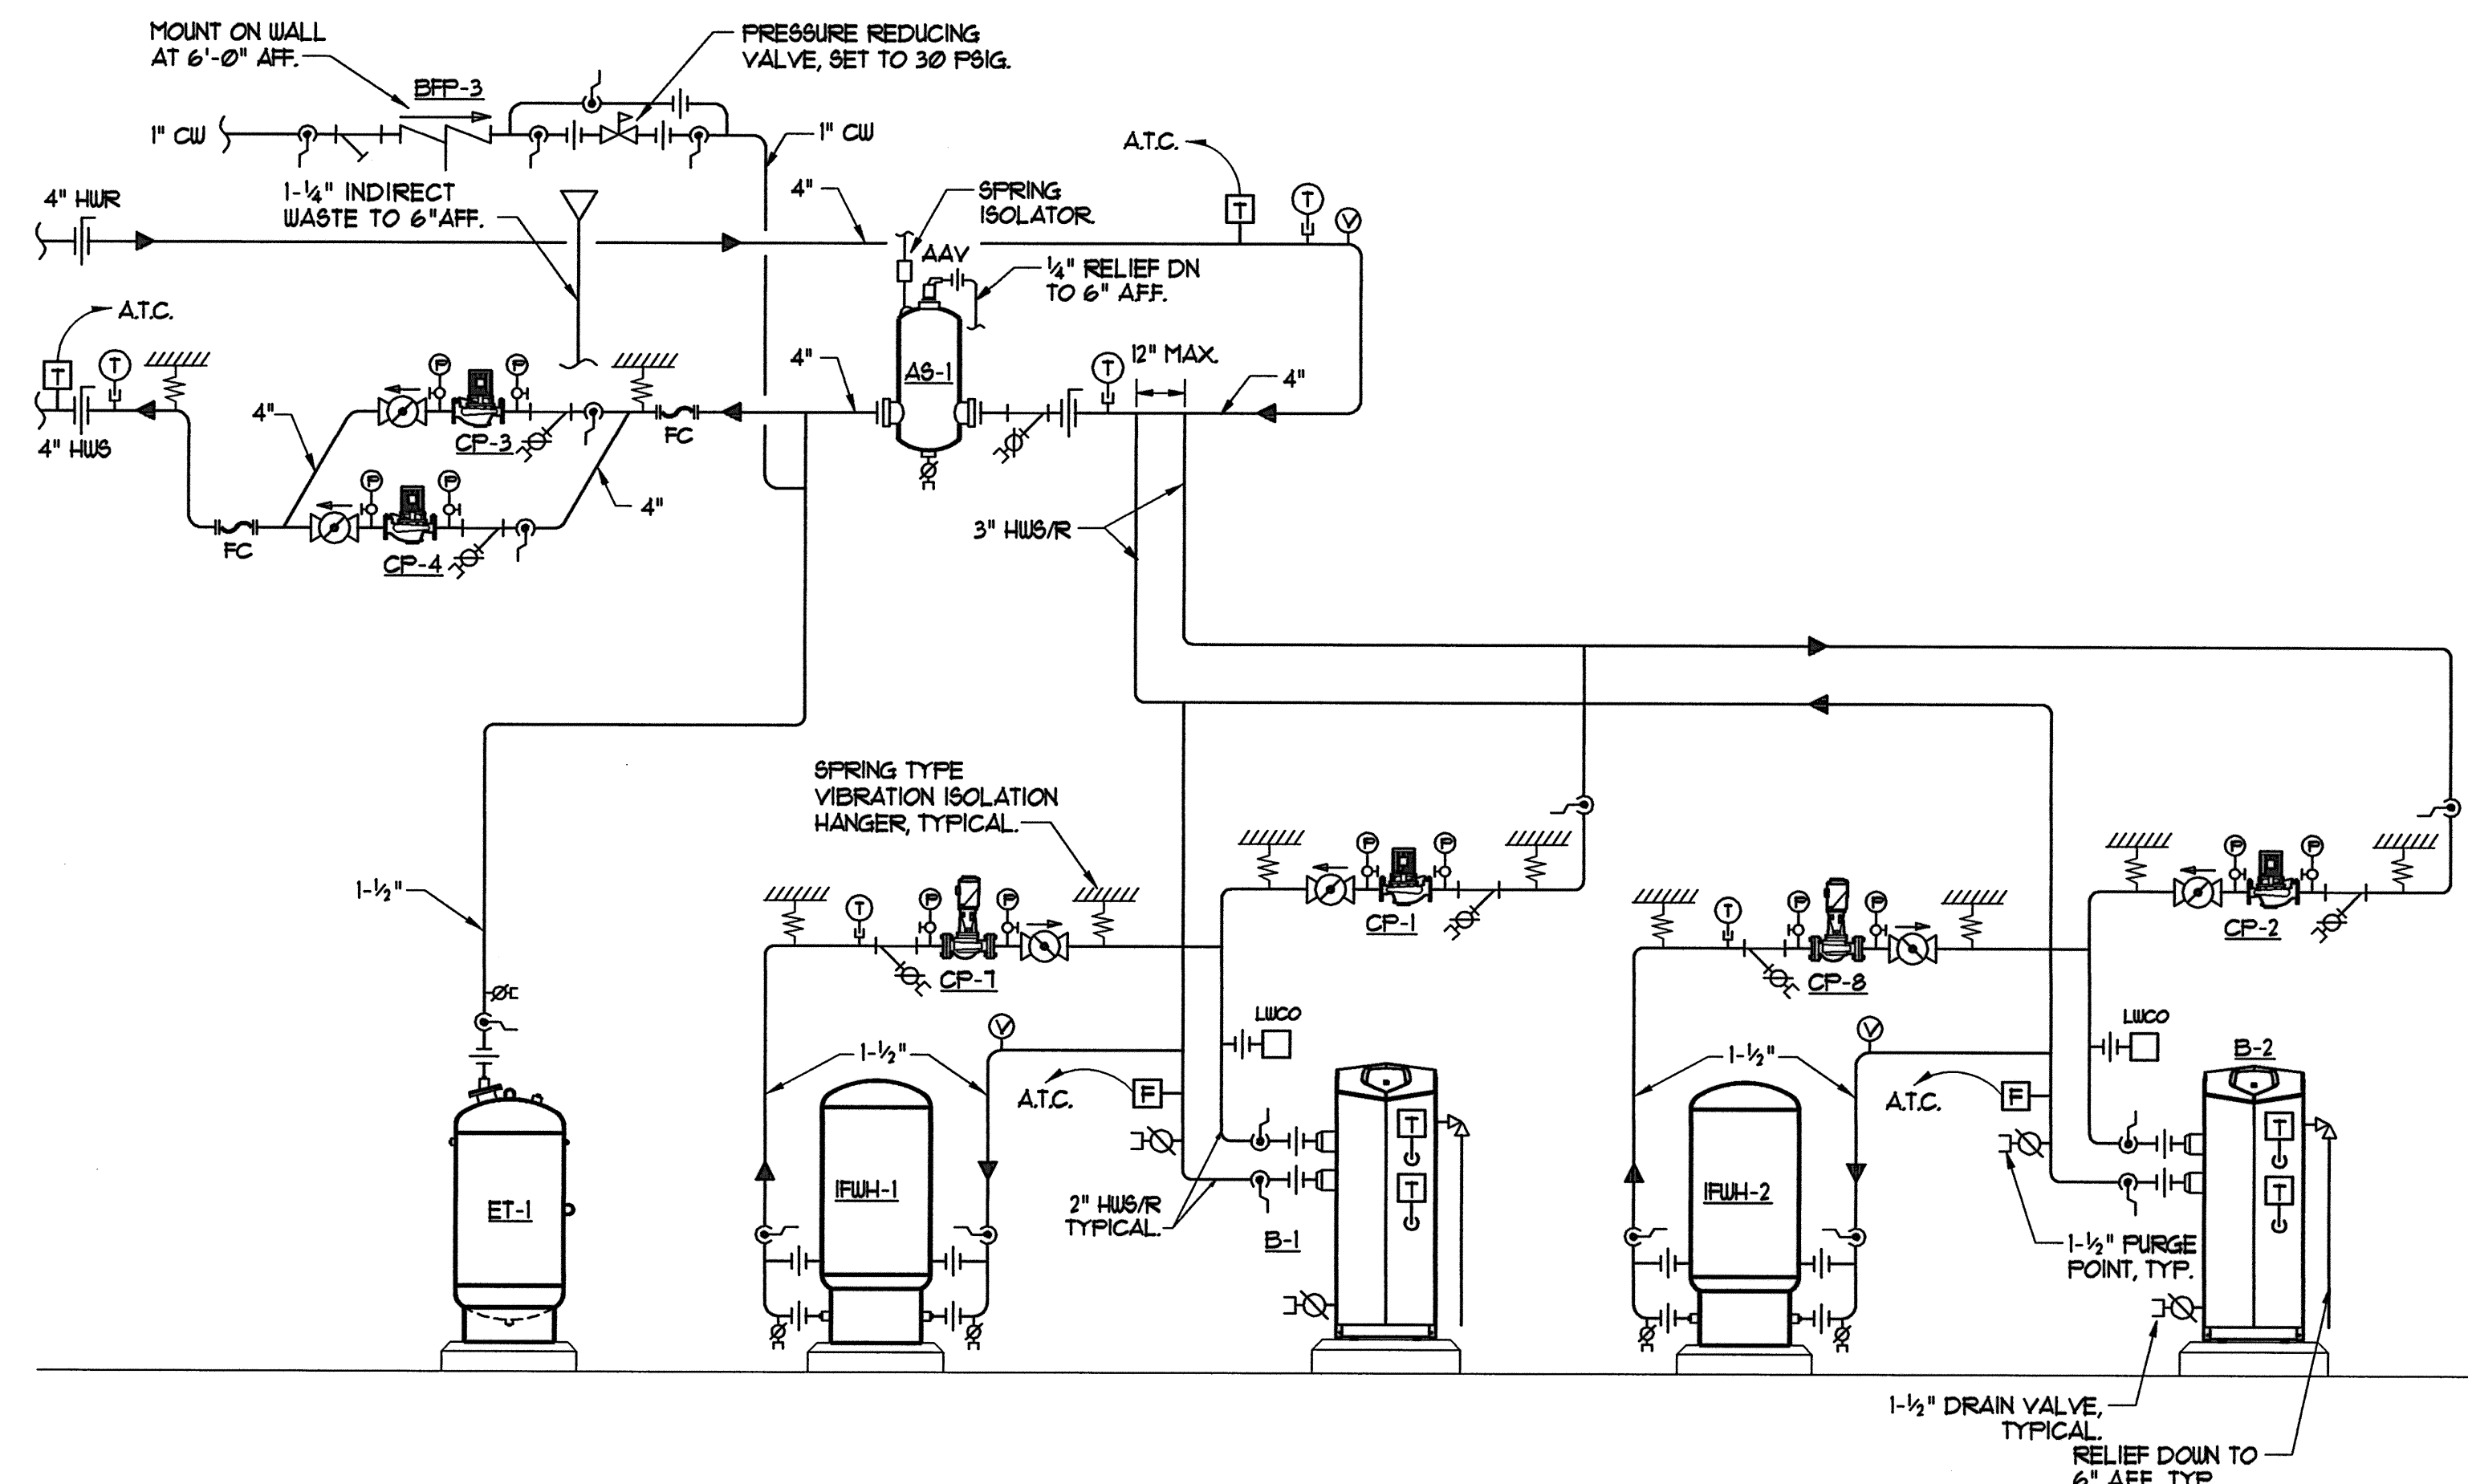

**BOILER PIPING SCHEMATIC**  
NTS

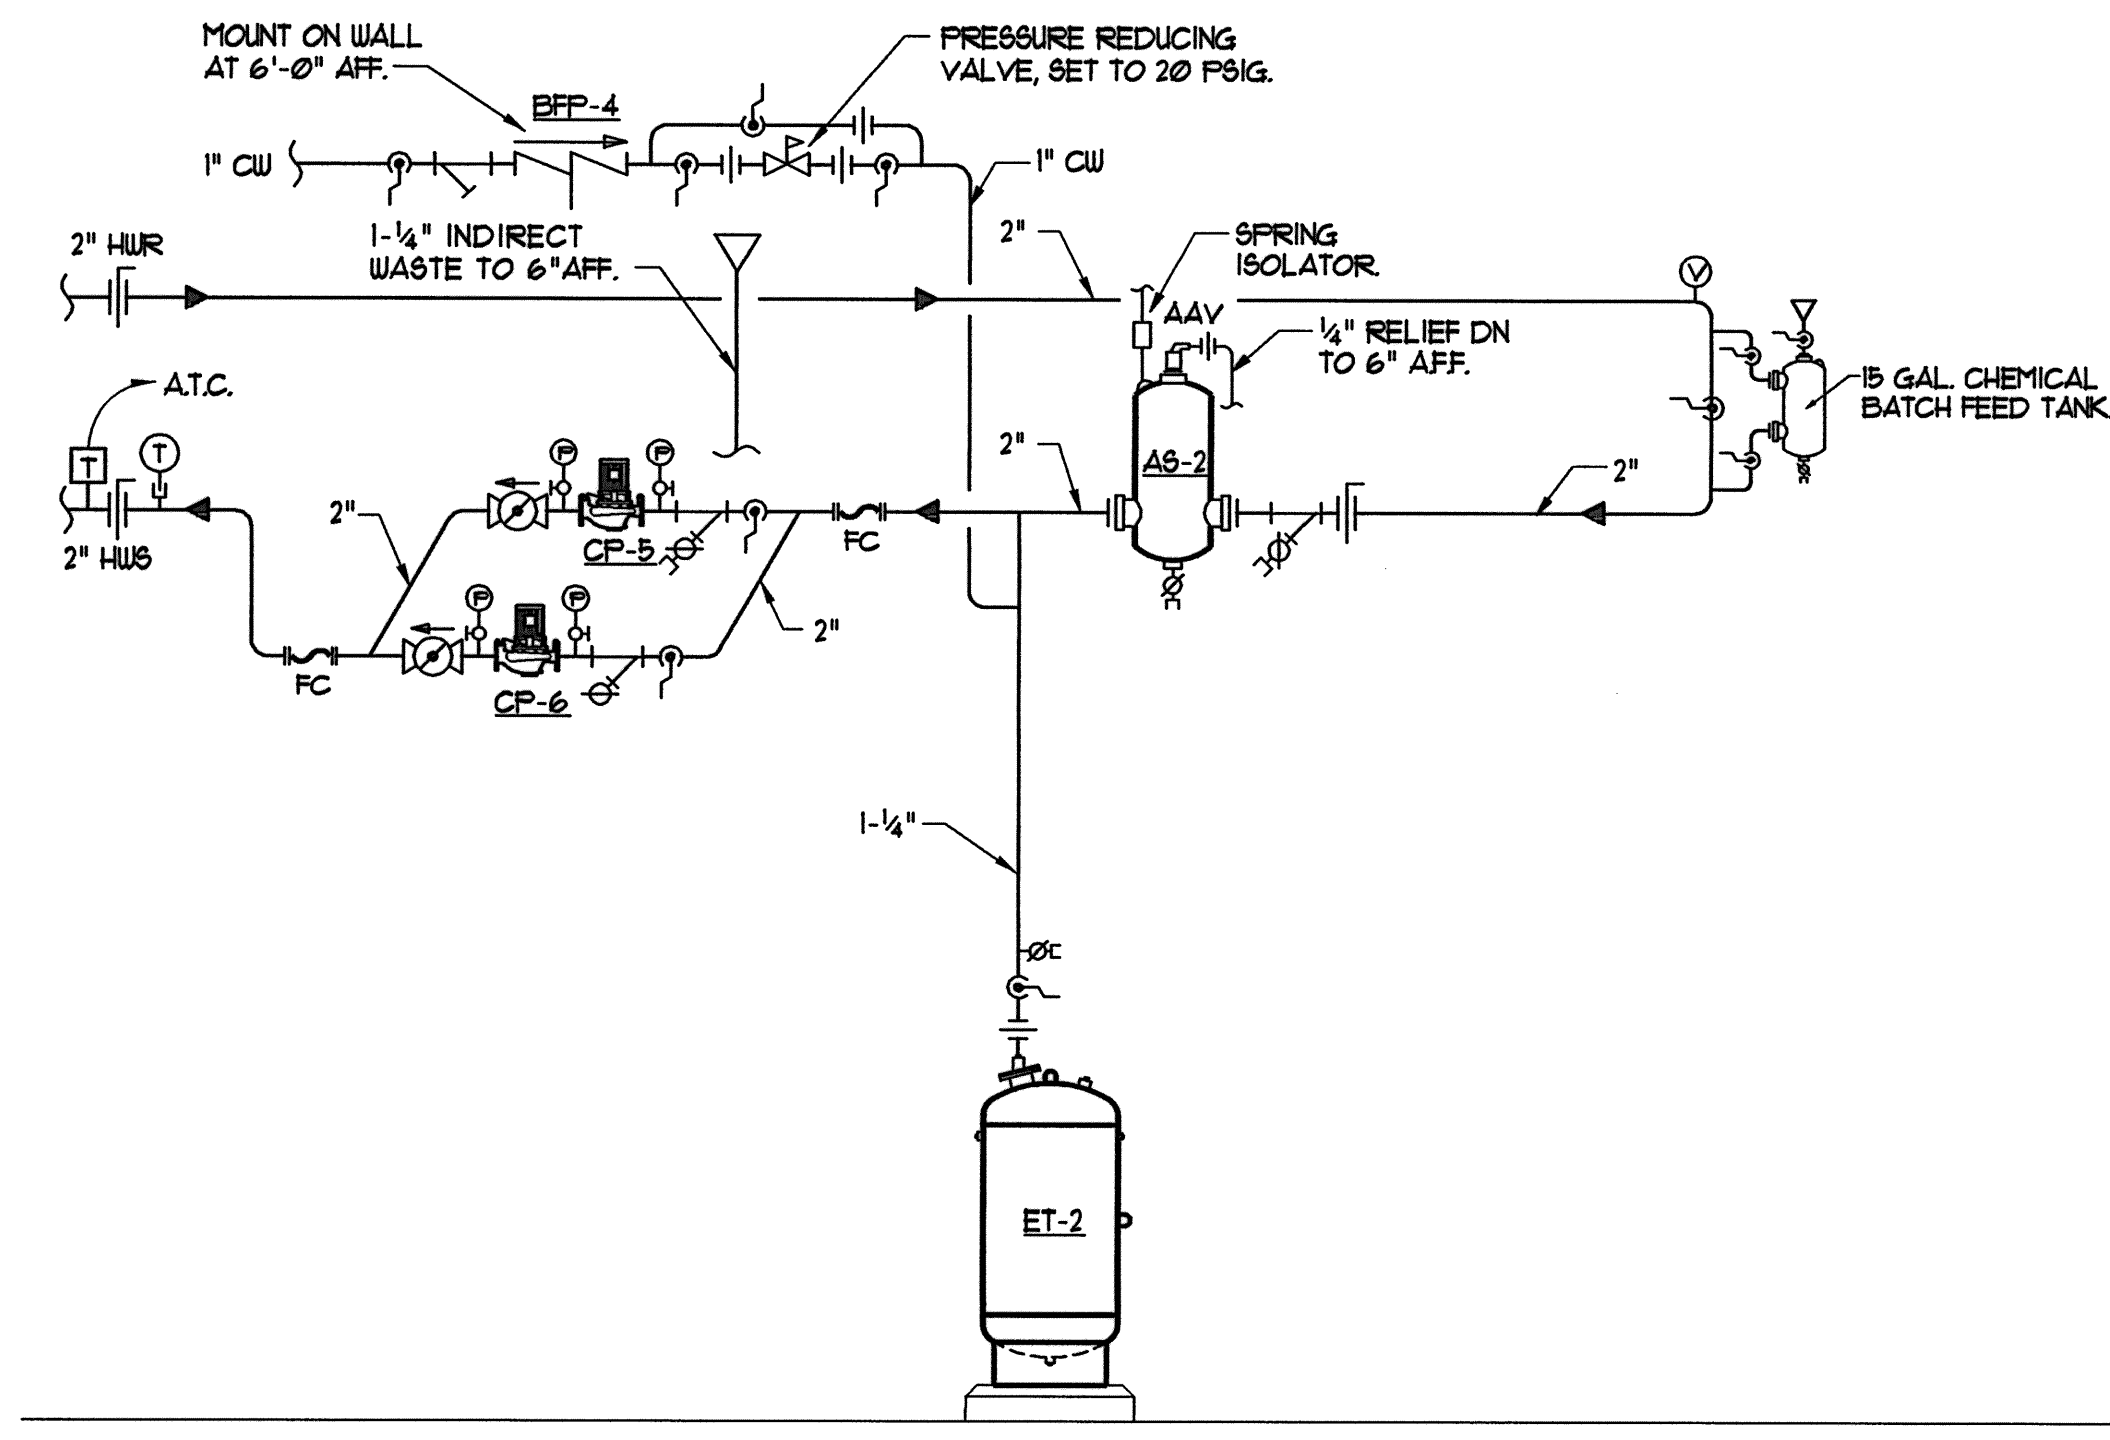

**GROUND SOURCE HEAT PUMP PUMPING SCHEMATIC**  
NTS