


VALLEY STREET

EXTERIOR ELECTRICAL PLAN
SCALE: 1"=10'-0"

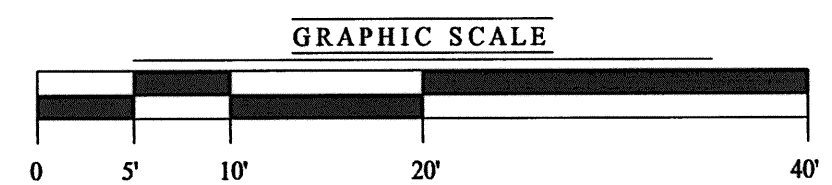

#	DATE	DESCRIPTION
1	4.03.07	CONTRACT ZONE SUBMISSION
2	5.01.07	CONTRACT ZONE SUBMISSION
3	7.10.07	CONTRACT ZONE SUBMISSION
4	9.04.07	SITE PLAN AND SUBDIVISION REVIEW
5	10.02.07	FINAL SITE PLAN REVIEW
6	11.15.07	50% REVIEW SET
7	12.04.07	50% MAINE HOUSING REVIEW SET
8	05.02.08	80% MAINE HOUSING REVIEW SET
9	07.31.08	100% MAINE HOUSING REVIEW SET
10	09.02.08	100% BID DOCUMENTS

DATE:	09/02/08
PROJECT #	100405
DRAWN BY:	SPD
CHECKED BY:	WSBJR
DRAWING SCALE	AS NOTED

SHEET TITLE
EXTERIOR ELECTRICAL PLAN

E 100

LIGHTING FIXTURE SCHEDULE			
TYPE	DESCRIPTION	LAMPS QUANTITY & TYPE	REMARKS
AA	KIM •1A/STS4-175MH208-xx-HS	(1) 175W MH	MOUNTED @ 18' AFG - W/ HOUSE SIDE SHIELD
BB	KIM •1A/STS3-175MH208-xx-WM-HS, 1W/AR3 SURFACE WALL ASSEMBLY	(1) 175W MH	WALL MOUNTED - W/ HOUSE SIDE SHIELD
CC	KIM •1A/STS3-175MH208-xx	(1) 175W MH	MOUNTED @ 15' AFG
DD	COLUMBIA •SLA-8-1-32-SLBI-2-E-U	(1) 32W T8	OUTDOOR SIGN LIGHT - REMOTE BALLAST MOUNTED IN JAN. 308