


FLORENCE HOUSE
190 VALLEY STREET
PORTLAND, MAINE

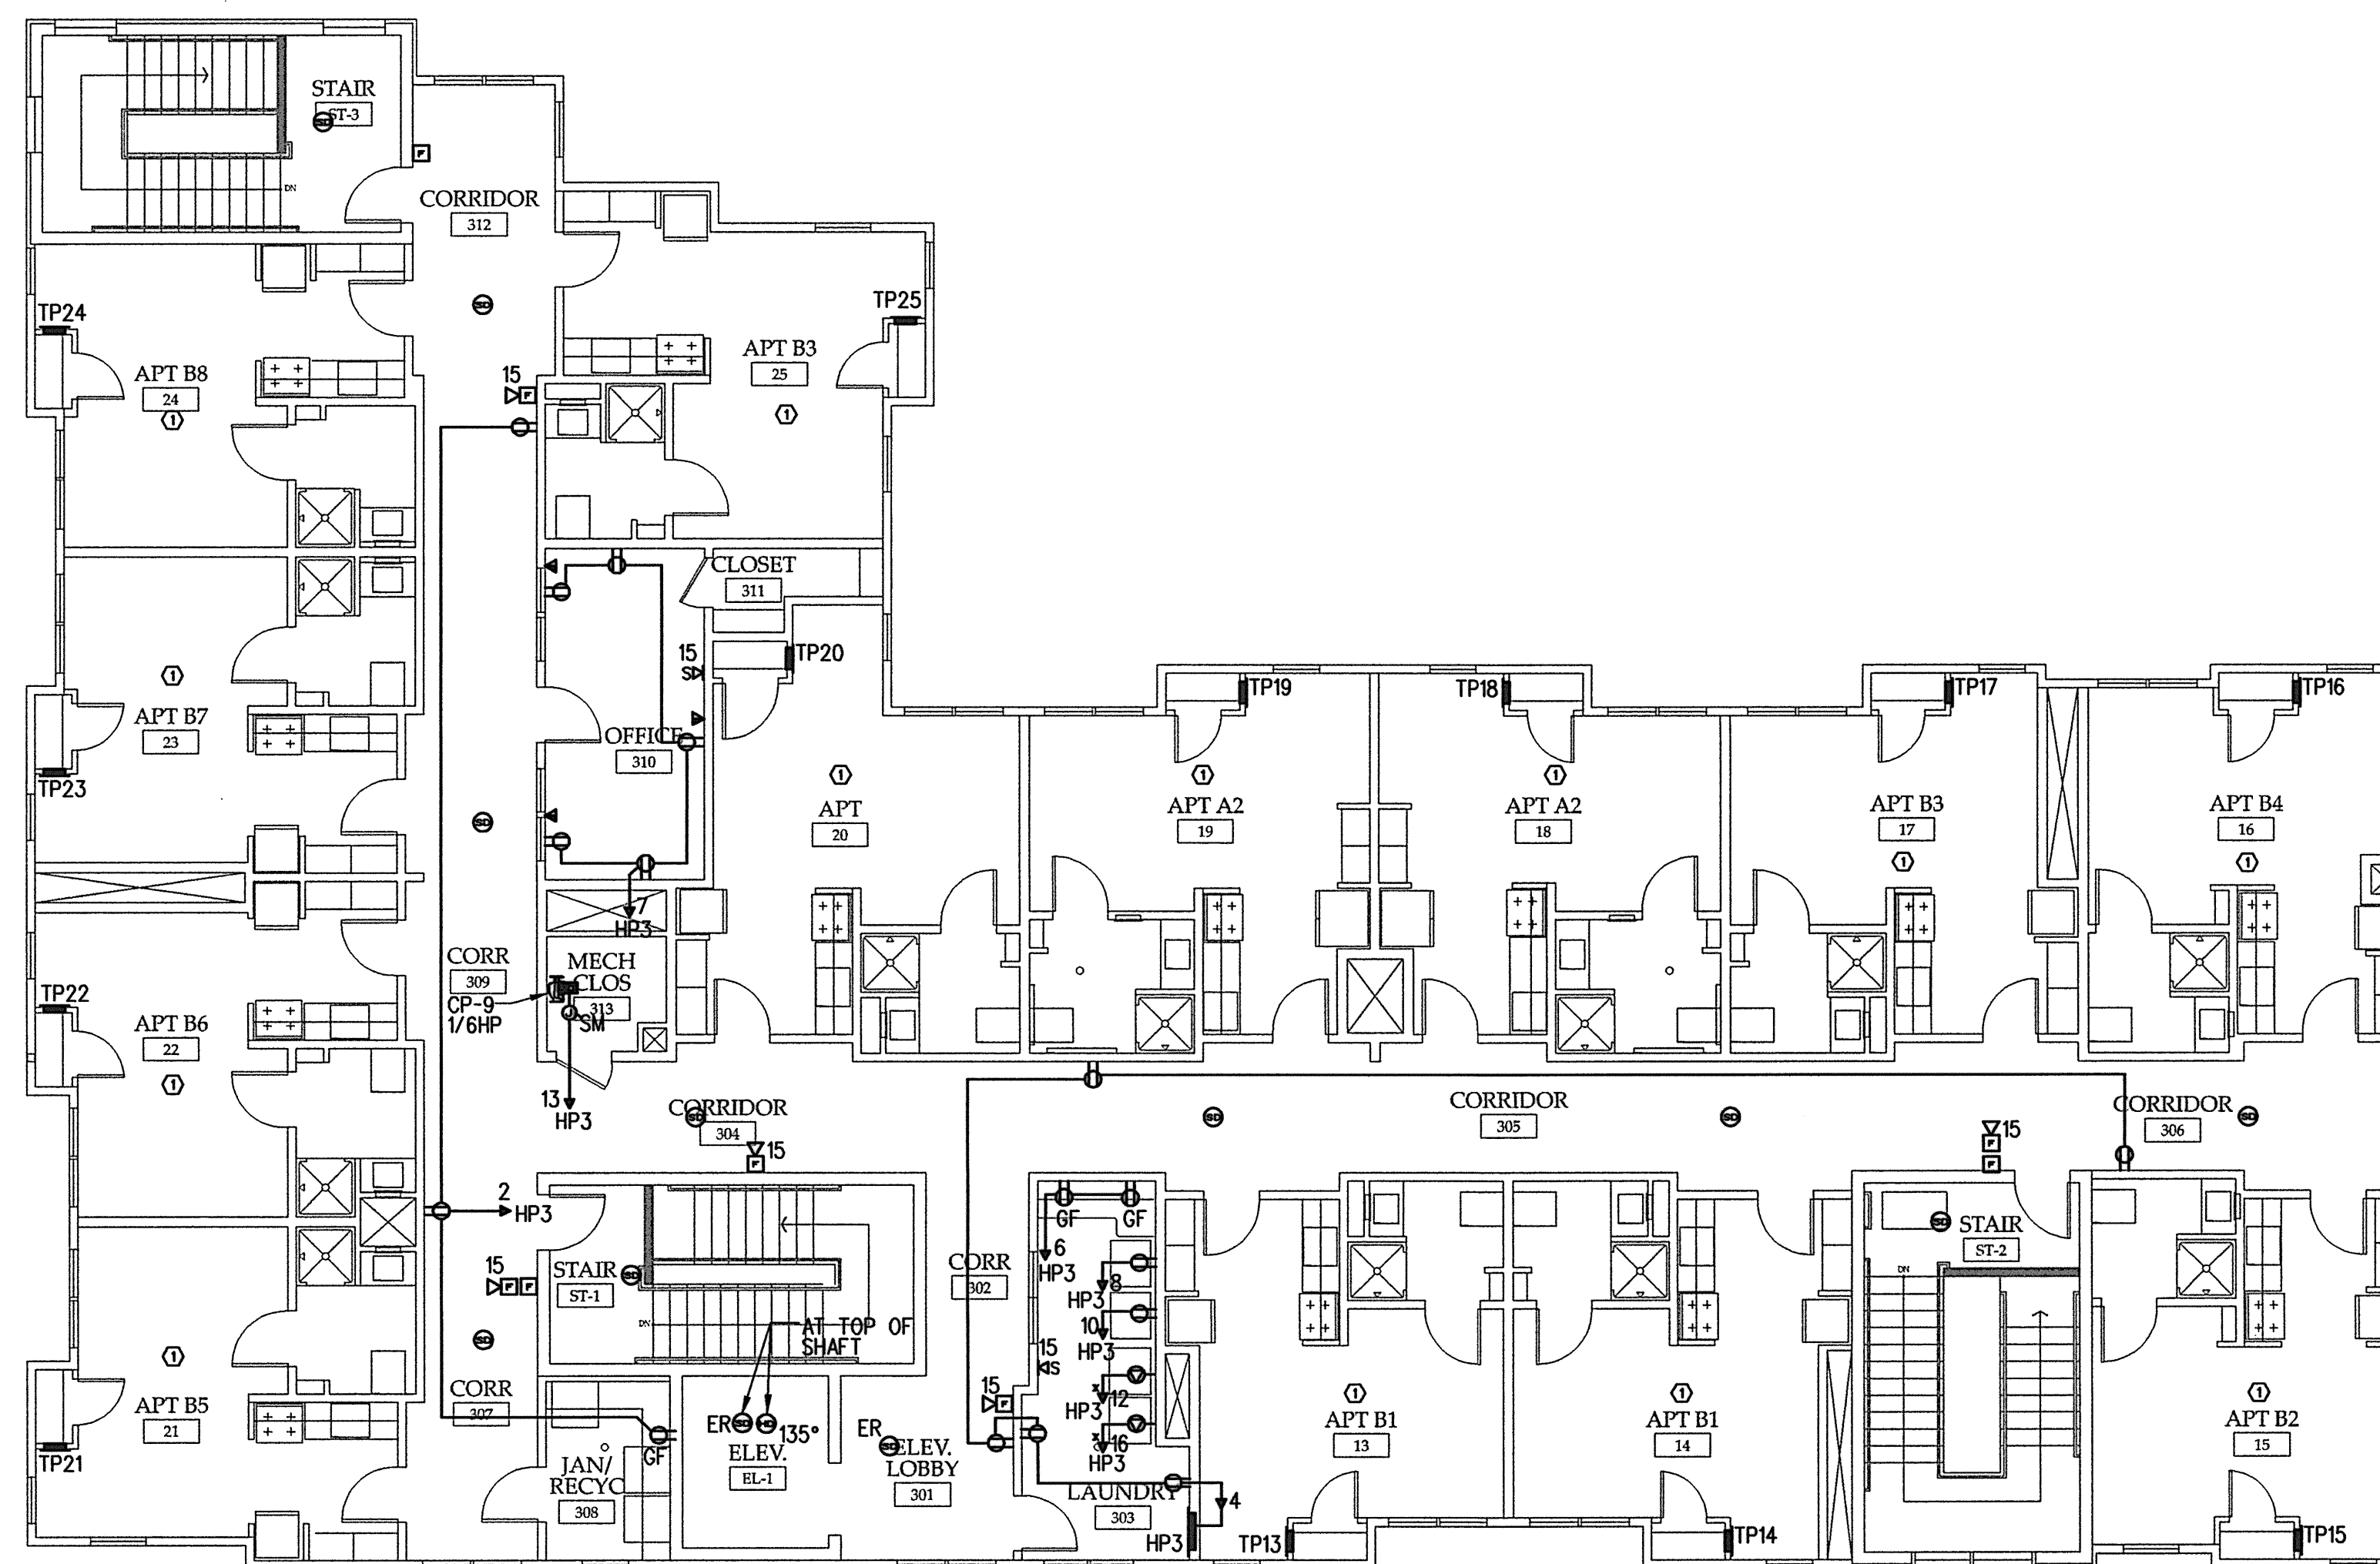

THIRD FLOOR POWER PLAN
SCALE: 1/8"=1'-0"

REVISIONS

#	DATE	DESCRIPTION
1	4.03.07	CONTRACT ZONE SUBMISSION
2	5.01.07	CONTRACT ZONE SUBMISSION
3	7.10.07	CONTRACT ZONE SUBMISSION
4	9.04.07	SITE PLAN AND SUBMISSION REVIEW
5	10.02.07	FINAL SITE PLAN REVIEW
6	11.15.07	50% REVIEW SET
7	12.04.07	50% MAINE HOUSING REVIEW SET
8	05.02.08	80% MAINE HOUSING REVIEW SET
9	07.31.08	100% MAINE HOUSING REVIEW SET
10	09.02.08	100% BID DOCUMENTS

DATE:	09/02/08
PROJECT #	100405
DRAWN BY:	SPD
CHECKED BY:	WSBJR
DRAWING SCALE	AS NOTED

SHEET TITLE

THIRD FLOOR POWER PLAN

E 303

NOTES:

- ① SEE TYPICAL UNIT ELECTRICAL PLAN ON DRAWING E 400.
- ② SEE TYPICAL ADA UNIT ELECTRICAL PLAN ON THIS DRAWING E400.