




**Gawron
Turgeon**

ARCHITECTS
29 Black Point Road
Scarborough, Maine 04074
www.gawronturgeon.com
207-863-6307 Int 207-863-0361 Fax

FLORENCE HOUSE
190 VALLEY STREET
PORTLAND, MAINE

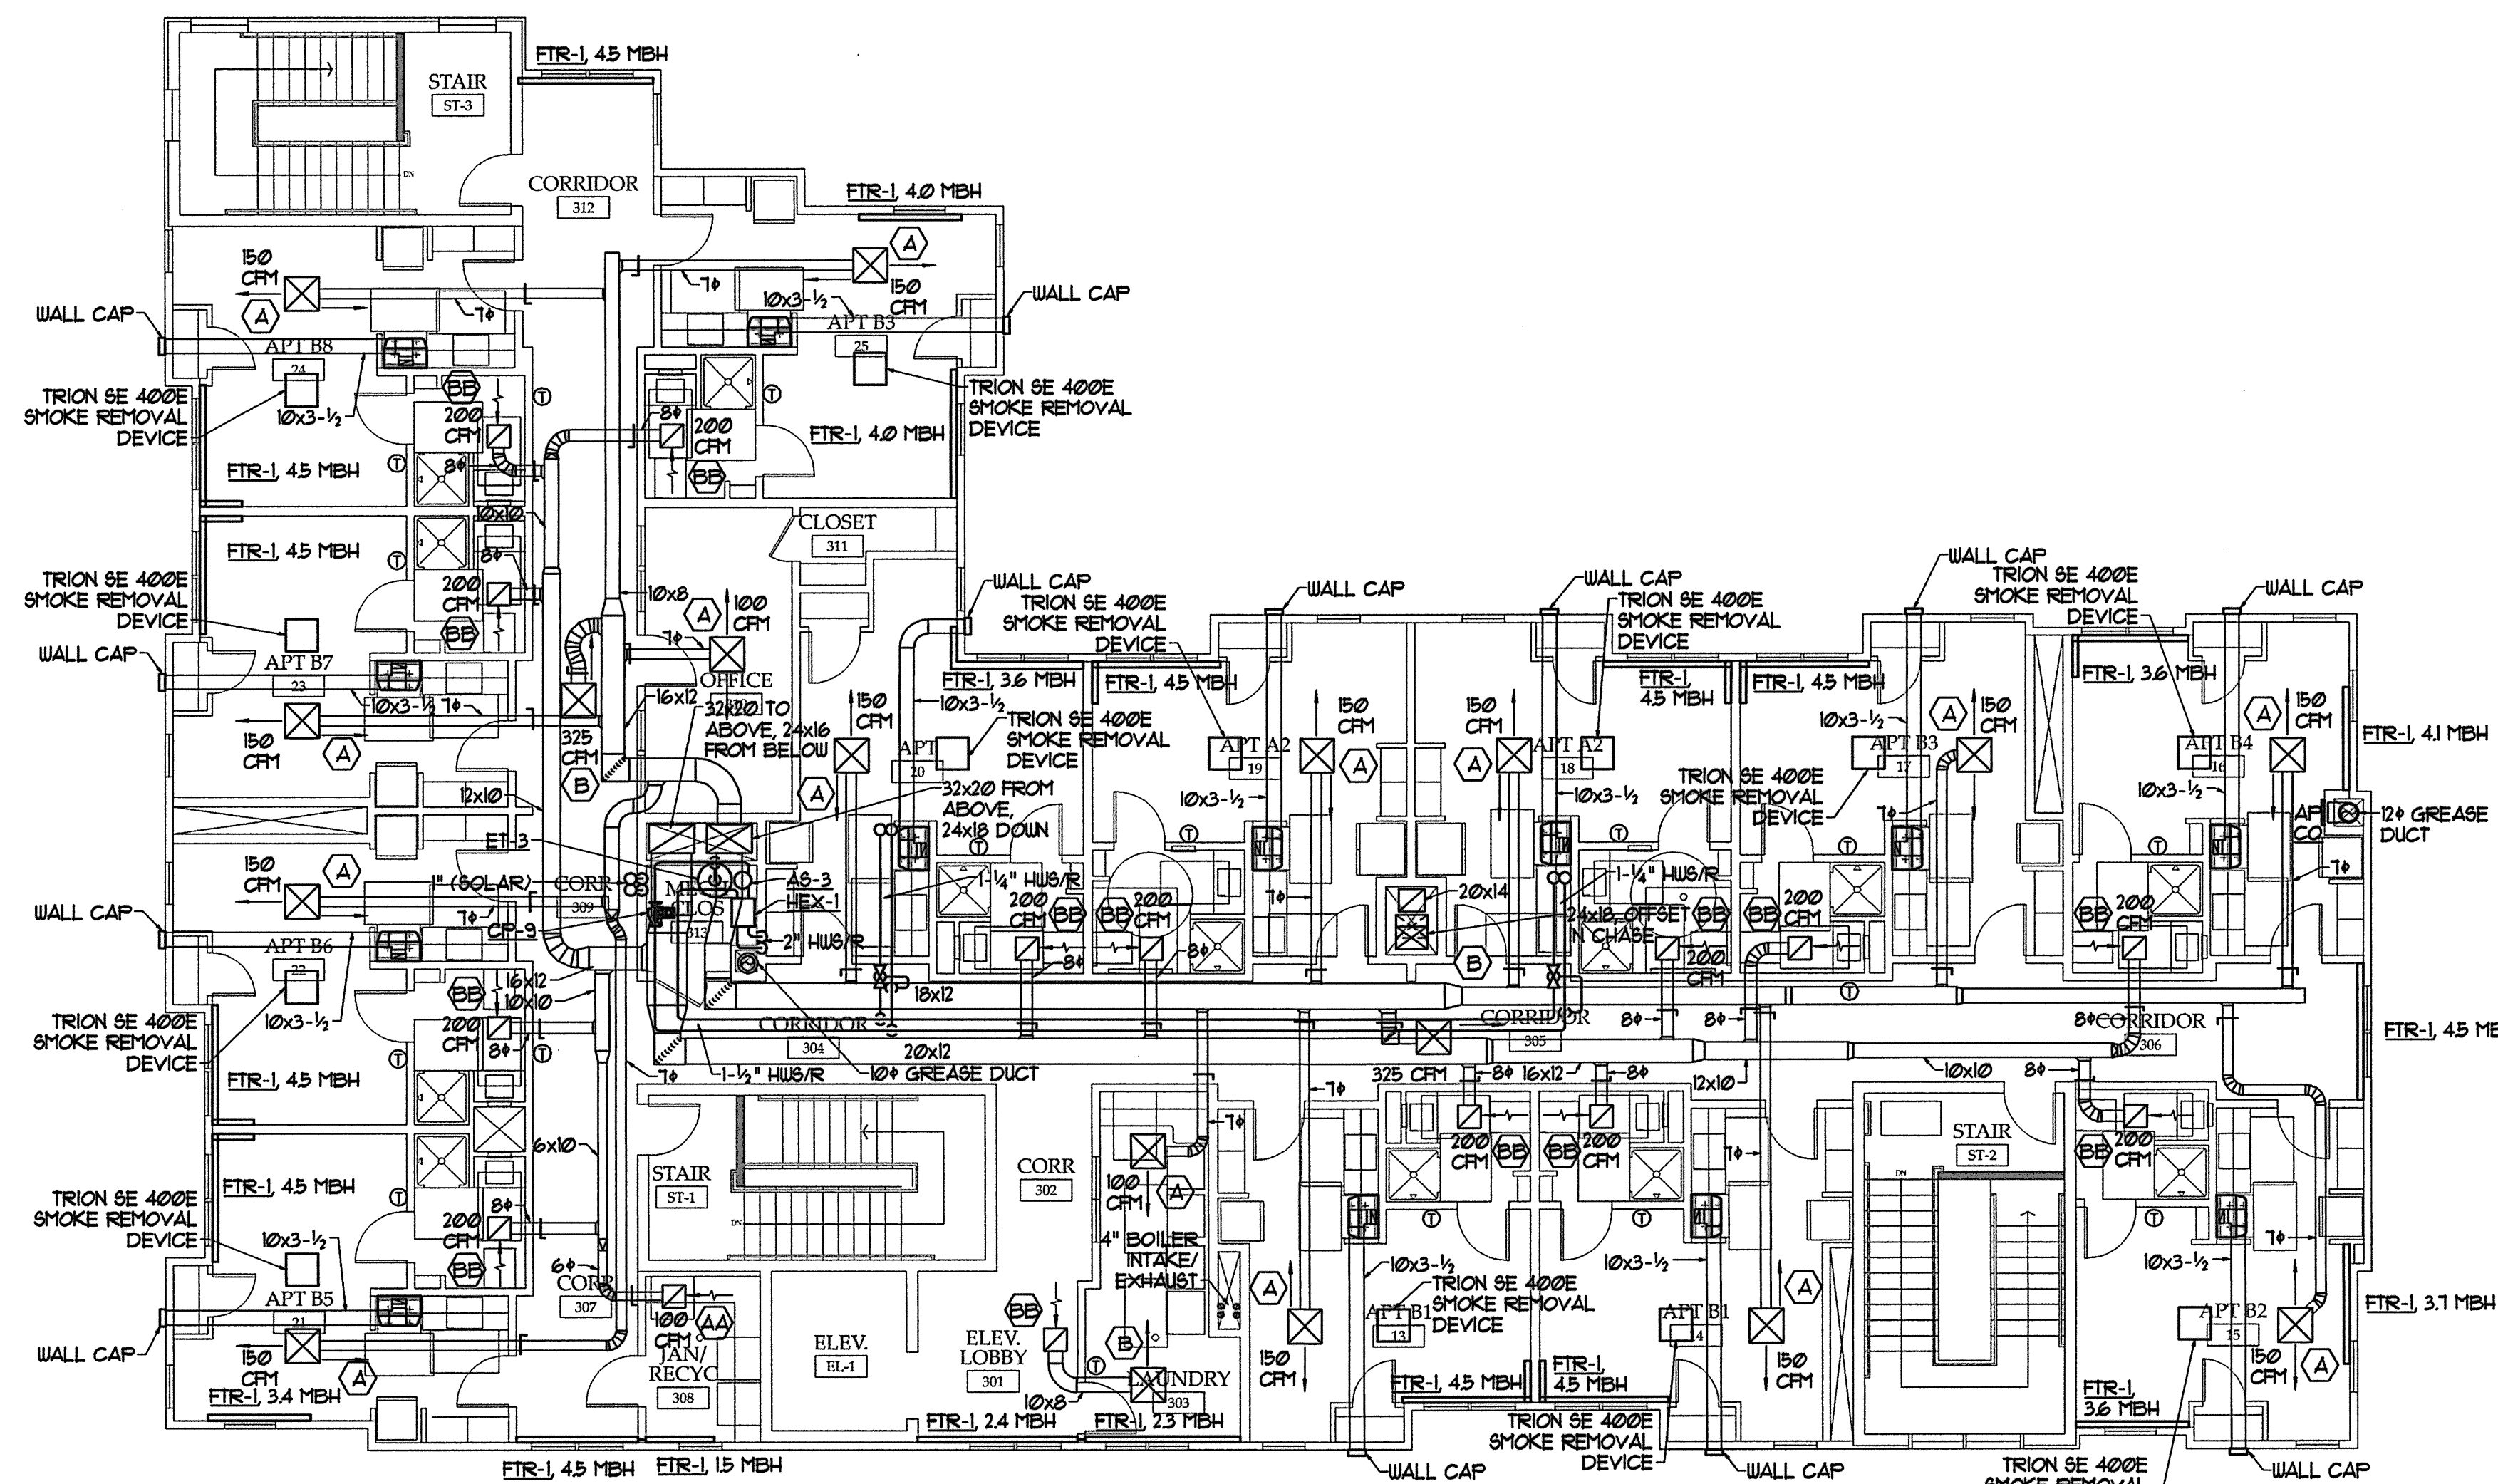

NOTE -
TRION SE 400E SMOKE REMOVAL DEVICES
SHALL BE ADD ALTERNATE #

THIRD FLOOR MECHANICAL PLAN
SCALE - 1/8" = 1'-0"

REVISIONS		
#	DATE	DESCRIPTION
1	4.03.07	CONTRACT ZONE SUBMISSION
2	5.01.07	CONTRACT ZONE SUBMISSION
3	7.10.07	CONTRACT ZONE SUBMISSION
4	9.04.07	SITE PLAN AND SUBDIVISION REVIEW
5	10.02.07	FINAL SITE PLAN REVIEW
6	11.15.07	50% REVIEW SET
7	12.04.07	50% MAINE HOUSING REVIEW SET
8	05.02.08	50% MAINE HOUSING REVIEW SET
9	07.31.08	100% MAINE HOUSING REVIEW SET
10	09.02.08	100% BID DOCUMENTS

DATE:	09/02/08
PROJECT #	100405
DRAWN BY:	JMV
CHECKED BY:	SPDoel
DRAWING SCALE	AS NOTED

SHEET TITLE
**THIRD FLOOR
MECHANICAL PLAN**

M104