



PARK AVENUE

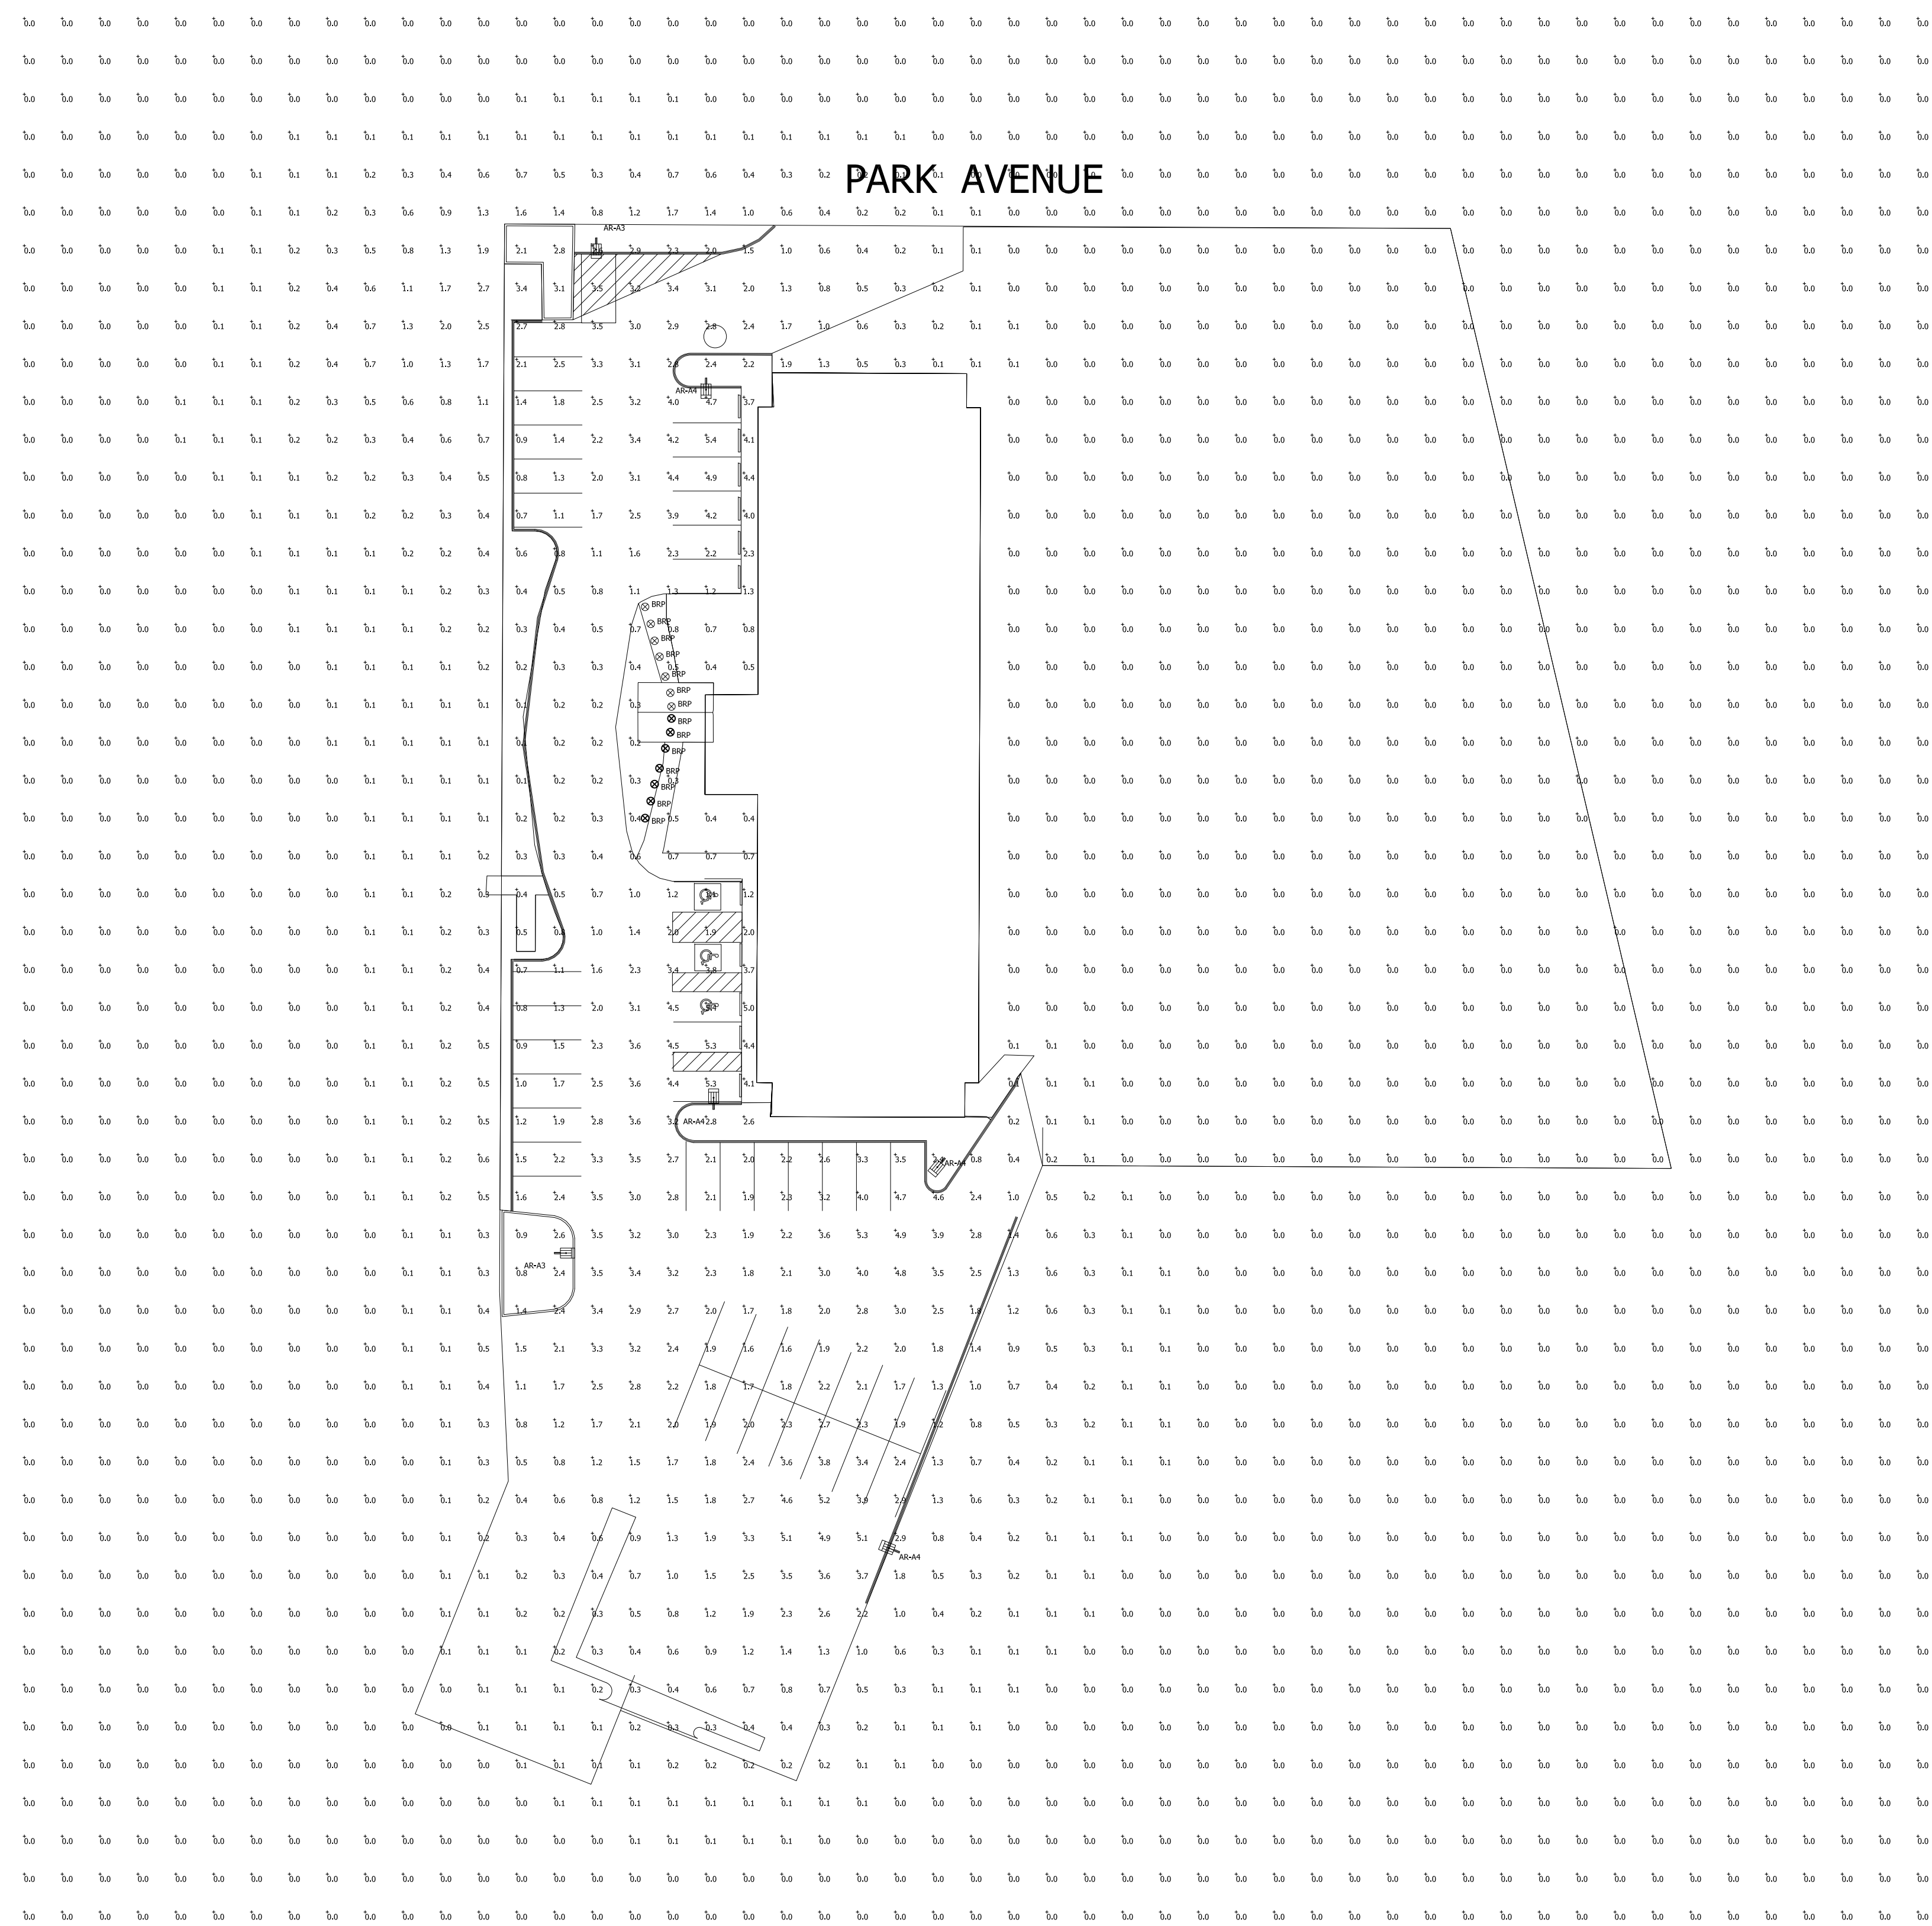

Luminaire Schedule							
Symbol	Label	Qty	Mounting Height	LLF	Watts	Lumens	Description
	AR-A4	4	25' - 0" AFG	0.900	210	16876	ARX16D4-4K70-FGL
	AR-A3	2	25' - 0" AFG	0.900	215	17713	ARX16D3-4K70-FGL
	BRP	14	3' - 6" AFG	N.A.	36	N.A.	BRP42-AC-12NB-36-4K-IND5

Calculation Summary							
Label	CalcType	Units	Avg	Max	Min	Avg/Min	Max/Min
Overall Area	Illuminance	Fc	0.32	5.4	0.0	N.A.	N.A.
Parking Area	Illuminance	Fc	2.16	5.4	0.1	21.60	54.00

Note: Photometric plan show does not reflect contribution from the "BRP" bollard.

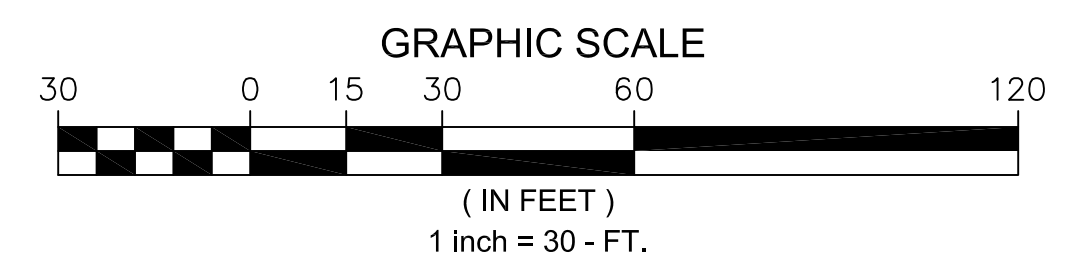

1. THIS LIGHTING DESIGN IS BASED ON LIMITED INFORMATION SUPPLIED BY OTHERS TO HUBBELL LIGHTING. SITE DETAILS PROVIDED HEREON ARE REPRODUCED ONLY AS A VISUALIZATION AID. FIELD DEVIATIONS MAY SIGNIFICANTLY AFFECT PREDICTED PERFORMANCE. PRIOR TO INSTALLATION, CRITICAL SITE INFORMATION (POLE LOCATIONS, ORIENTATION, MOUNTING HEIGHT, ETC.) SHOULD BE COORDINATED WITH THE CONTRACTOR AND/OR SPECIFIER RESPONSIBLE FOR THE PROJECT.

2. LUMINAIRE DATA IS TESTED TO INDUSTRY STANDARDS UNDER LABORATORY CONDITIONS. OPERATING VOLTAGE AND NORMAL MANUFACTURING TOLERANCES OF LAMP, BALLAST, AND LUMINAIRE MAY AFFECT FIELD RESULTS.

3. CONFORMANCE TO FACILITY CODE AND OTHER LOCAL REQUIREMENTS IS THE RESPONSIBILITY OF THE OWNER AND/OR THE OWNER'S REPRESENTATIVE.

TITLE: LA QUINTA INN PORTLAND, ME SITE LIGHTING PLAN	REVISED FROM DRAWING NUMBER(S):	 Hubbell Lighting, Inc. 701 MILLENNIUM BLVD. GREENVILLE, SC 29607	DN BY:	DATE:	CHK BY:
	1781058		DHK	01/12/17	N/A
	1781170		DHK	04/25/17	SCALE: AS NOTED
1782155			QUOTE:	DRAWING / DESIGN NO.:	
			N/A	1782243	