



MECHANICAL KEYNOTES	
NOTE	DESCRIPTION
M02	RECONNECT TO EXISTING EXHAUST DUCTWORK
M04	INSTALL NEW SIDEWALL SUPPLY AIR REGISTER
M05	INSTALL NEW VOLUME DAMPER FULL SIZE OF DUCTWORK
M06	INSTALL NEW FIRE DAMPER FULL SIZE OF DUCTWORK
M10	INSTALL NEW CEILING EXHAUST FAN
M35	INSTALL NEW CEILING EXHAUST FAN SWITCH WITH RED INDICATING LIGHT

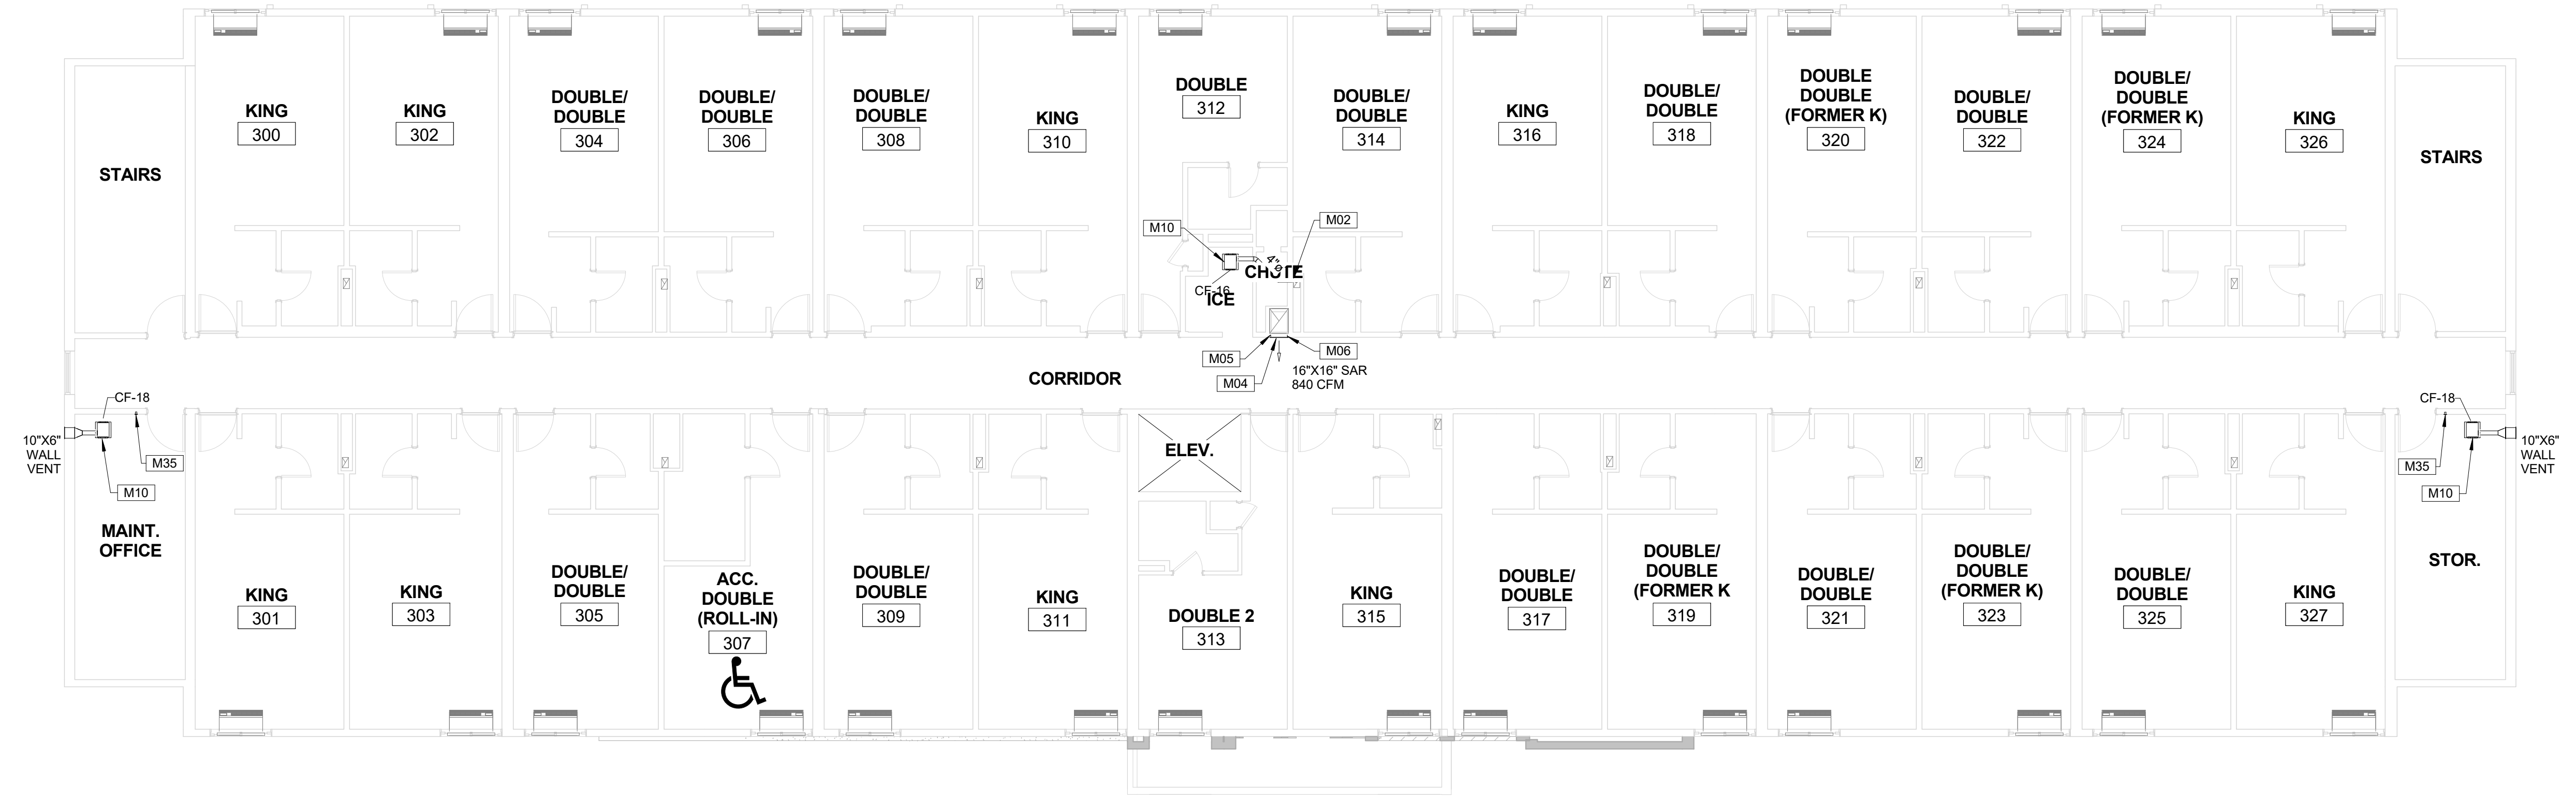

Project:  
**PORTLAND LaQUINTA INN & SUITES - LQ #2049 RENOVATION**

Project Owner:  
**LQ MANAGEMENT, LLC**  
 909 HIDDEN RIDGE, SUITE 600 IRVING, TEXAS 75038

Architect:  
**BMA Architectural Group**  
 Professional Corporation  
 Architects ■ Designers ■ Planners  
 12 Middle Street  
 Amherst, New Hampshire 03031  
 TEL 603 673 1991 FAX 603 672 1385  
 www.bmaworld.com

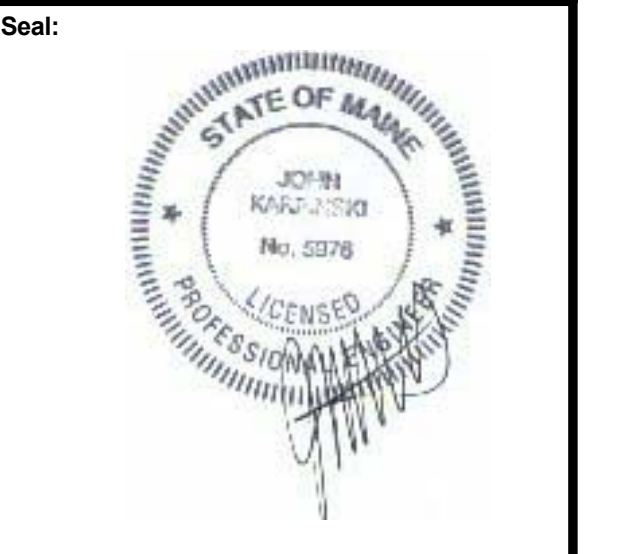

ENGINEER:  
**INTEGRATED ENGINEERED SYSTEMS, INC.**  
 △ MECH. DESIGN  
 △ ENERGY MGT.  
 △ INDOOR AIR QUALITY  
 P.O. BOX 657  
 AUBURN, N.H. 03032  
 Tel: (603) 625-1346  
 Fax: (603) 625-8456

REVISIONS	

Job Number: J799  
 Drawn By: CLB  
 Checked By: JK  
 Phase: Lobby and ADA Documents

Drawing Title:  
**SECOND & THIRD FLOOR MECHANICAL PLAN**

SHEET NUMBER:  
**M-202**  
 DATE: 10 APRIL 2017