



| MECHANICAL KEYNOTES | |
|---------------------|---|
| NOTE | DESCRIPTION |
| M02 | RECONNECT TO EXISTING EXHAUST DUCTWORK |
| M04 | INSTALL NEW SIDEWALL SUPPLY AIR REGISTER |
| M05 | INSTALL NEW VOLUME DAMPER FULL SIZE OF DUCTWORK |
| M06 | INSTALL NEW FIRE DAMPER FULL SIZE OF DUCTWORK |
| M10 | INSTALL NEW CEILING EXHAUST FAN |
| M11 | INSTALL NEW THERMOSTAT |
| M12 | INSTALL NEW ROOF EXHAUST FAN WITH MATCHING ROOF CURB |
| M18 | FOR INSTALLATION SEE LOUVER INSTALLATION DETAIL ON SHEET M-500 |
| M23 | FOR INSTALLATION SEE CEILING EXHAUST FAN INSTALLATION DETAIL ON SHEET M-501 |
| M25 | FOR INSTALLATION SEE ROOF FAN MOUNTING DETAIL ON SHEET M-501 |
| M28 | INSTALL NEW SMOKE DAMPER IN DUCTWORK |
| M30 | INSTALL NEW LOUVER AND SEAL WEATHER TIGHT |
| M31 | INSTALL NEW MOTORIZED DAMPER FULL SIZE OF DUCT & RELAY LINK |
| M33 | INSTALL NEW RELAY AND LINK WITH WATER HEATER |
| M35 | INSTALL NEW CEILING EXHAUST FAN SWITCH WITH RED INDICATING LIGHT |

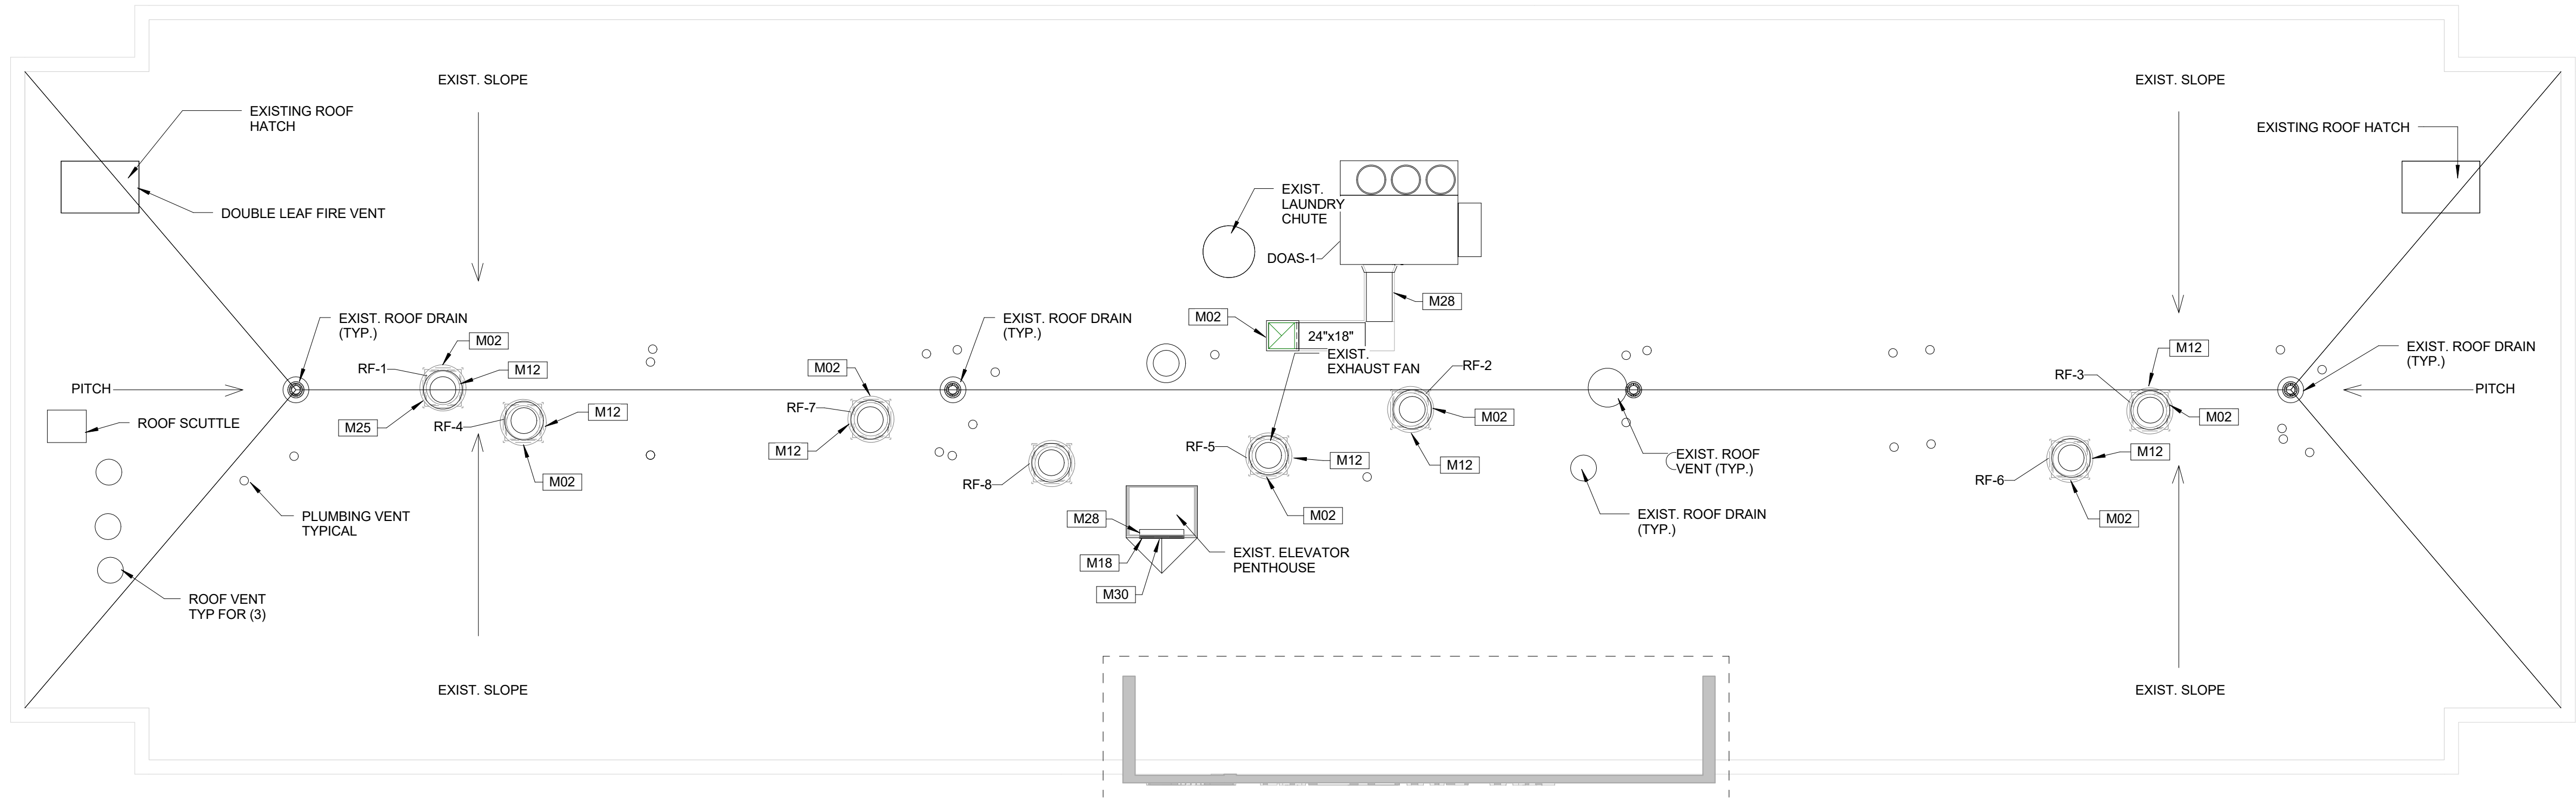

2 ROOF LEVEL PLAN
1/8" = 1'-0"

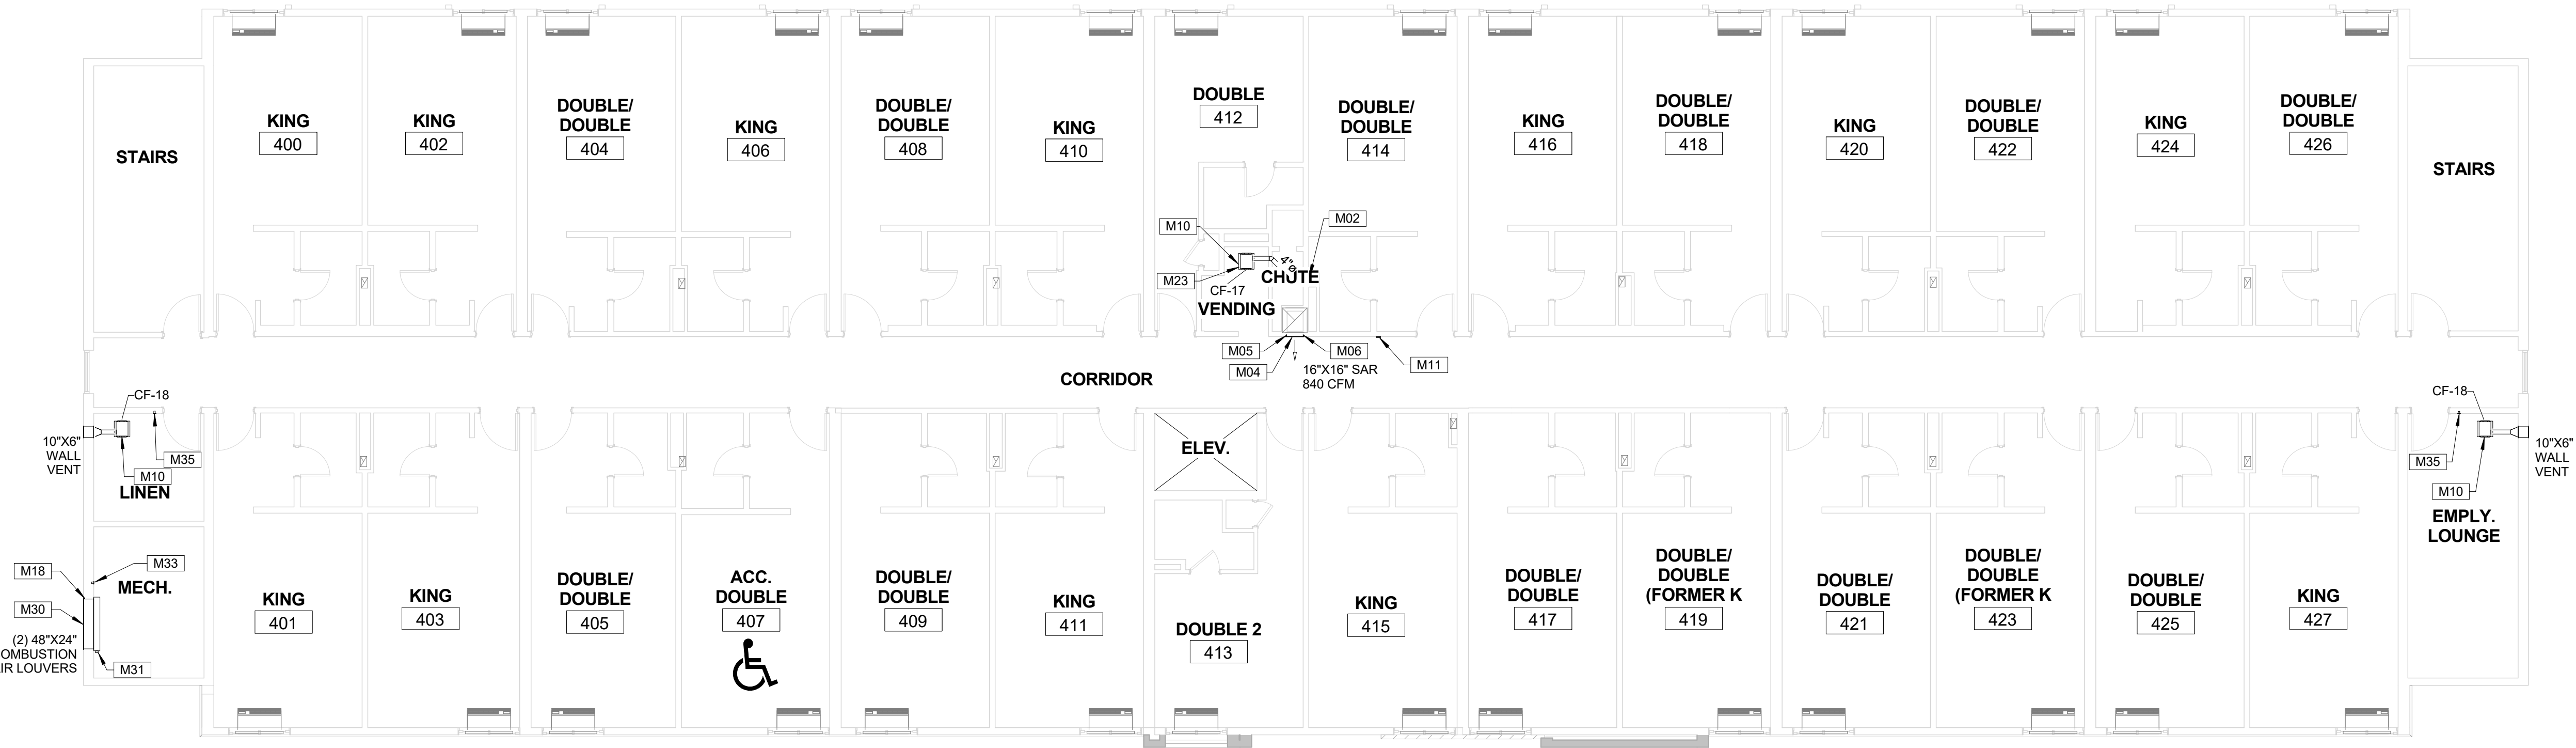

1 FOURTH FLOOR PLAN
1/8" = 1'-0"

Project:


**PORTLAND LaQUINTA
 INN & SUITES - LQ
 #2049 RENOVATION**


Project Owner:
LQ MANAGEMENT, LLC

909 HIDDEN RIDGE, SUITE 600 IRVING, TEXAS
 75038

Architect:

BMA
 Architectural Group
 Professional Corporation
 Architects ■ Designers ■ Planners
 12 Middle Street
 Amherst, New Hampshire 03031
 TEL 603 673 1991 FAX 603 672 1385
 www.bmaworld.com

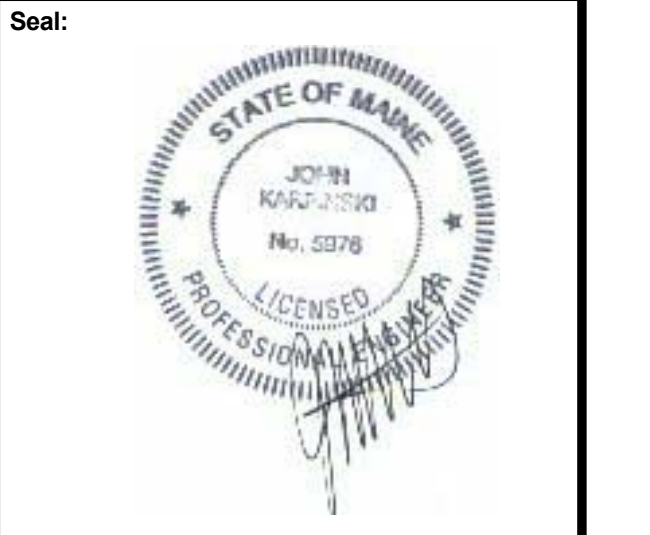

ENGINEER:

**INTEGRATED
 ENGINEERED
 SYSTEMS, INC.**
 Δ MECH. DESIGN
 Δ ENERGY MGT.
 Δ INDOOR AIR QUALITY
 P.O. BOX 657
 AUBURN, N.H. 03032
 Tel: (603) 625-1346
 Fax: (603) 625-8456

| REVISIONS | |
|-----------|--|
| | |
| | |
| | |

Job Number: J799
 Drawn By: CLB
 Checked By: JK
 Phase: Lobby and ADA Documents

Drawing Title:
**FOURTH FLOOR &
 ROOF LEVEL
 MECHANICAL PLAN**

SHEET NUMBER:
M-203
 DATE: 10 APRIL 2017