


REVISIONS

NO.	DESCRIPTION

Job Number: J799
 Drawn By: CLB
 Checked By: JK
 Phase: Lobby and ADA Documents


Drawing Title:
PLUMBING DETAILS

SHEET NUMBER:
P-500
 DATE: 10 April 2017

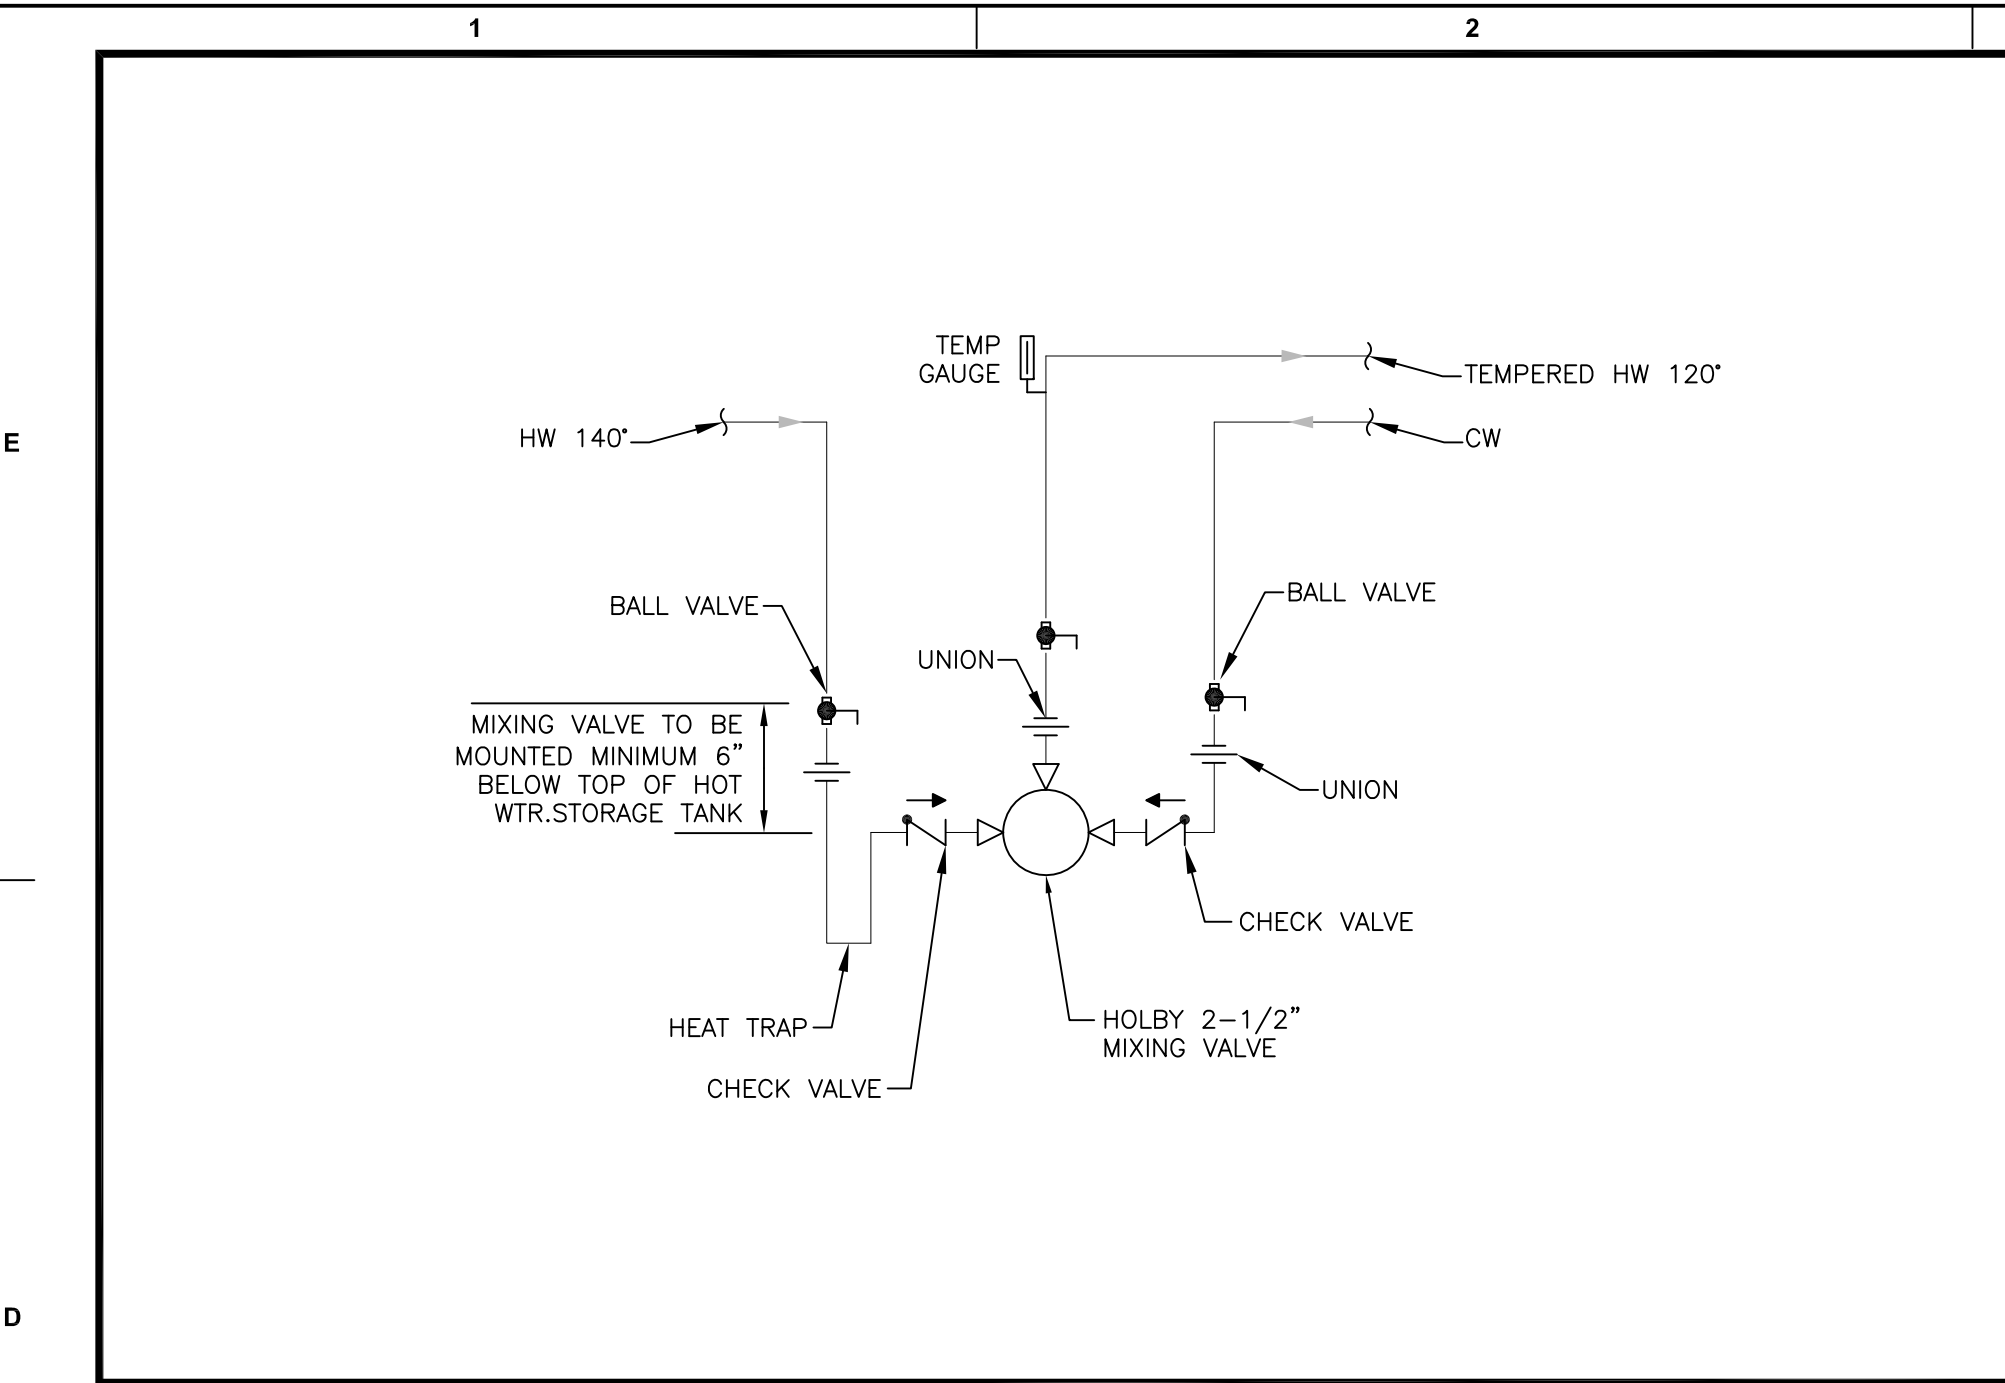


MIXING VALVE DETAIL

NTS

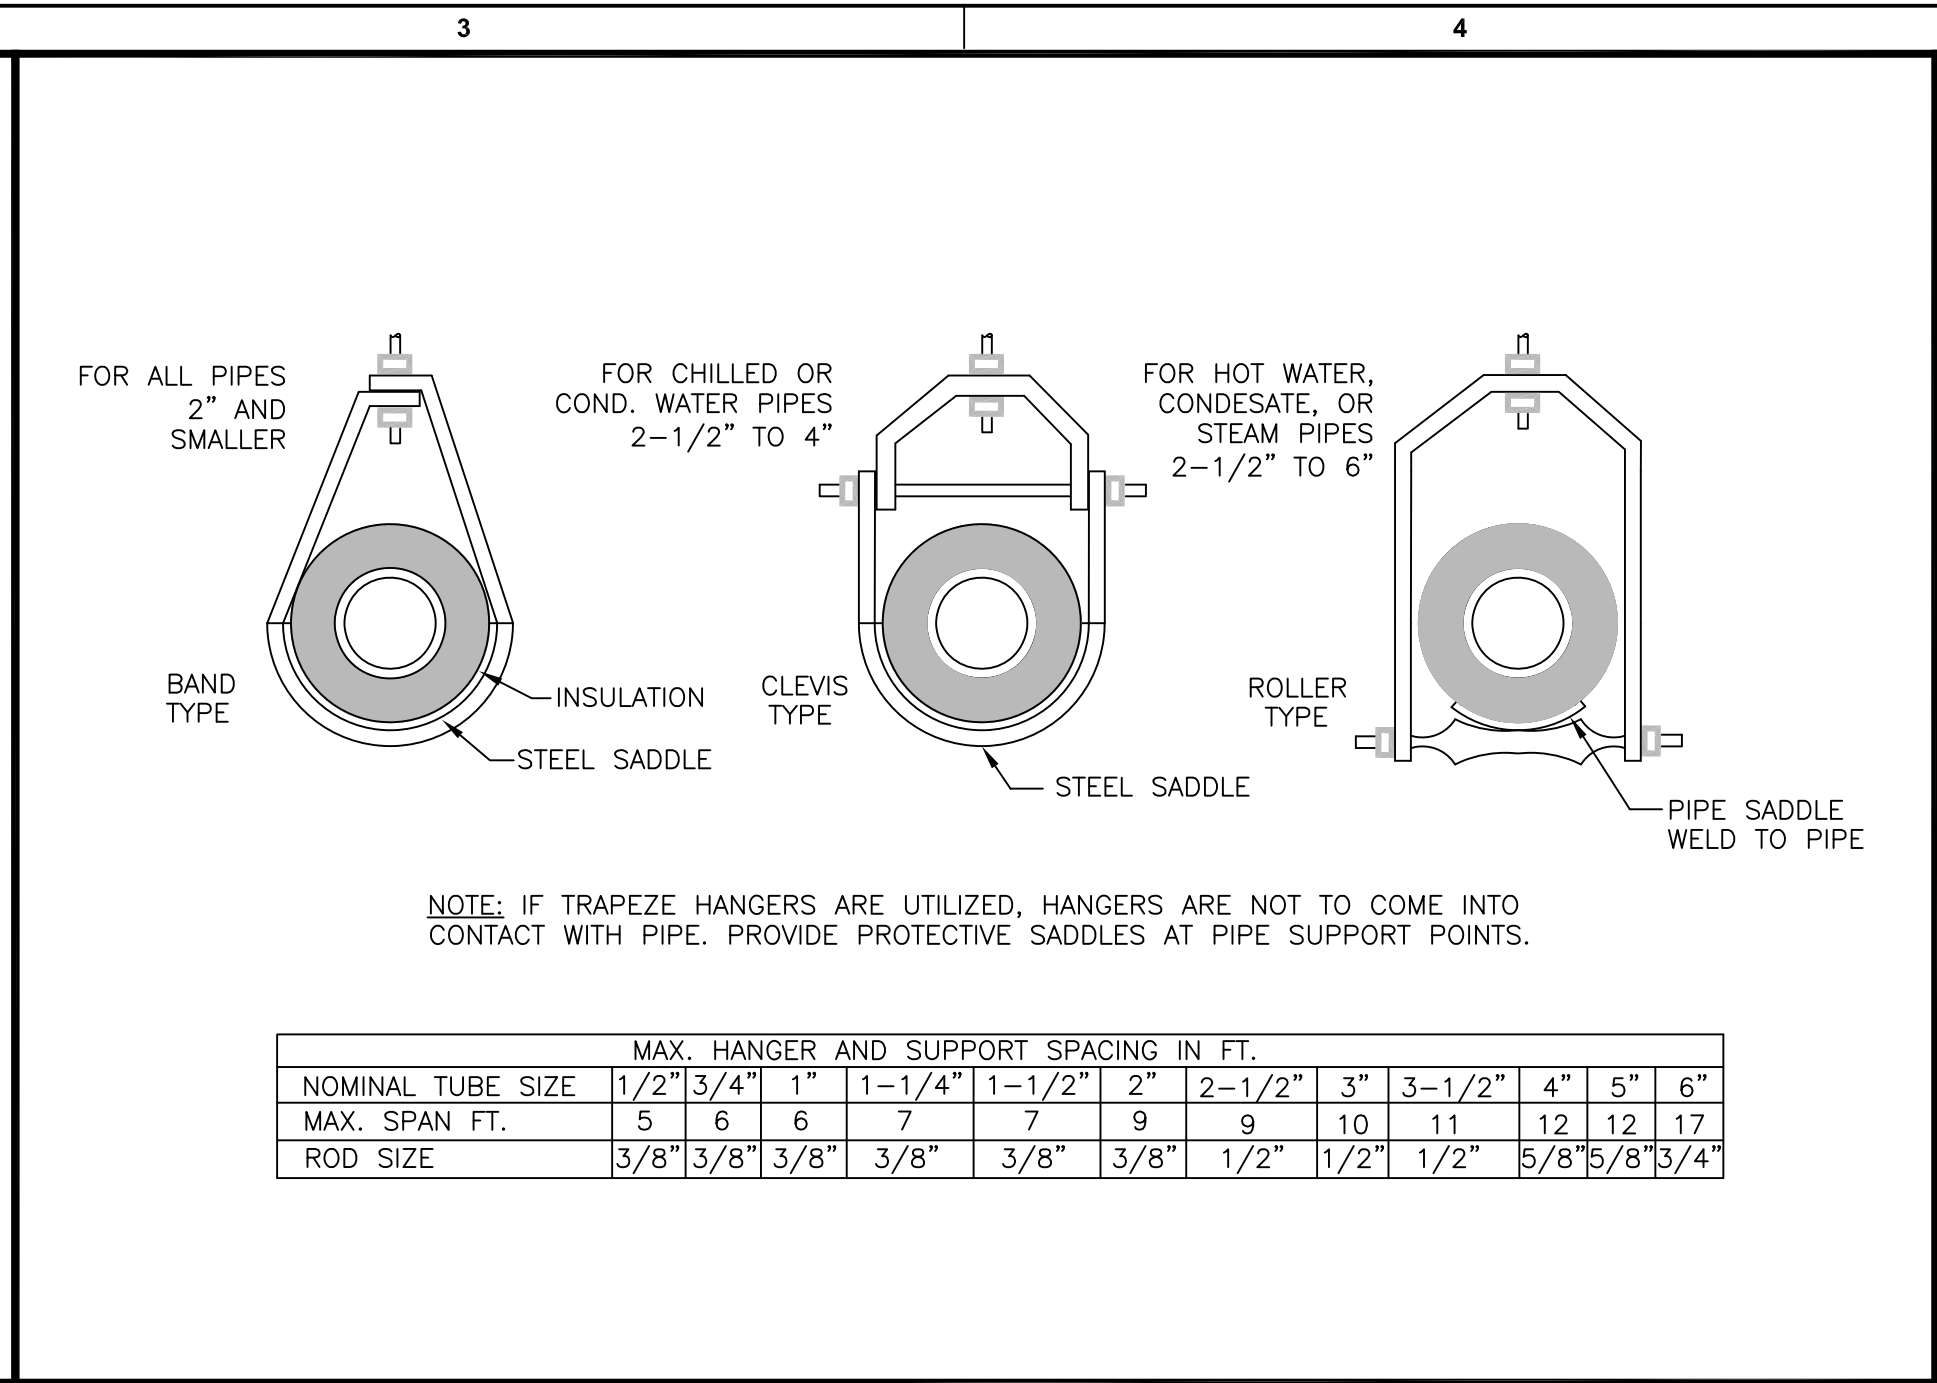


PIPE HANGER STANDARDS DETAIL

NTS

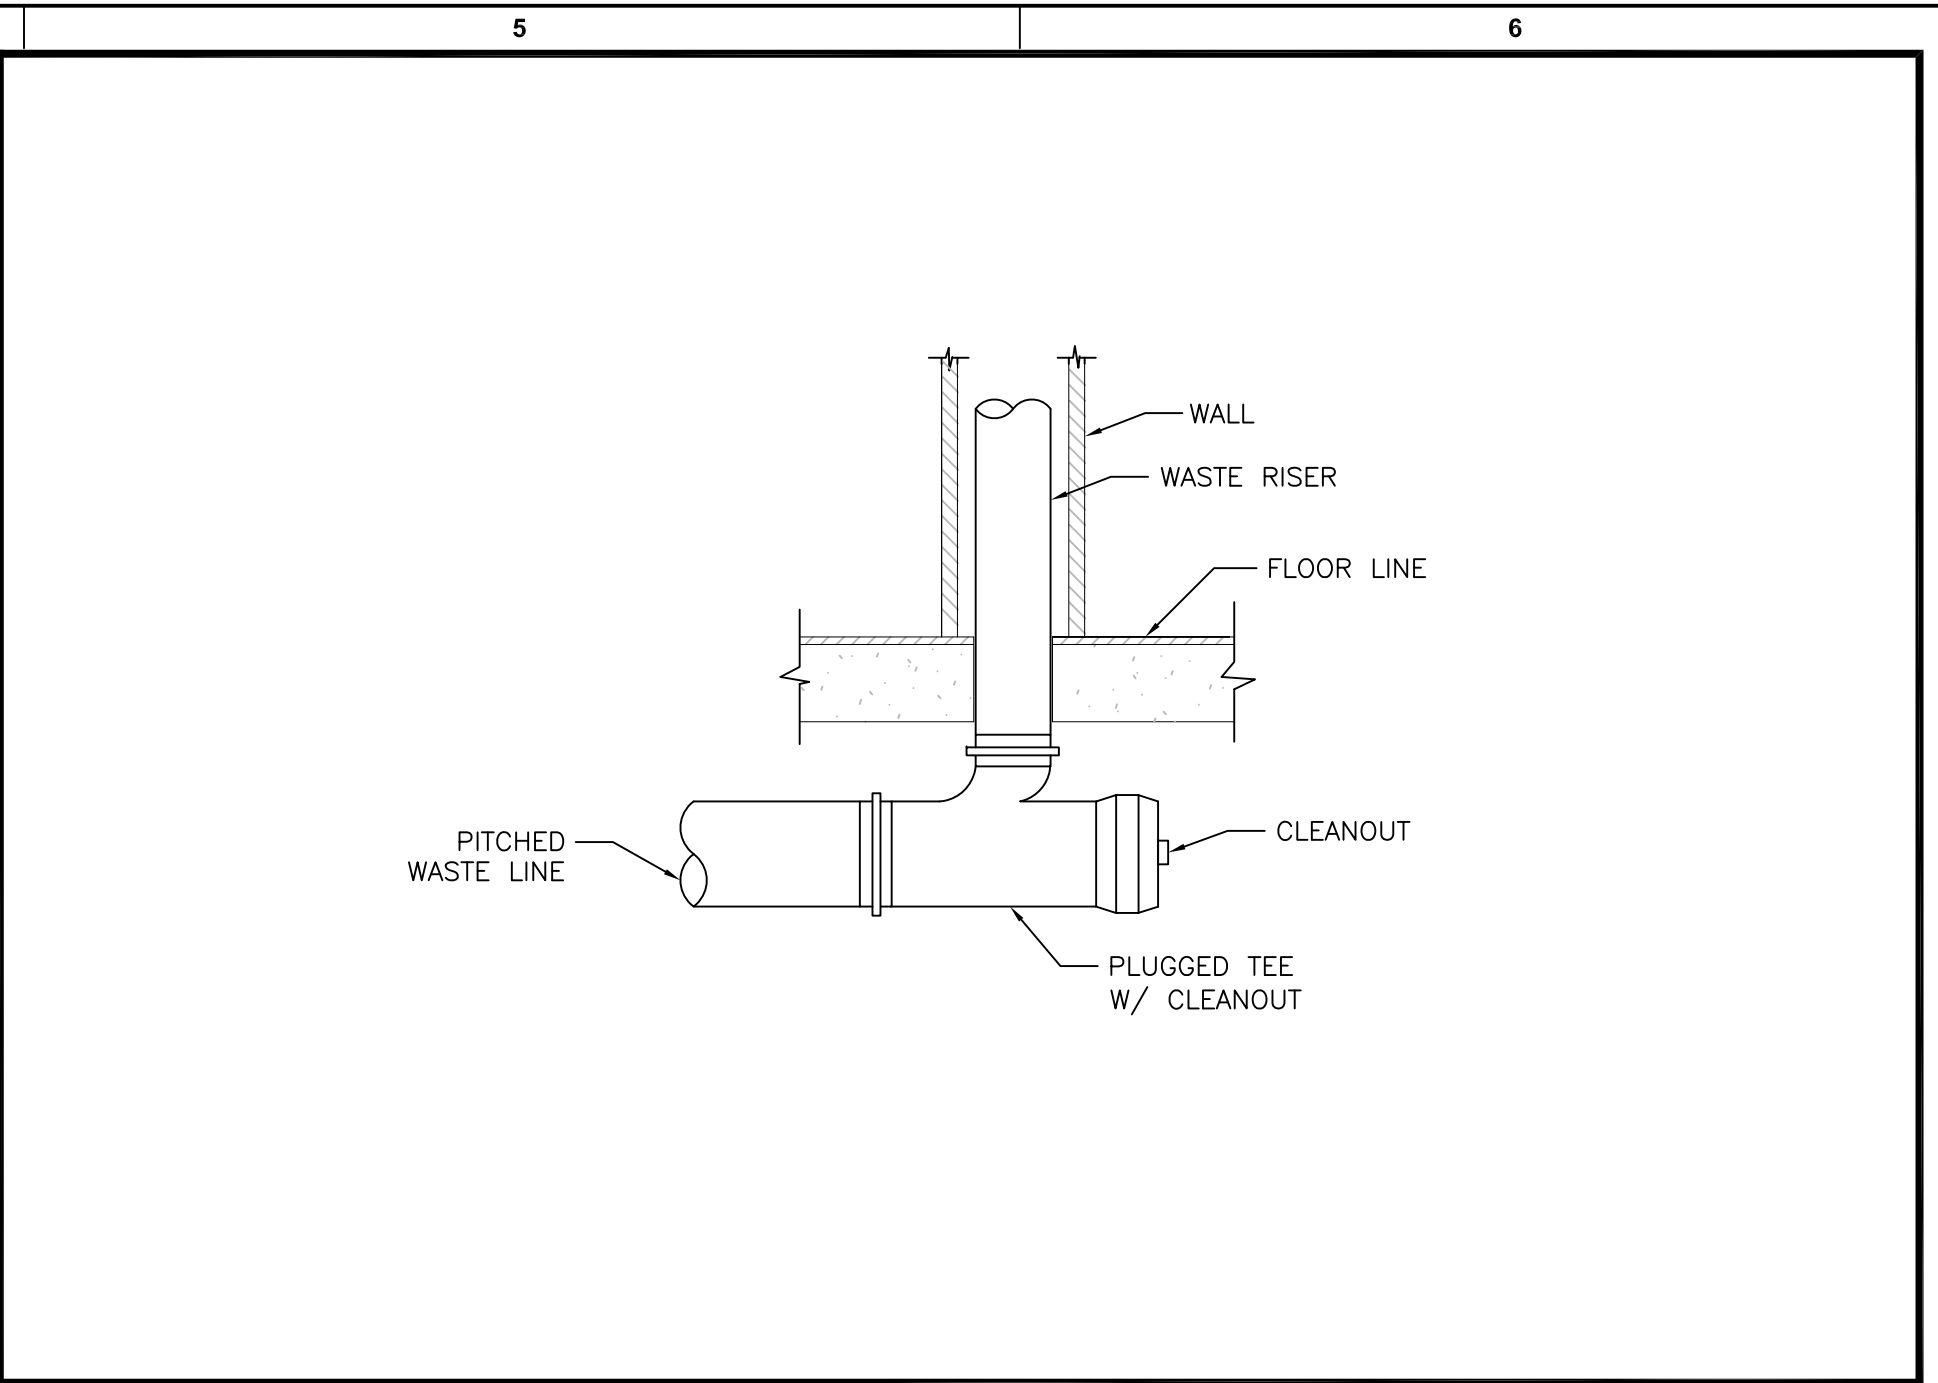


WASTE PIPE CLEANOUT DETAIL

NTS

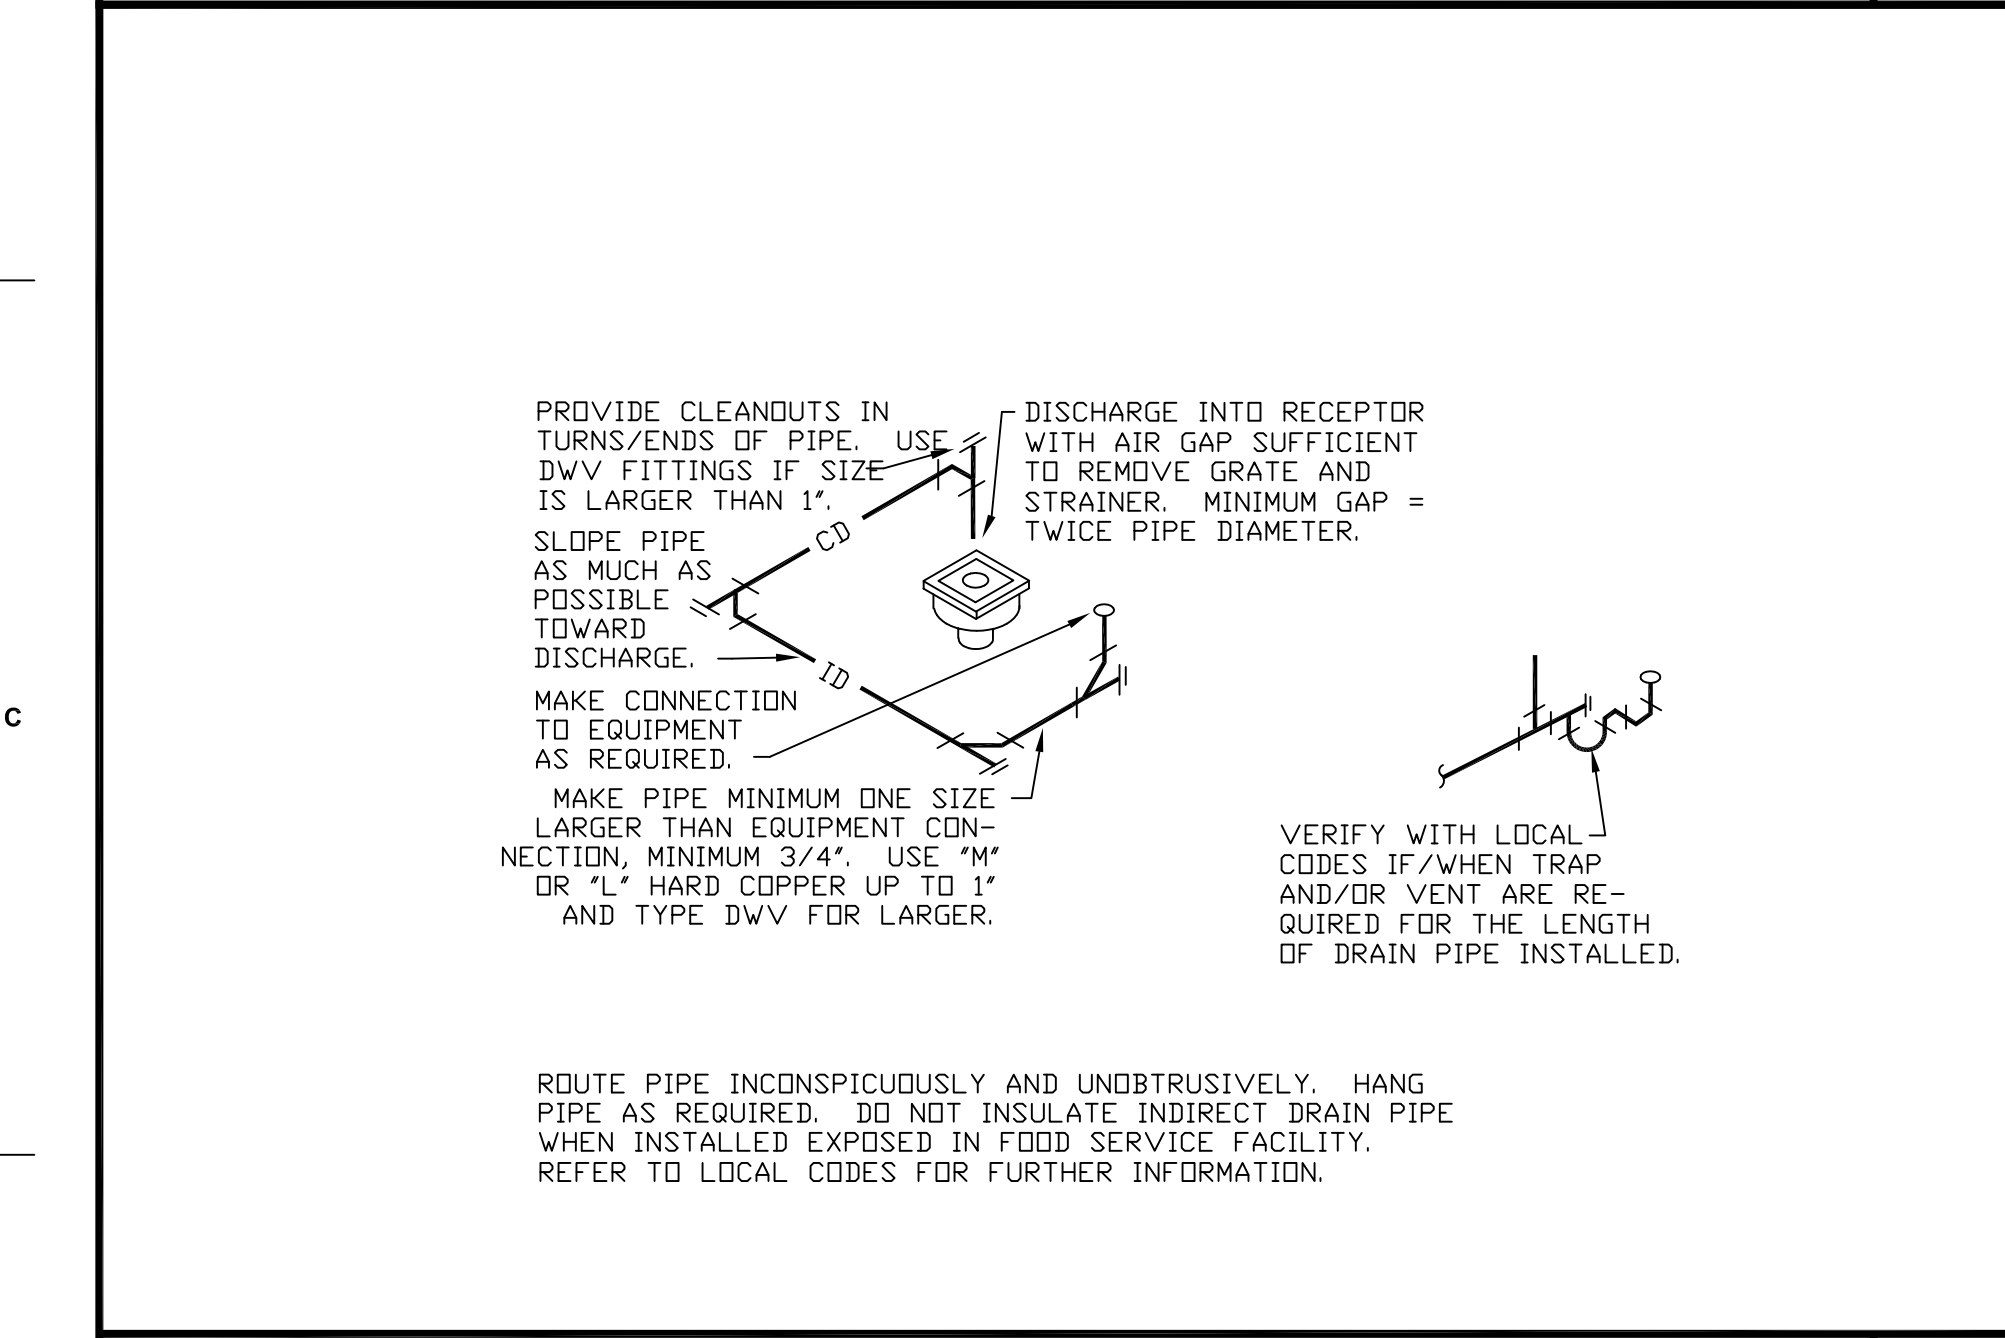


CONDENSATE DRAIN DETAIL

NTS

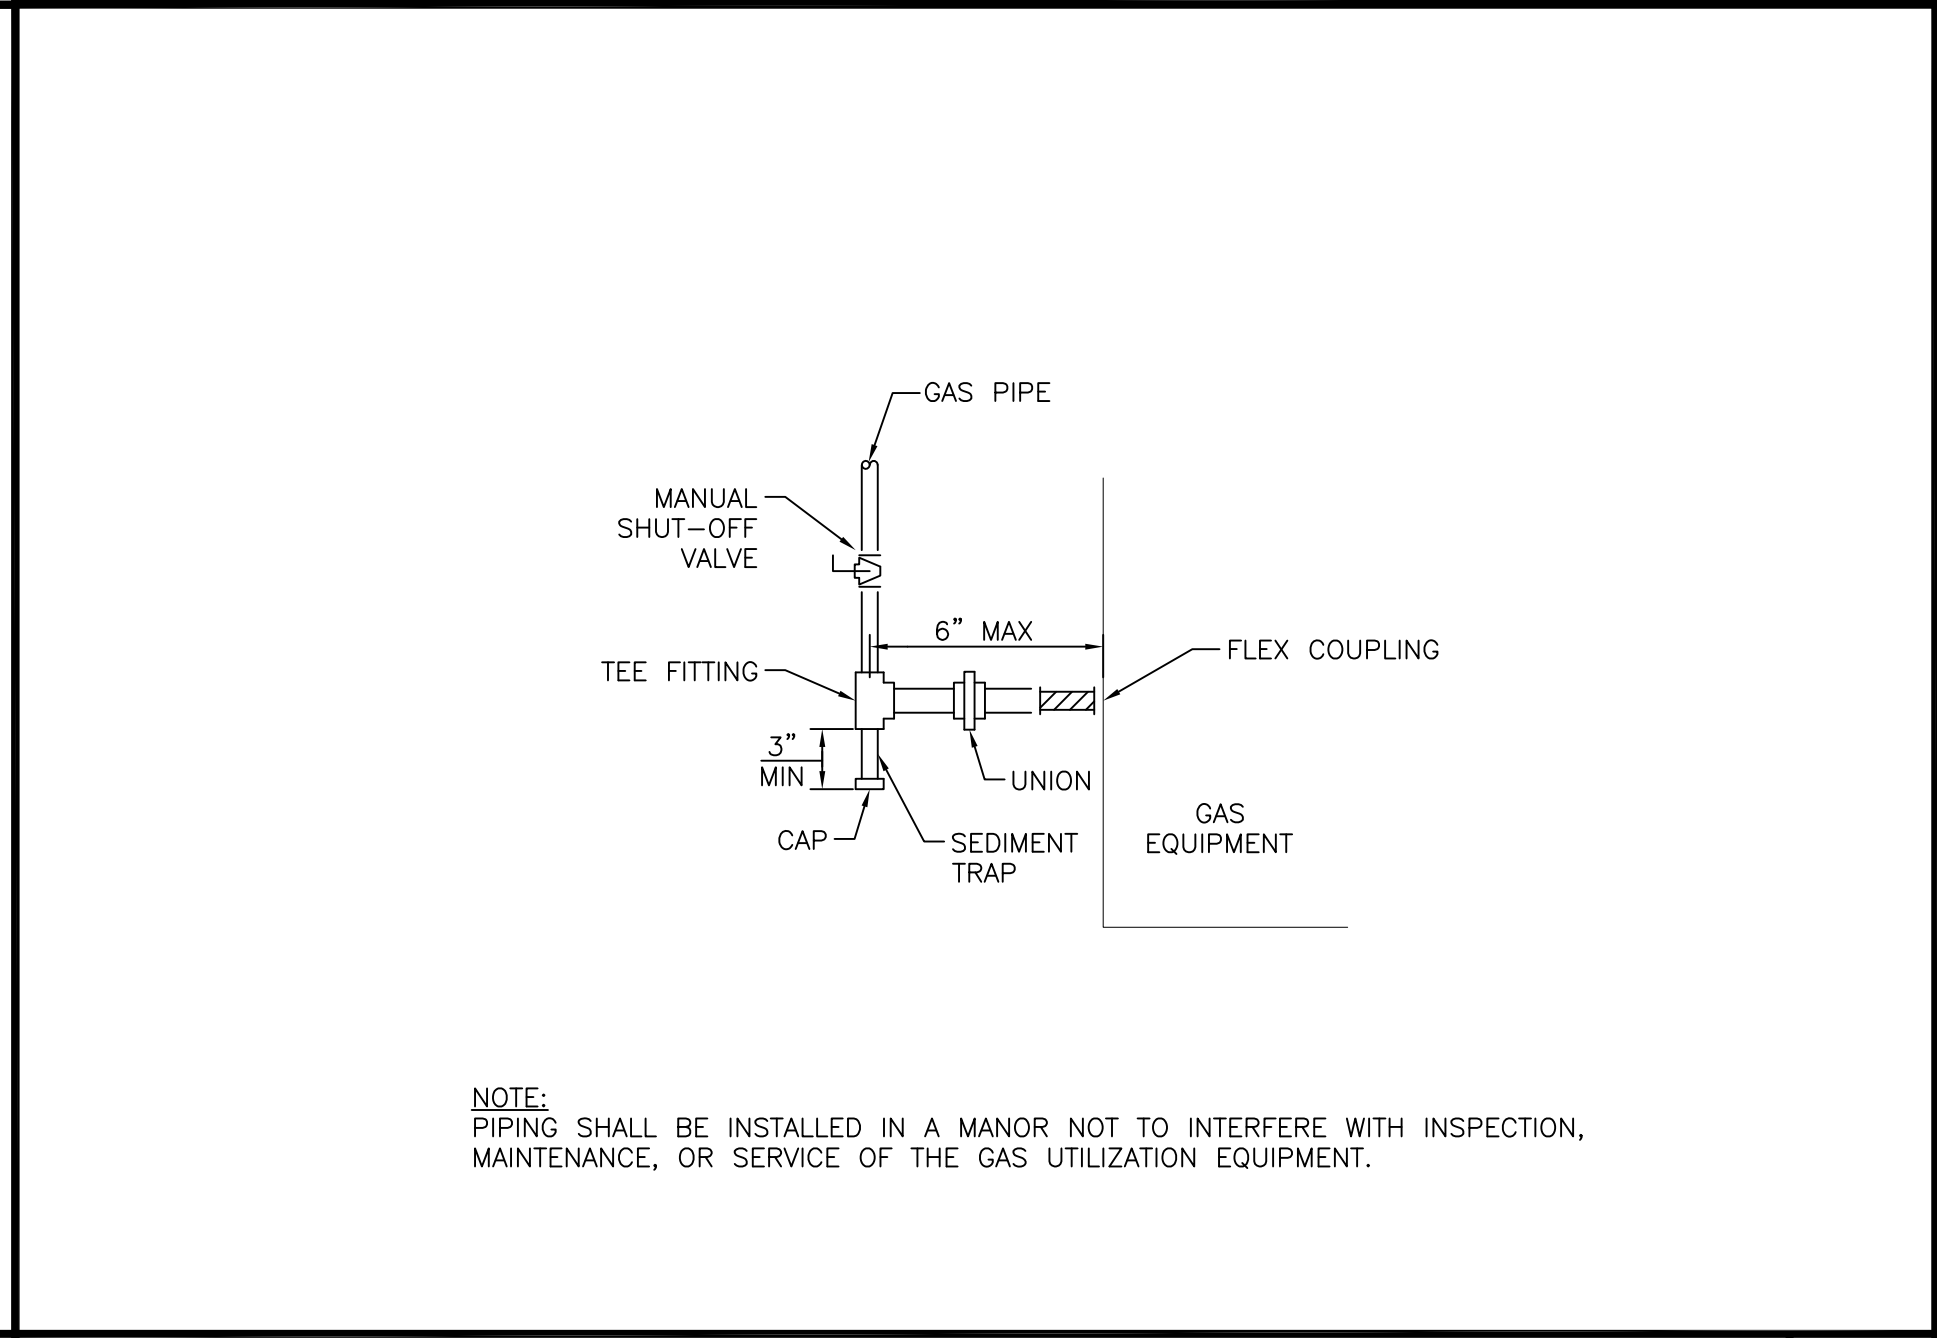


GAS CONNECTION TO EQUIPMENT DETAIL

NTS

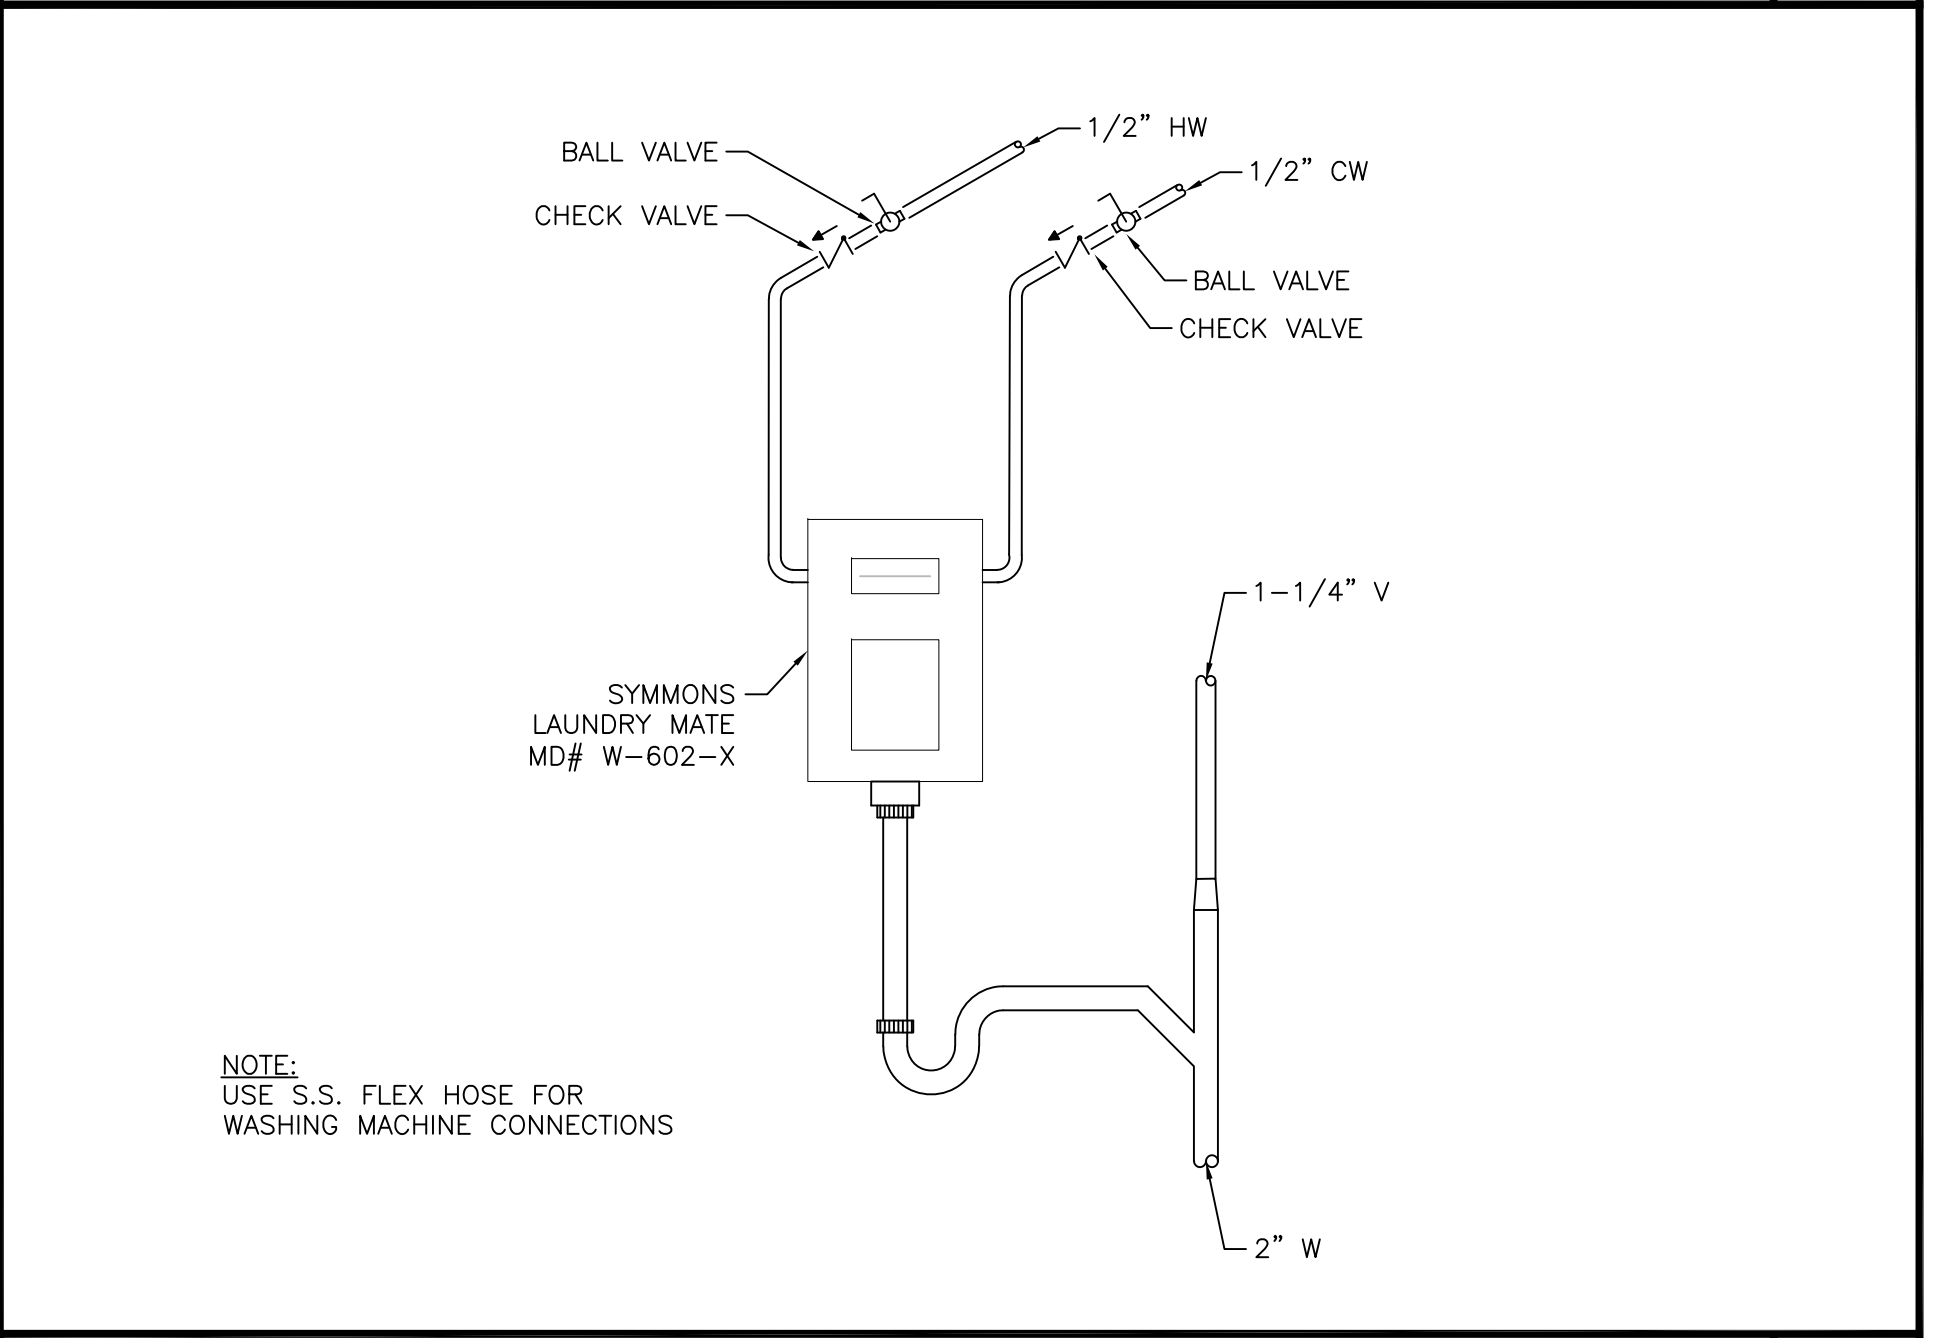


DOMESTIC WASHING MACHINE DETAIL

NTS

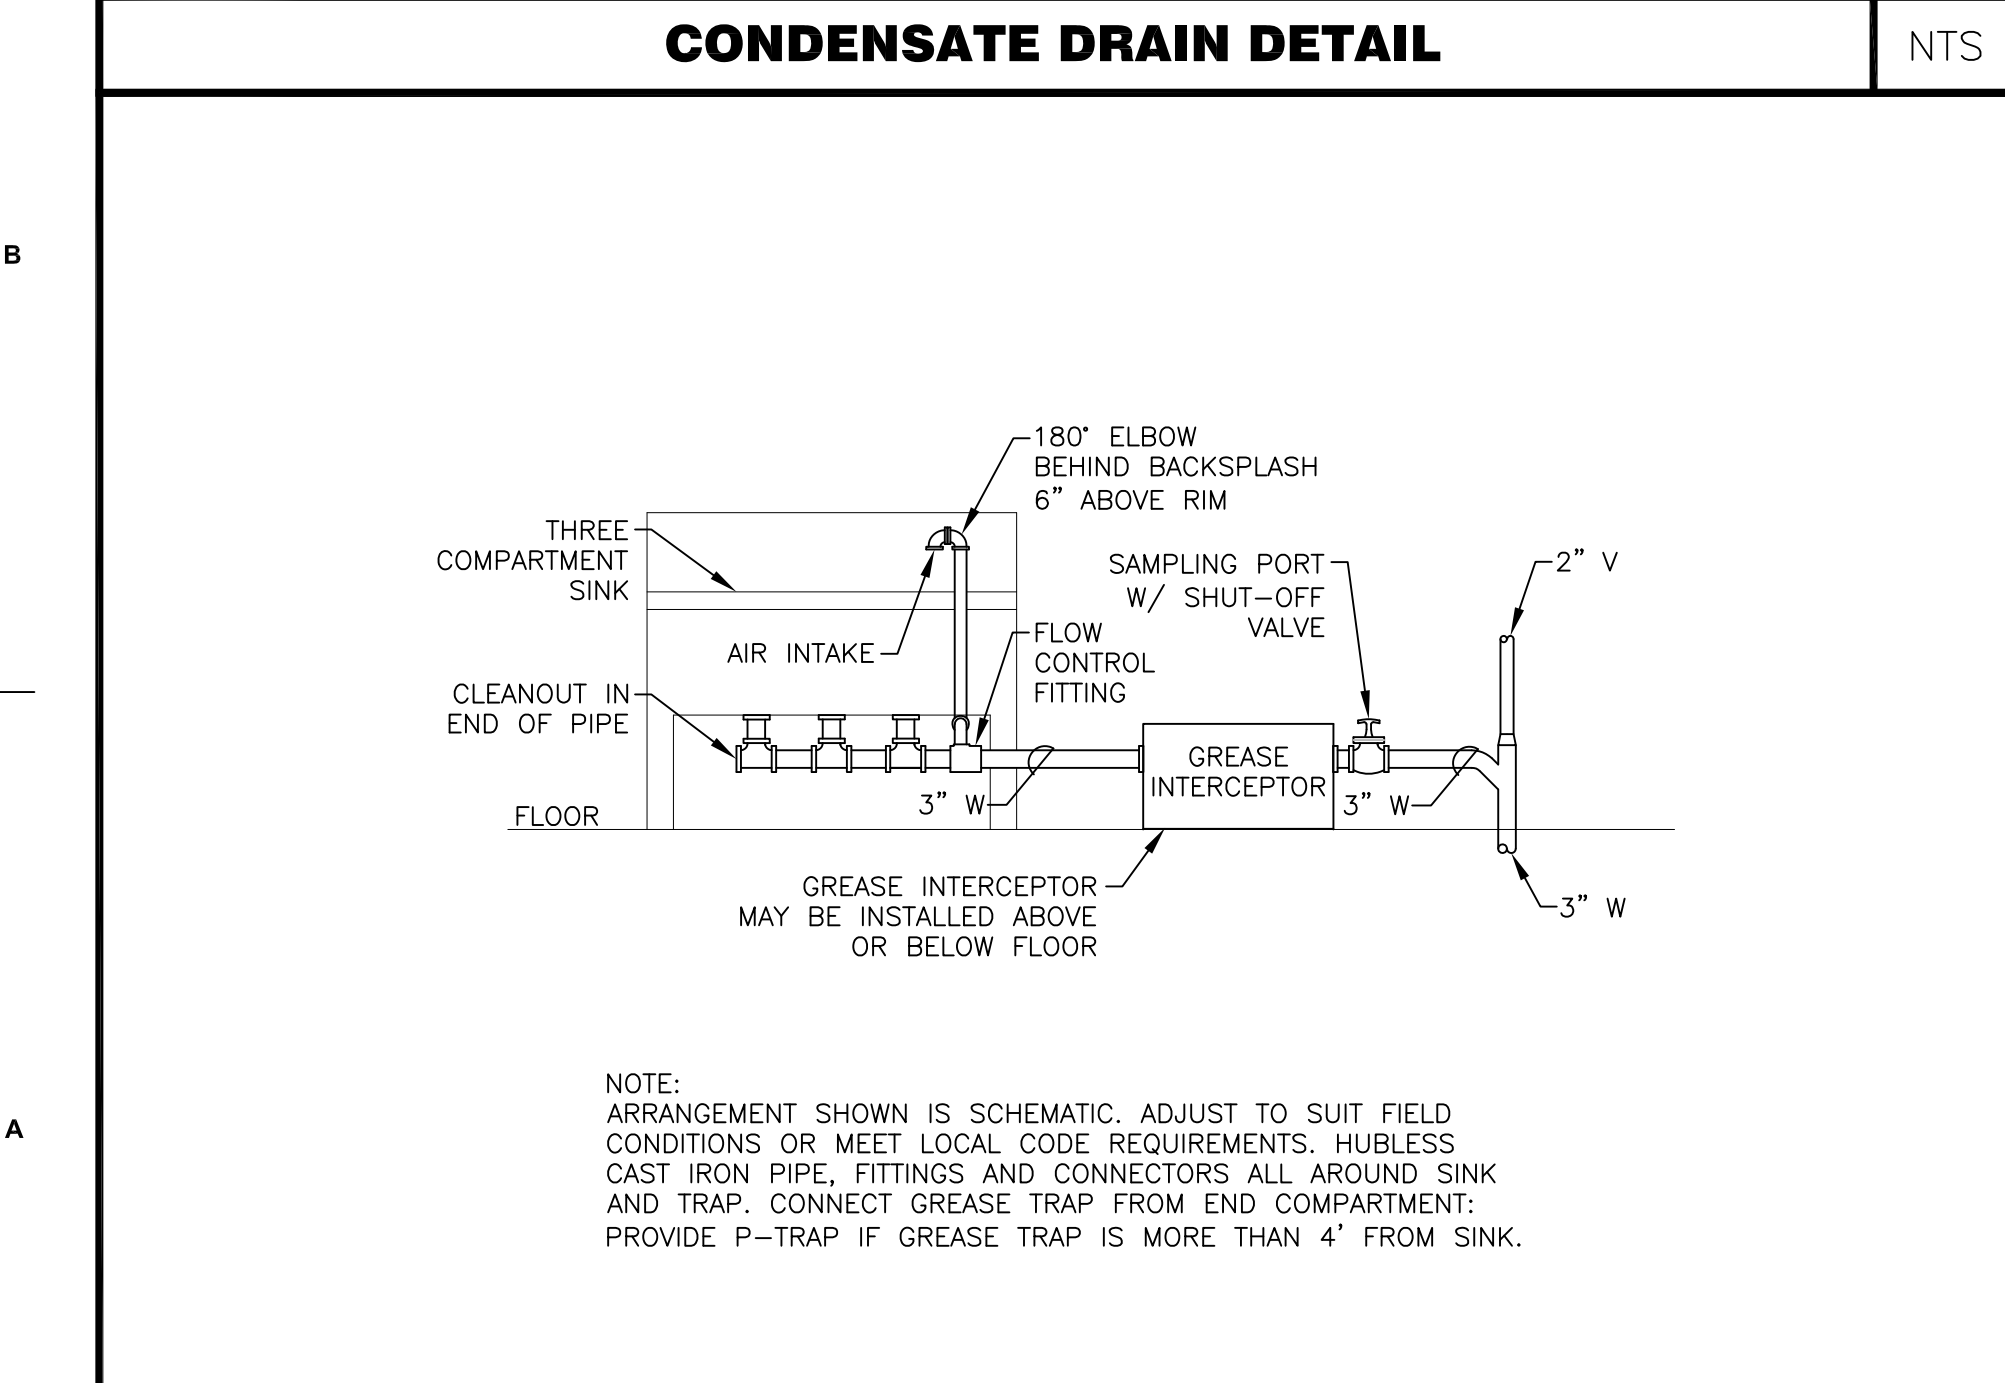


GREASE INTERCEPTOR DETAIL

NTS

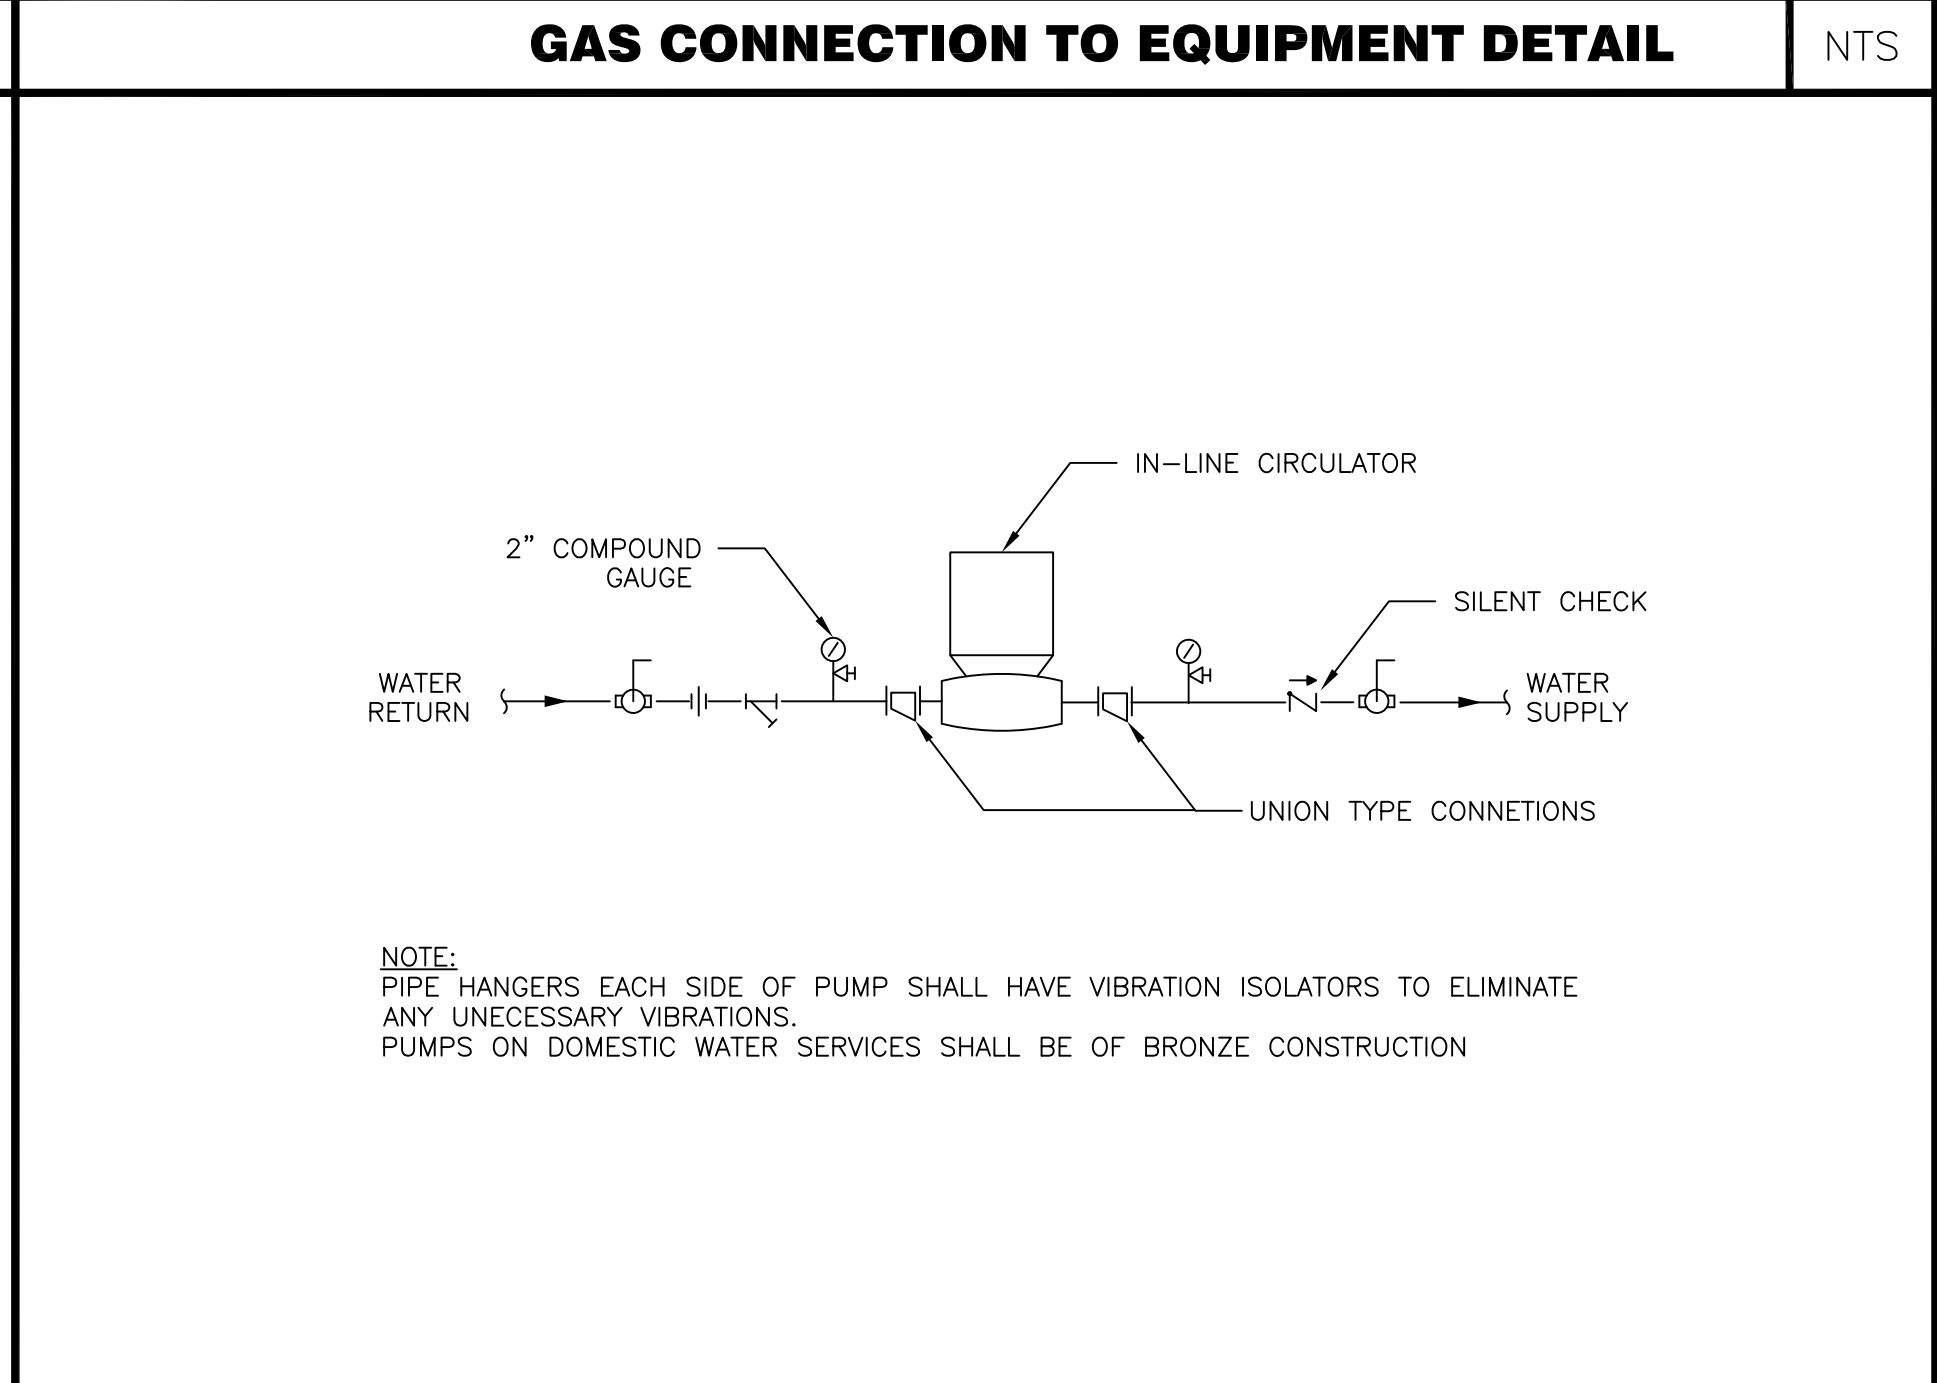

IN-LINE CIRCULATOR DETAIL

NTS

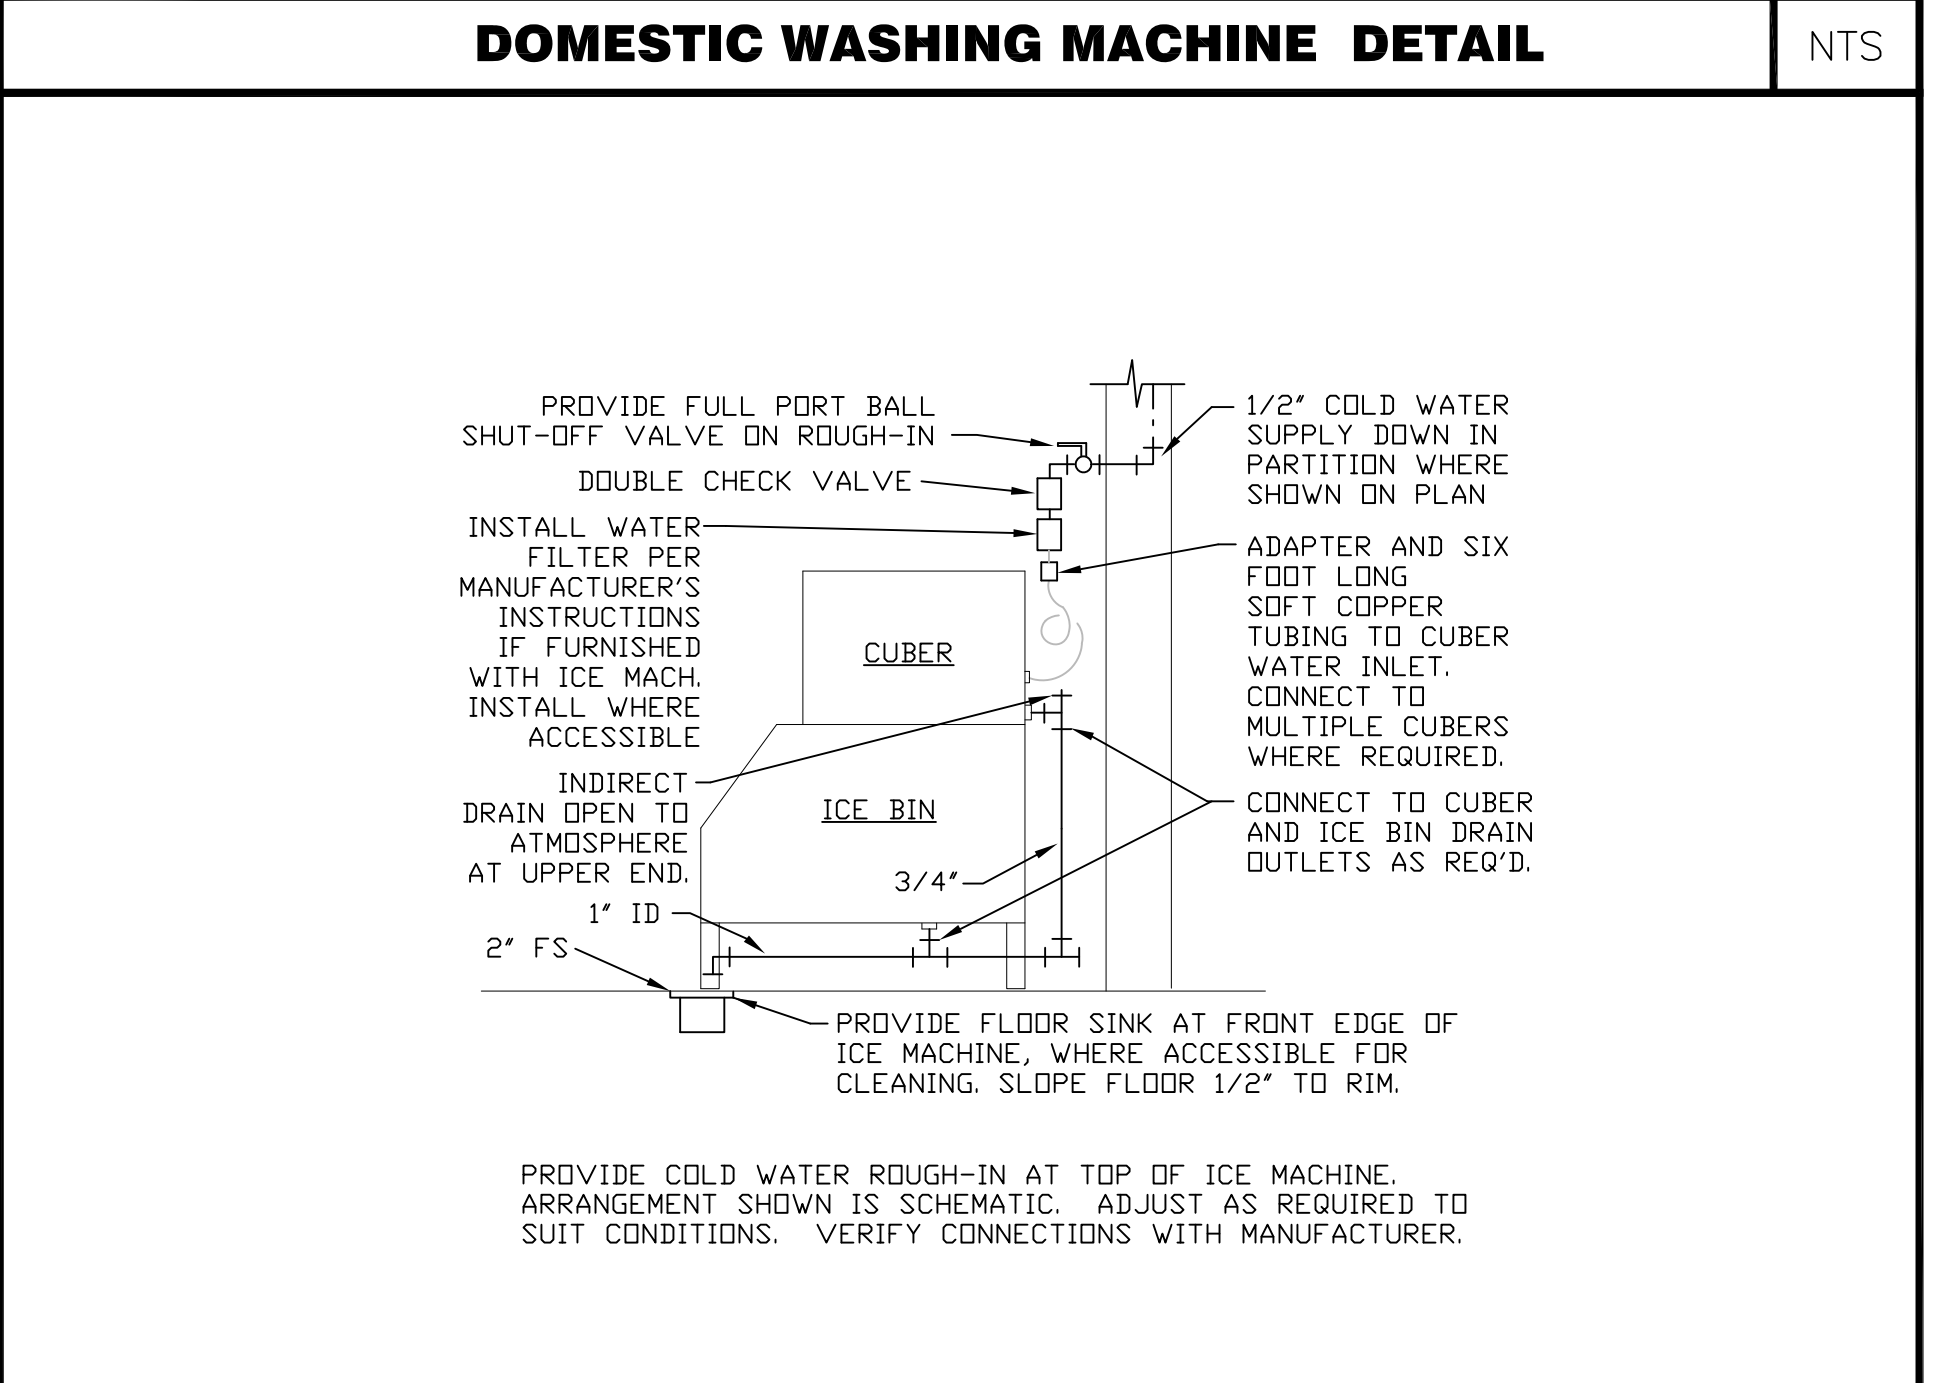

ICE MACHINE CONNECTIONS DETAIL

NTS