


PLAYPLACE LIGHT FIXTURES									
F12	○	COMPACT FLUORESCENT DOWN LIGHT	8" SPECULAR CLEAR REFLECTOR TEMPERED GLASS	2-26W	PL125W/3500K QUAD TUBE LOW MERCURY	ELECTRONIC	RECESSED SURFACE	DINING	SECURITY LIGHTING # DA226E120/4489W
F27 & F27(A)	⊗	FOR SERIES (F27A= PROVIDE QUARTZ RESISTIVE, QSS)	REFLECTOR TEMPERED GLASS	1-400	METAL HALIDE	-	SURFACE	PLAYPLACE	SECURITY LIGHTING # PGR-400MH-WH 2X2 GRID ADAPTOR (OPEN), PROVIDE 2'x2' LUMINAIRE TRAY FOR ACQUISITIAL TILE
F28 & F28(A)	⊗	FOR SERIES (F27A= PROVIDE QUARTZ RESISTIVE, QSS)	REFLECTOR TEMPERED GLASS	1-250	METAL HALIDE	-	SURFACE	PLAYPLACE	SECURITY LIGHTING # PGR-250MH-WH 2X2 GRID ADAPTOR (OPEN), PROVIDE 2'x2' LUMINAIRE TRAY FOR ACQUISITIAL TILE

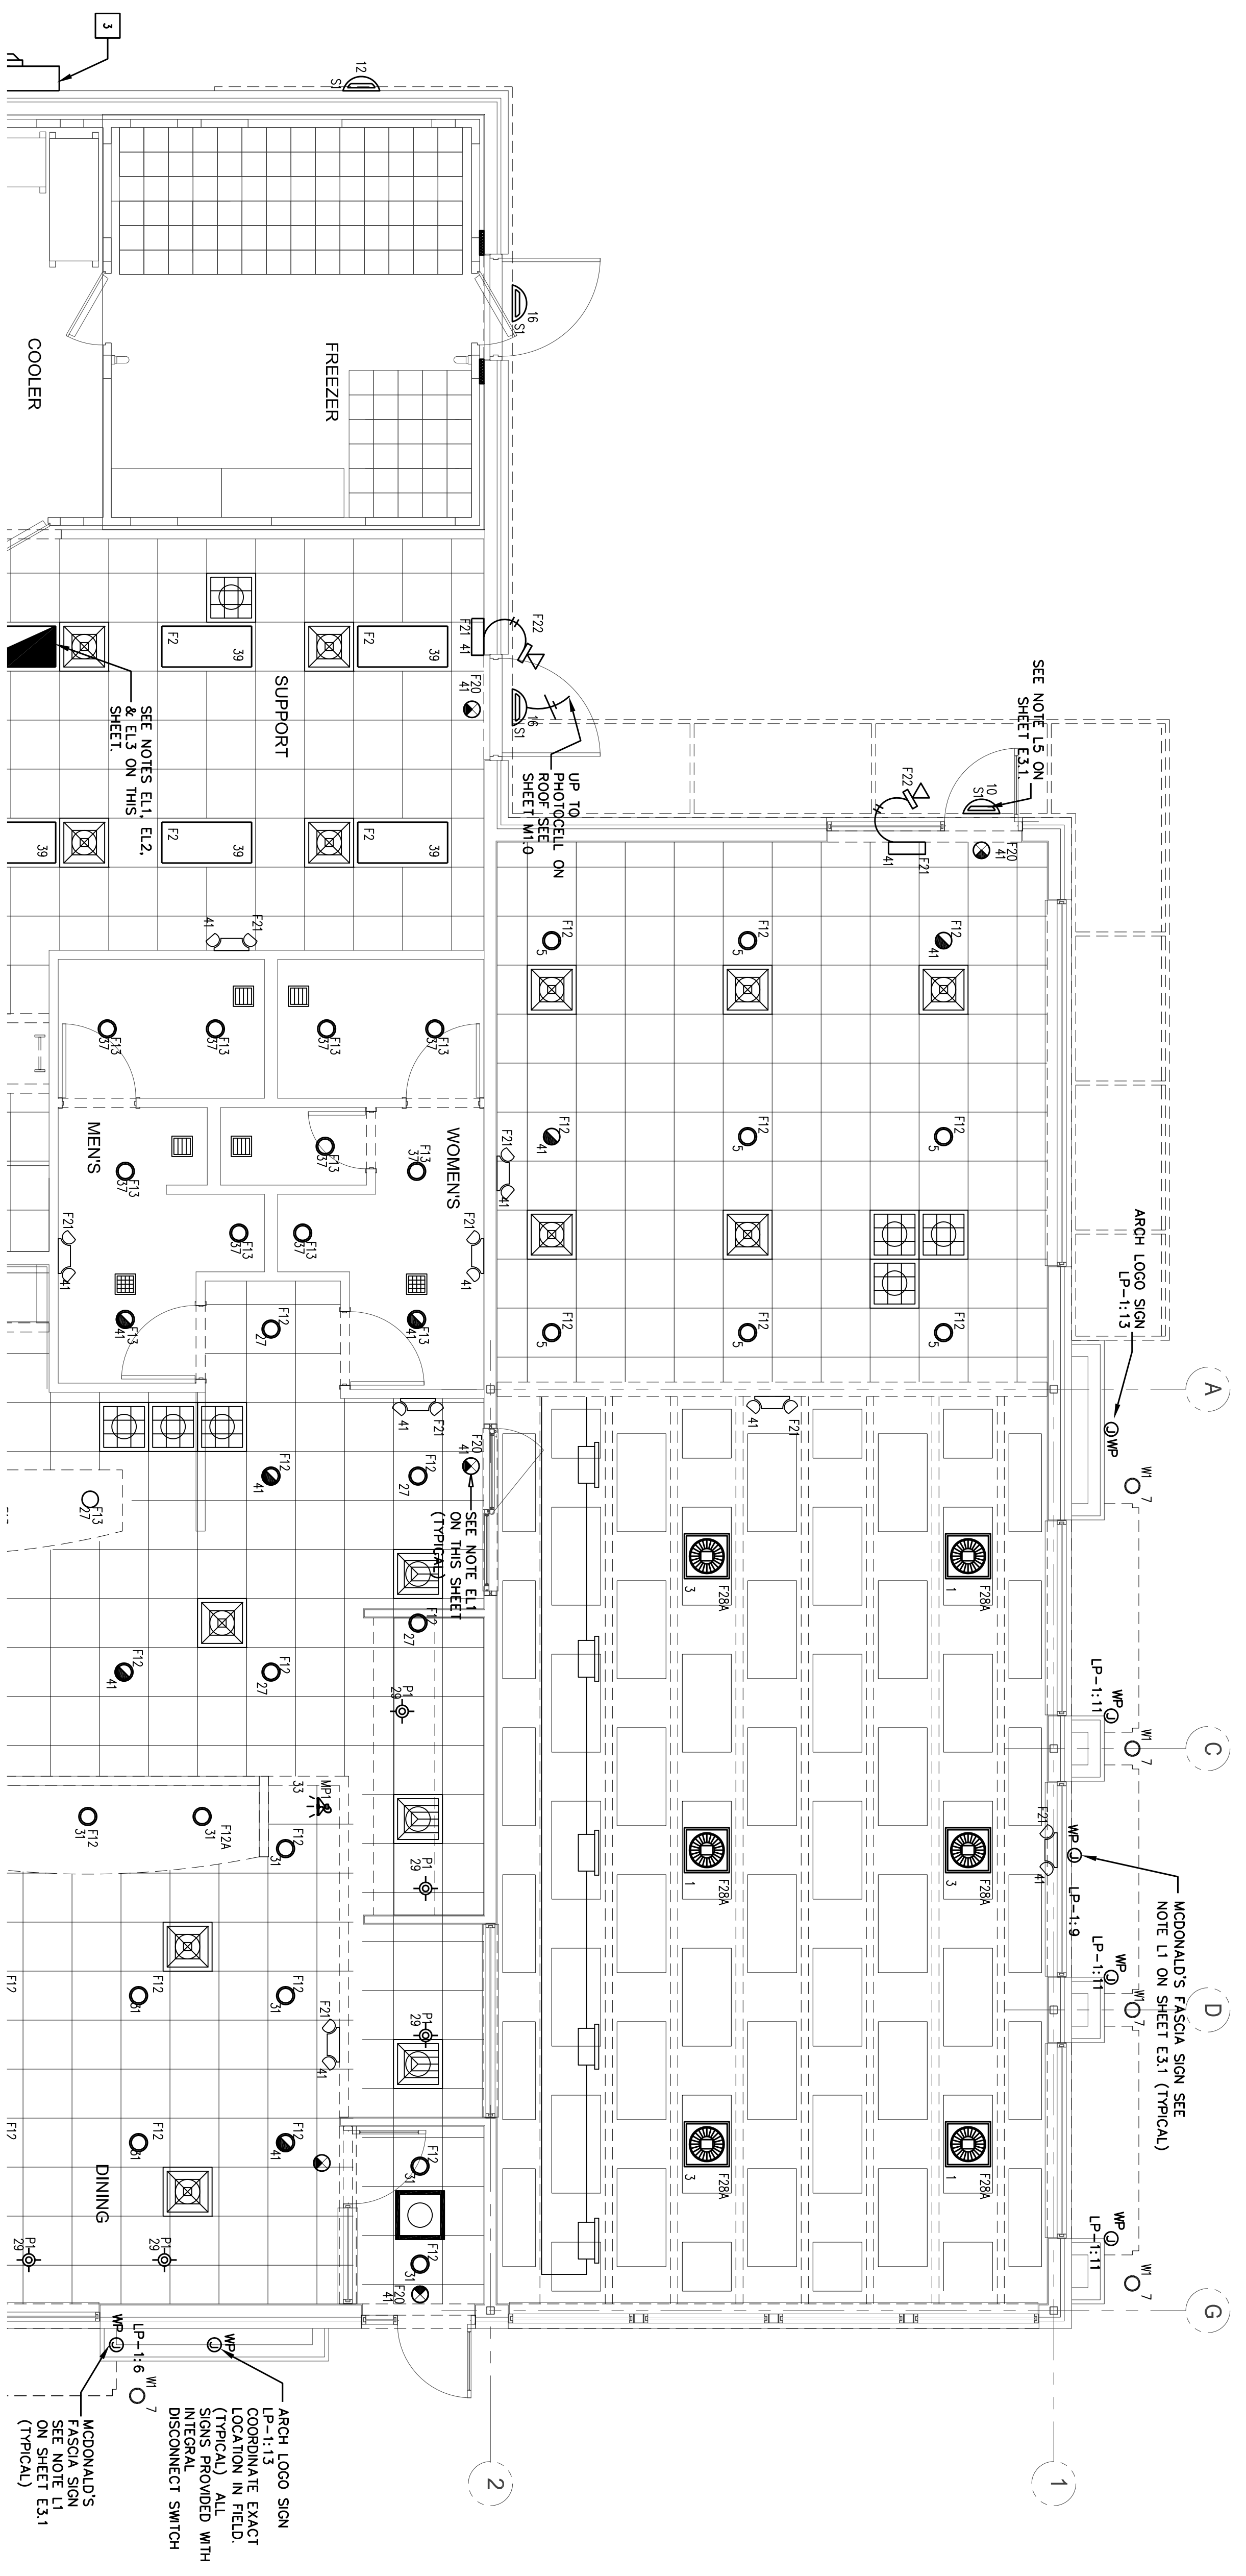

1 LIGHTING FLOOR PLAN
1/4"=1'-0"

RESTAURANT LOCATION:
1332 US ROUTE 302
PORTLAND, ME

PREPARED FOR:
McDonald's USA, LLC
McDONALD'S PLAZA
OAK BROOK, ILLINOIS
60521

SHEET NUMBER:
E2.1

SHEET TITLE:
LIGHTING PLAN

CONSULTANT:
EA
ENGINEERING ADVANTAGE, INC.
2 PARK ST.
BOSTON, MASSACHUSETTS 02122
PHONE: (617) 288-3969
FAX: (617) 825-8922

Landry ARCHITECTS
389 Main Street - Salem, MA 03079
T 603.890.6414 F 603.894.4358

DRAWN BY: CJC DATE ISSUED: 08/14/07
CHECKED BY: LAF SCALE: AS NOTED
DATE DRAWN: 04/17/07 JOB NUMBER: M-1035

REVISIONS		
NO.	DATE	BY
1		
2		
3		
4		
5		
6		
7		