

REVISION	DESCRIPTION	DATE
0	ISSUED FOR REVIEW & APPROVAL	9/3/2014

RESERVED FOR CITY STAMP

CUNNINGHAM

Security Systems


10 Princes Point Road, Yarmouth, Maine 04096
Office: 207.846.3350 • Fax: 207.846.6080

**MAINE ORTHOTIC LAB
CORNER OF ST. JOHN STREET & PARK AVENUE
PORTLAND, MAINE
FIRST FLOOR FIRE ALARM PLAN**

DRAWN	JPB UNICAD JOB #14518
CHECKED	WAYNE B. HAWES NCET # 90496
DATE	9/3/2014
REVISION	0
SCALE	1/8"=1'-0"

UNICAD Inc.
Fire Alarm Design & Drafting Services
www.unicad.net
578 W. 40th St.
Portland, ME 04102
Office: 501.865.6410

FA-2

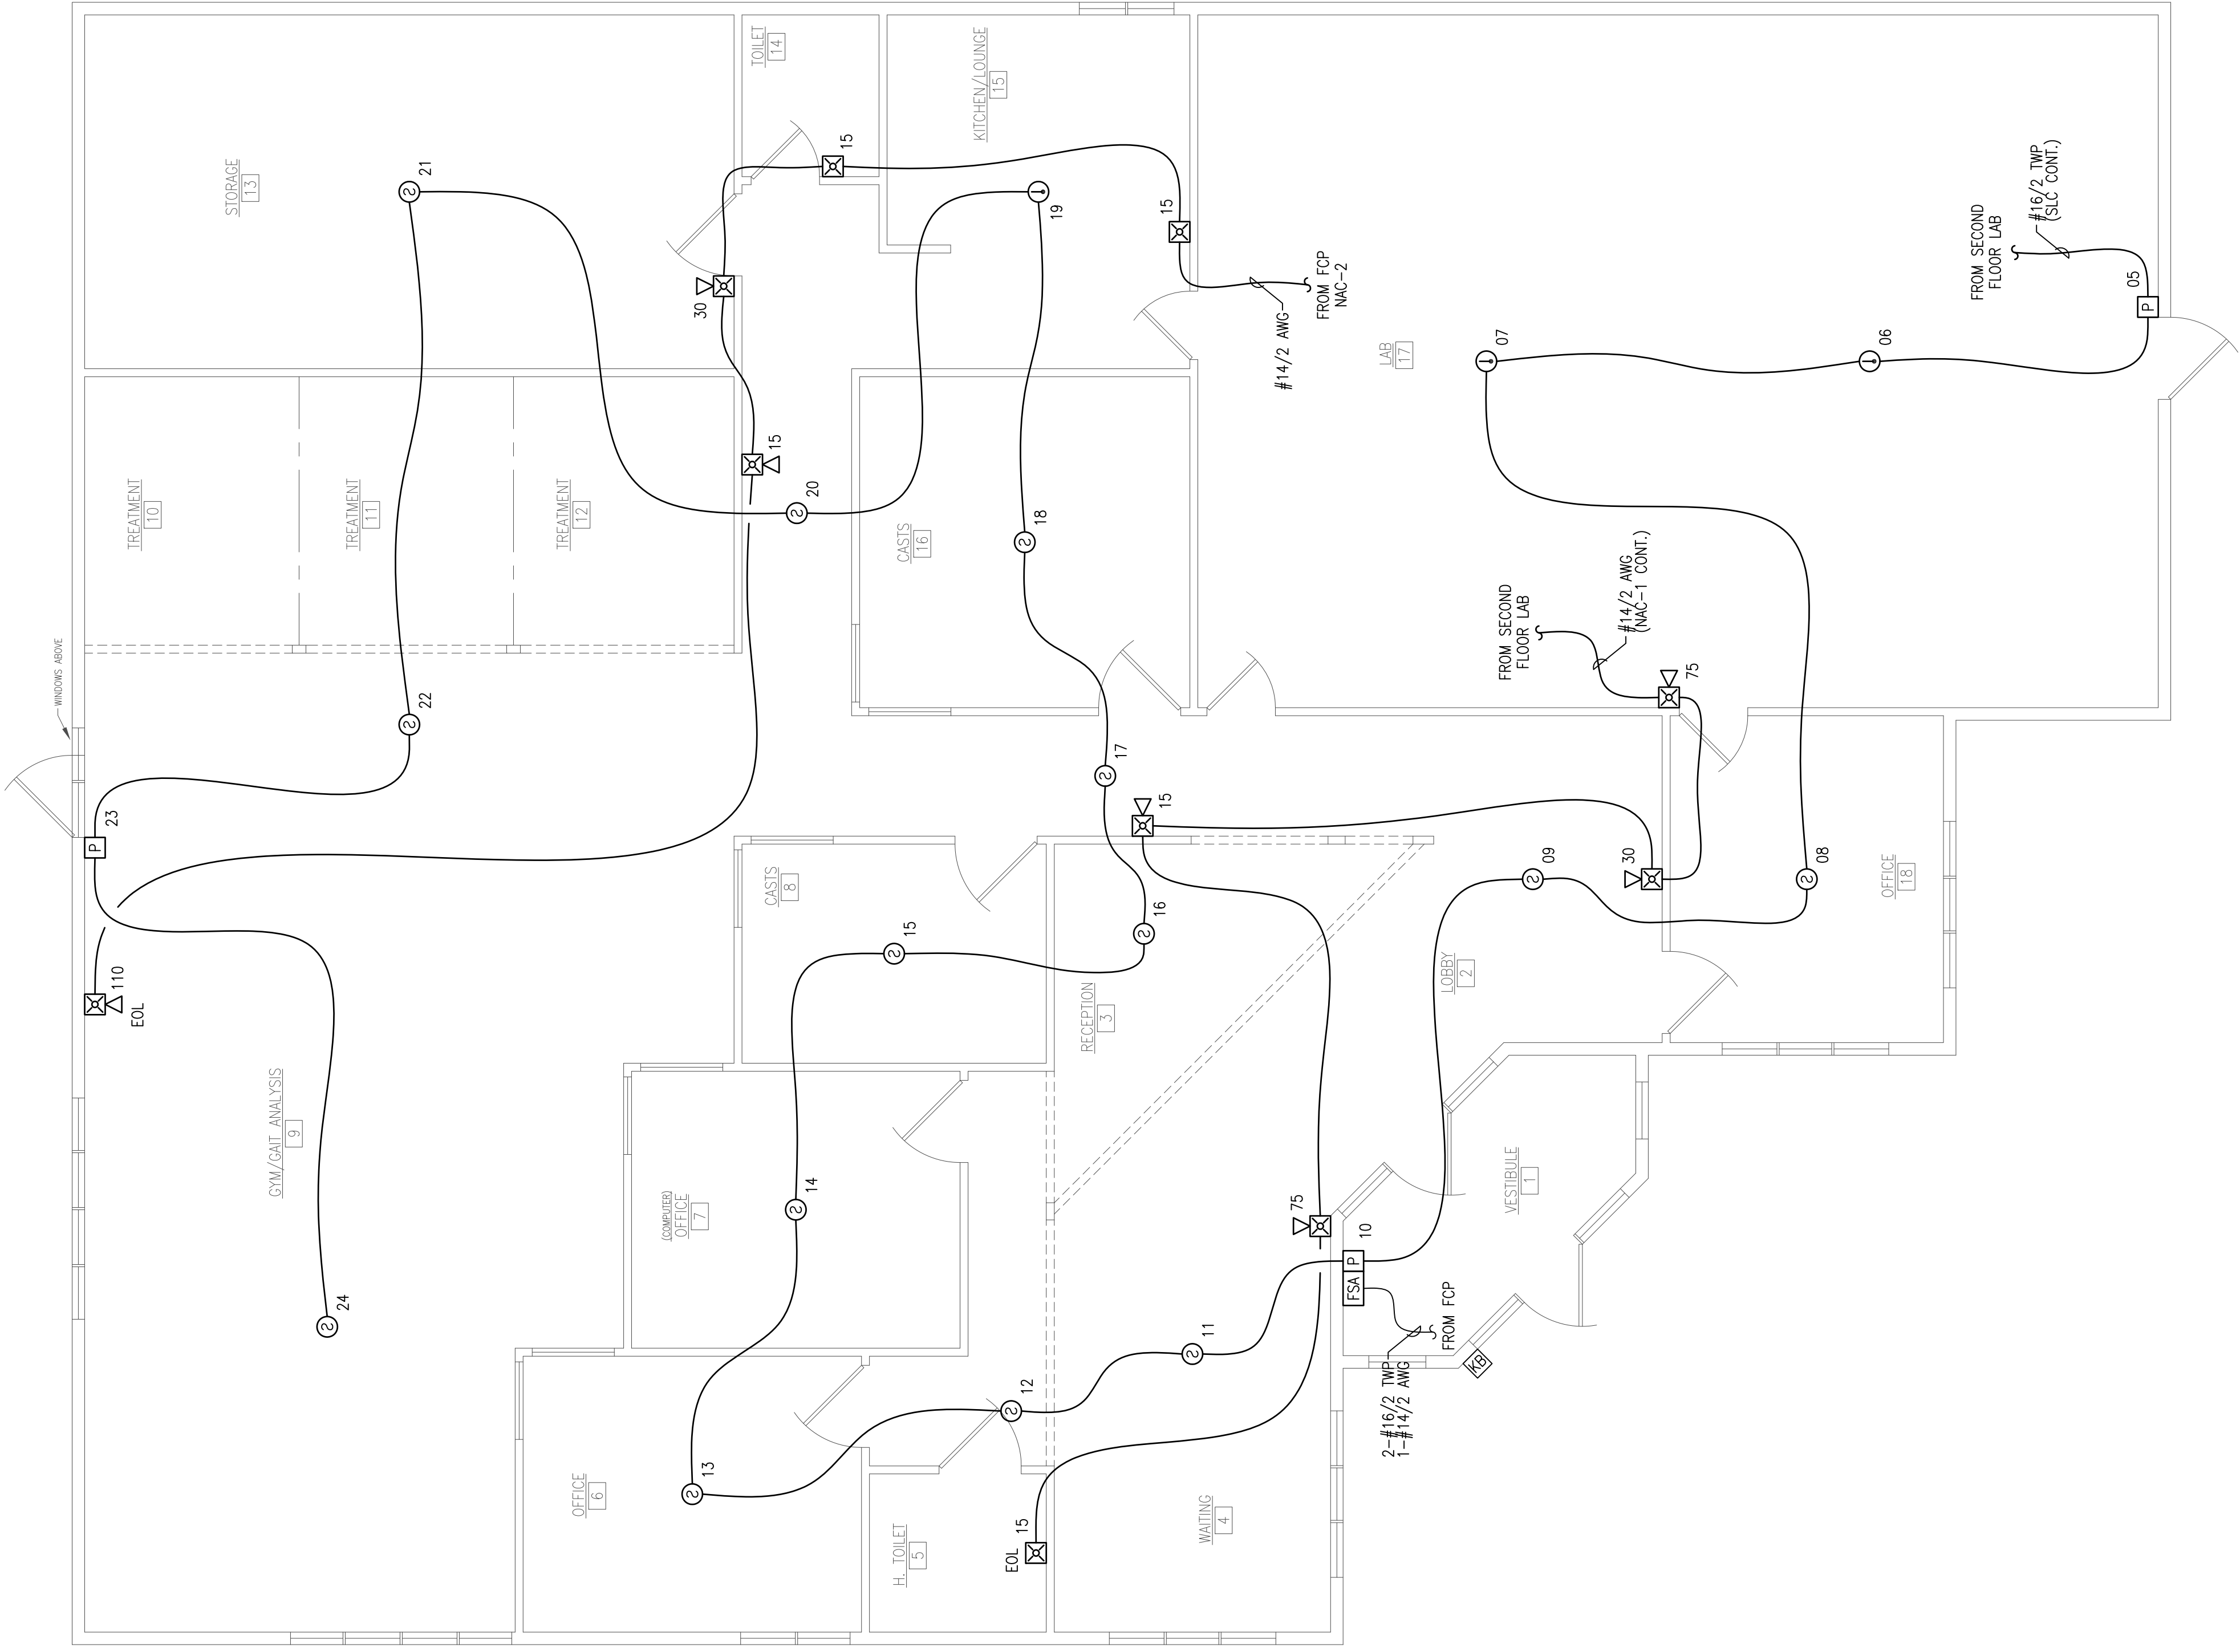

FIRST FLOOR FIRE ALARM PLAN
SCALE: 1/8"=1'-0"

