

REVISION	0	ISSUED FOR REVIEW & APPROVAL	9/3/2014
DESCRIPTION			
DATE			

RESERVED FOR CITY STAMP

CUNNINGHAM


Security Systems

10 Princes Point Road, Yarmouth, Maine 04096
Office: 207.846.3350 • Fax: 207.846.6080

MAINE ORTHOTIC LAB
CORNER OF ST. JOHN STREET & PARK AVENUE
PORTLAND, MAINE
SECOND FLOOR FIRE ALARM PLAN

DRAWN	JPB	UNICAD JOB #14518
CHECKED	WAYNE B. HAWES	NCET # 90496
DATE	9/3/2014	
REVISION	0	
SCALE	1/8"=1'-0"	

FA-3

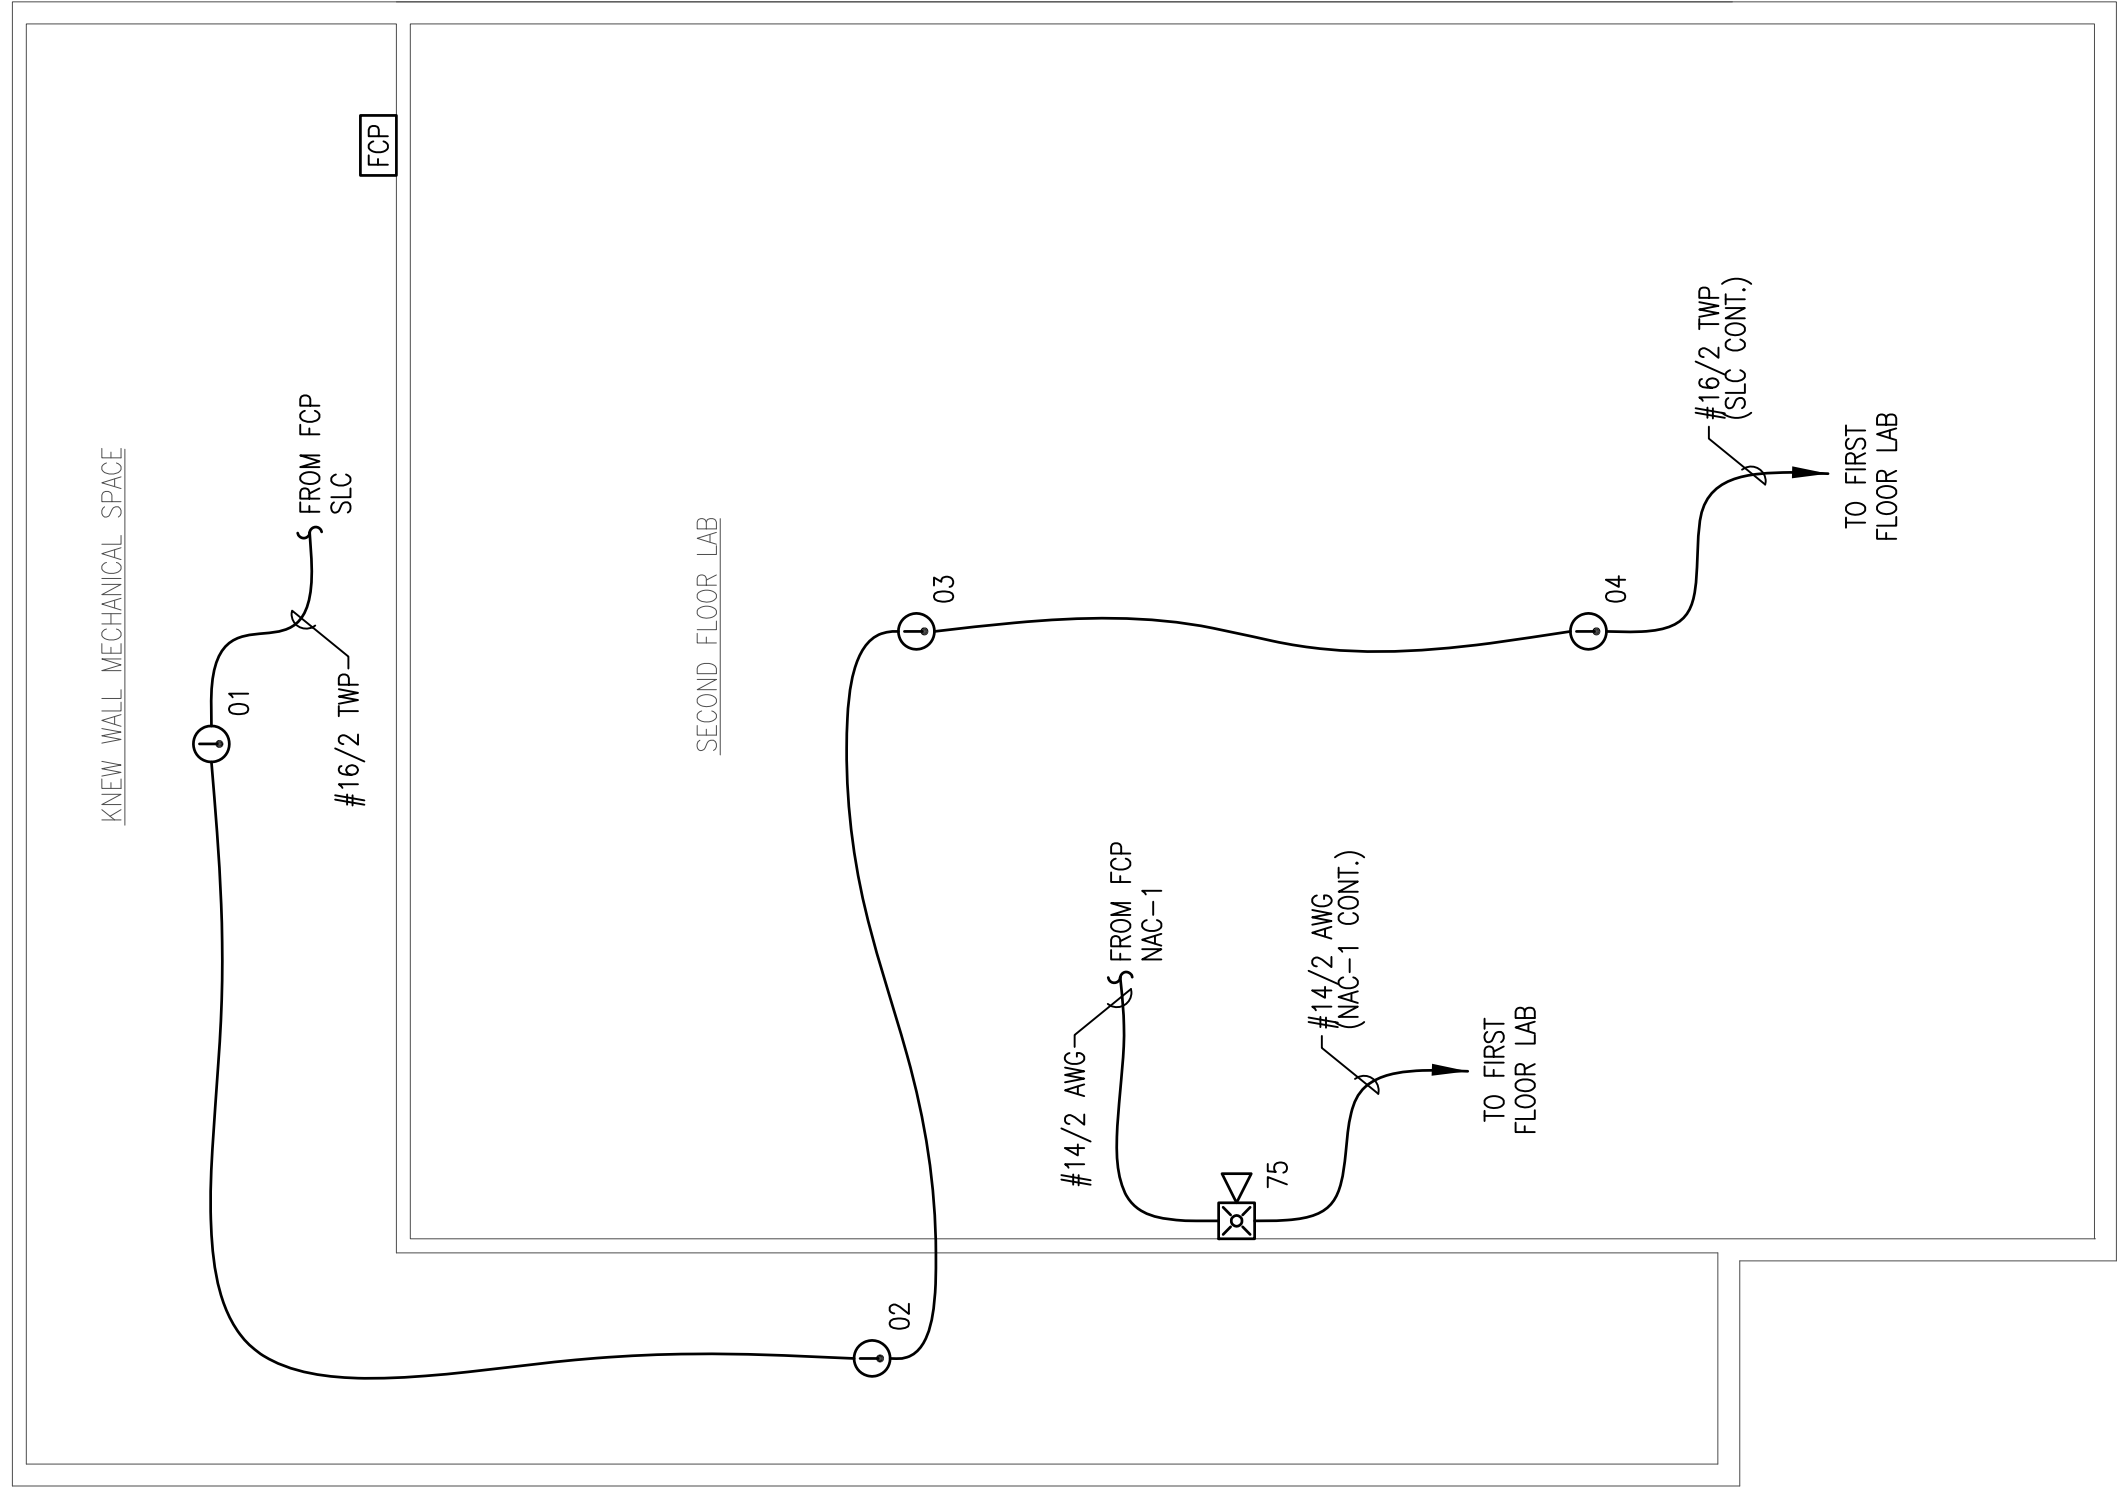

SECOND FLOOR FIRE ALARM PLAN
SCALE: 1/8"=1'-0"