



**2** FIRST FLOOR PLAN
   
 A.1 SCALE: 1/8" = 1'-0"

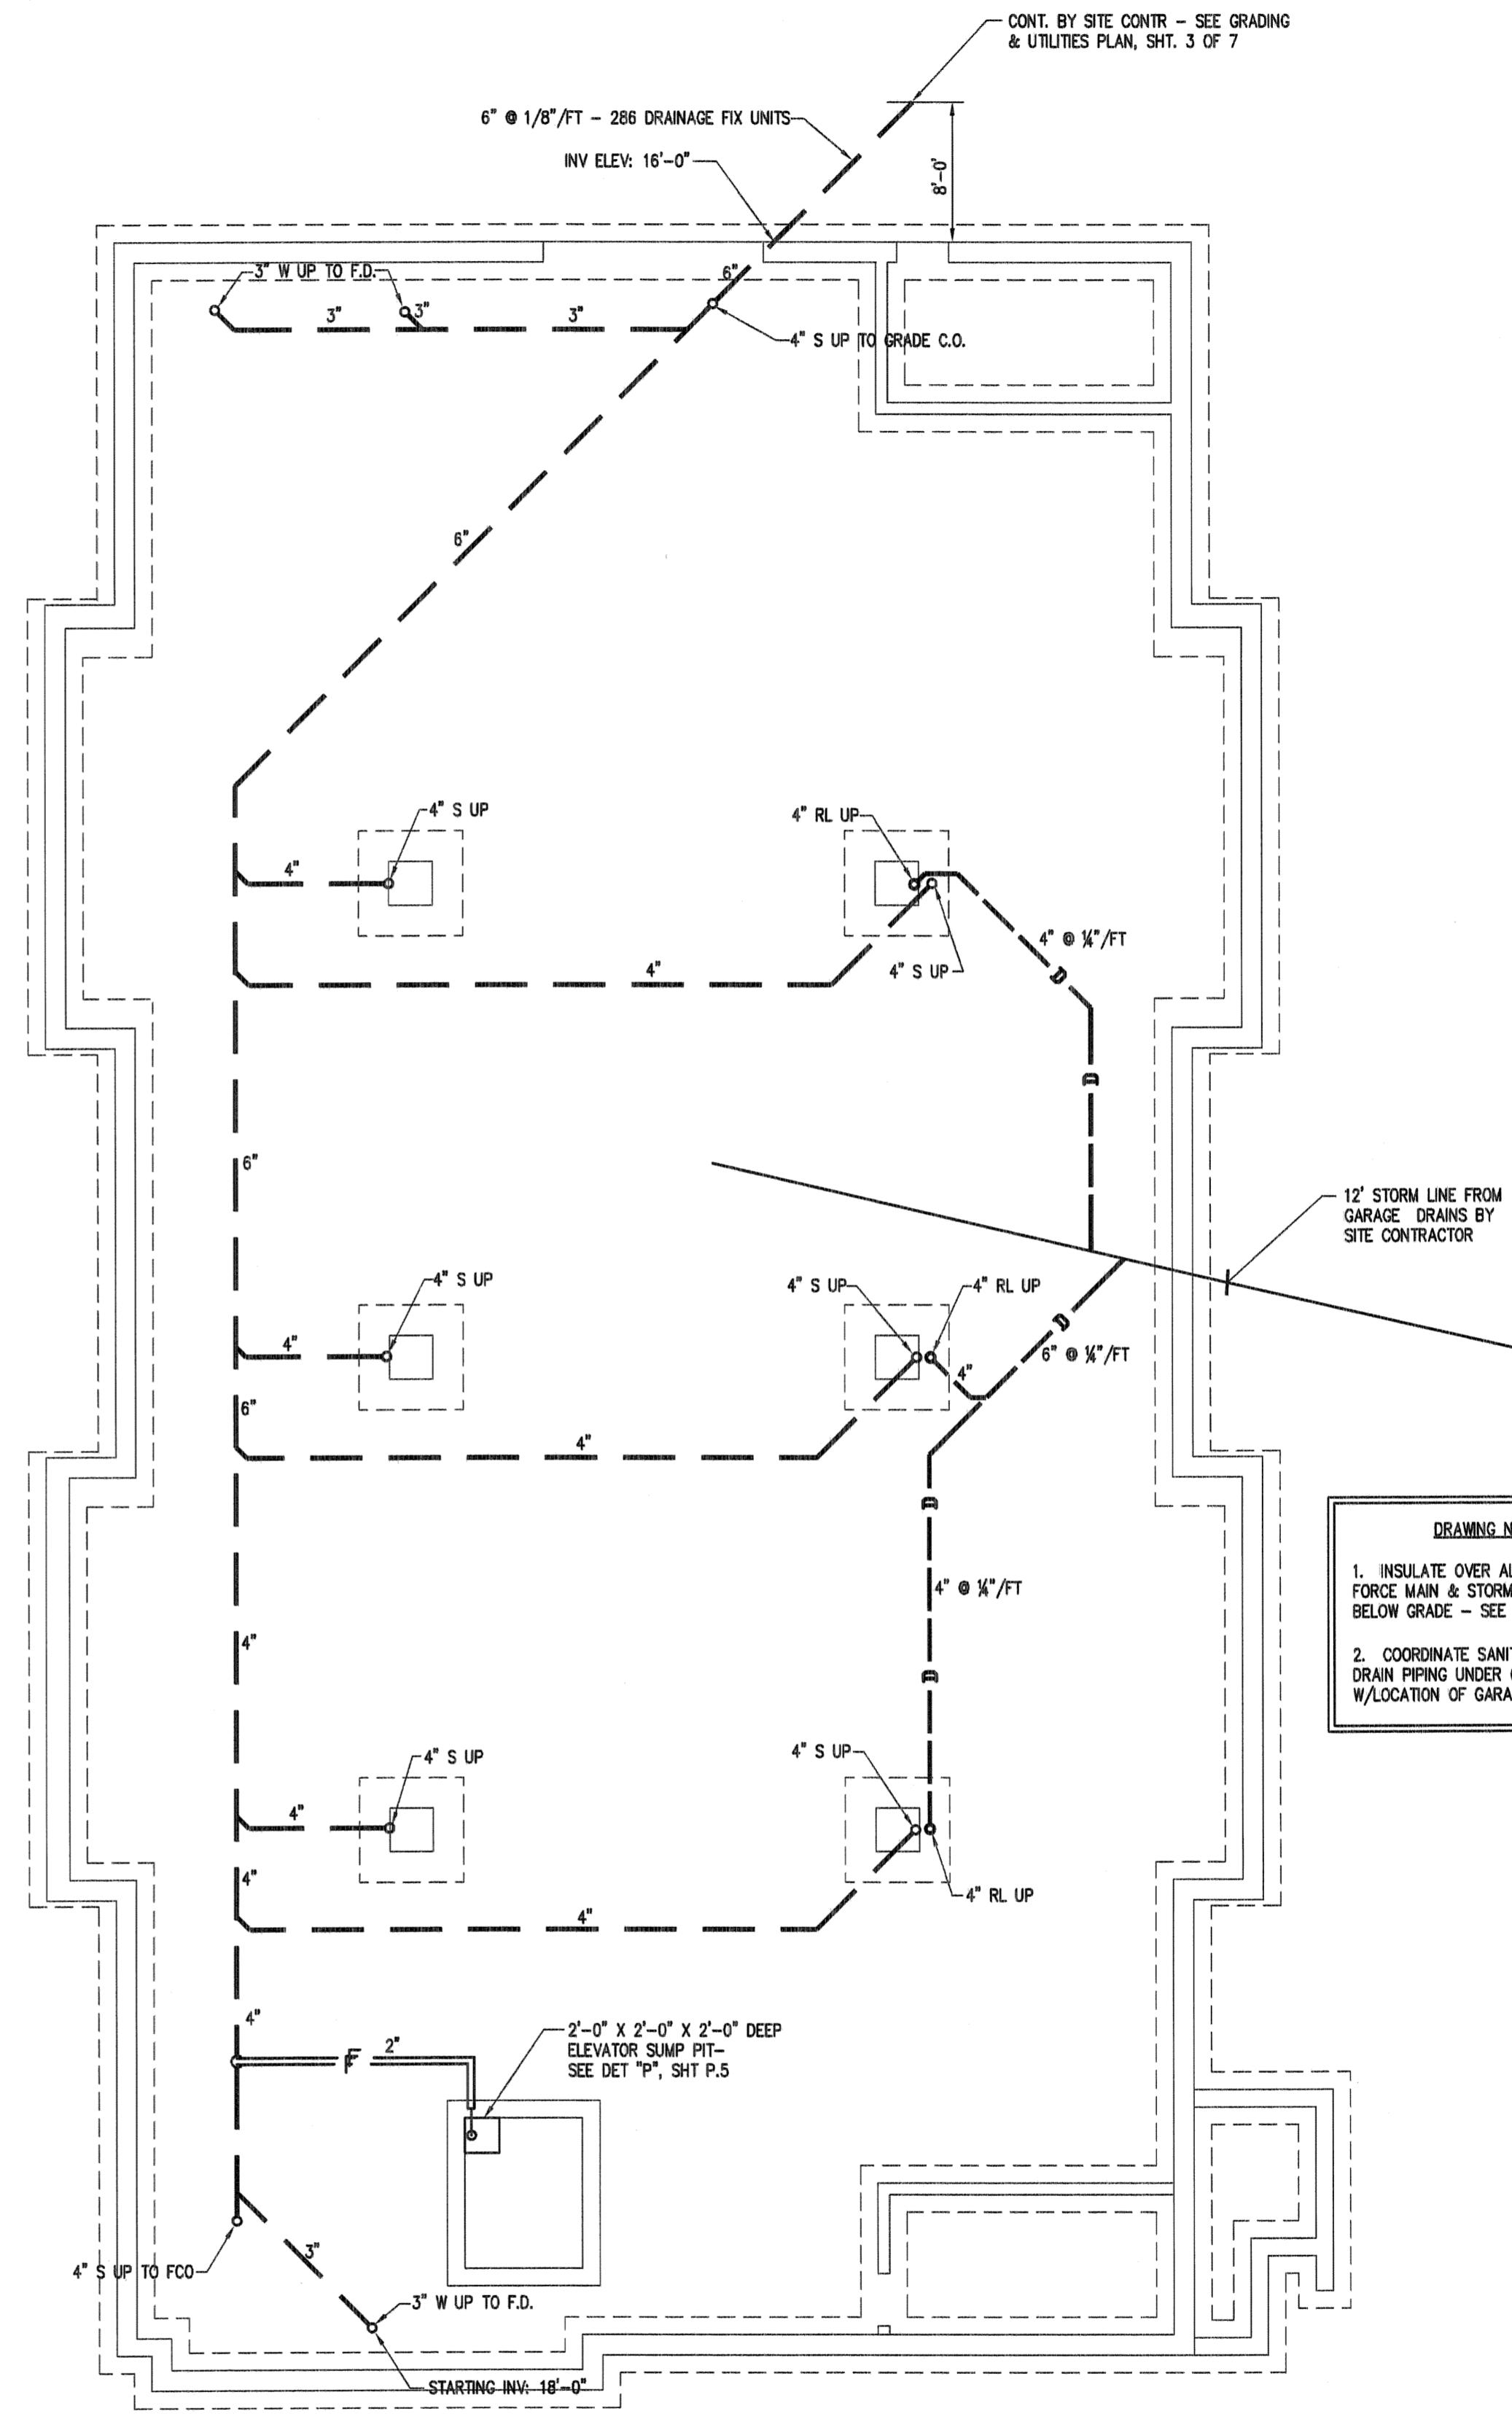

- DRAWING NOTES:**
- INSULATE OVER ALL SANITARY, FORCE MAIN & STORM DRAIN PIPING BELOW GRADE - SEE DET 'K', SH1 P.5
  - COORDINATE SANITARY & STORM DRAIN PIPING UNDER GARAGE PAVEMENT W/LOCATION OF GARAGE DRAINS.

**1** FOUNDATION PLAN
   
 A.1 SCALE: 1/8" = 1'-0"

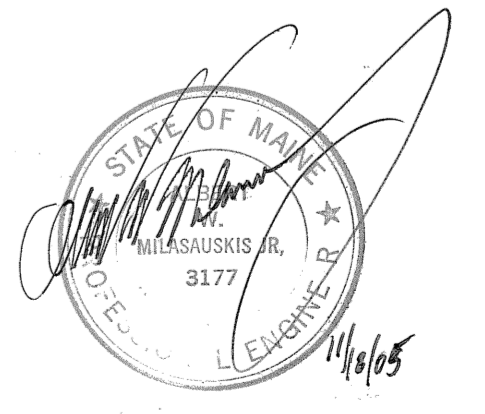

**FOR BIDDING**
  
**11/18/05**

NOTE: WORK SHOWN ON THIS DETAIL TO BE PERFORMED UNDER SECTION 13940 OF THE CONTRACT.

**R SPRINKLER RISER**
  
 P.2 NO SCALE