



3 THIRD FLOOR PLAN  
 A.1 SCALE: 1/8" = 1'-0"

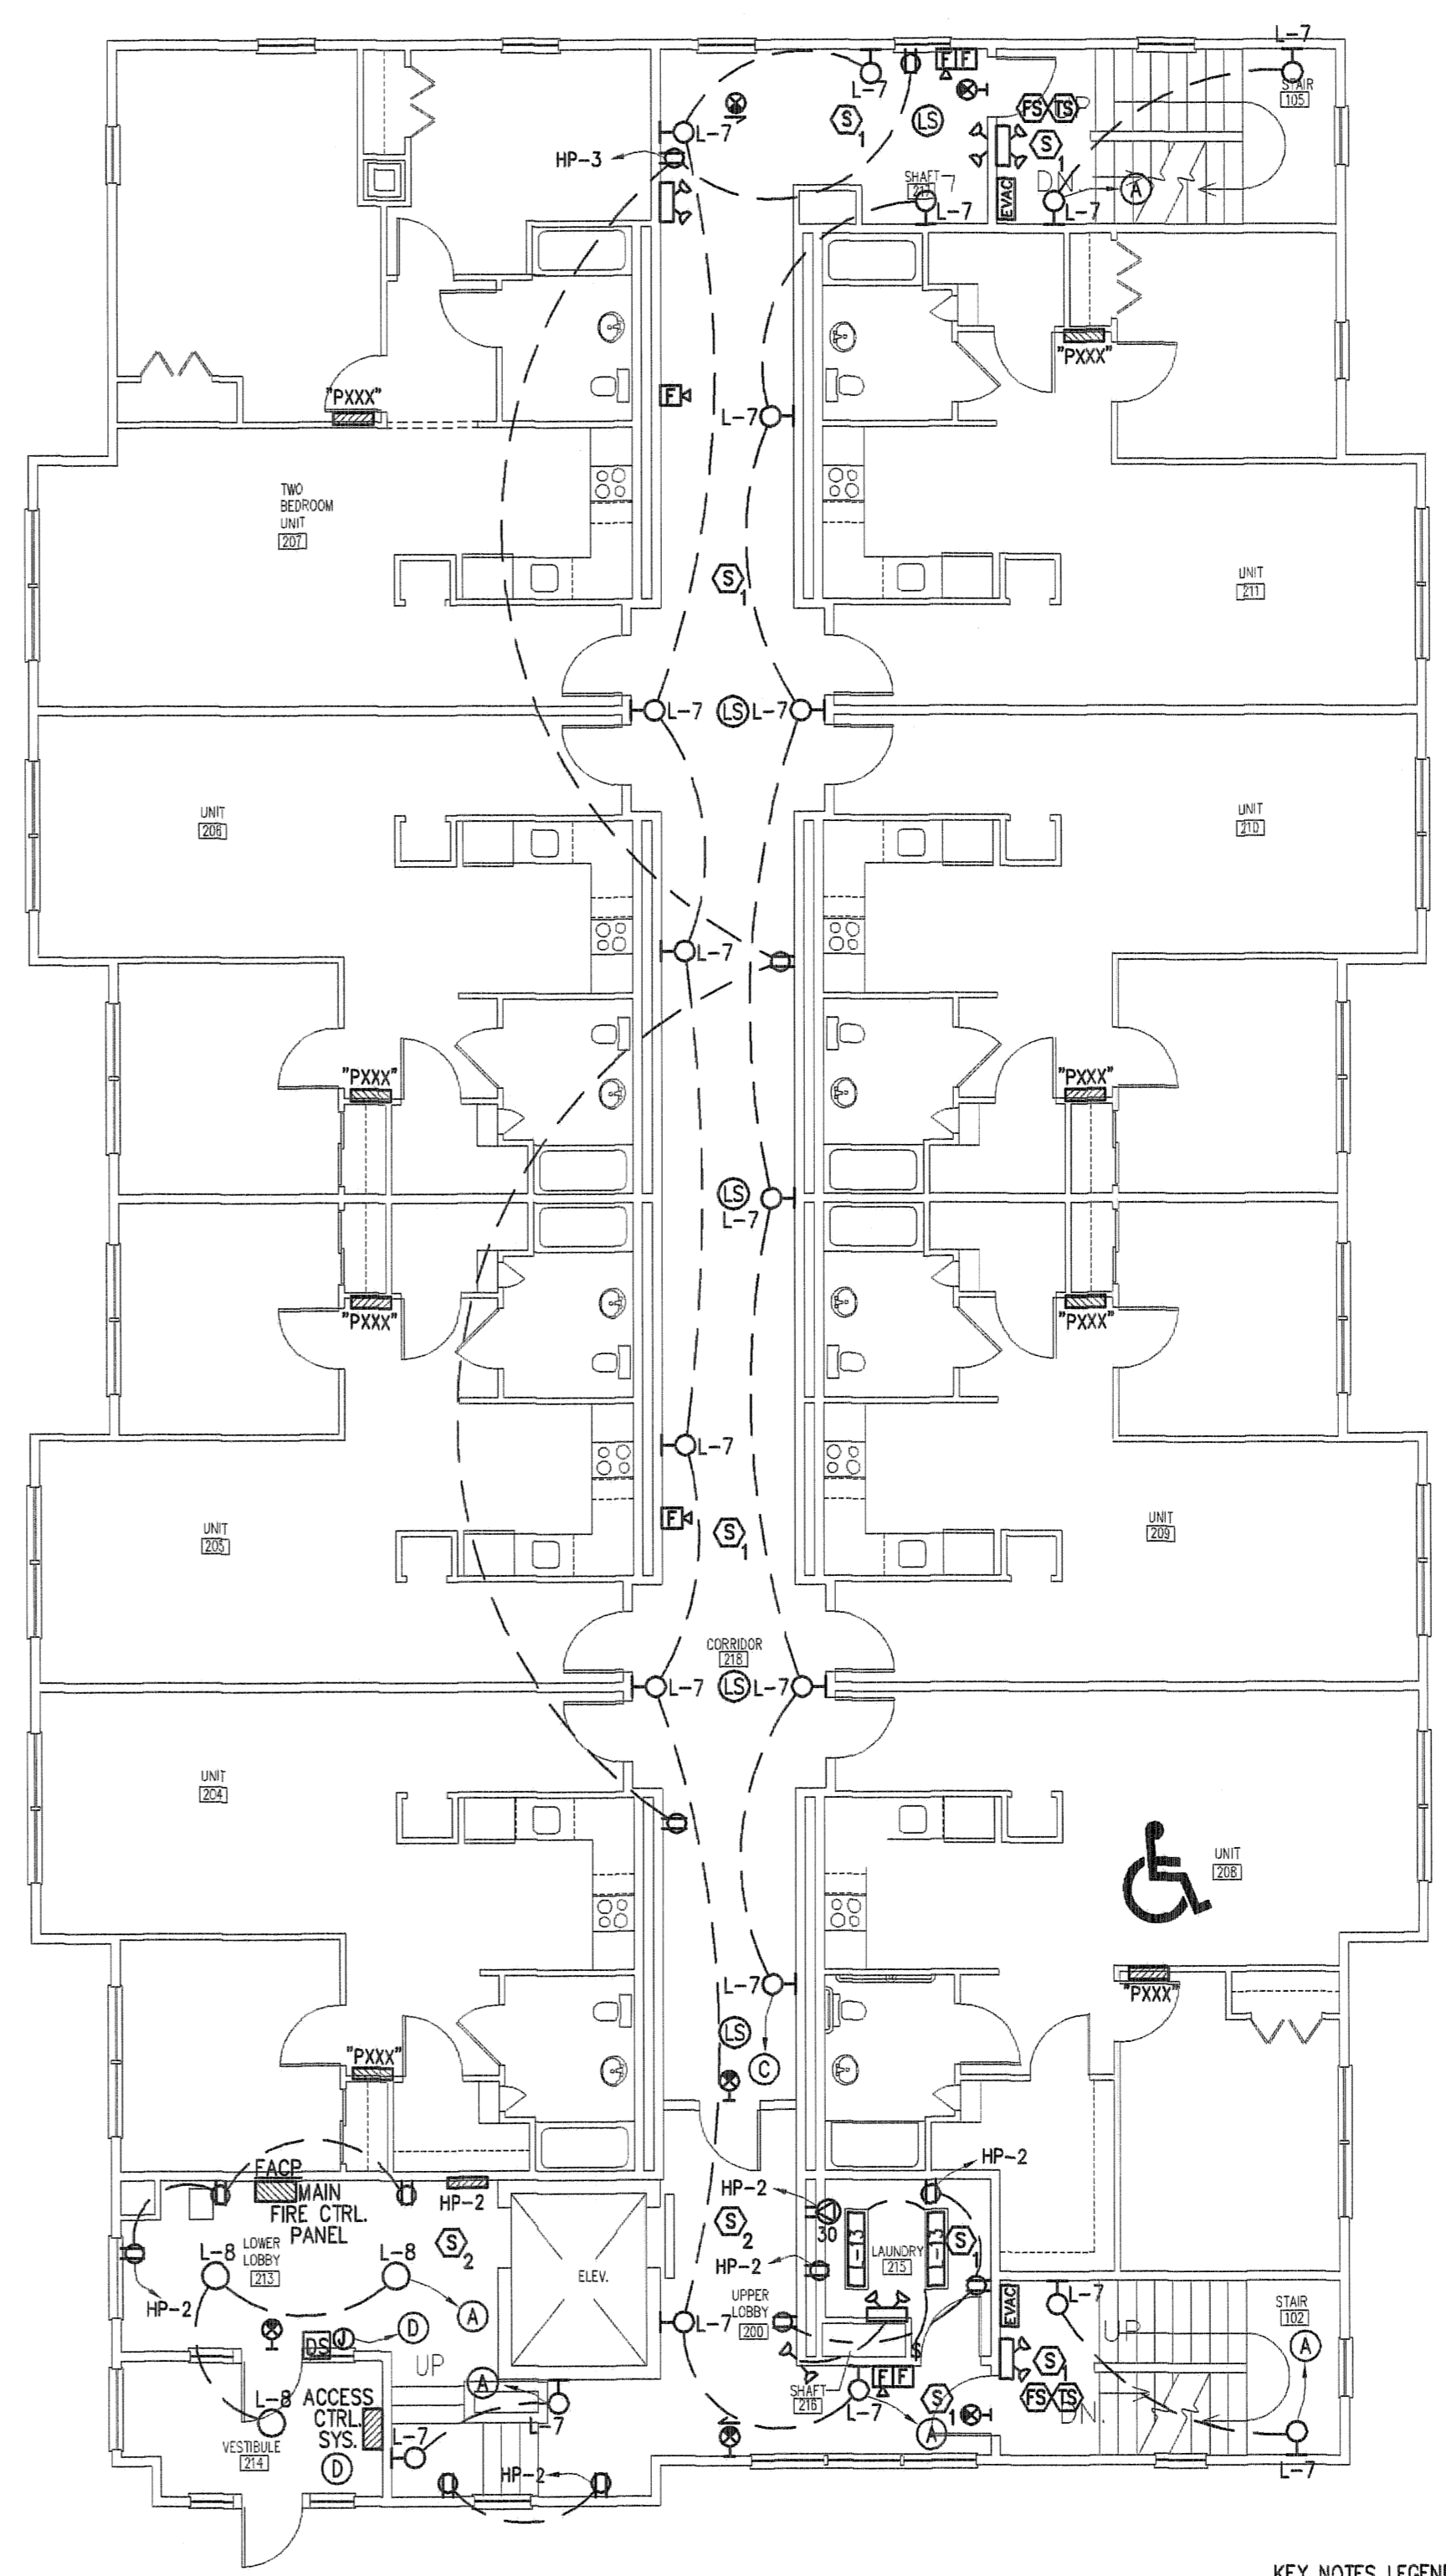

2 SECOND FLOOR PLAN  
 A.1 SCALE: 1/8" = 1'-0"

- KEY NOTES LEGEND:**
- (A) TO HOUSE PANEL HP-2 (ALWAYS ON) LIGHT CIRCUIT
  - (B) TO SWITCH CIRCUIT FROM HOUSE PANEL HP-2
  - (C) CONTROLLED BY OCCUPANCY SENSORS "INSIGHT TYPE OSC" BY LIGHTOLIER COMPLETE WITH POWER PACK, CEILING SENSORS AND REMOTE SWITCH
  - (D) PROVIDE COMPLETE ACCESS SYSTEM TO ENTRANCE DOOR LOCK FOR LOBBY DOOR. EQUAL TO SILENT NIGHT SECURITY SYSTEM. THE NEW CALL ENTRY SYSTEM SHALL BE COMPLETE WITH COMMUNICATION TO EACH APARTMENT, CODE ENTRY IDENTIFICATION, DEDICATED CONNECTIONS, CONTROL POWER, DOOR STRIKE ACCESSORIES AND HARDWARE COMPLETE AS REQUIRED.

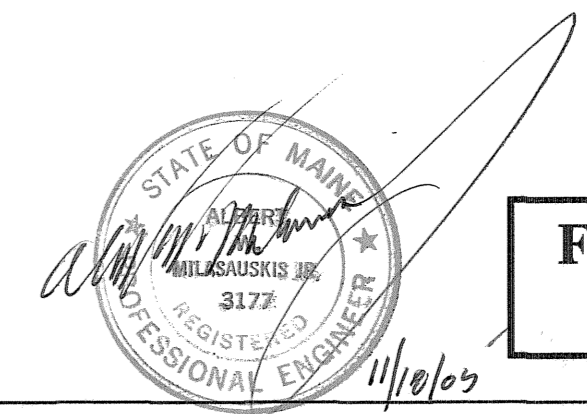

**FOR BIDDING**  
 11/18/05