



2 ROOF PLAN
 A.2 SCALE: 1/8" = 1'-0"

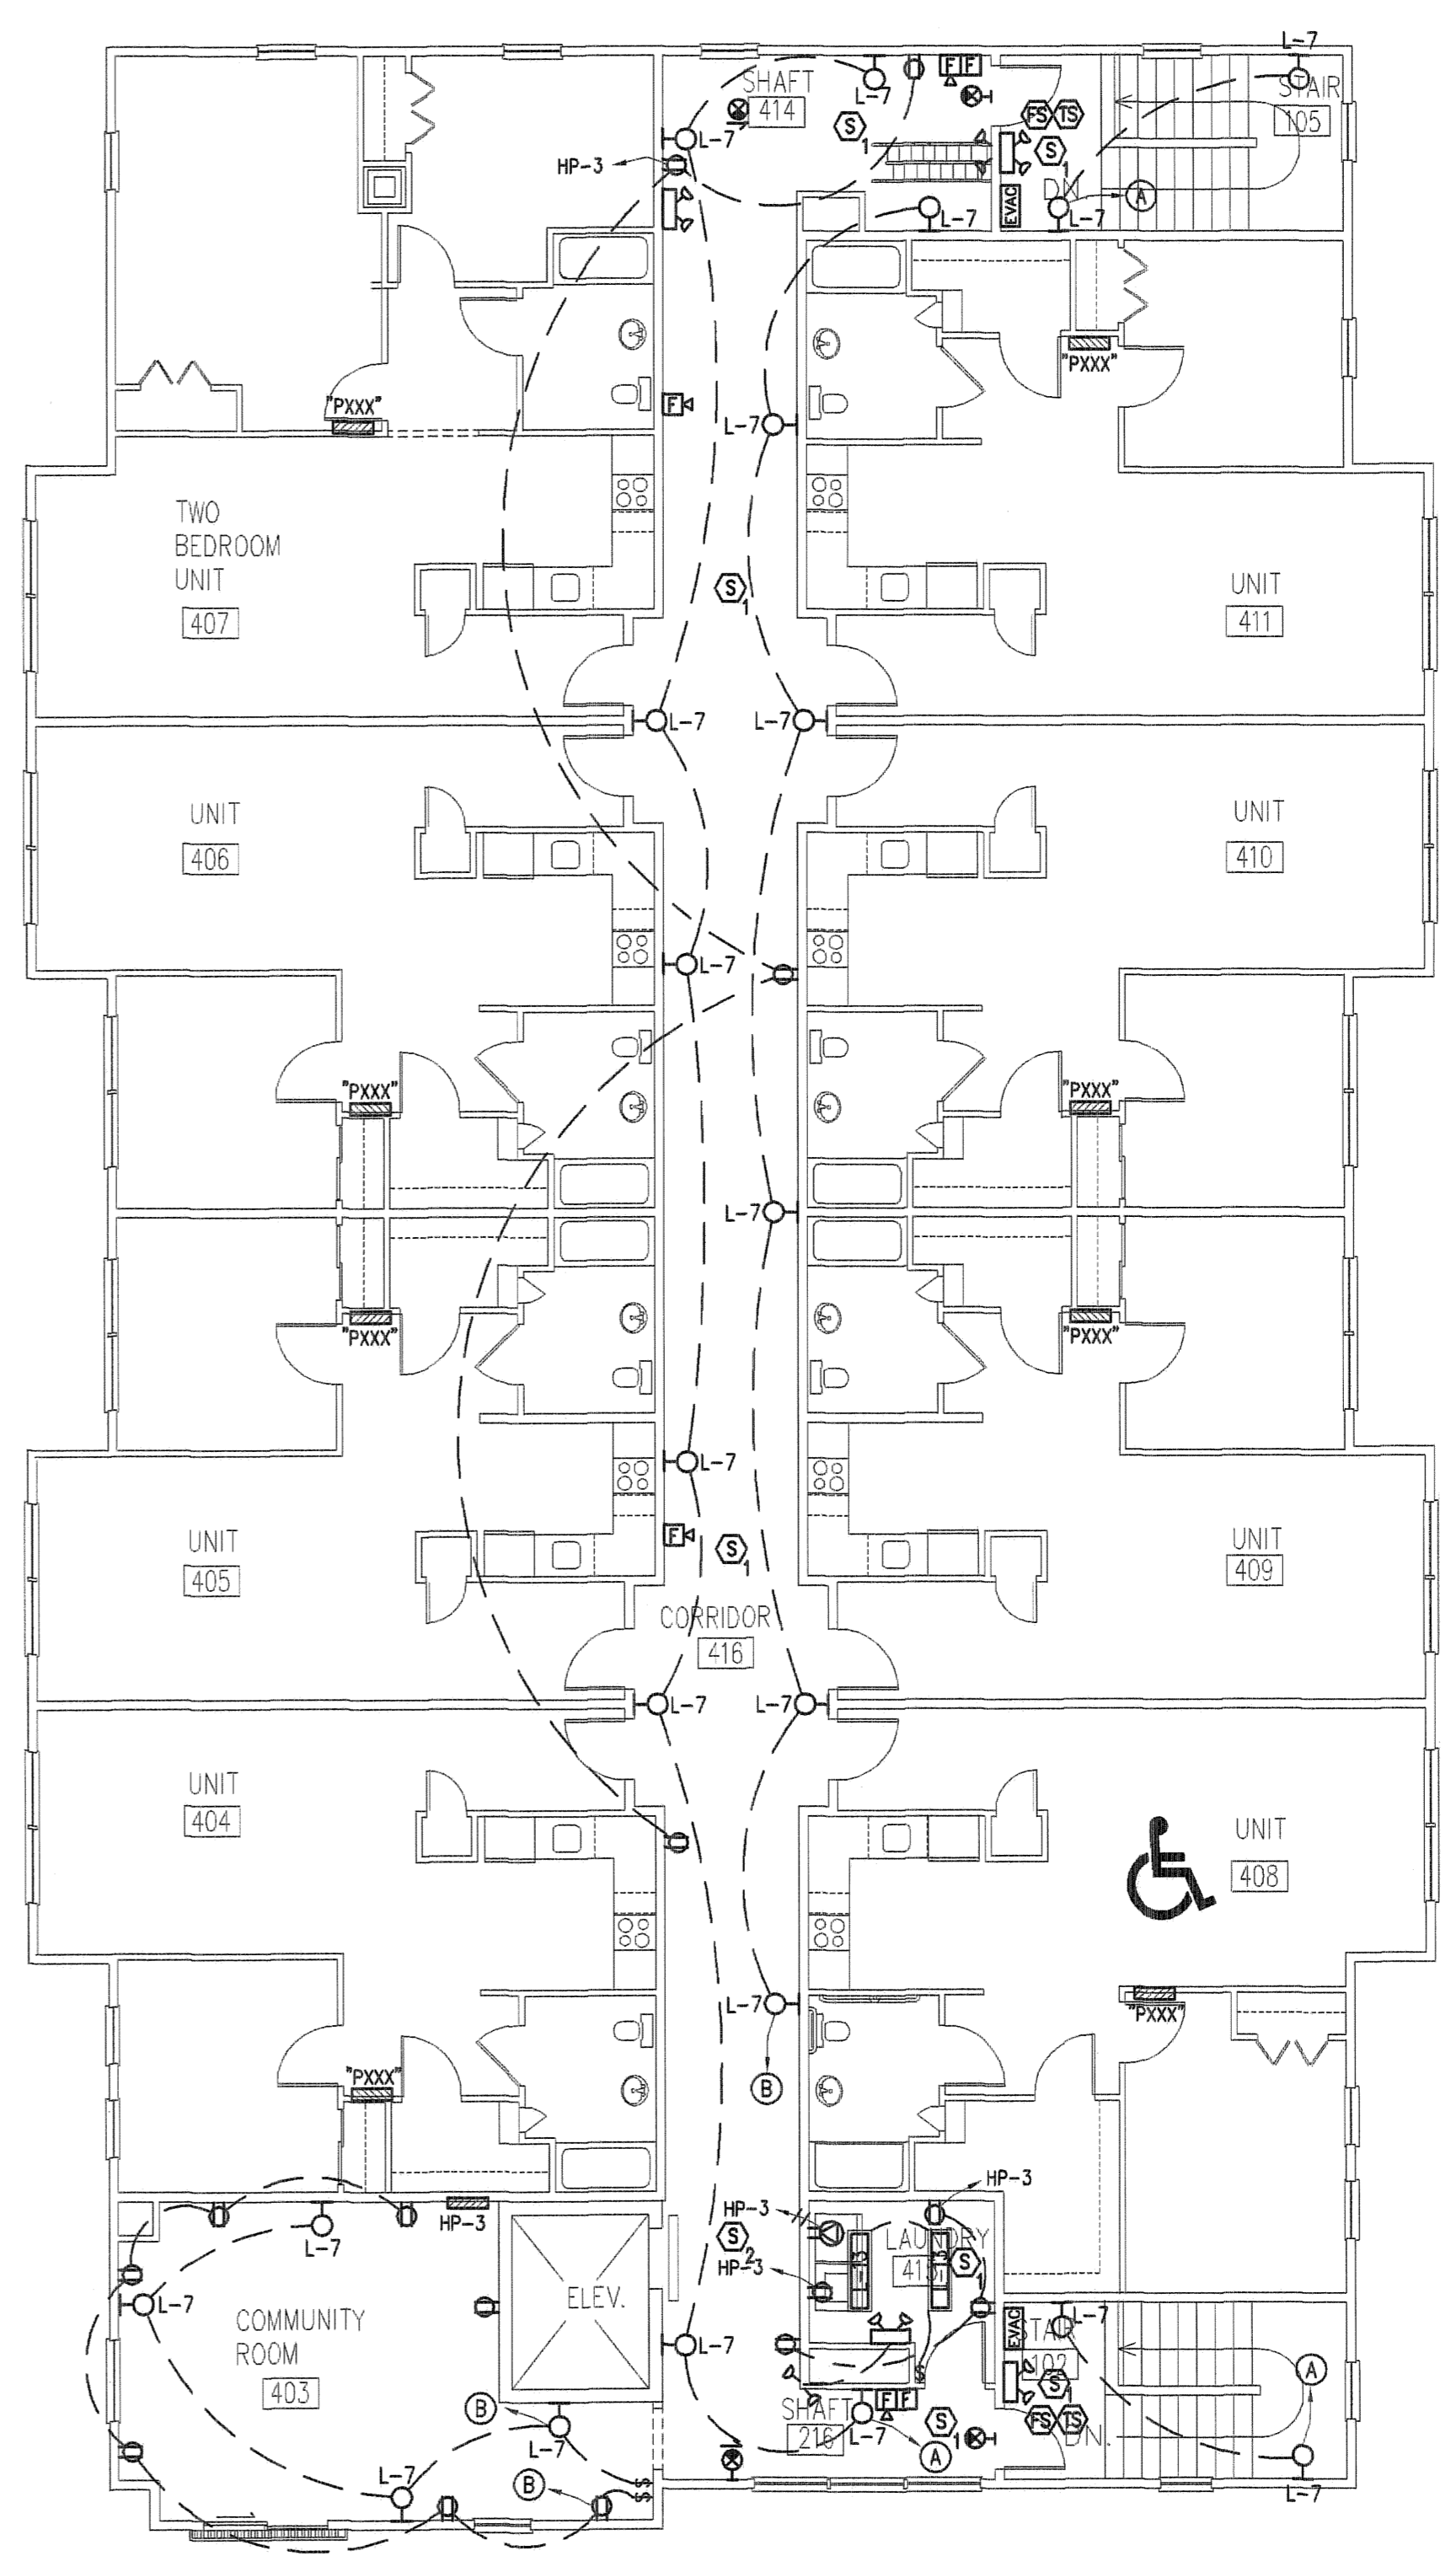

1 FOURTH FLOOR PLAN
 A.2 SCALE: 1/8" = 1'-0"

- KEY NOTES LEGEND:
- (A) TO HOUSE PANEL HP-3 (ALWAYS ON) LIGHT CIRCUIT
 - (B) TO SWITCH CIRCUIT FROM HOUSE PANEL HP-3
 - (C) CONTROLLED BY OCCUPANCY SENSORS "INSIGHT TYPE OSC" BY LIGHTOLIER COMPLETE WITH POWER PACK, CEILING SENSORS AND REMOTE SWITCH

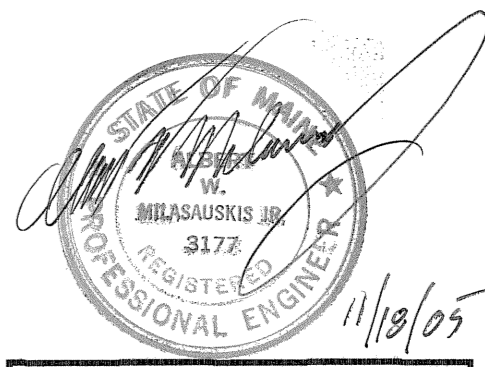

FOR BIDDING
 11/18/05