



PDT ARCHITECTS
 49 DARTMOUTH STREET
 PORTLAND, MAINE 04101
 207-775-0550
 www.pdtarchs.com




Allied Engineering
 Structural Mechanical Electrical Commissioning
 160 Veranda Street
 Portland, Maine 04103
 T: 207.221.2266
 F: 207.221.2266
 Web: www.allied-eng.com

ALLIED PROJECT No.:
 13008
 CAD FILE:
 13008M.DWG

COPYRIGHT
PDT Architects
 Reuse or reproduction of the
 contents of this document is not
 permitted without written
 permission of PDT Architects

TruChoice FCU - 272 Park Avenue
 PORTLAND, MAINE

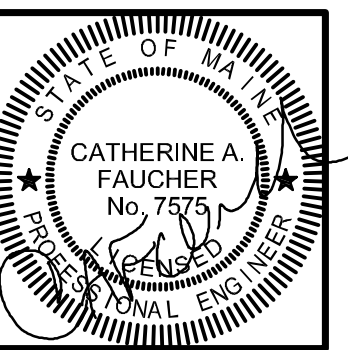

PDT JOB NO.
 12084

DRWN.
 CHK.


SCALE:
 AS NOTED

ISSUE:
 04/26/2013
 CONSTRUCTION
 DOCUMENTS

TITLE
 ELECTRICAL
 PLAN -
 BASEMENT

SHEET

EP100

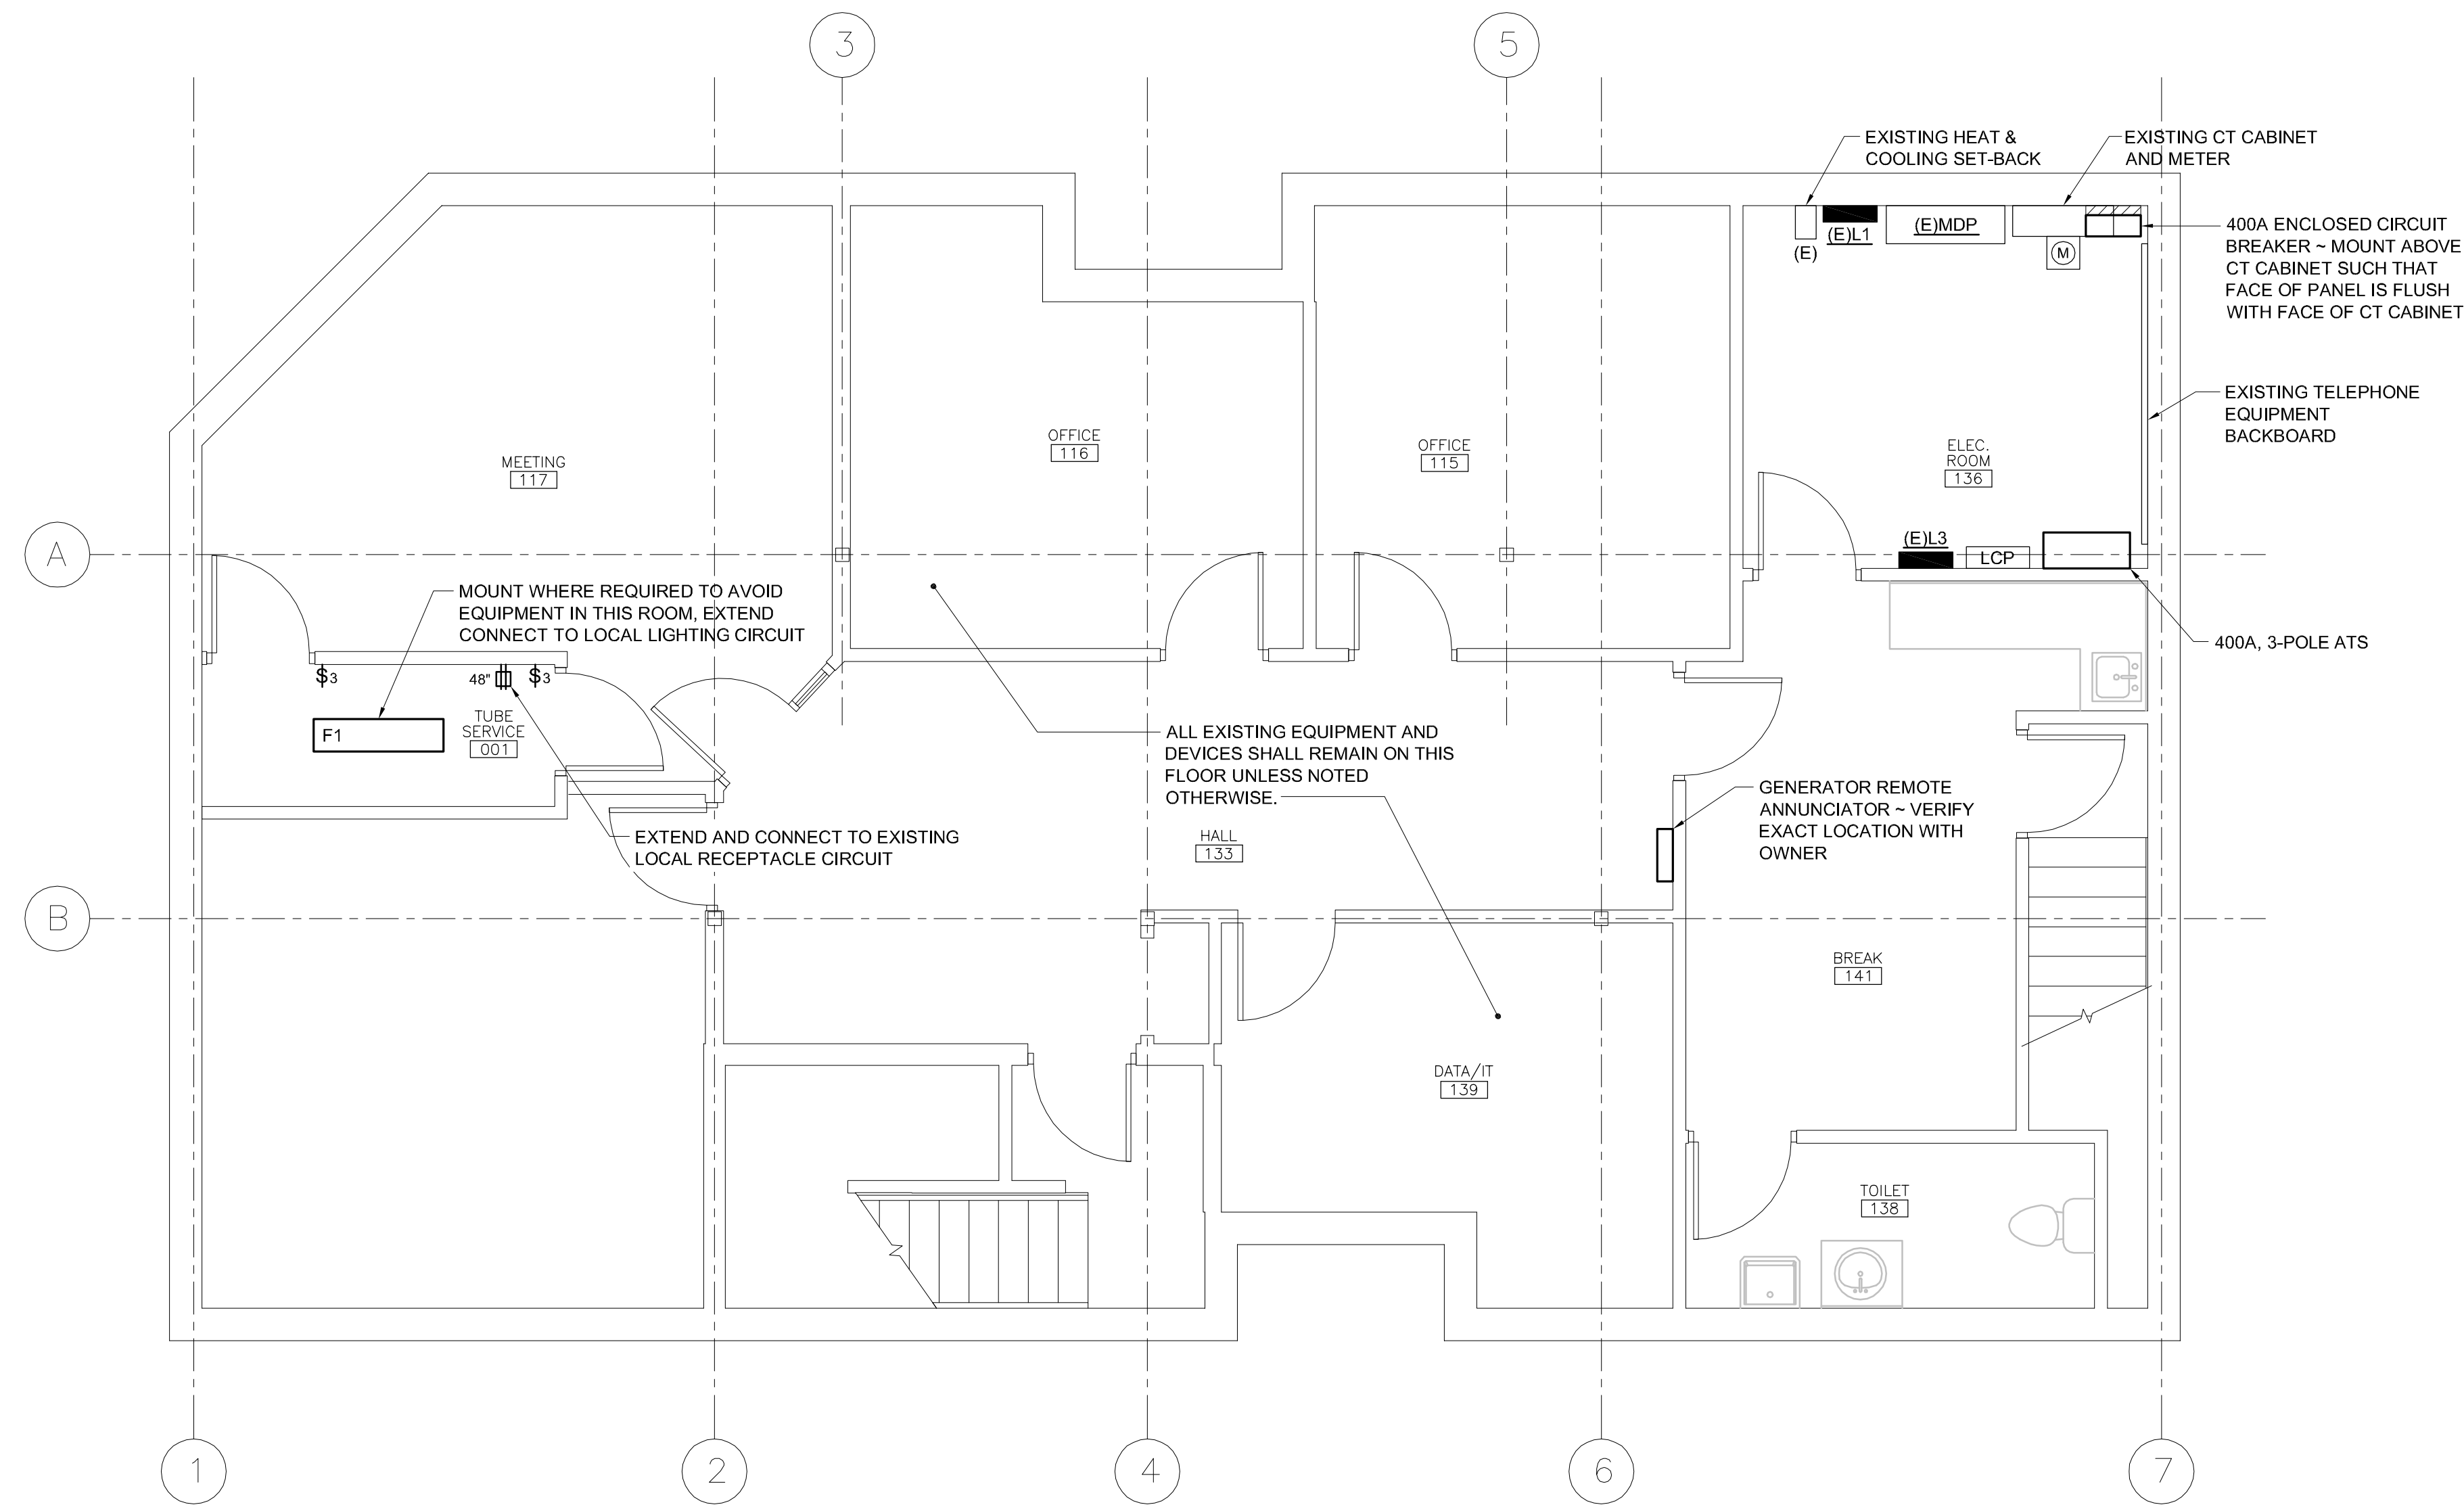

A1 ELECTRICAL POWER PLAN ~ BASEMENT

1/4" = 1'-0"