



PDT ARCHITECTS

49 DARTMOUTH STREET
PORTLAND, MAINE 04101
207-775-1050
www.pdtarchs.com



Allied Engineering

Structural Mechanical Electrical Commissioning

160 Veranda Street
Portland, Maine 04103
T: 207.231.2366
F: 207.231.2366
Web: www.allied-eng.com

ALLIED PROJECT No.:
13008
CAD FILE:
13008M.DWG

COPYRIGHT
PDT Architects

Reuse or reproduction of the
contents of this document is not
permitted without written
permission of PDT Architects

TruChoice FCU - 272 Park Avenue
PORTLAND, MAINE



PDT JOB NO.
12084

DRWN.
CHK.



SCALE:
AS NOTED

ISSUE:
04/26/2013
CONSTRUCTION
DOCUMENTS

TITLE
MECHANICAL
PLAN -
BASEMENT

SHEET

M100

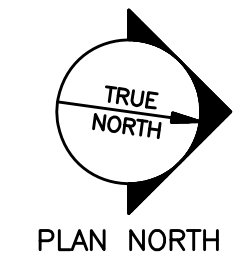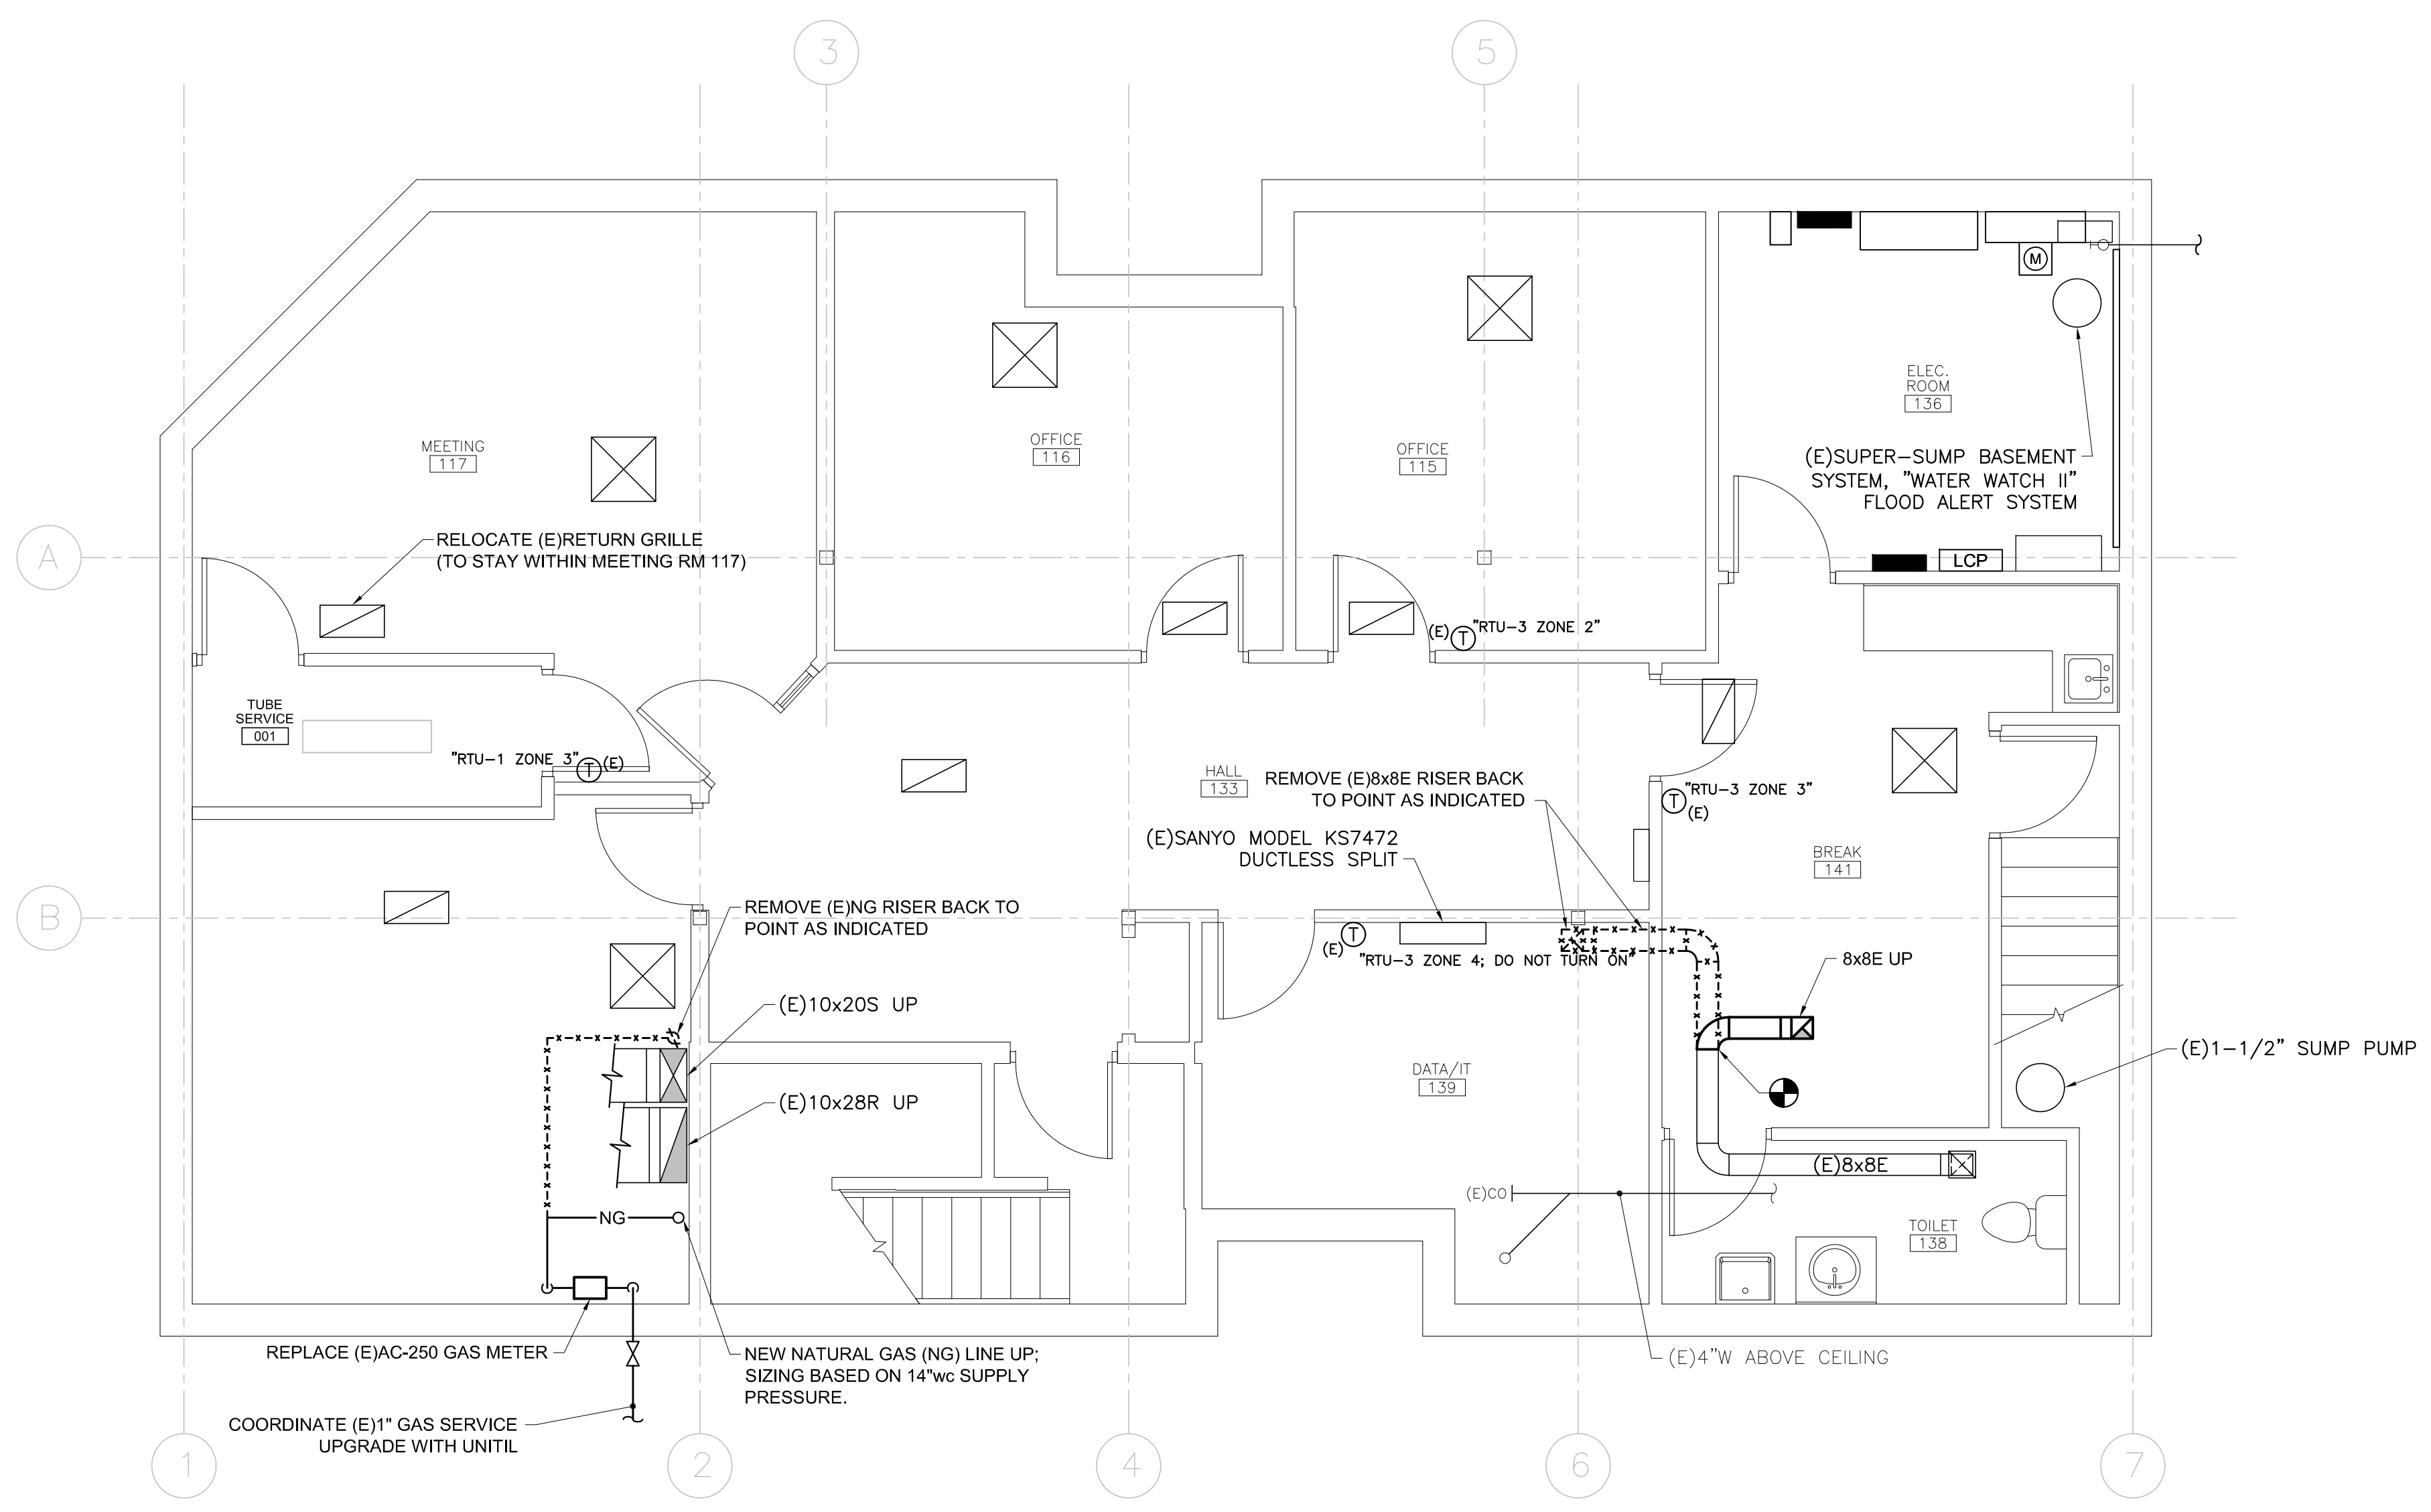

A1	MECHANICAL PLAN ~ BASEMENT
1/4" = 1'-0"	