

CONSULTANTS



Nathan Clifford
Falmouth ST.
Portland, Maine


OWNER



REV.	DATE	DESCRIPTION

SCALE: 3/4" = 1'
PROJECT NO: -----
CAD DWG FILE: NC M&P 3RD FLOOR.DWG
DRAWN BY: WPS
CHK'D BY:
COPYRIGHT:

SHEET TITLE
3rd Floor Heating Layout

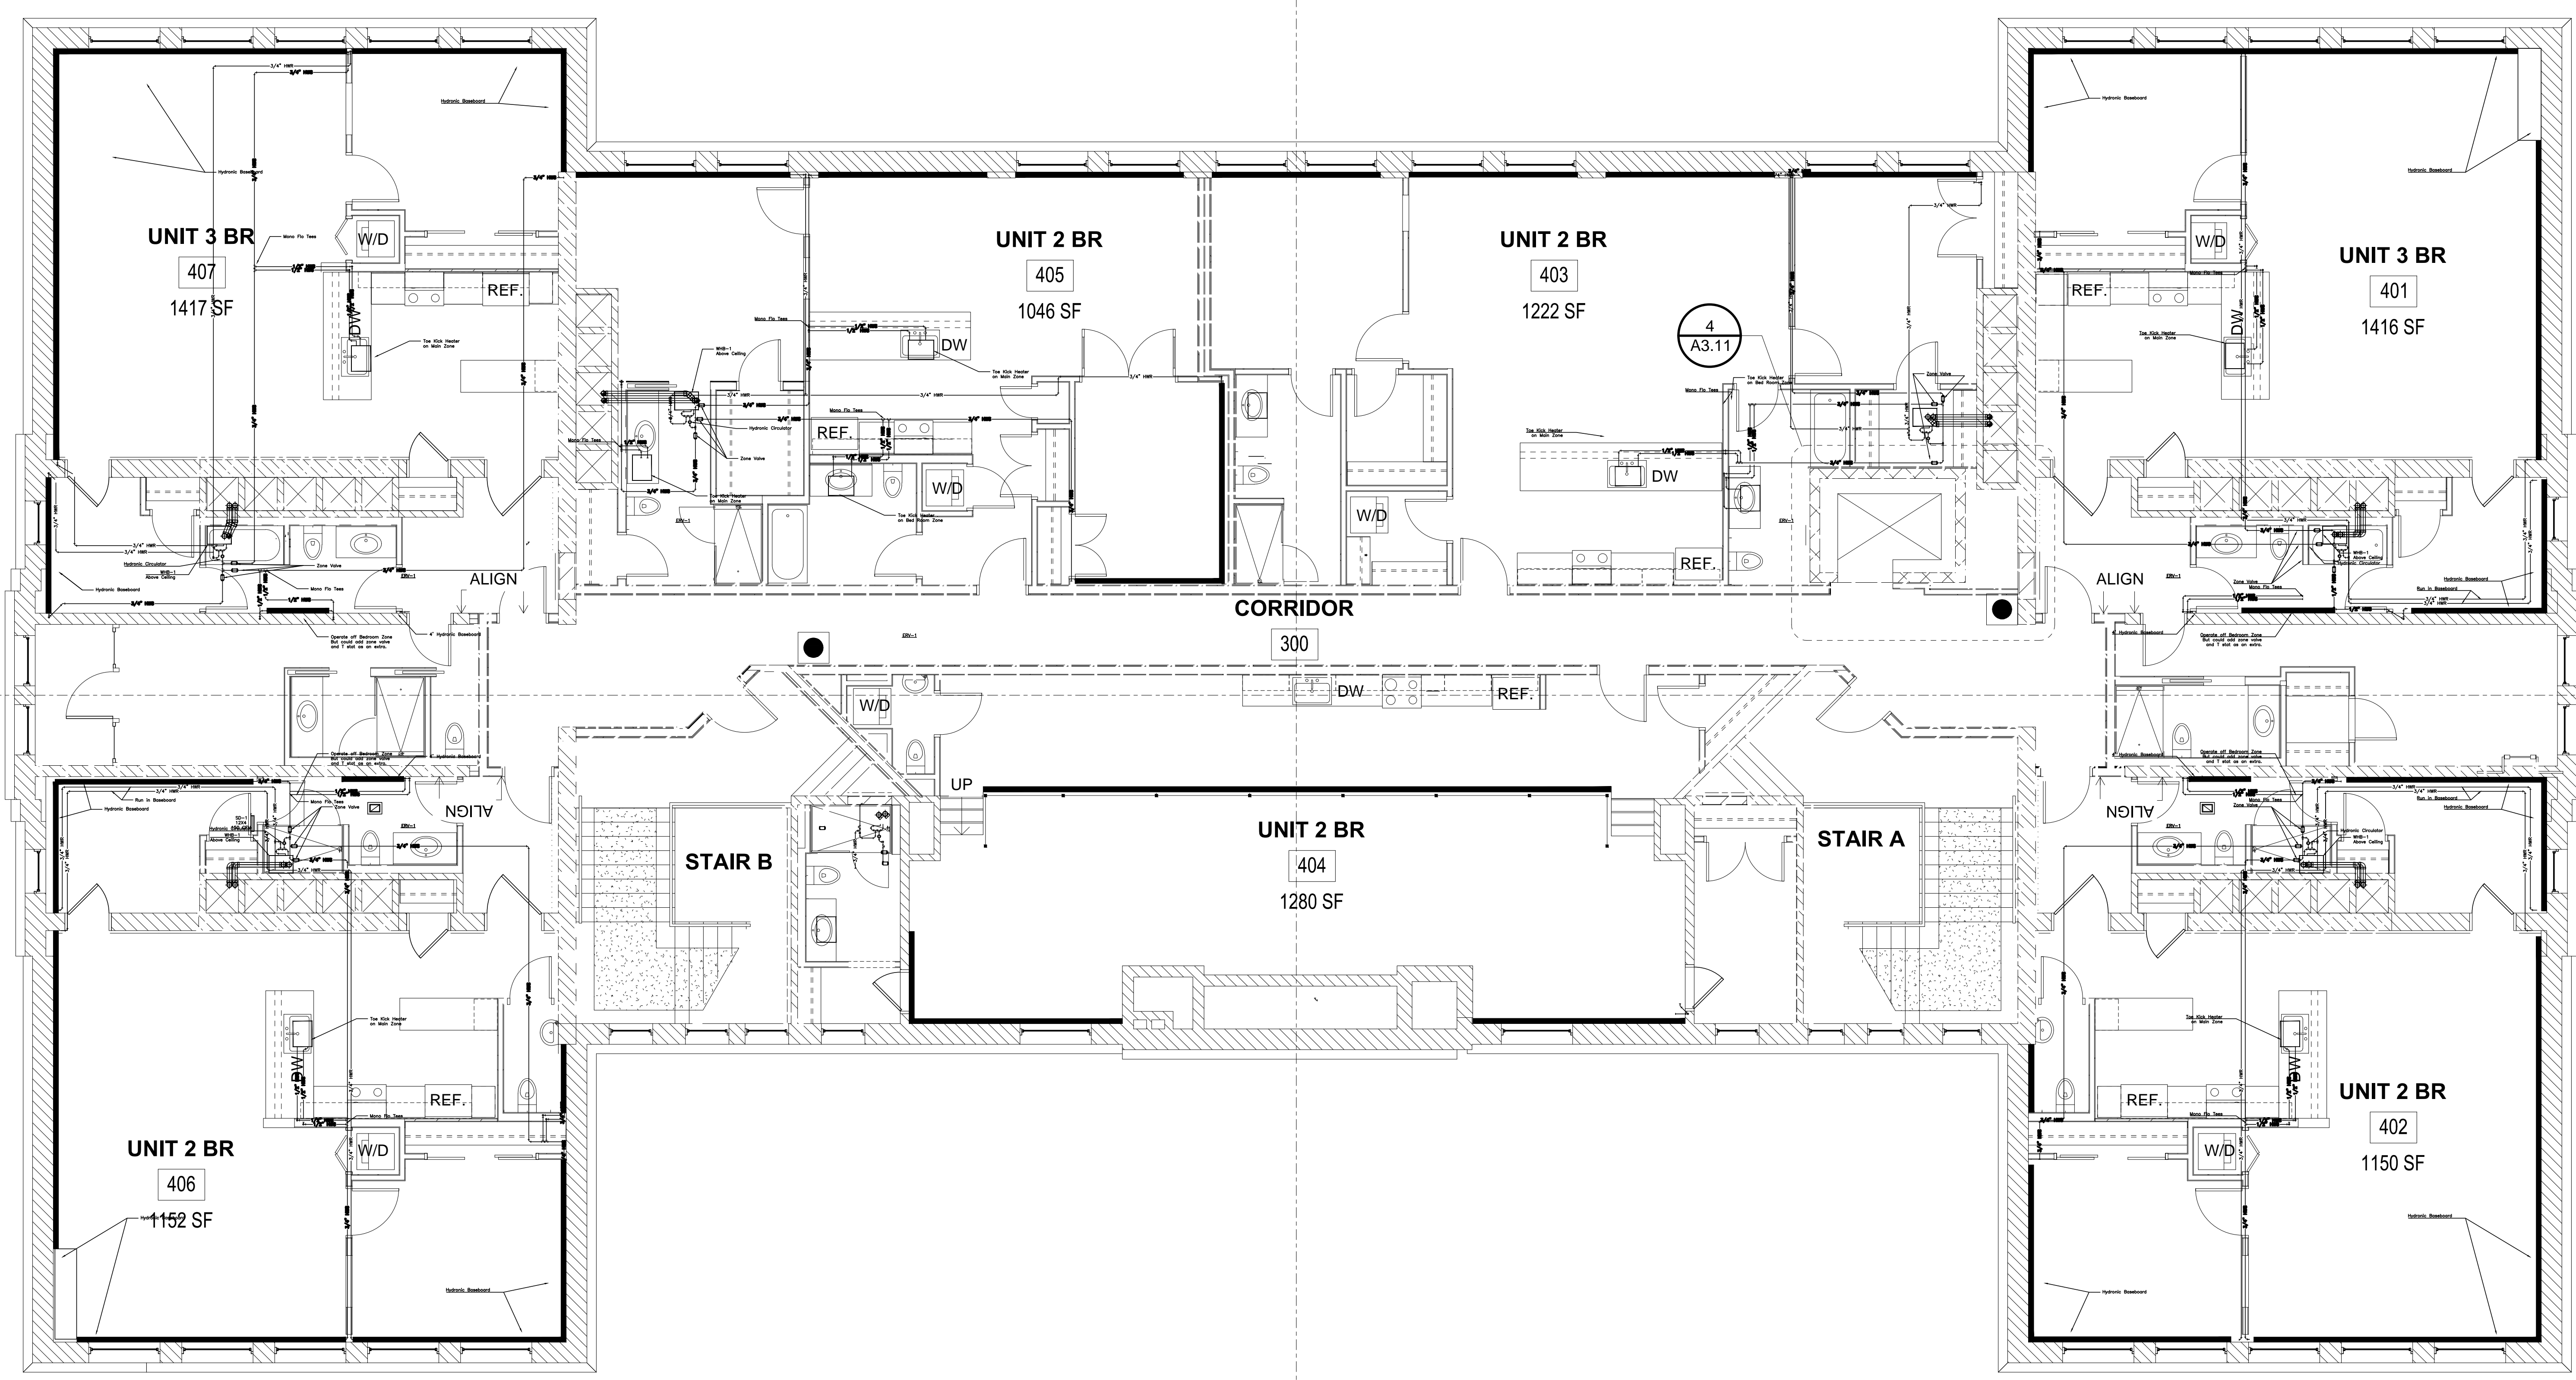

E
D
C
B
A

1 2 3 4 5 6