


LOWER LEVEL PLAN
SCALE: 1/8" = 1'-0"

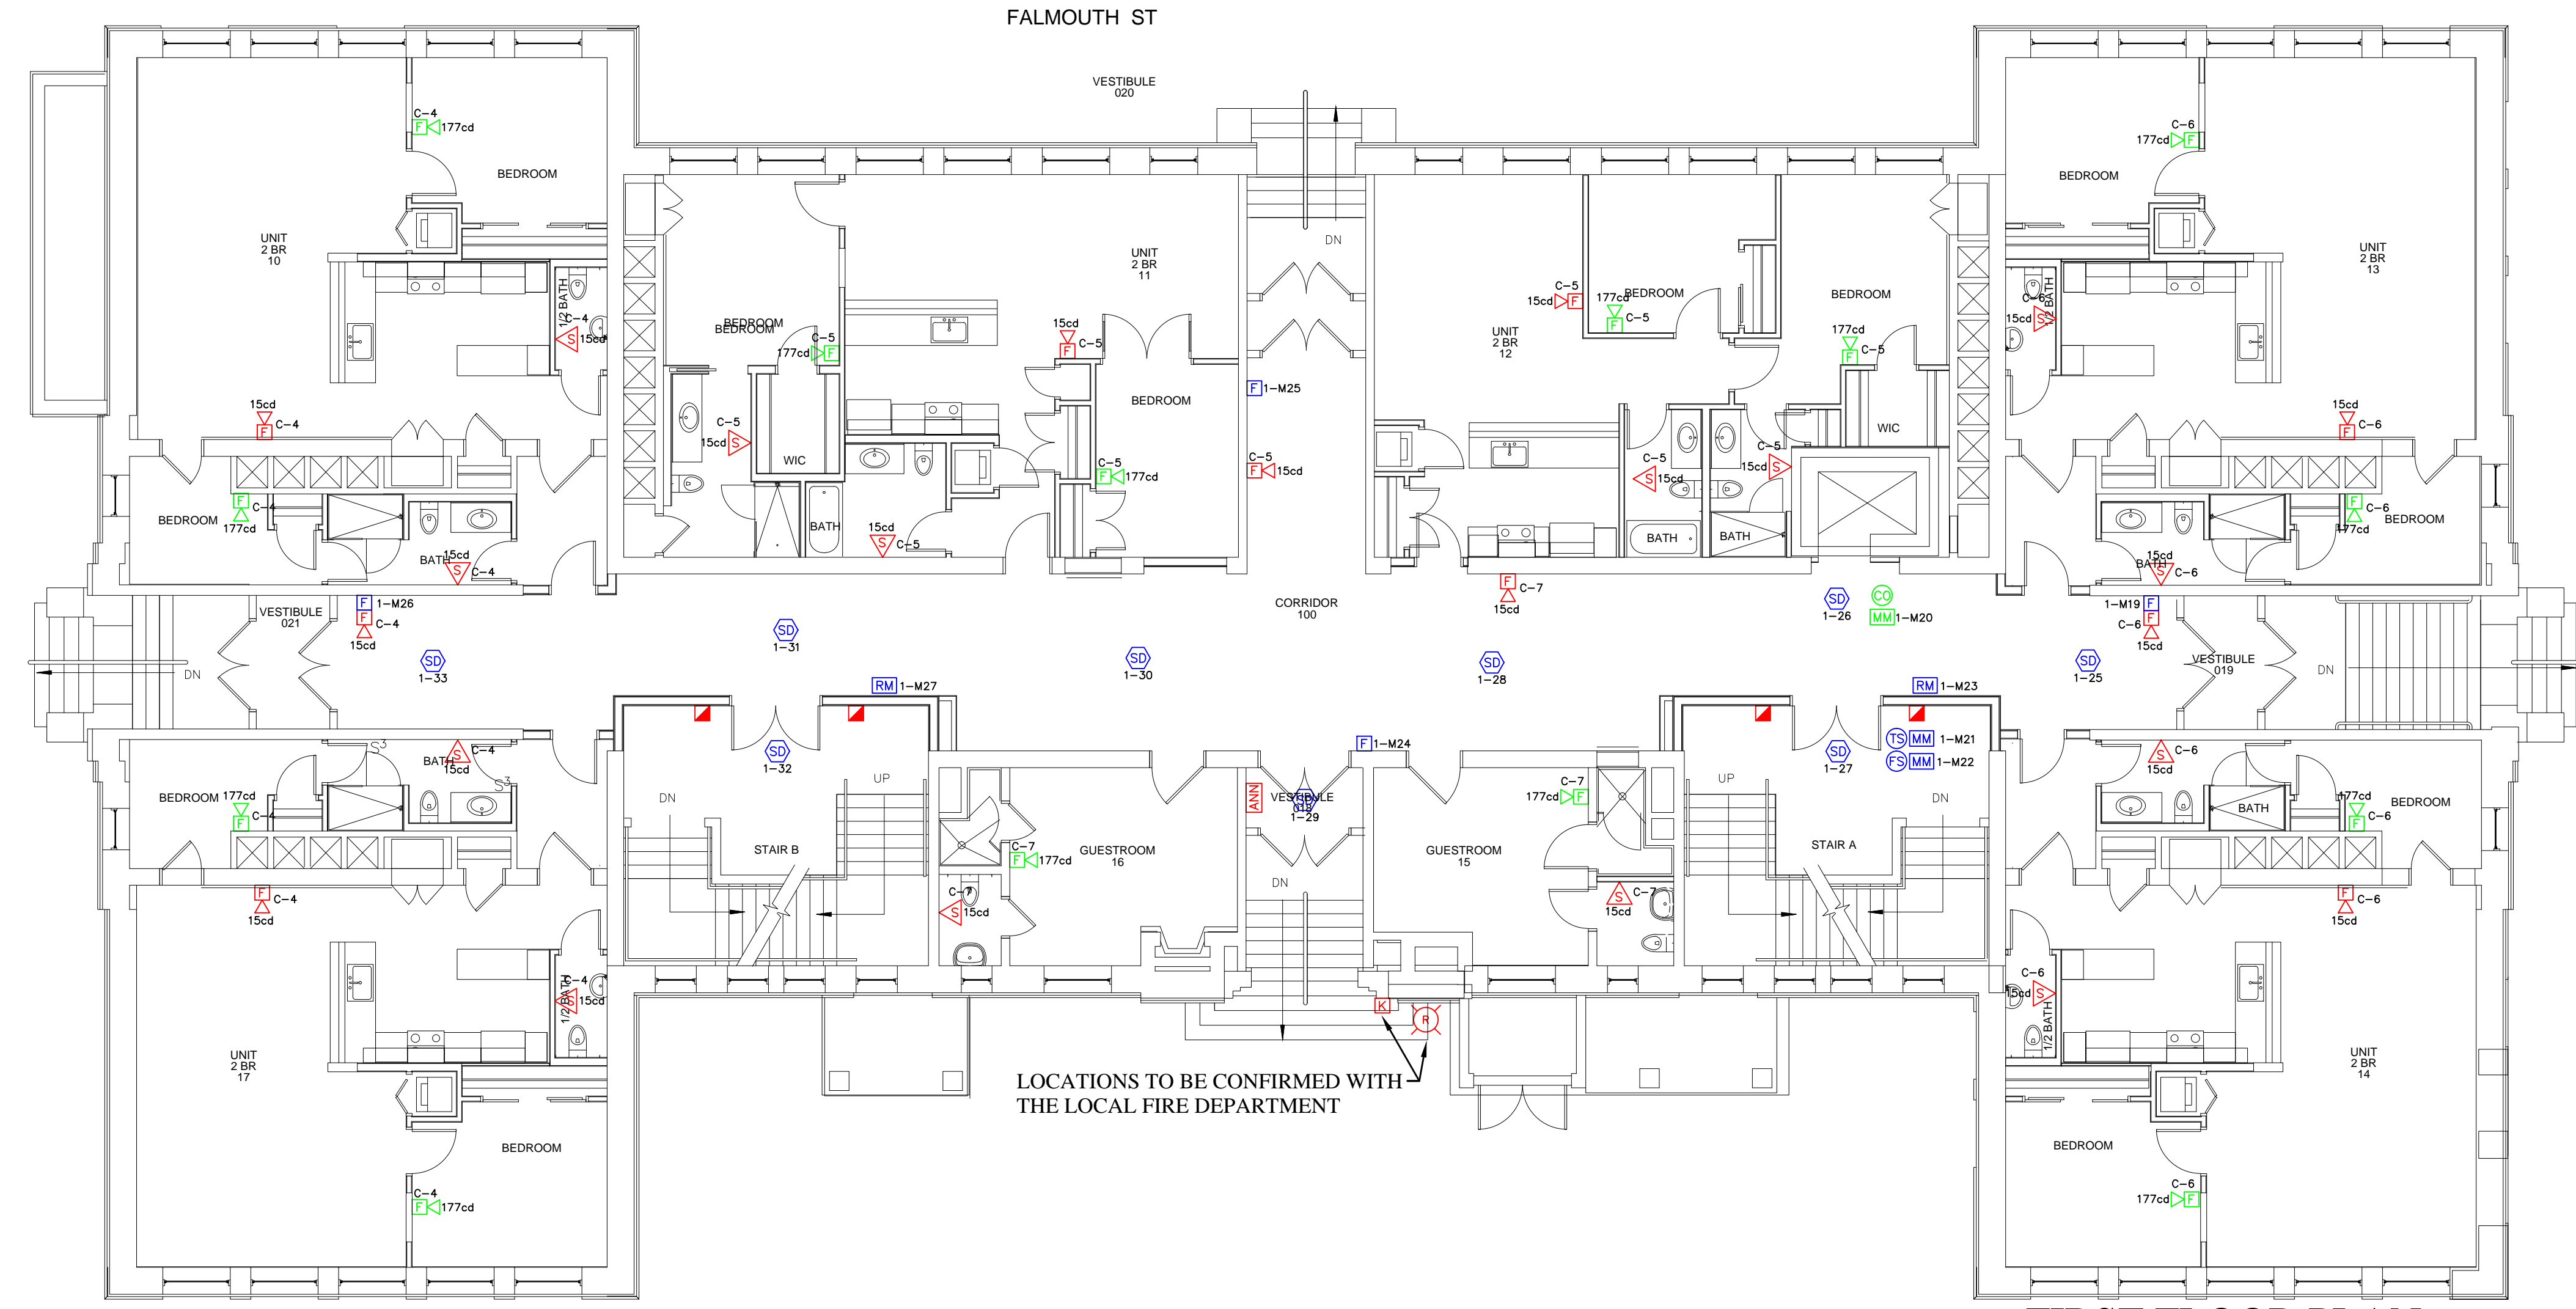

FIRST FLOOR PLAN
SCALE: 1/8" = 1'-0"

This drawing and the information and design application herein contained is the property of BK Systems, Inc.; all information herein contained shall be treated as proprietary and confidential; no reproduction of this drawing or part thereof shall be made without the written consent of BK Systems, Inc.

BK SYSTEMS
"BUILDING SYSTEMS SPECIALISTS"
BK SYSTEMS, INC.
4 COTE AVENUE · GOFFSTOWN, NH 03045
TEL: (603) 647-8775 / FAX: (603) 647-4806
www.bksystemsinc.com

REVISIONS	DATE

NATHAN CLIFFORD SCHOOL
PORTLAND, MAINE
FIRE ALARM LOWER LEVEL - FIRST FLOOR PLANS
PREPARED FOR:
TRT ELECTRIC
65 WASHINGTON STREET
AUGUSTA, ME 04330

SHEET:
FA-1