


SECOND FLOOR PLAN

SCALE: 1/8" = 1'-0"

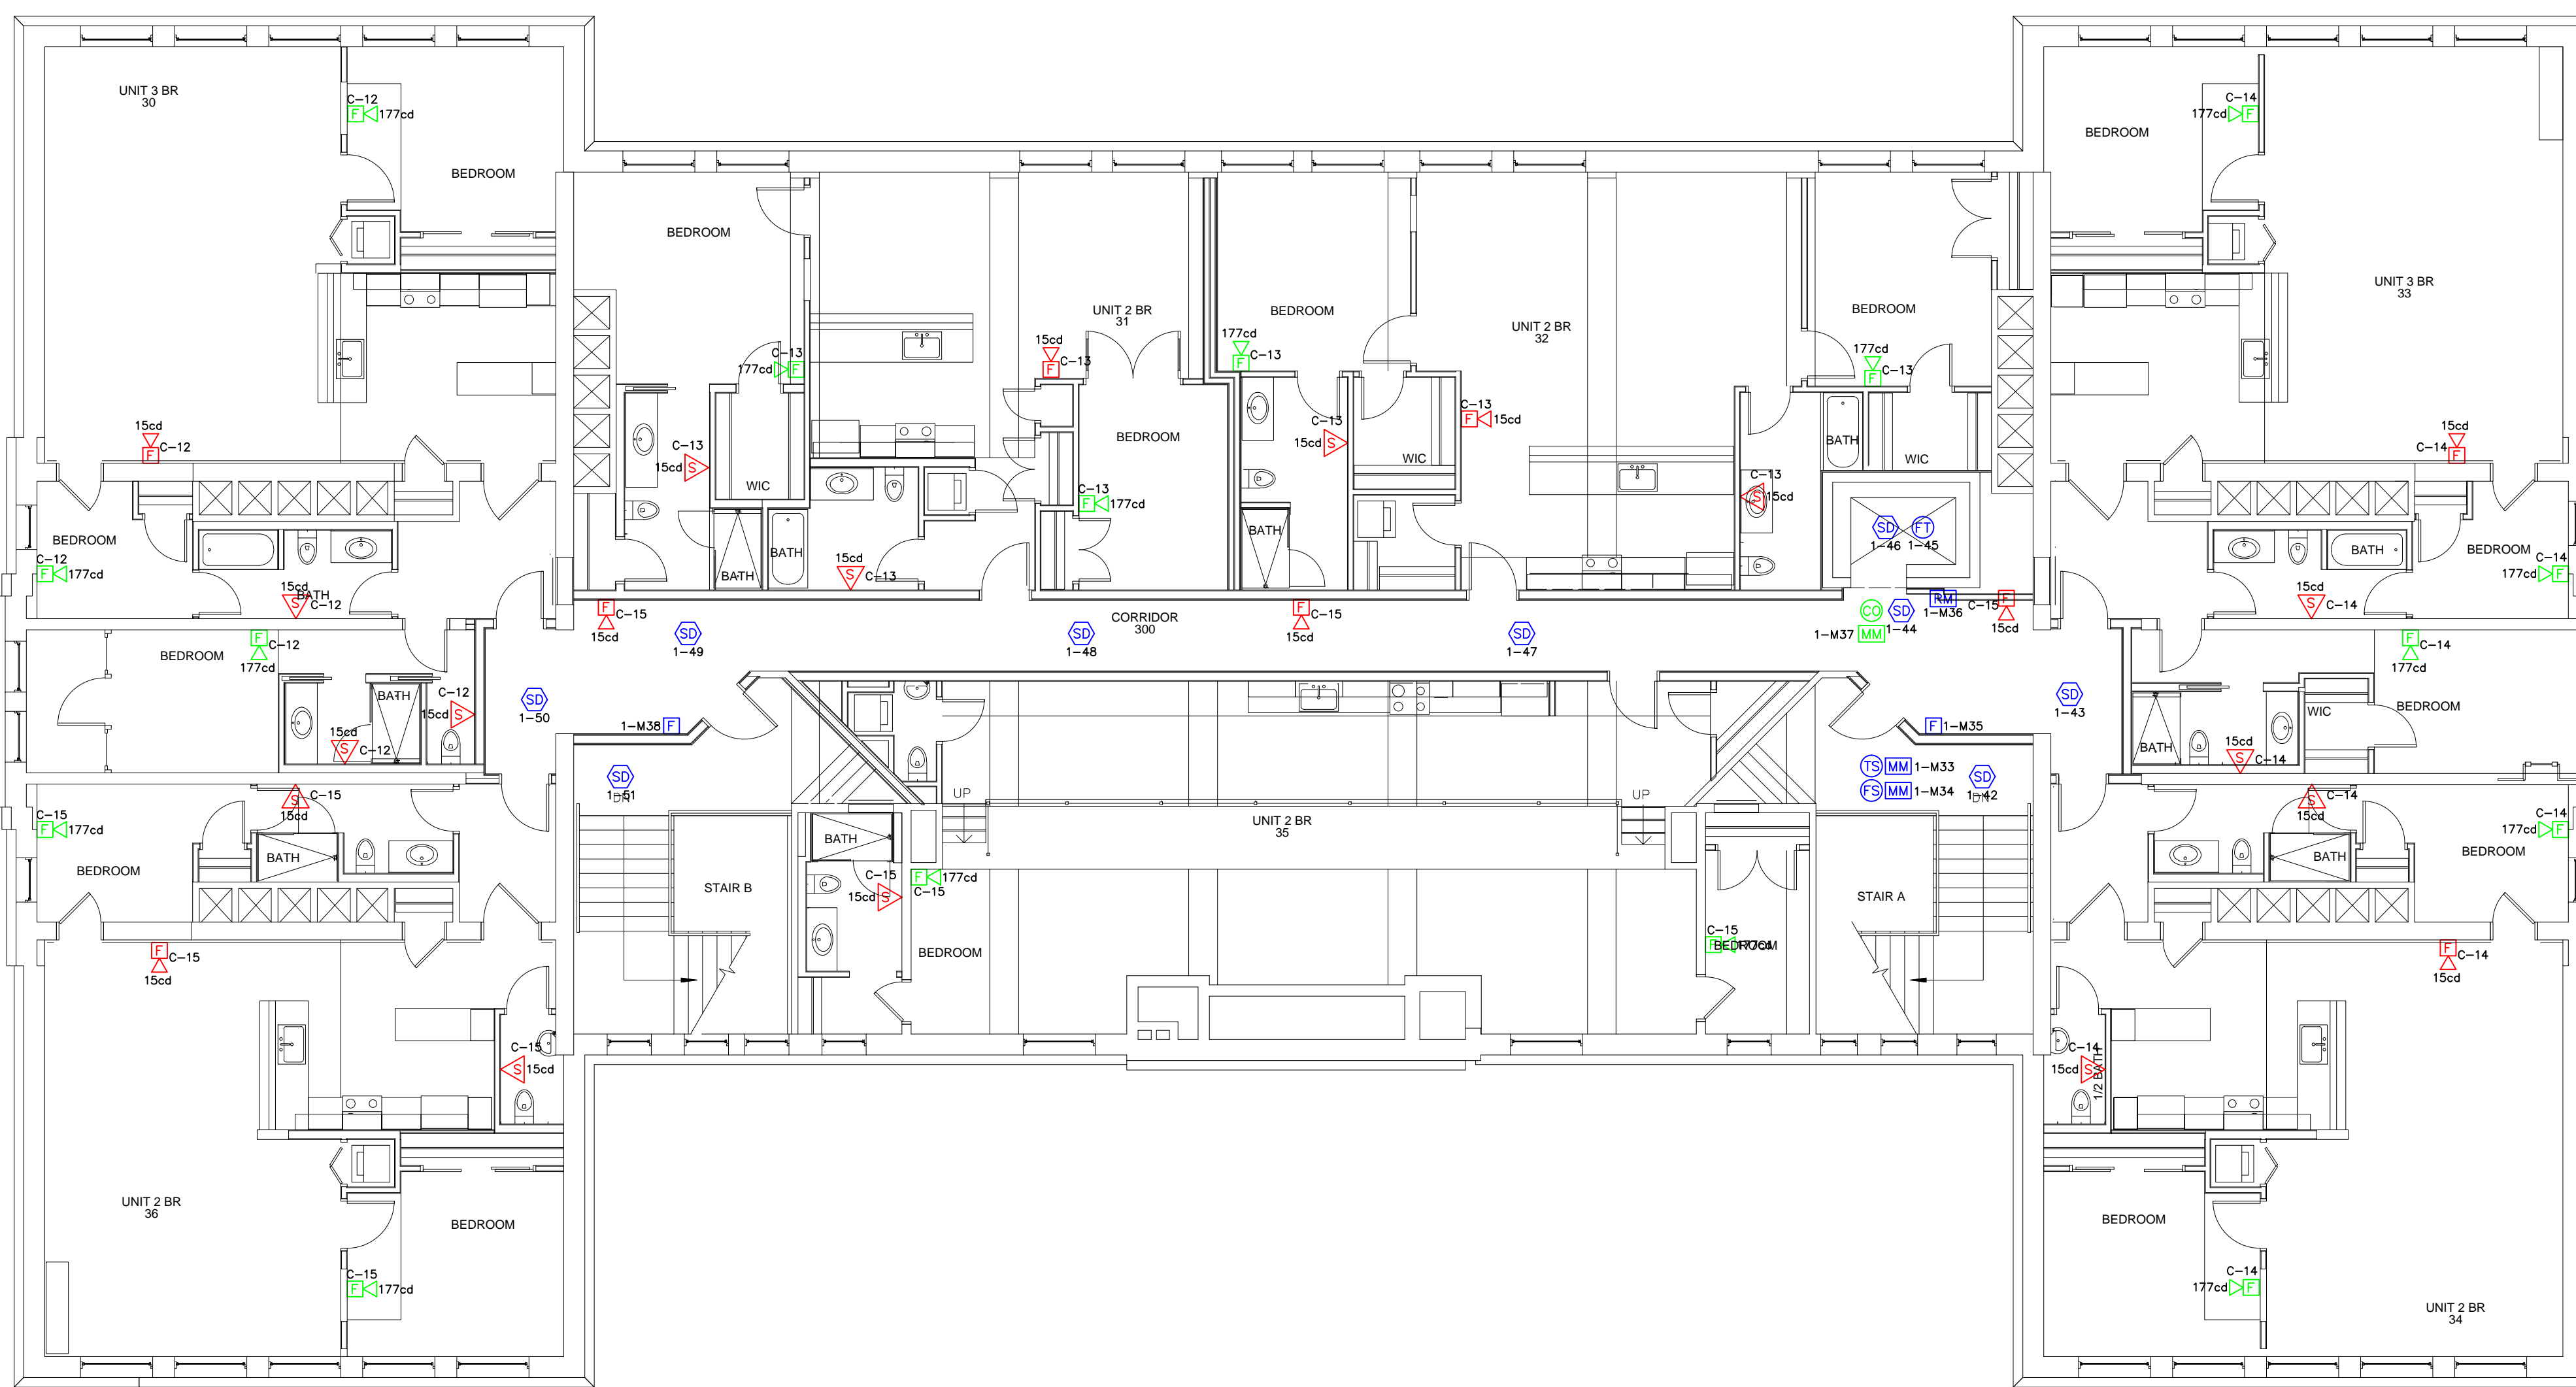

THIRD FLOOR PLAN

SCALE: 1/8" = 1'-0"

This drawing and the information and design application herein contained is the property of BK Systems, Inc.; all information herein contained shall be treated as proprietary and confidential; no reproduction of this drawing or part thereof shall be made without the written consent of BK Systems, Inc.

BK SYSTEMS
 "BUILDING SYSTEMS SPECIALISTS"
 BK SYSTEMS, INC.
 4 COTE AVENUE - GOFFESTOWN, NH 03045
 TEL: (603) 647-8775 / FAX: (603) 647-4806
 www.bksystemsinc.com

| REVISIONS | DATE |
|-----------|------|
| | |
| | |
| | |
| | |
| | |

NATHAN CLIFFORD SCHOOL
 PORTLAND, MAINE
 FIRE ALARM SECOND, THIRD FLOOR PLANS
 PREPARED FOR:
 TRT ELECTRIC
 65 WASHINGTON STREET
 AUGUSTA, ME 04330

SHEET:
FA-2