

DESCRIPTION

DATE

MARK

DATE: 12/22/17

CHECKED BY: JAD


DRAWN BY: CLBC

JOB: ROB2017


SHEET TITLE:

LIFE SAFETY PLANS

LS.1

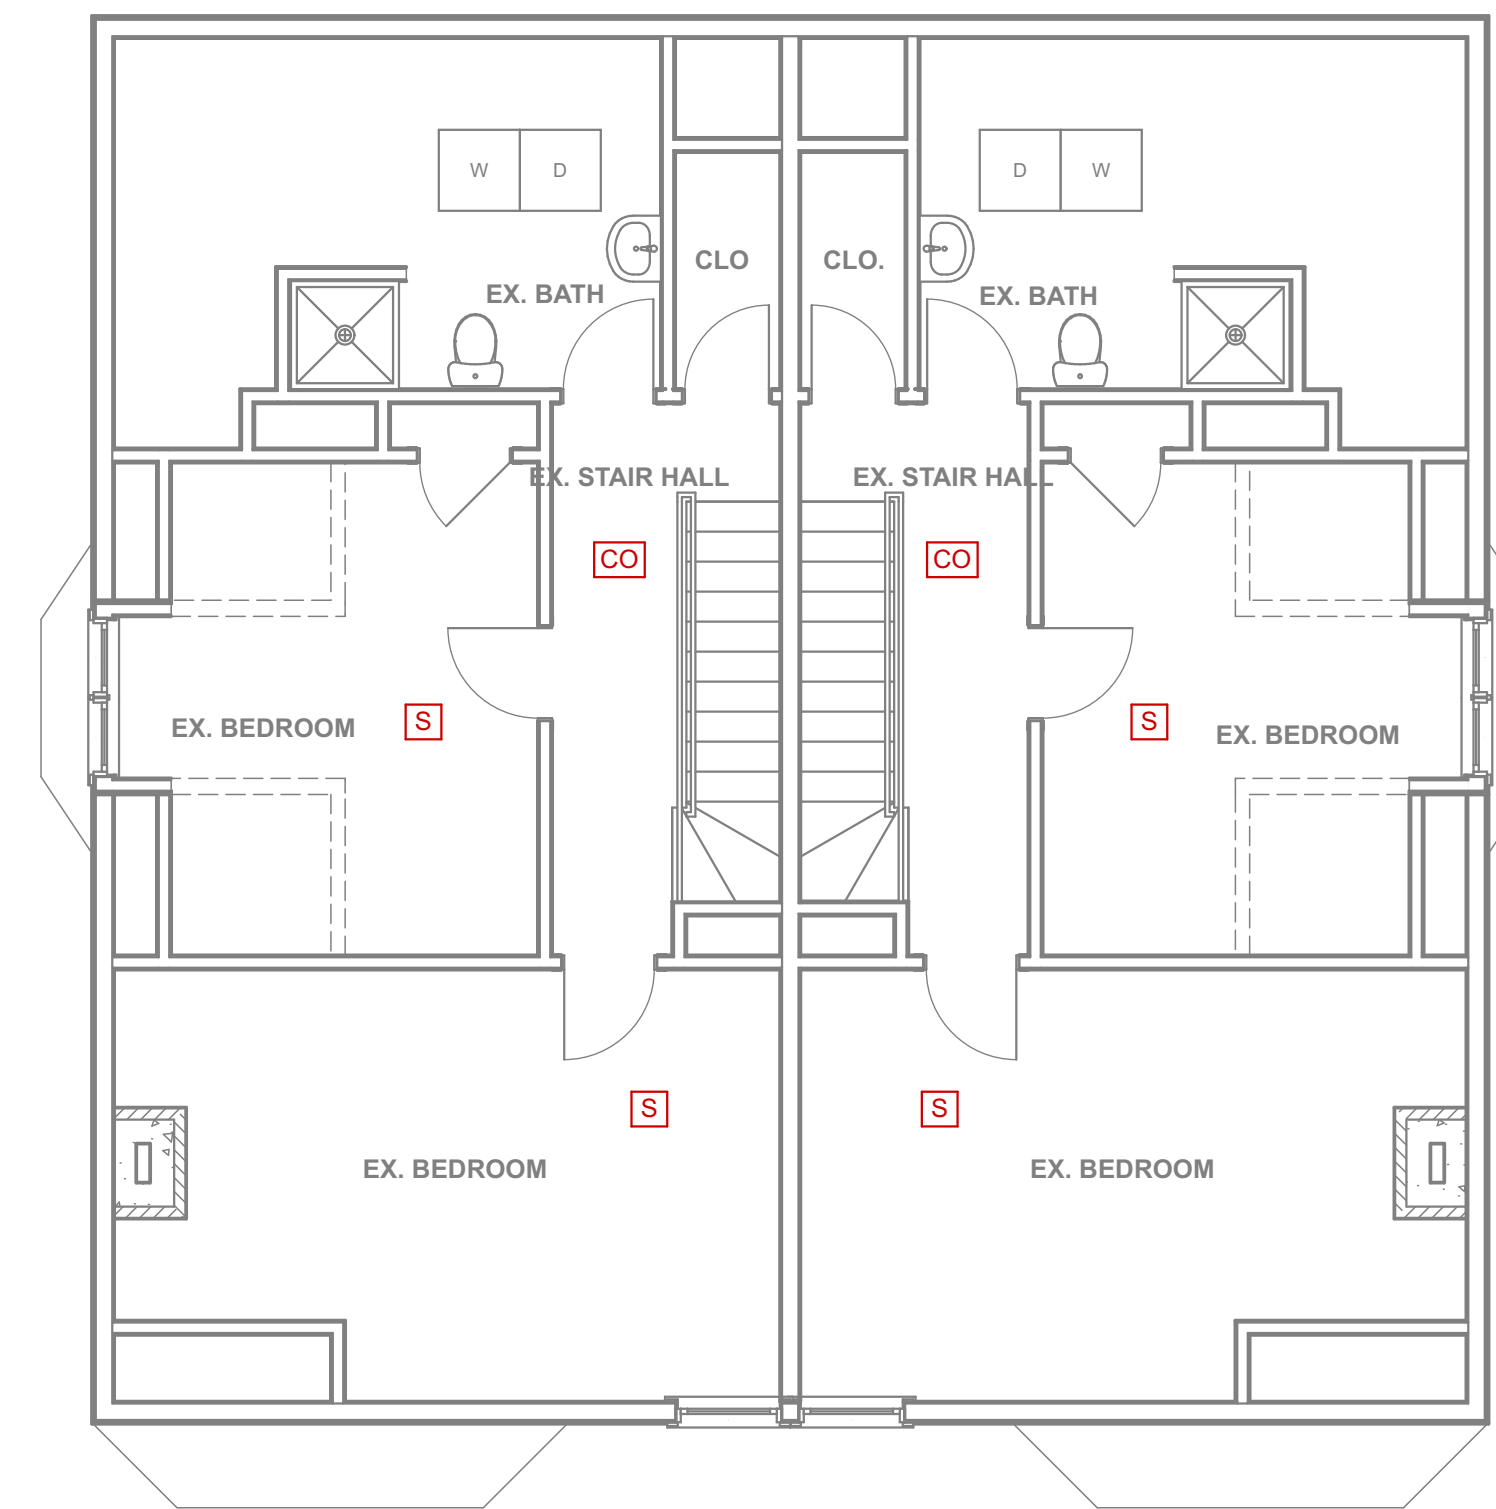


4 LIFE SAFETY THIRD FLOOR PLAN
 SCALE: 3/16" = 1'-0"

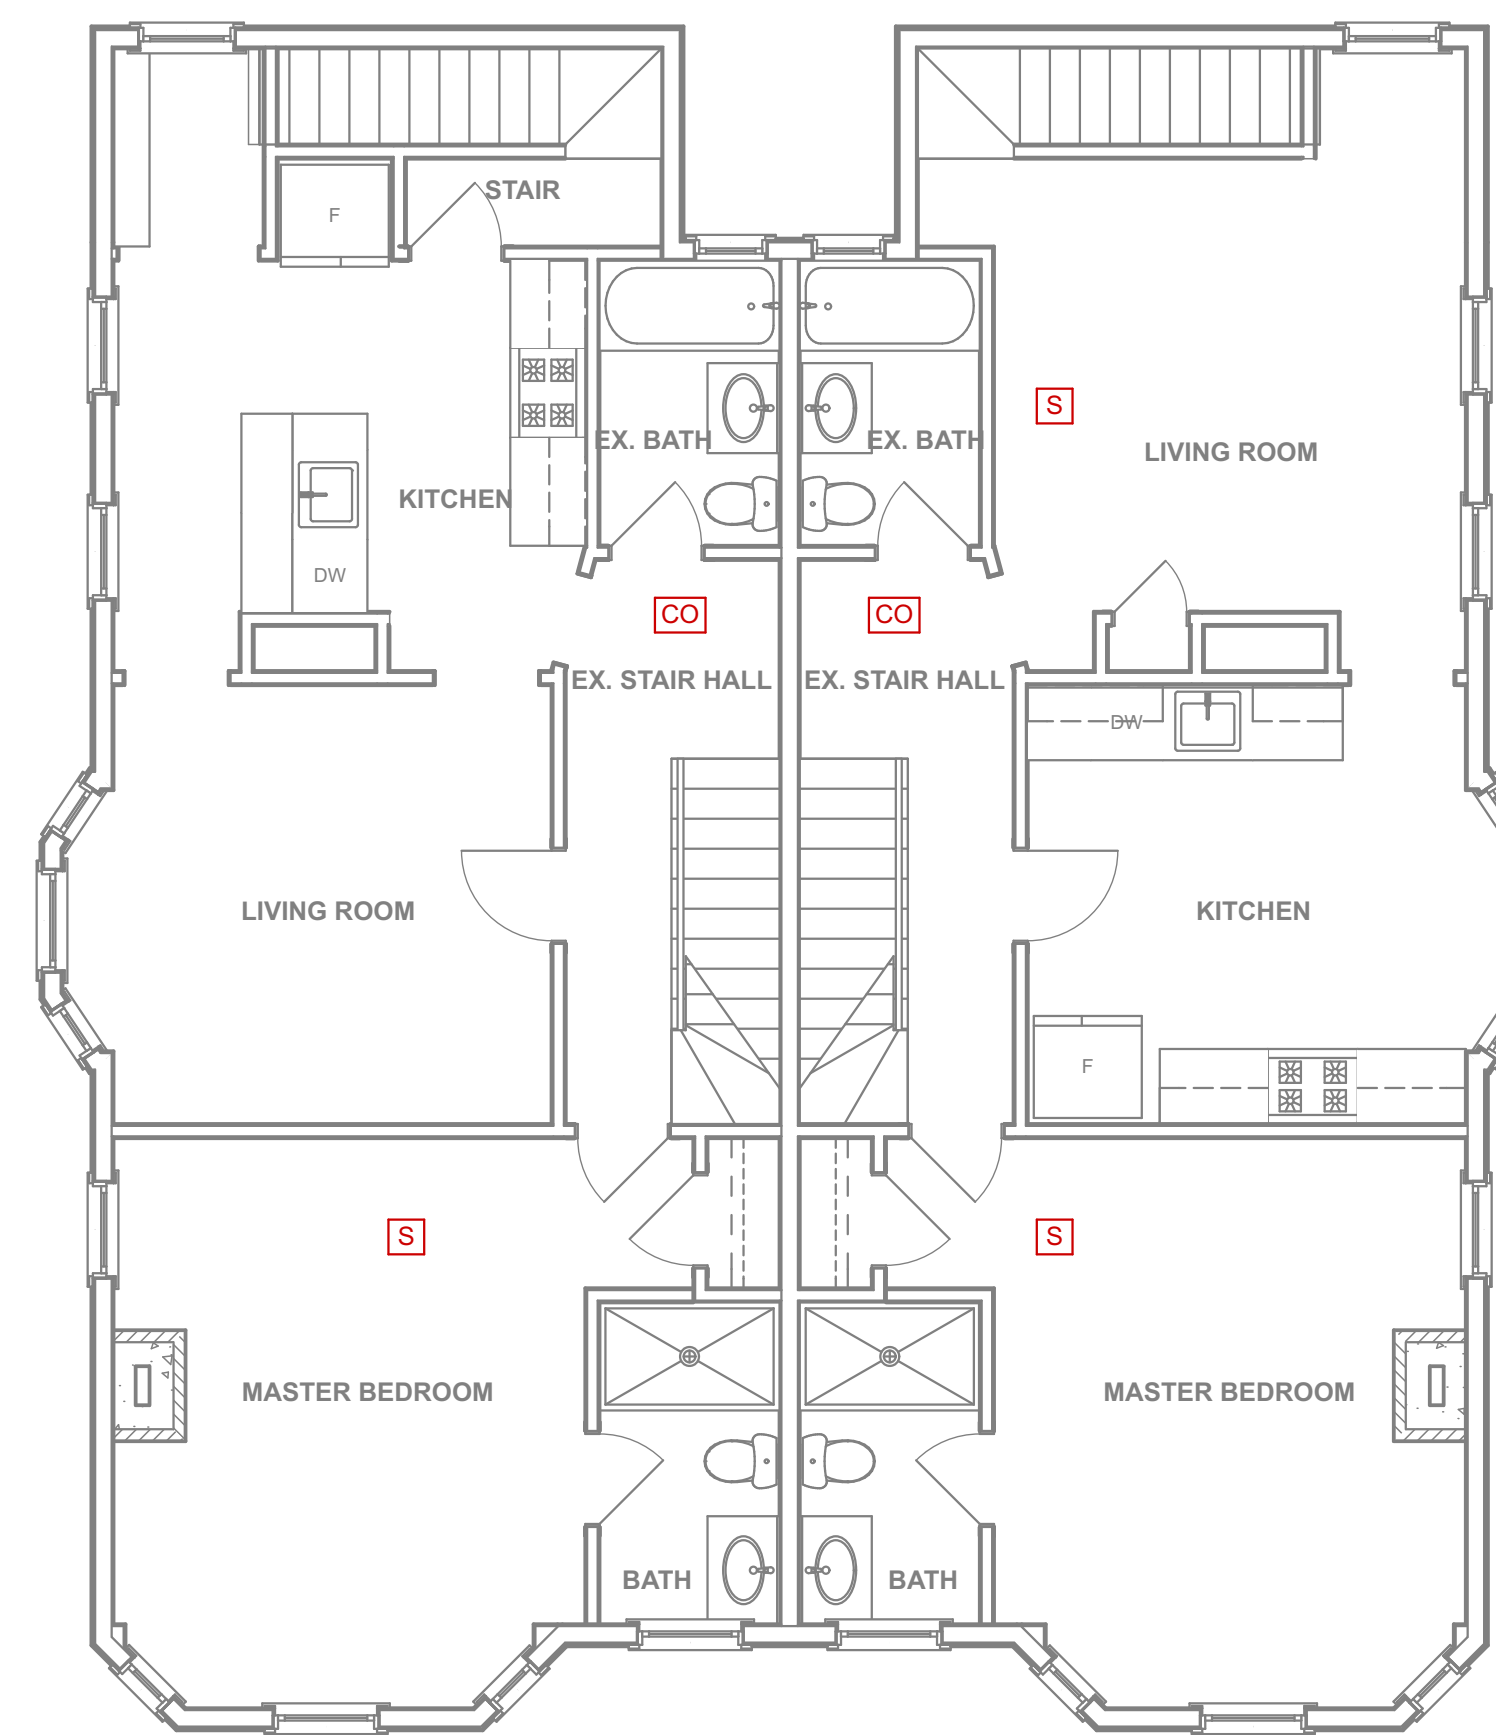


3 LIFE SAFETY SECOND FLOOR PLAN
 SCALE: 3/16" = 1'-0"

LIFE SAFETY LEGEND
 [S] SMOKE DETECTOR
 [CO] CARBON MONOXIDE DETECTOR

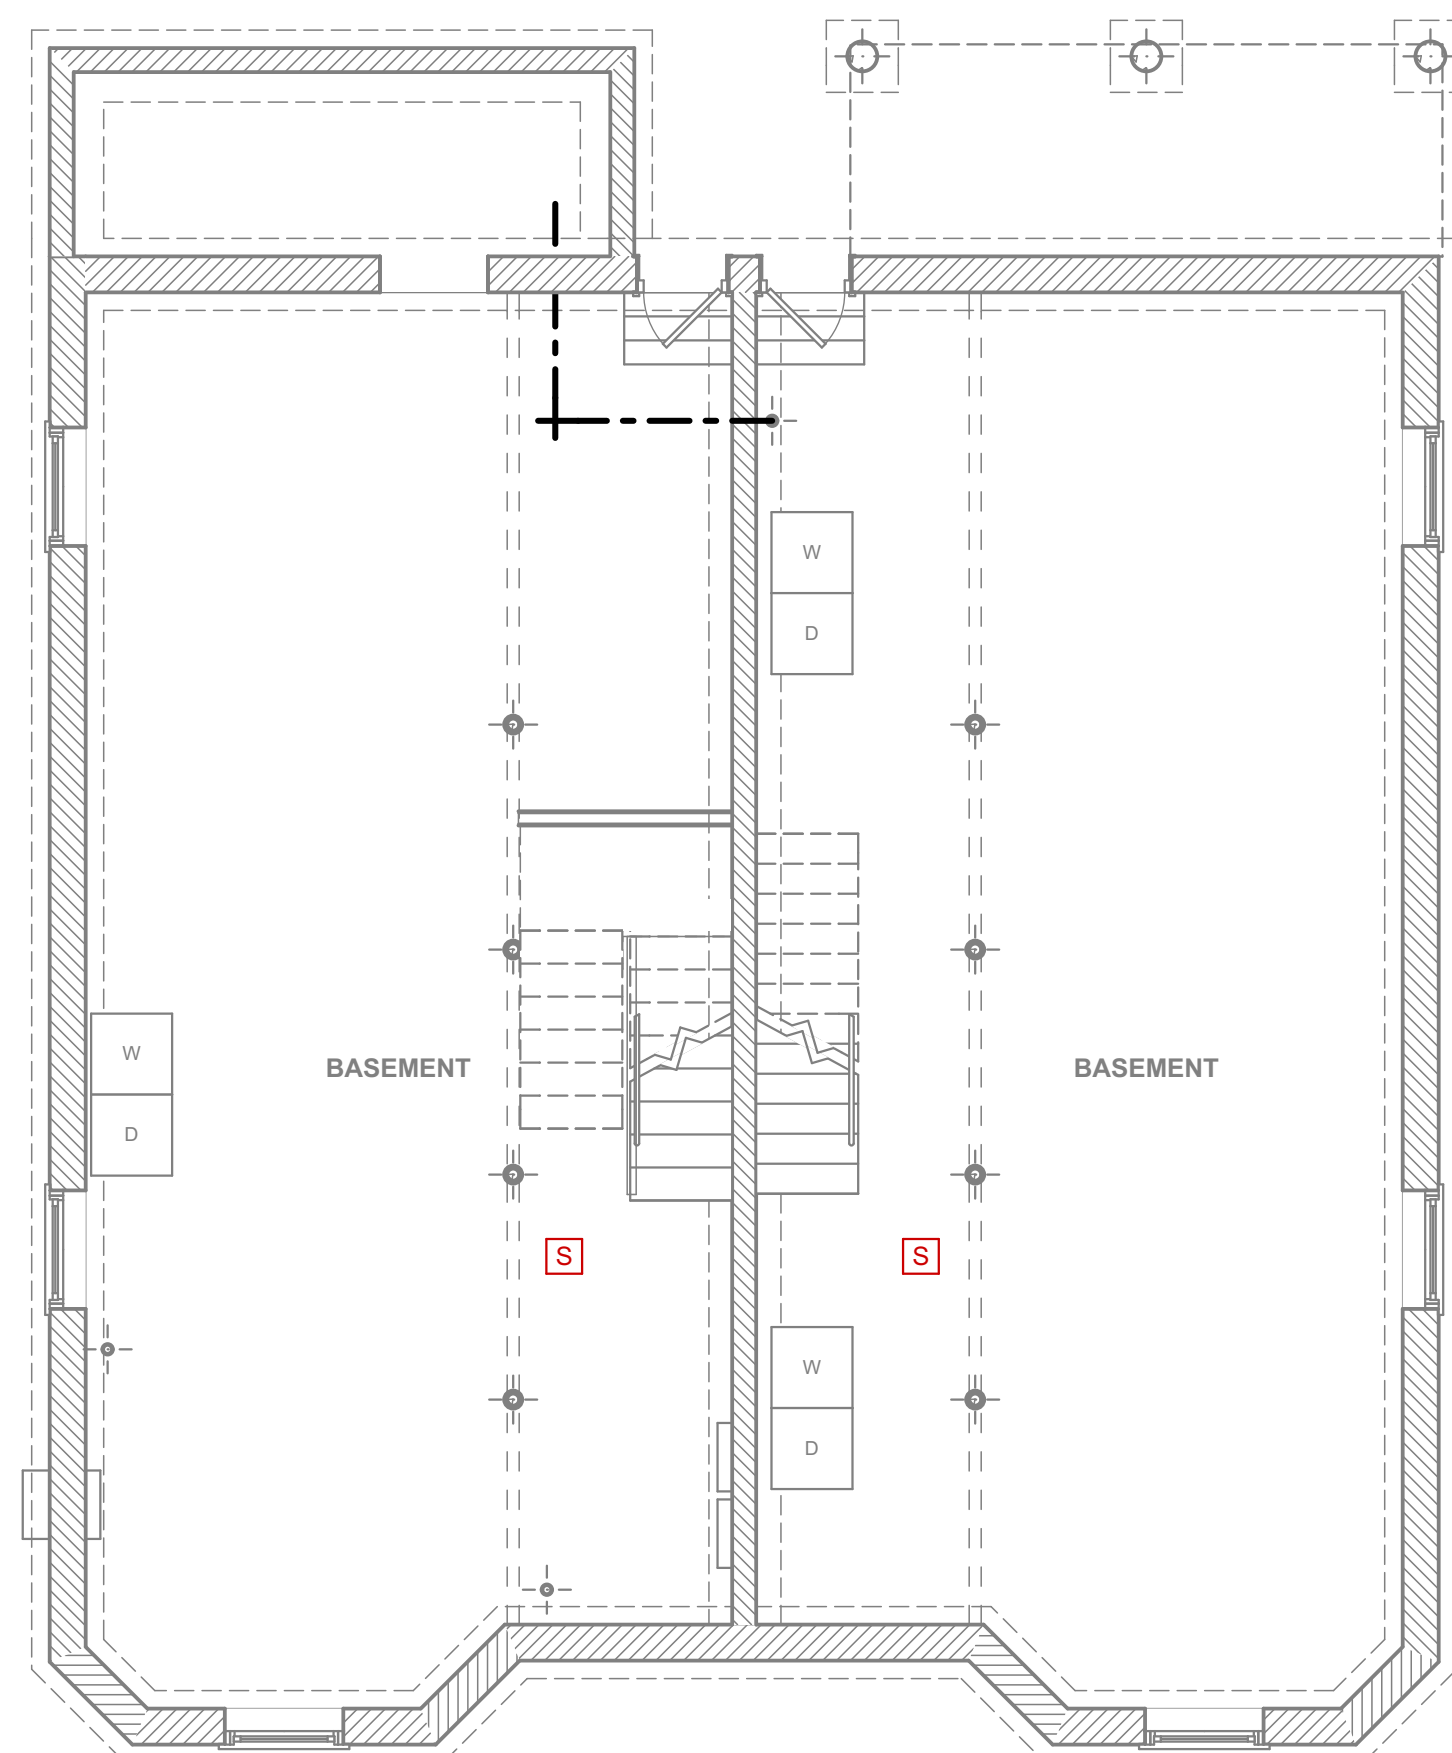

1 LIFE SAFETY BASEMENT PLAN
 SCALE: 3/16" = 1'-0"

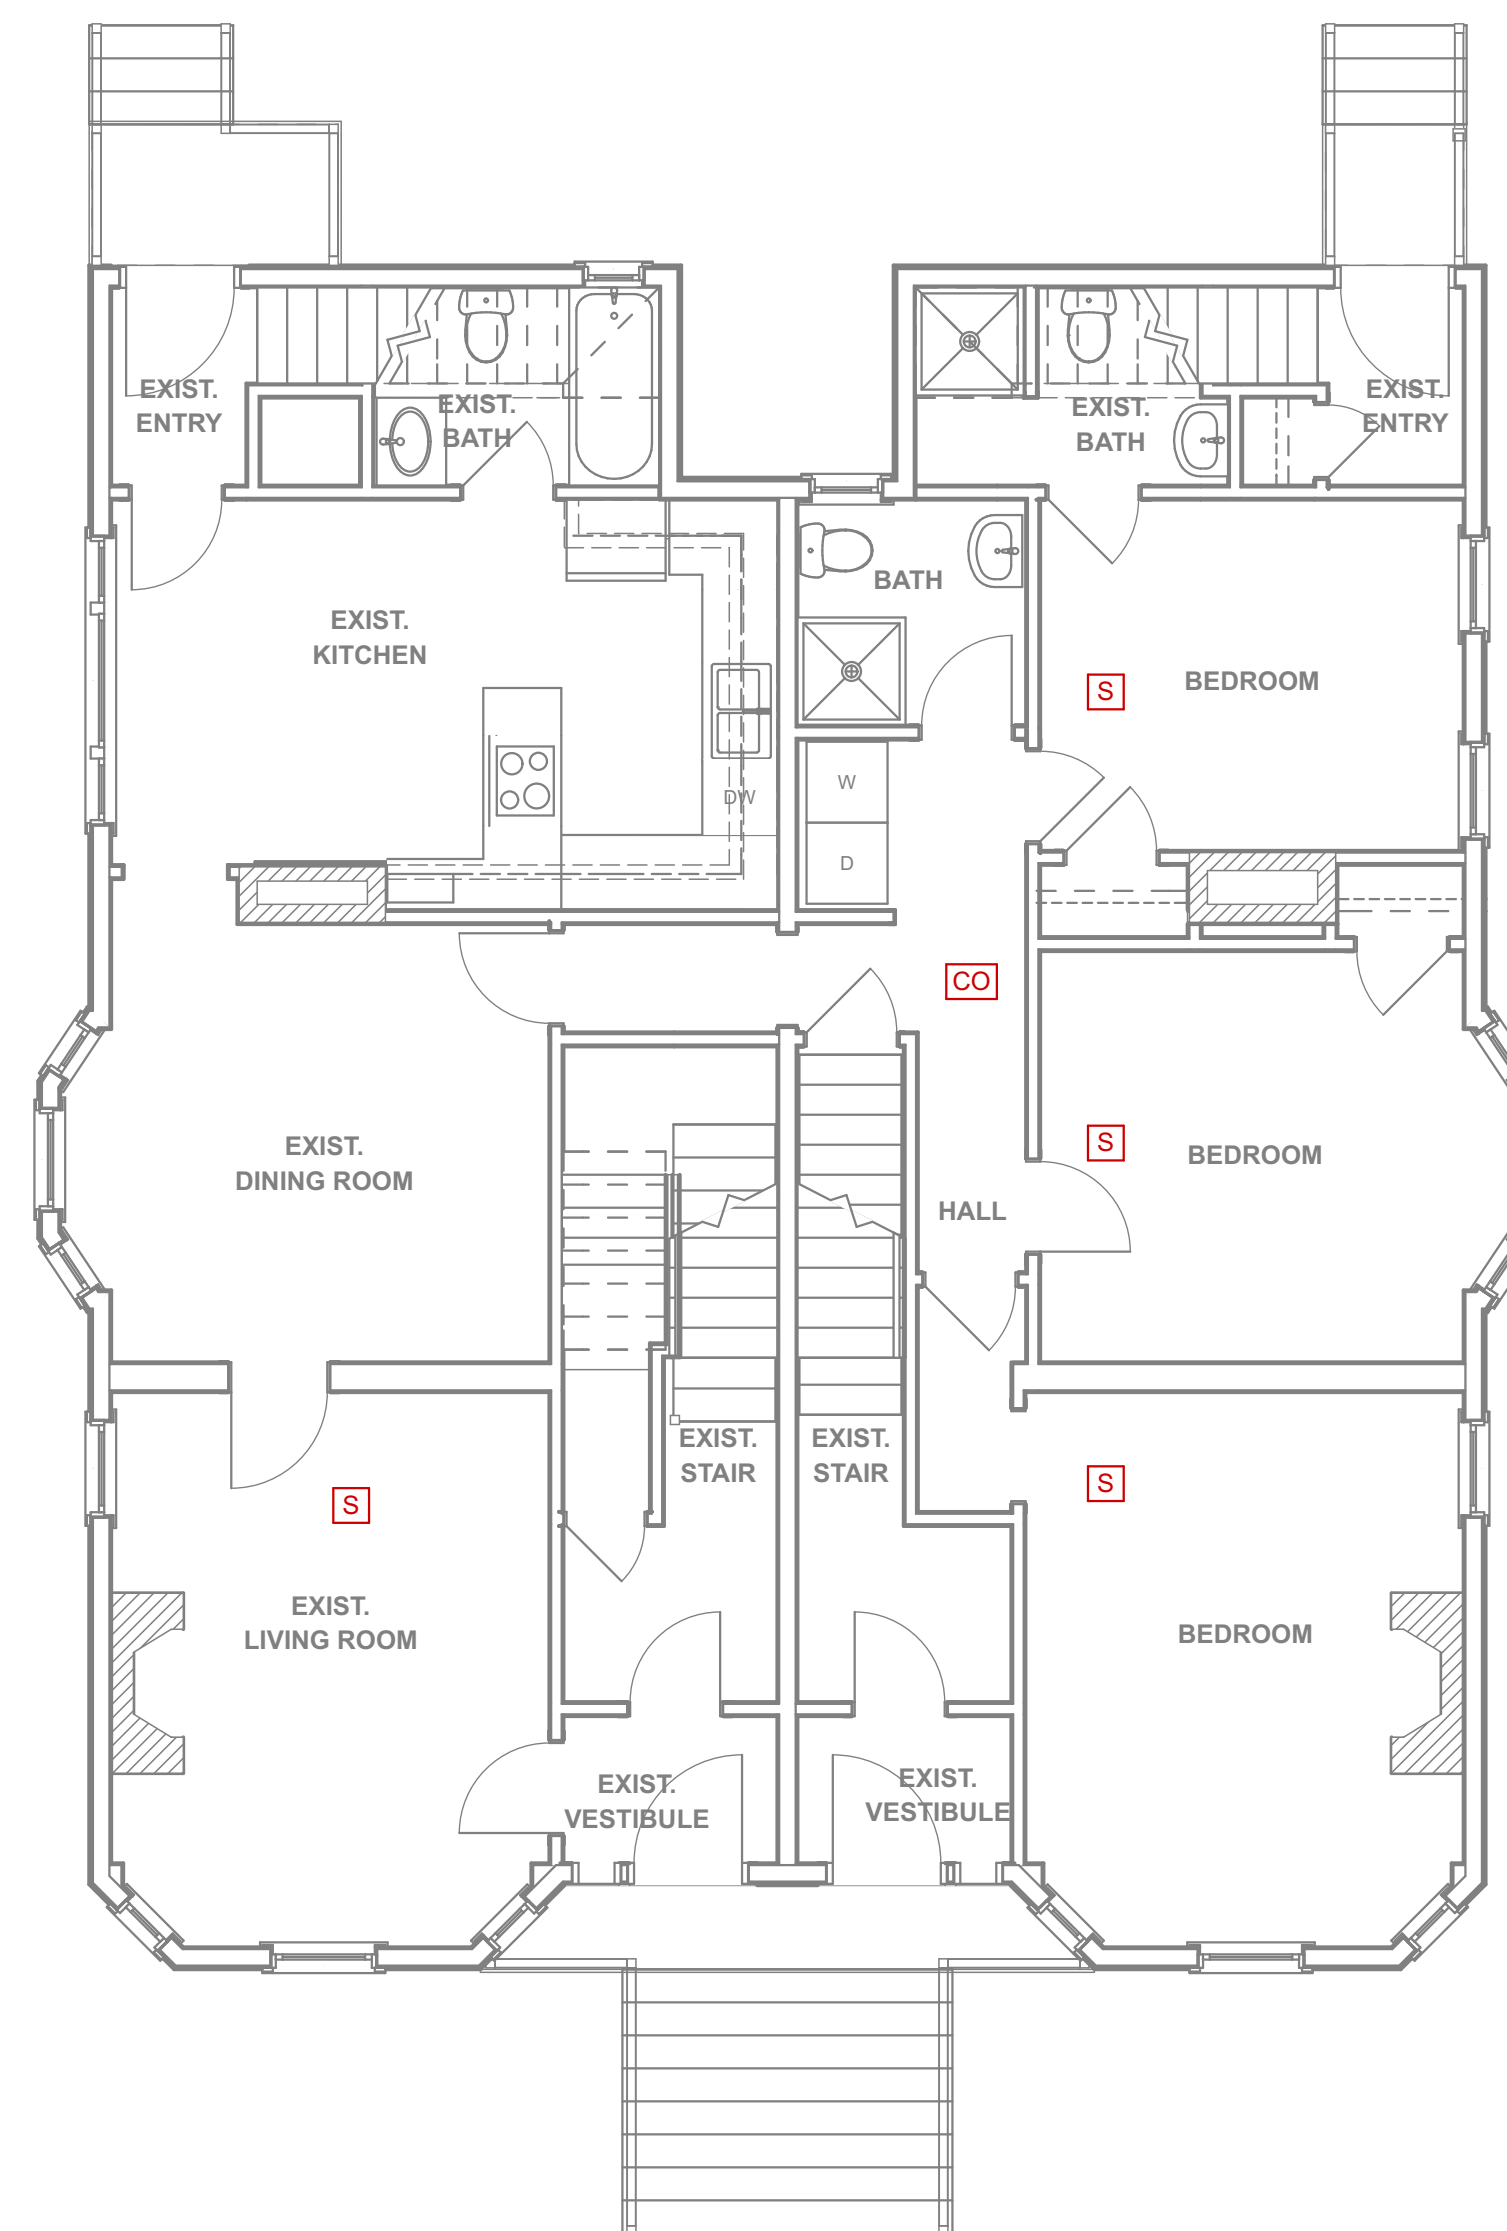

2 LIFE SAFETY FIRST FLOOR PLAN
 SCALE: 3/16" = 1'-0"