




1 LIFE SAFETY BASEMENT PLAN
 LS.1 SCALE: 3/16" = 1'-0"

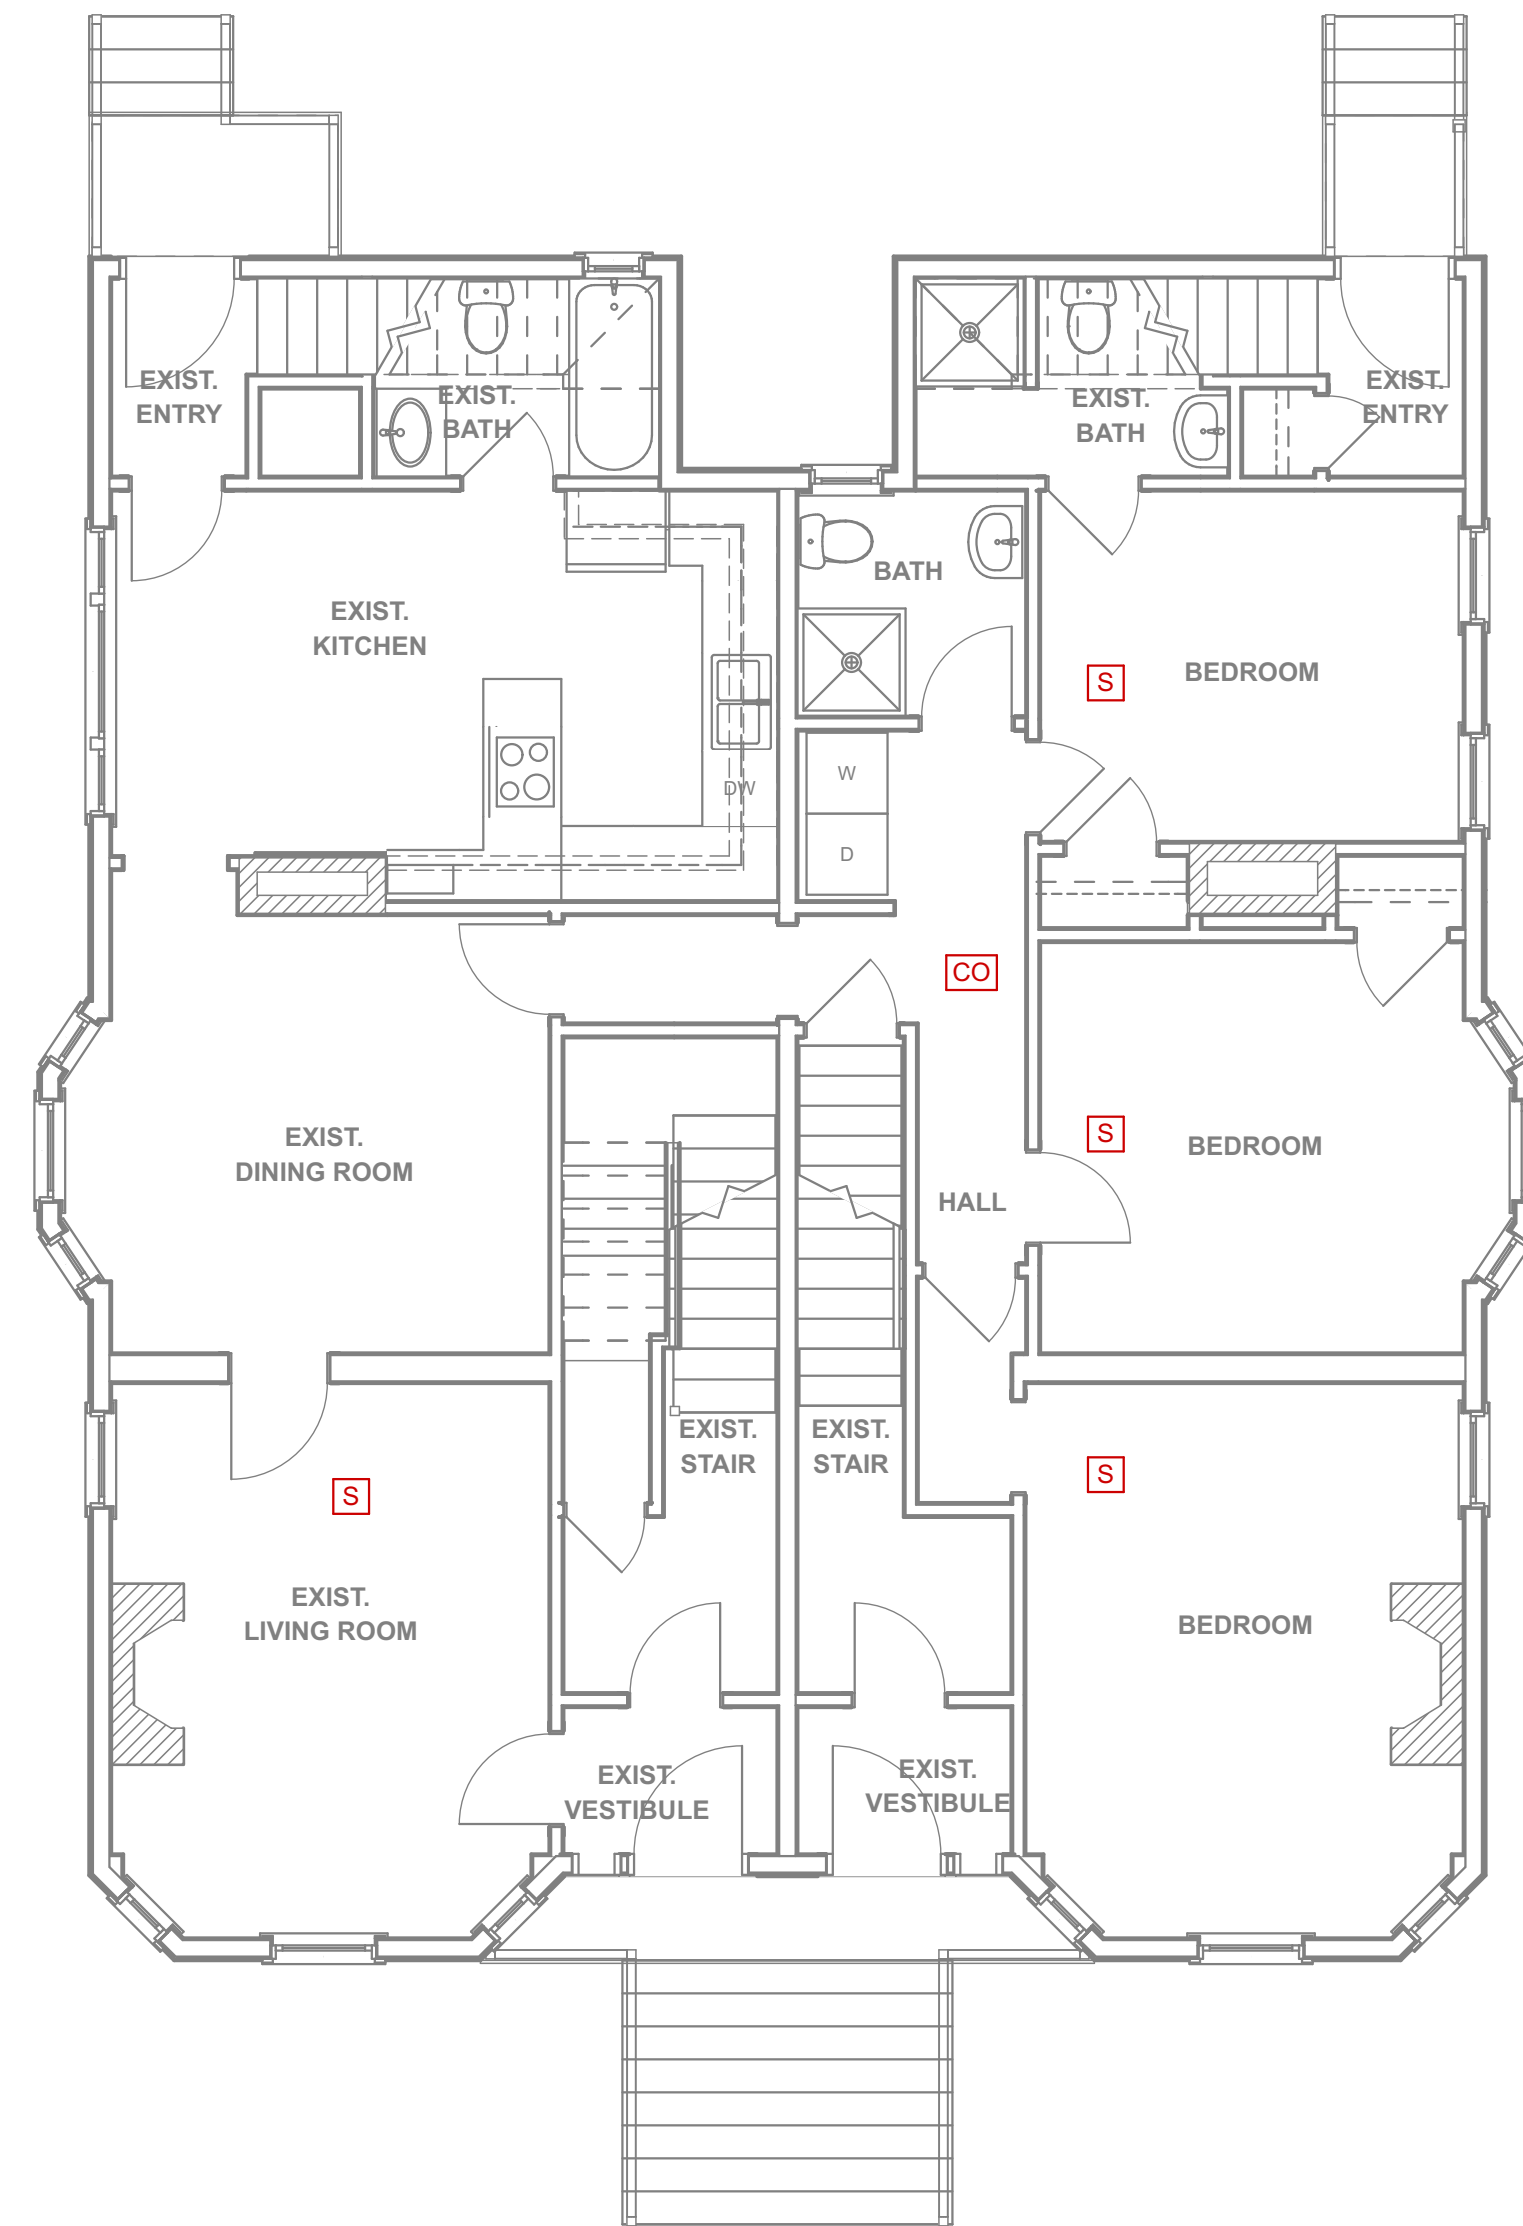

2 LIFE SAFETY FIRST FLOOR PLAN
 LS.1 SCALE: 3/16" = 1'-0"

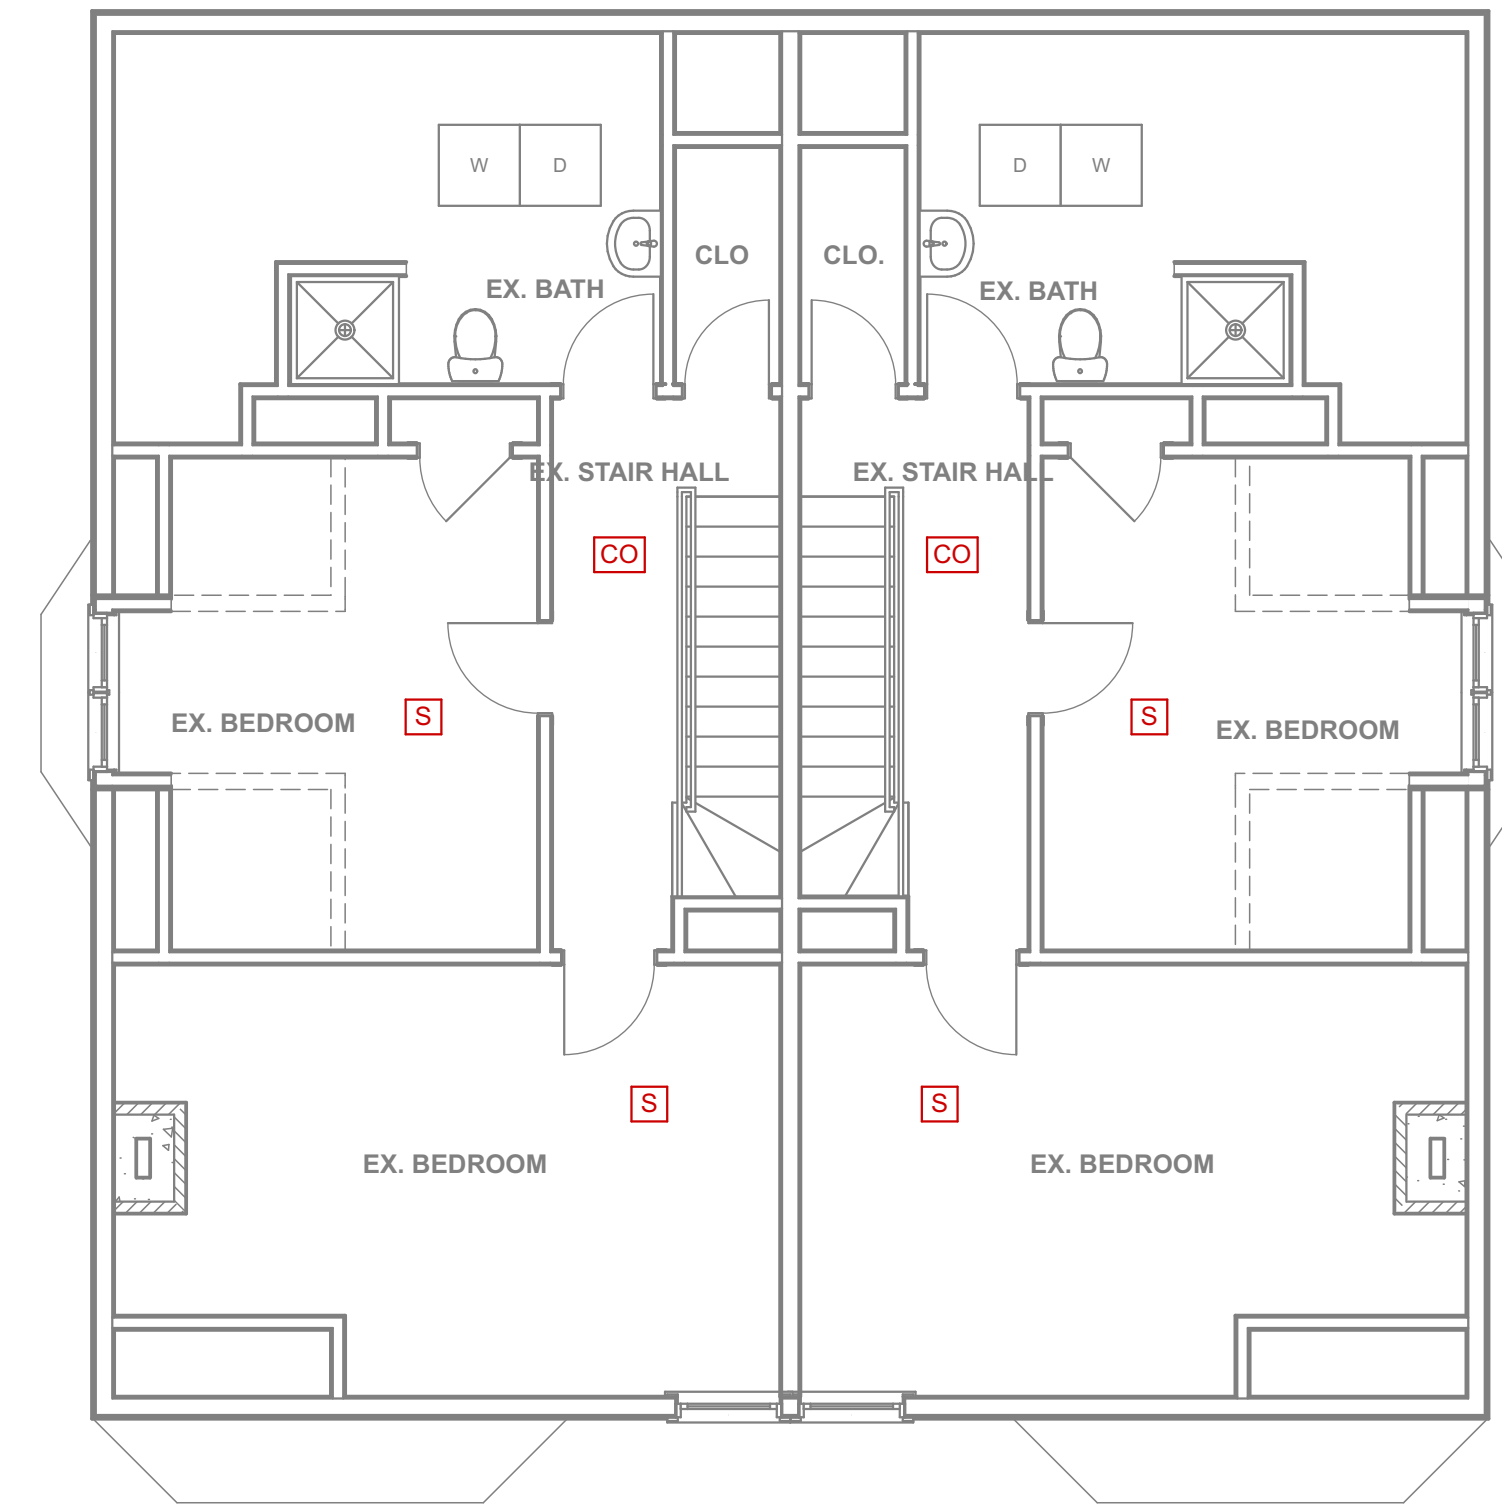

4 LIFE SAFETY THIRD FLOOR PLAN
 LS.1 SCALE: 3/16" = 1'-0"

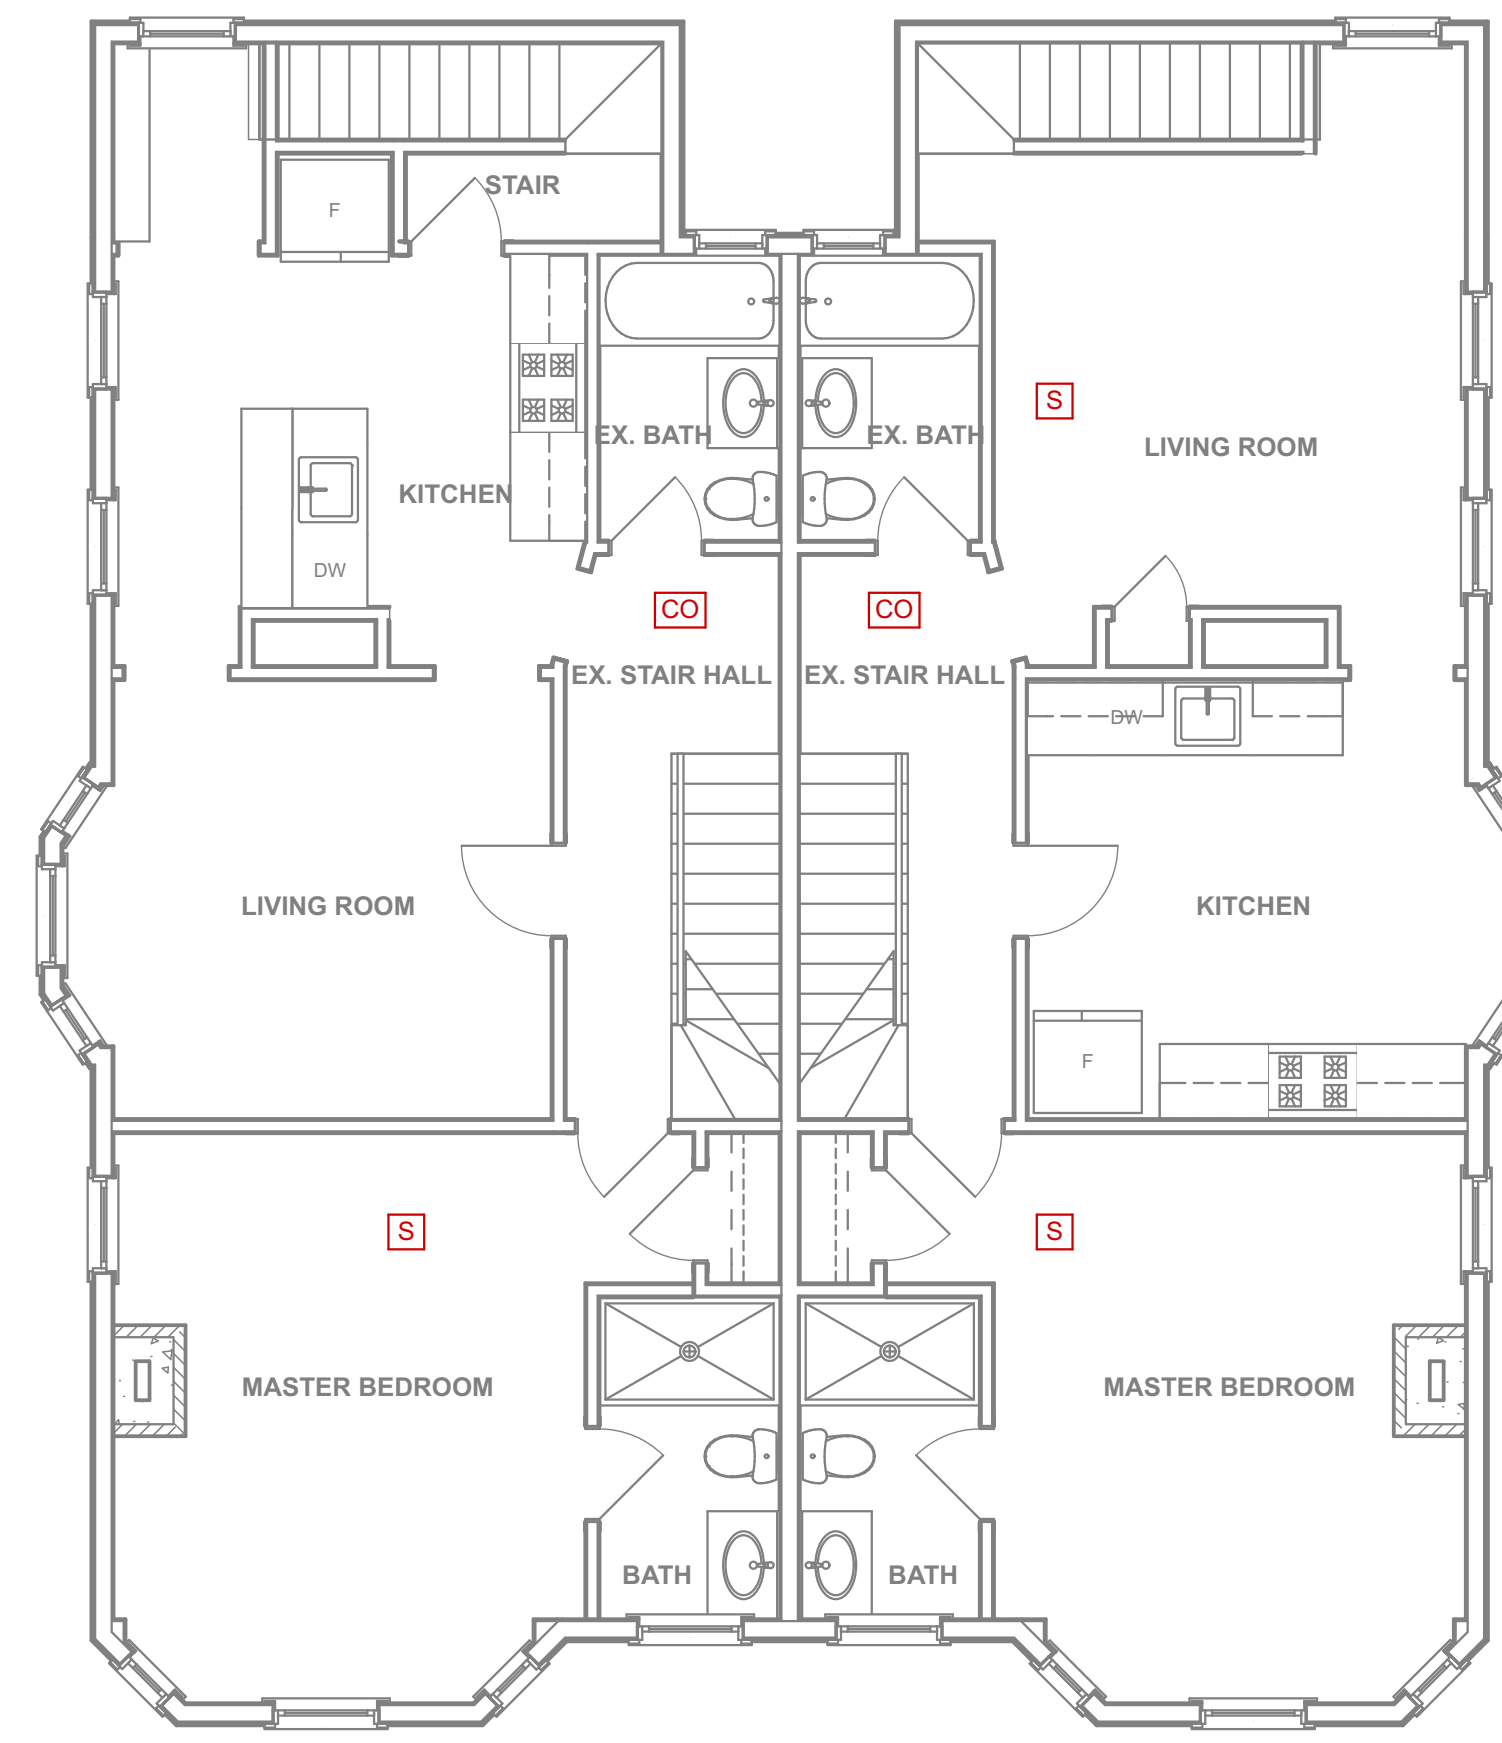

3 LIFE SAFETY SECOND FLOOR PLAN
 LS.1 SCALE: 3/16" = 1'-0"

- LIFE SAFETY LEGEND**
- S SMOKE DETECTOR
 - CO CARBON MONOXIDE DETECTOR



APARTMENT RENOVATION
 PORTLAND, MAINE

77 ROBERTS STREET

WHIPPLE CALLENDER ARCHITECTS

136 PLEASANT AVE.
 PORTLAND, ME 04103
 P 207.775.2696
 F 207.775.3631
 www.whipplecallender.com

MARK	DATE	DESCRIPTION
1	2.6.18	CODE RELATED NOTES ADDED

DATE: 2/6/18
 CHECKED BY: JAD
 DRAWN BY: CLBC
 JOB: ROB2017
 SHEET TITLE: LIFE SAFETY PLANS

LS.1