




FIRE ALARM SYSTEM LAYOUT - 1ST FLOOR  
SCALE: 1/8" = 1'


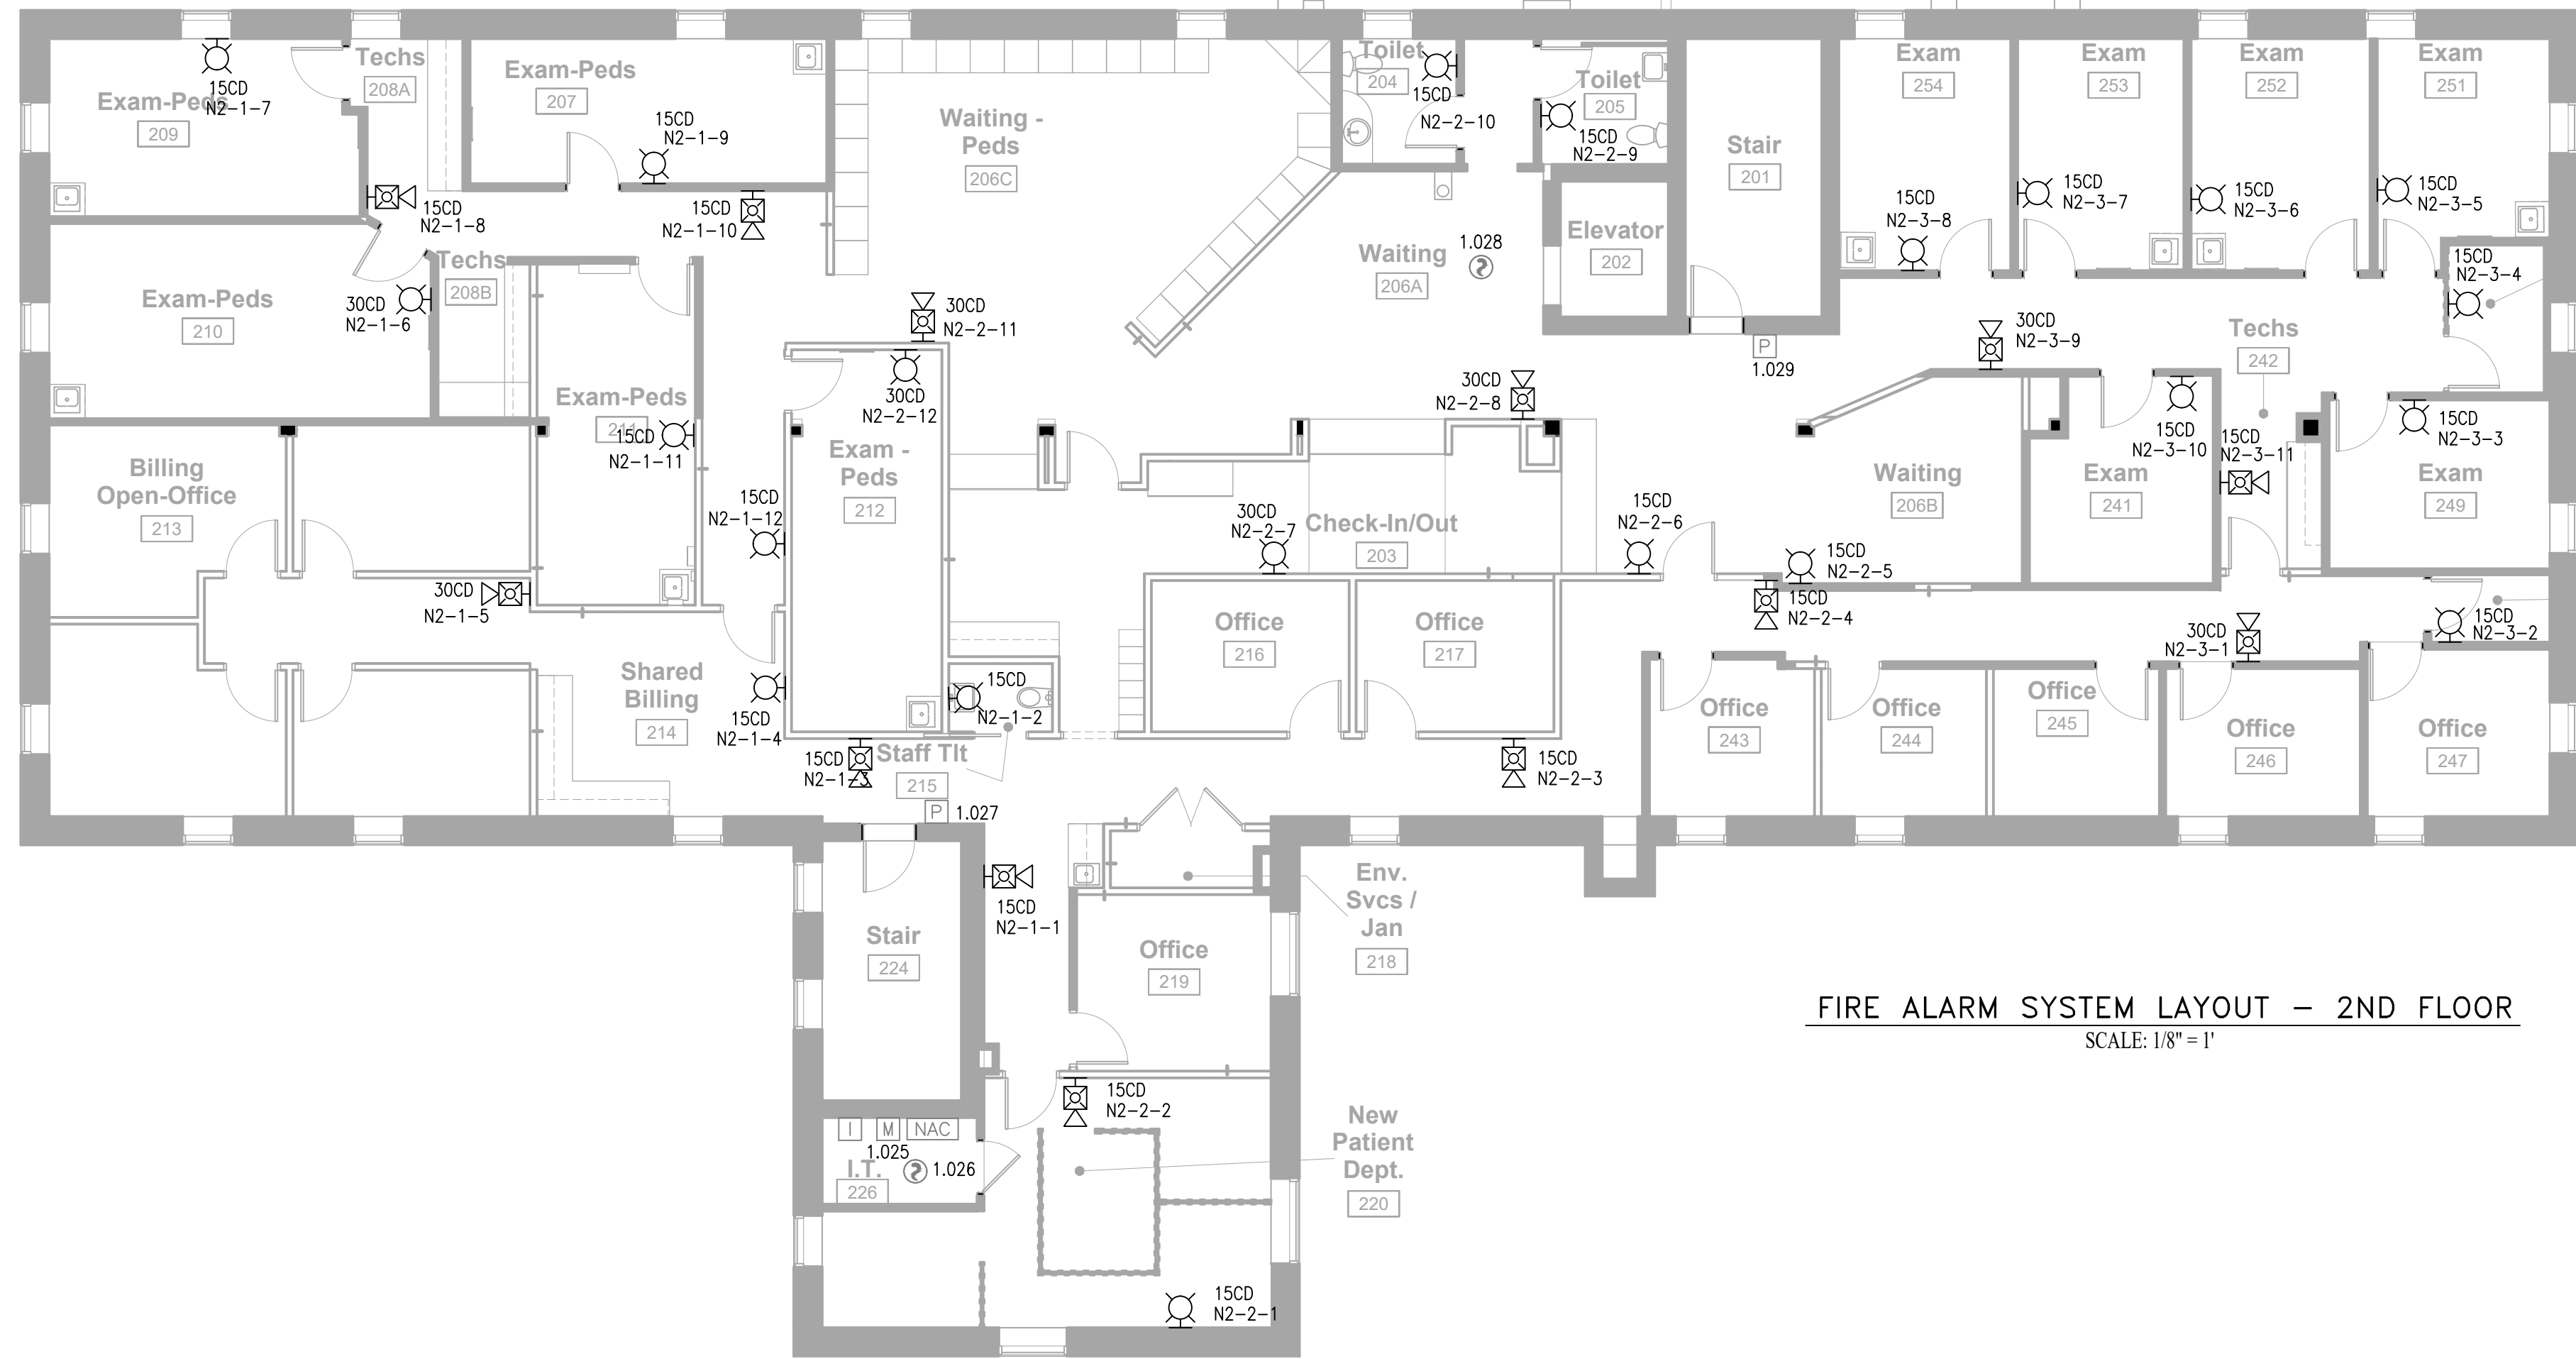


FIRE ALARM SYSTEM LAYOUT - 2ND FLOOR  
SCALE: 1/8" = 1'

SYMBOL LEGEND			
ITEM NO.	SYMBOL	QTY. TOTAL	DESCRIPTION
1	○	10	STANDARD BASE (DB-11) - OCTAGON BOX
2	⦿	1	HEAT DETECTOR (H921) - MOUNTS ON DB-11
3	⌈	3	LINE ISOLATOR (HLIM) - 4" SQUARE
4	DM	1	DUAL MONITOR MODULE (HTRI-D) - 4" SQUARE
5	M	3	MONITOR MODULE (HTRI-S) - 4" SQUARE
6	P	9	PULL STATION (MSM-KD/HTRI-M) - SINGLE GANG
7	RM	4	INPUT/OUTPUT MODULE (HTRI-R) - 4" SQUARE
8	⊗	9	SMOKE DETECTOR (OH921) - MOUNTS ON DB-11
9	⊗ XX	53	HORN/STROBE (2H-MC-R) - SINGLE GANG OR 4" SQUARE
10	⊗ XX	88	STROBE (2R-MC-R) - SINGLE GANG OR 4" SQUARE
11	ANN	1	ANNUNCIATOR (FT-2015)
12	FACP	1	FIRE ALARM CONTROL PANEL (FC-922)
13	NAC	3	NAC PANEL (PAD-4)

ITEM NO.	SYMBOL LEGEND													ITEM NO.
	A	B	C	D	E	G	H	I	J	K	L	M	N	
1	X			X	X	X	X							1
2	X			X	X	X	X							2
3	X			X	X	X	X							3
4			X	X	X			X						4
5			X	X	X		X							5
6			X	X	X		X							6
7			X	X	X		X							7
8			X	X	X		X							8
9			X	X	X		X							9
10	X		X	X	X		X		X					10
11	X		X	X	X		X			X				11
12	X		X	X	X		X				X			12
13	X		X	X	X		X					X		13

FIRE ALARM SYSTEM I/O MATRIX  
SCALE: 1/8" = 1'

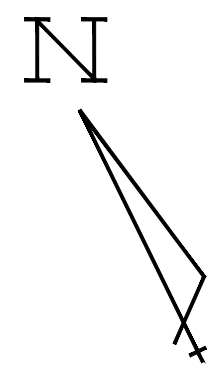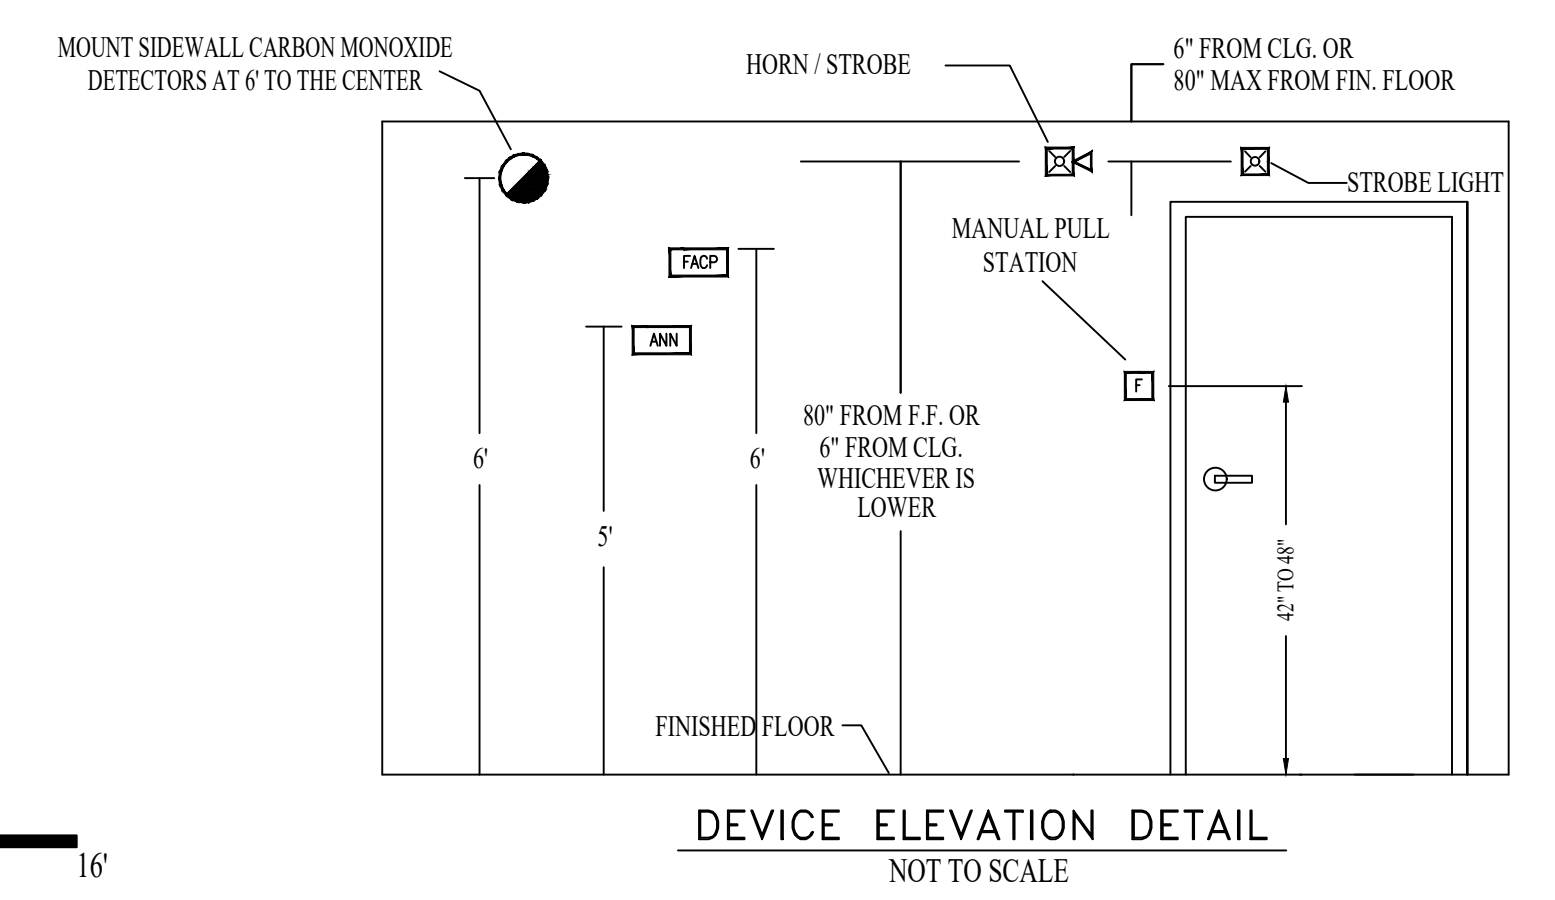

1/8"=1' SCALE 0 4 8 16'

DATE	REVISIONS	REQUIRED APPROVALS	<b>MAINE EYE CARE</b> 15 LOWELL ST PORTLAND, ME 04102 CONTRACT WITH: DEBLOIS ELECTRIC <b>EASTERN FIRE</b> <small>FIRE PROTECTION CONTRACTORS AND ENGINEERS</small> <small>Home Office: 170 Ketchikan Ave., P.O. Box 1390, Auburn, ME 04210-1390, 207-584-1507</small> <small>Satellite Office: 480 Barrow St., Bangor, ME 04401, 207-942-8014</small>	FIRE ALARM SYSTEM
		OWNER / ARCHITECT STATE FIRE MARSHAL LOCAL FIRE MARSHAL OWNERS INSURANCE CO.		PLANS & DETAILS DWG. NO. FA-2 JOB NUMBER 1-0583-FA-17 SCALE AS NOTED DATE 9/12/17
		DRAWN BY DYB CHECKED BY CONTRACTOR LICENSE #		