




ELECTRICAL PLAN - TYPE A UNIT
SCALE: 1/4" = 1'-0"

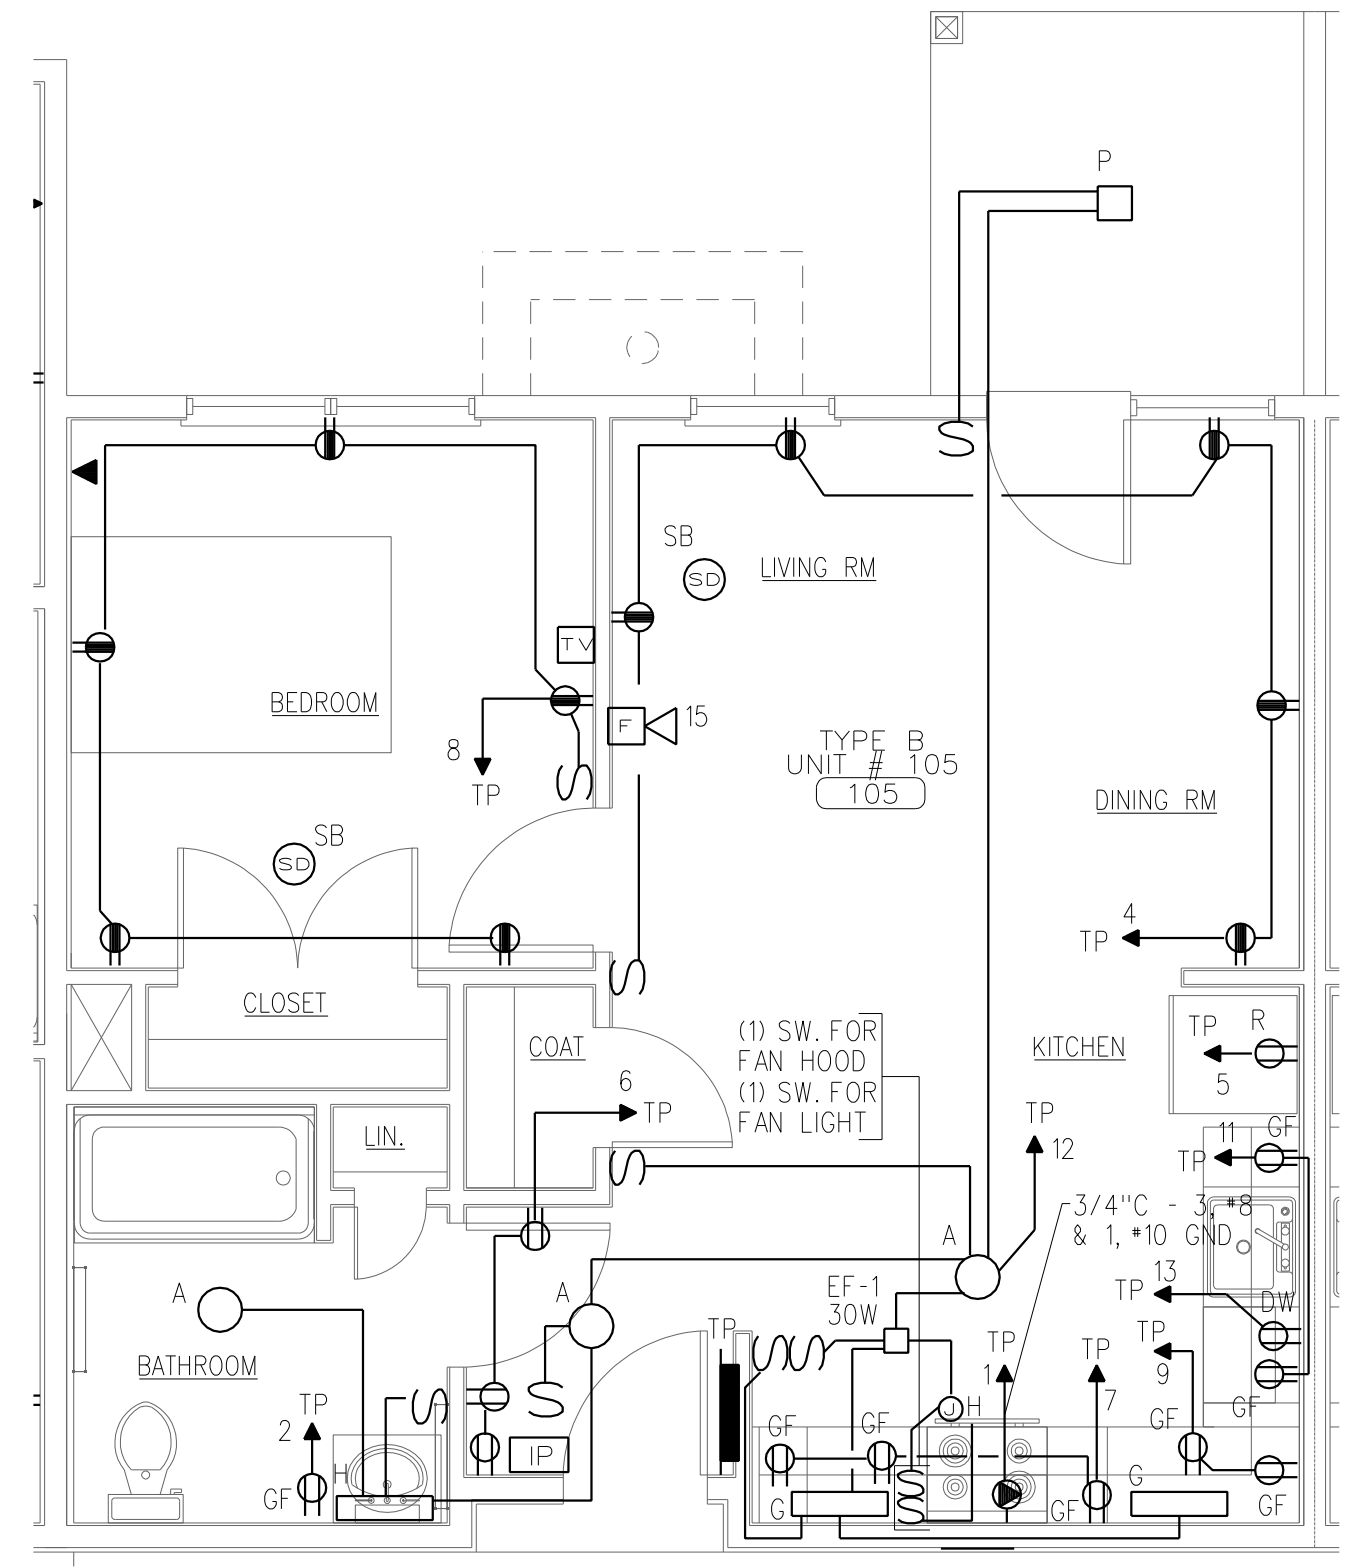


ELECTRICAL PLAN - TYPE B UNIT
SCALE: 1/4" = 1'-0"

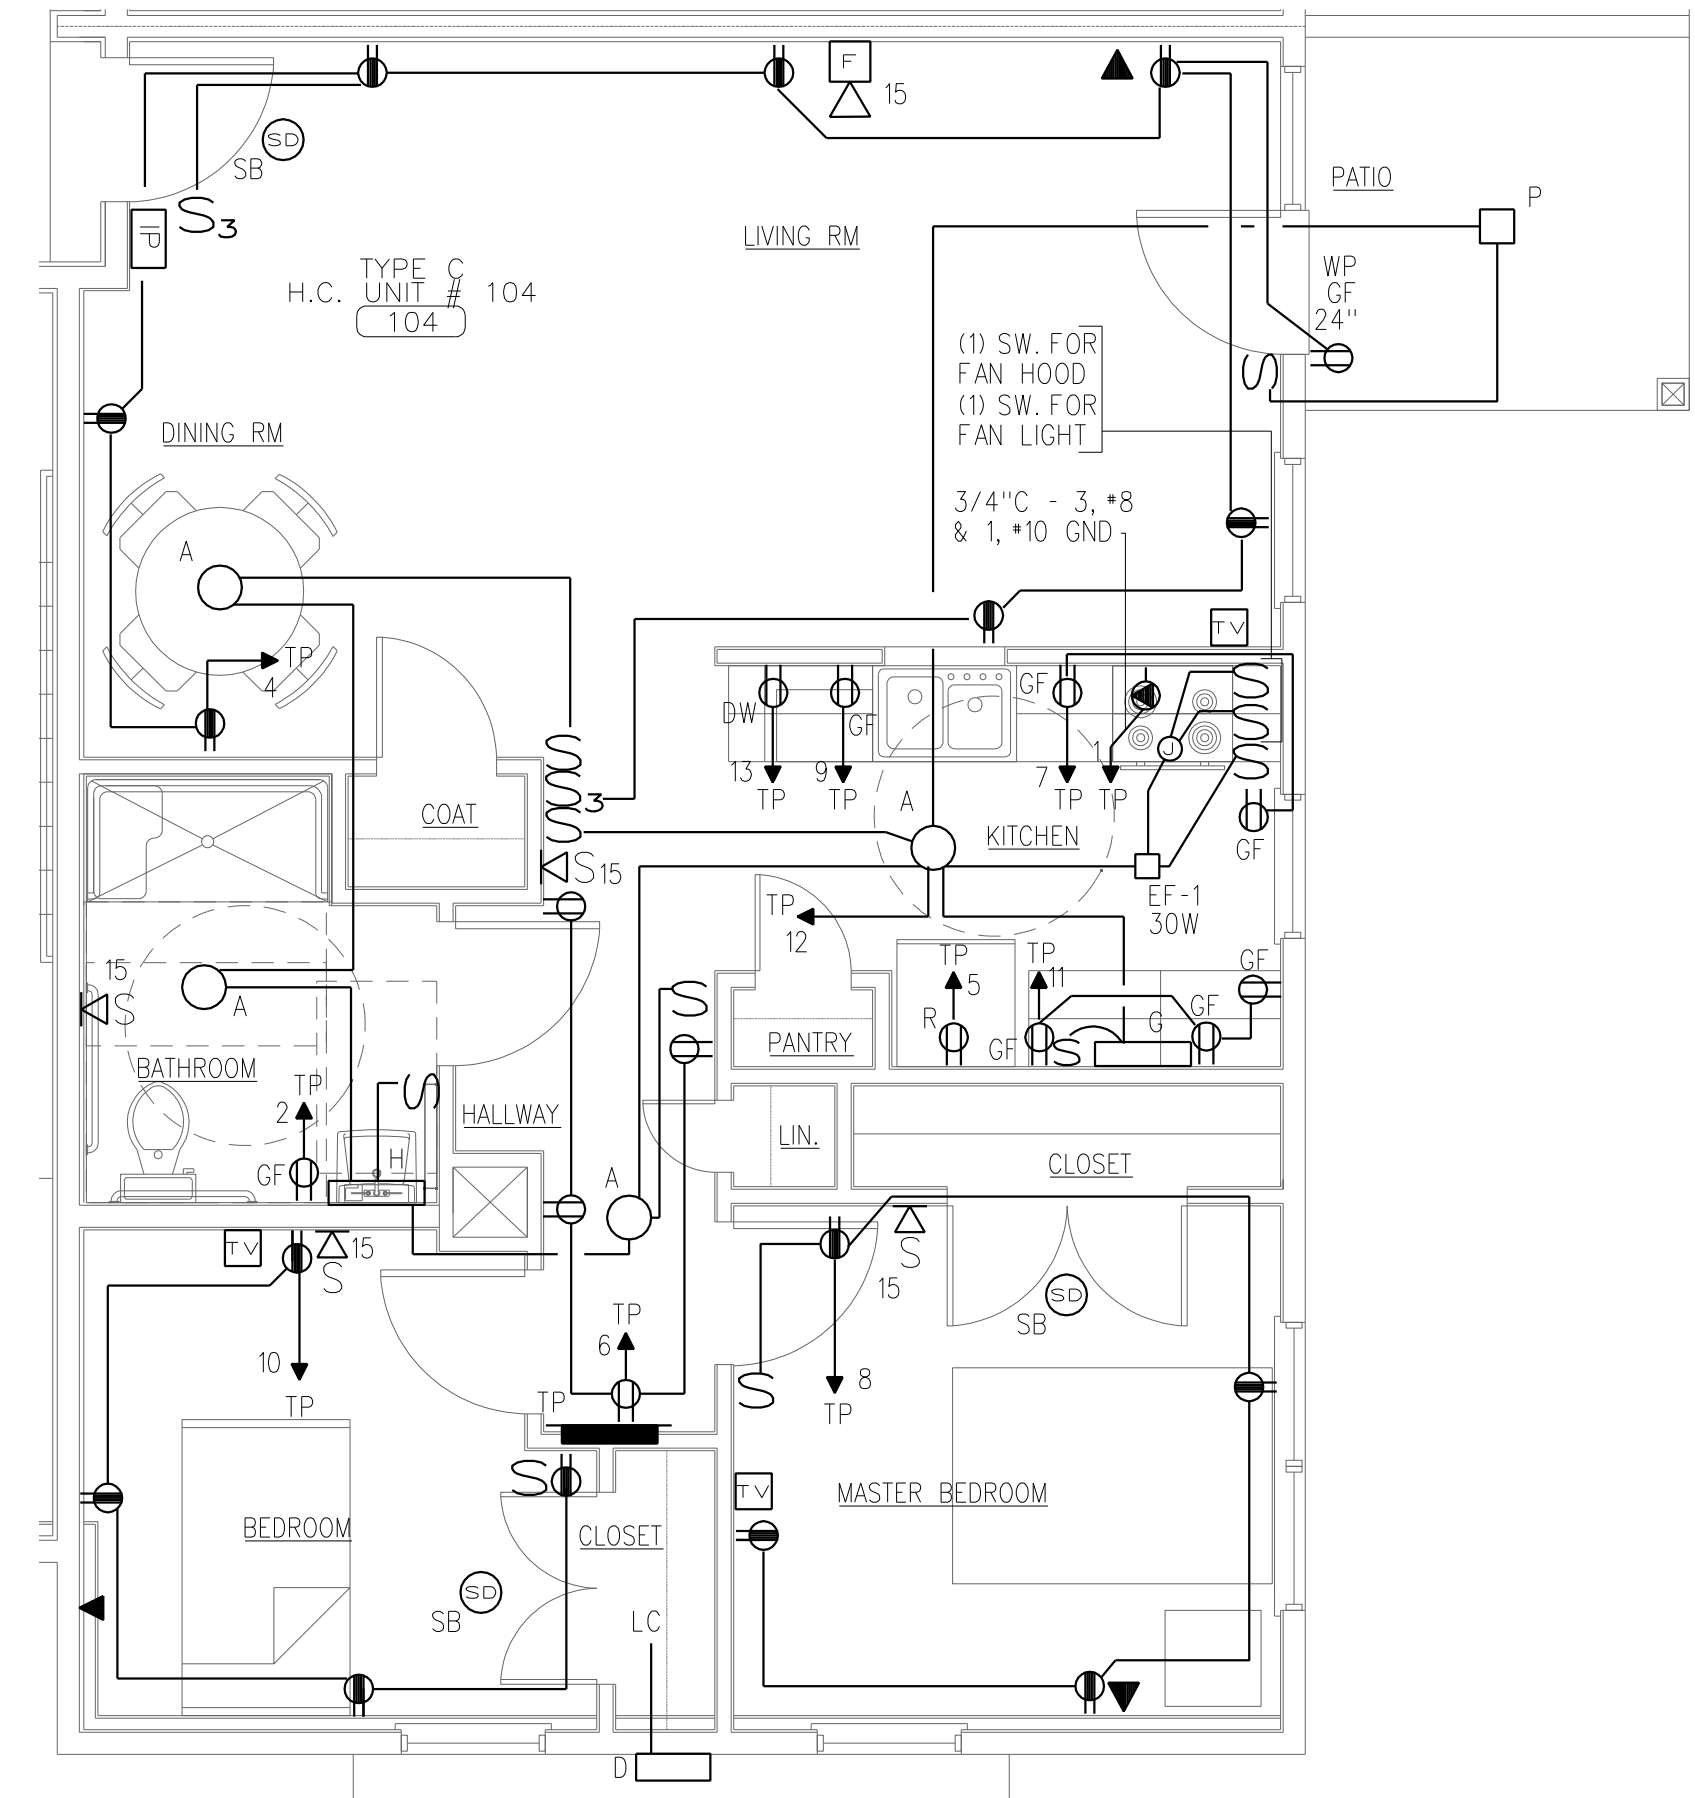

ELECTRICAL PLAN - TYPE C H.C. UNIT
SCALE: 1/4" = 1'-0"

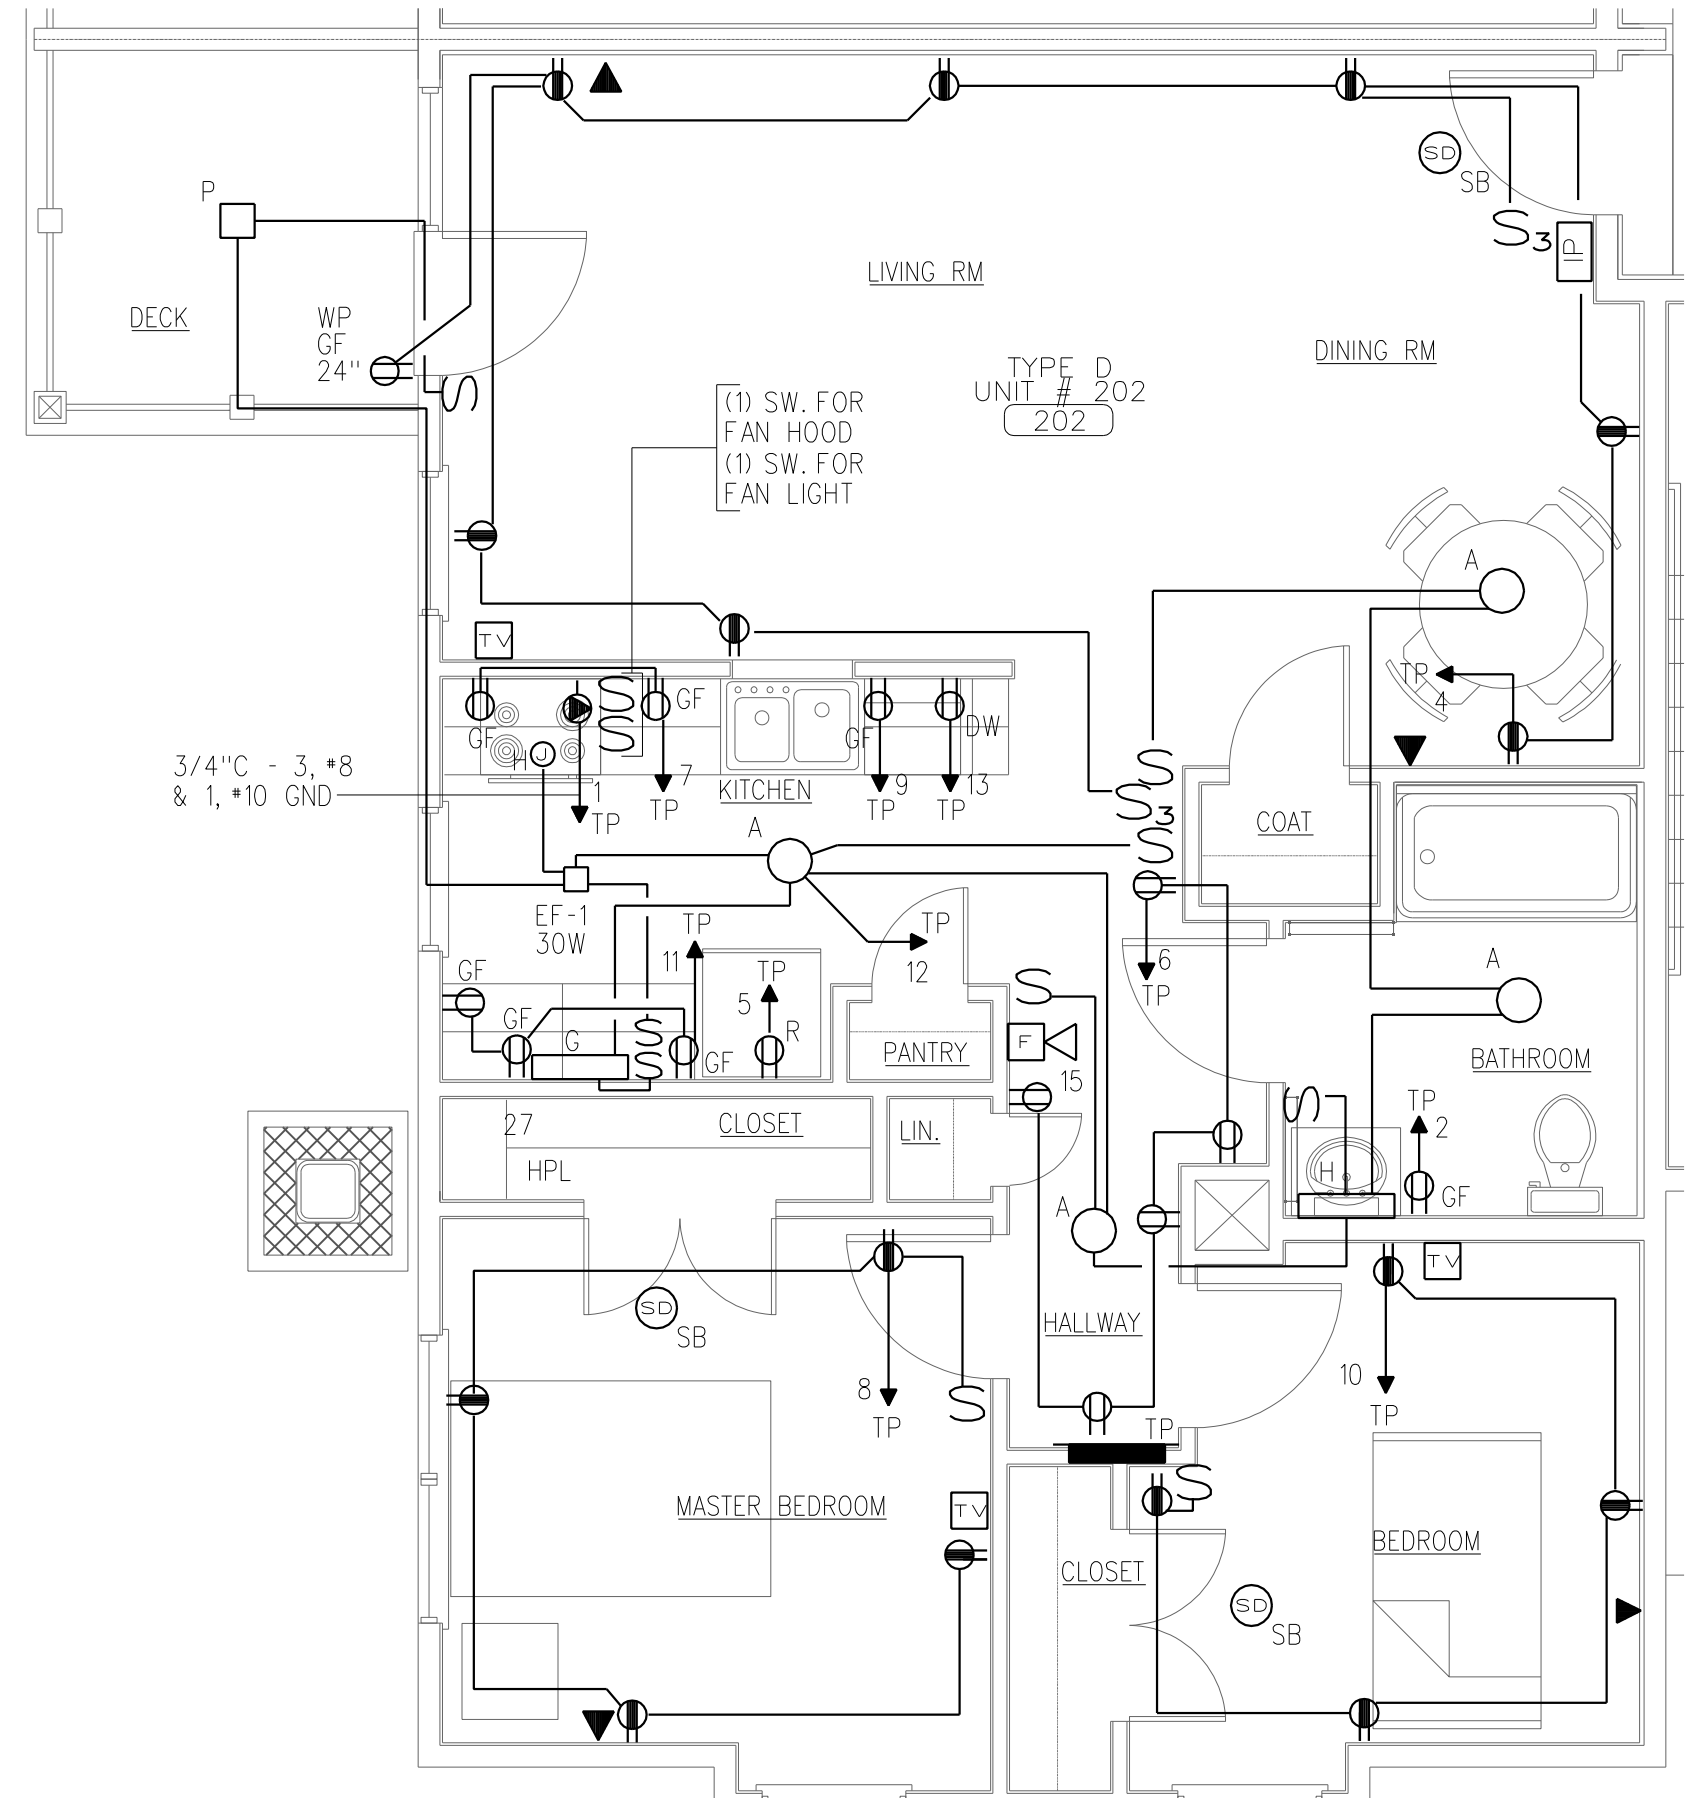

ELECTRICAL PLAN - TYPE D UNIT
SCALE: 1/4" = 1'-0"

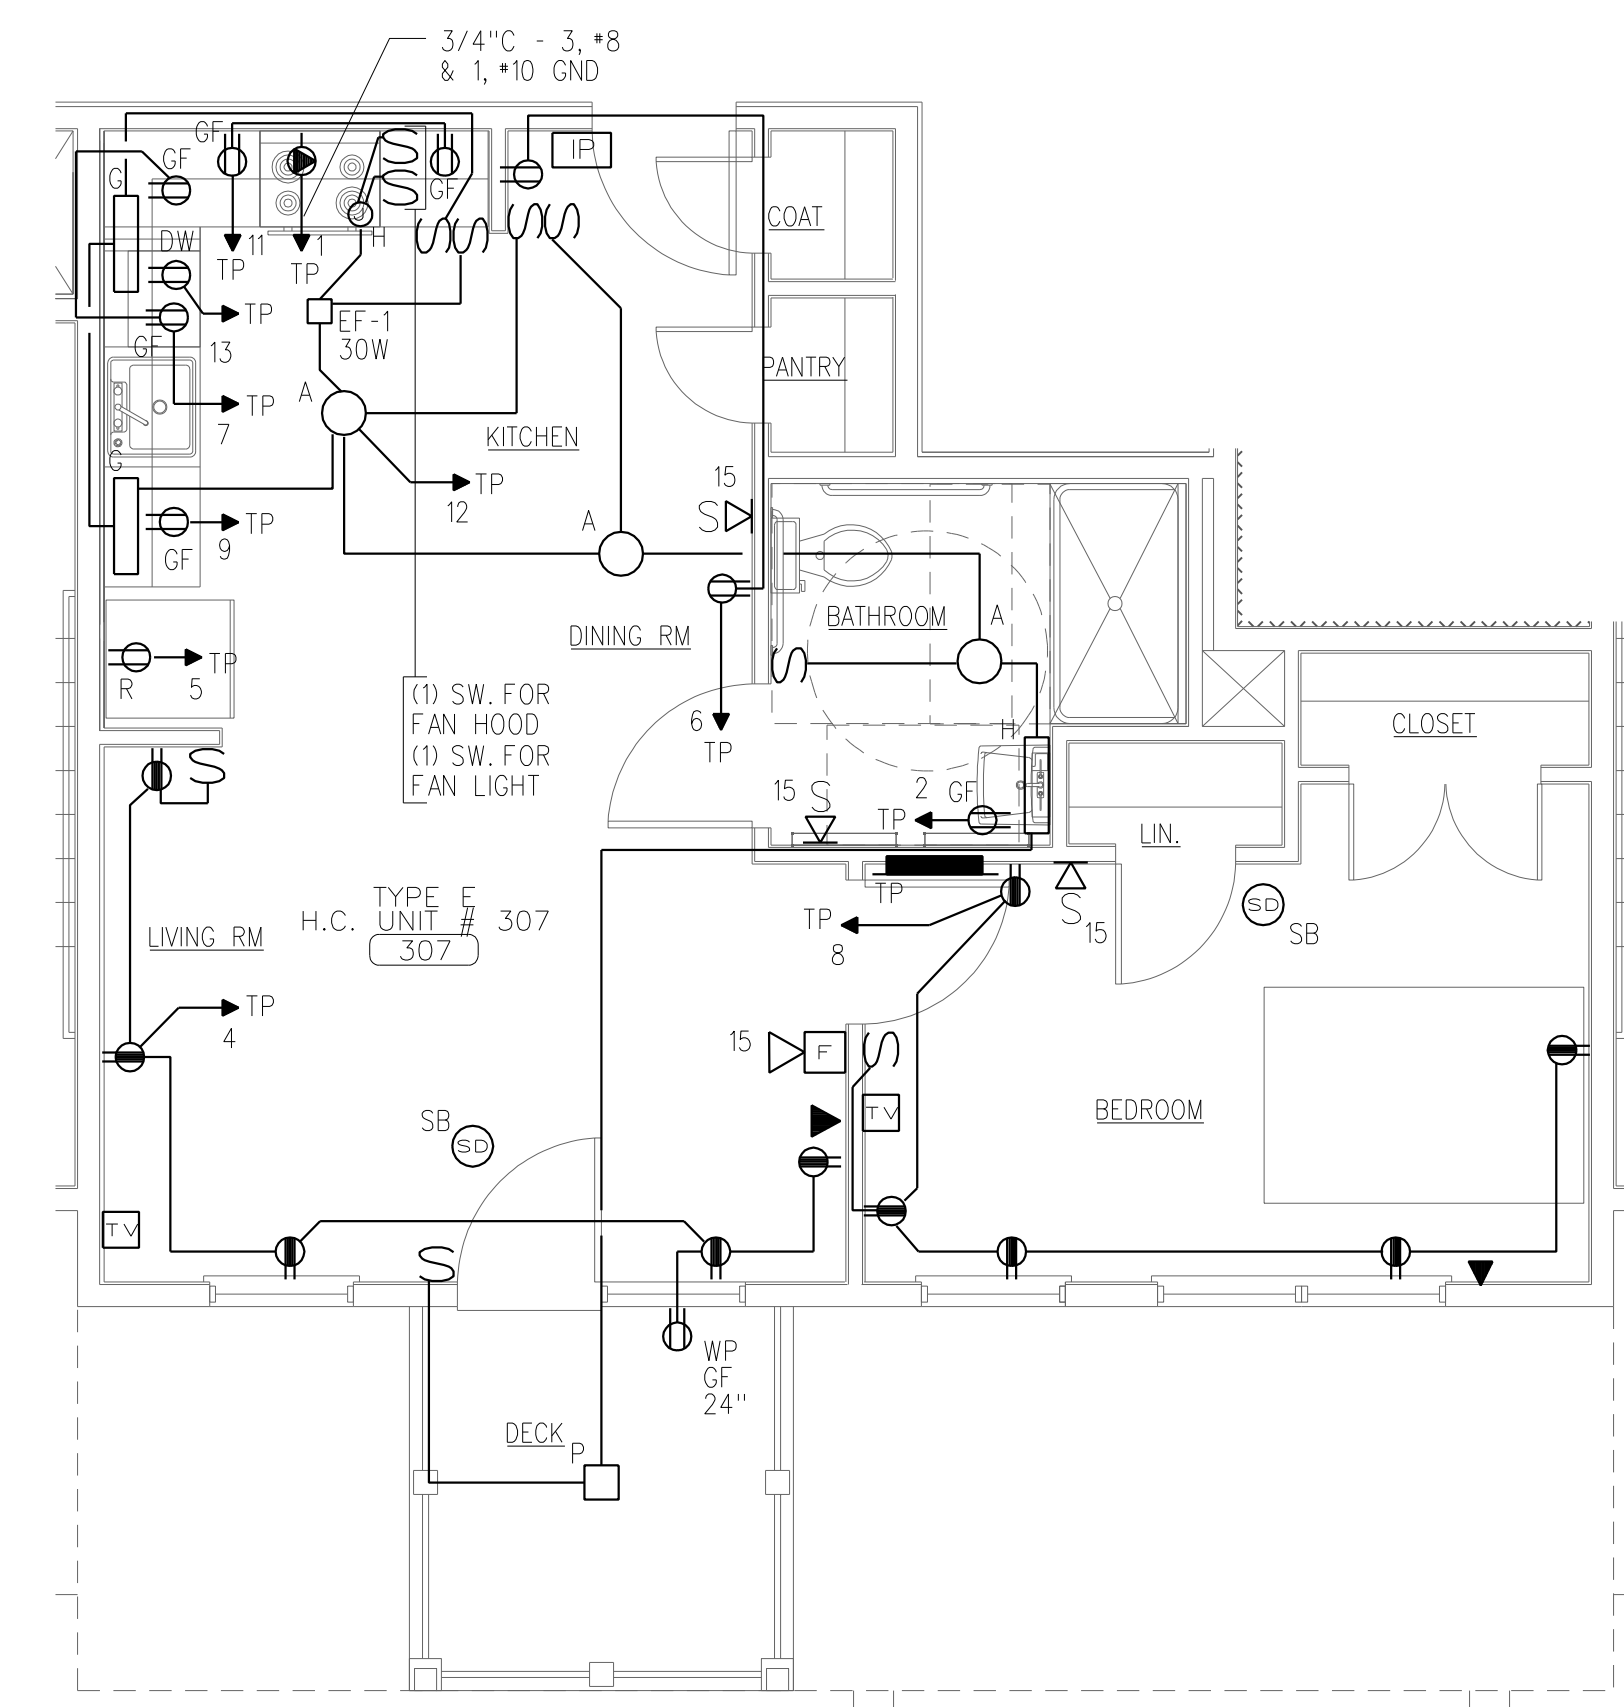

ELECTRICAL PLAN - TYPE E H.C. UNIT
SCALE: 1/4" = 1'-0"

PROJECT:		SINGLE PHASE		PANEL DESIGNATION:	
FORE RIVER APARTMENTS PORTLAND, ME		PANELBOARD SCHEDULE		TP (TYPICAL TENANT PANEL)	
MAIN LUGS: 100A		RECESSED			
		VOLTS: 120/208		PHASE: 1	
		WIRE: 3			
KVA LOAD		A	C		KVA LOAD
4.0	RANGE	1-2P	20-2P	BATHROOM OUTLET	1.5
4.0		30	20	4 OUTLETS - LIVING ROOM	1.4
1.5	REFRIGERATOR	5-20	20	6 OUTLETS	1.4
1.5	COUNTER OUTLET	7-20	20	8 OUTLETS - BEDROOM	.80
1.5	COUNTER OUTLET	9-20	20	10 OUTLETS - BEDROOM	.80
1.5	COUNTER OUTLET	11-20	20	12 LIGHTING	1.0
1.0	DISHWASHER	13-20	20	14 SPARE	
	SPACE	15	16	SPACE	
		17	18		
		19	20		
		21	22		
		23	24		
TOTAL CONN. LOAD: 21.9 KVA		TOTAL DEM. LOAD: _____			

x PROVIDE ARC FAULT TYPE CIRCUIT BREAKER.
xx PROVIDE 1P, 20A SPARE FOR 1BEDROOM UNITS.