


- △
- △
- △
- △
- △
- △

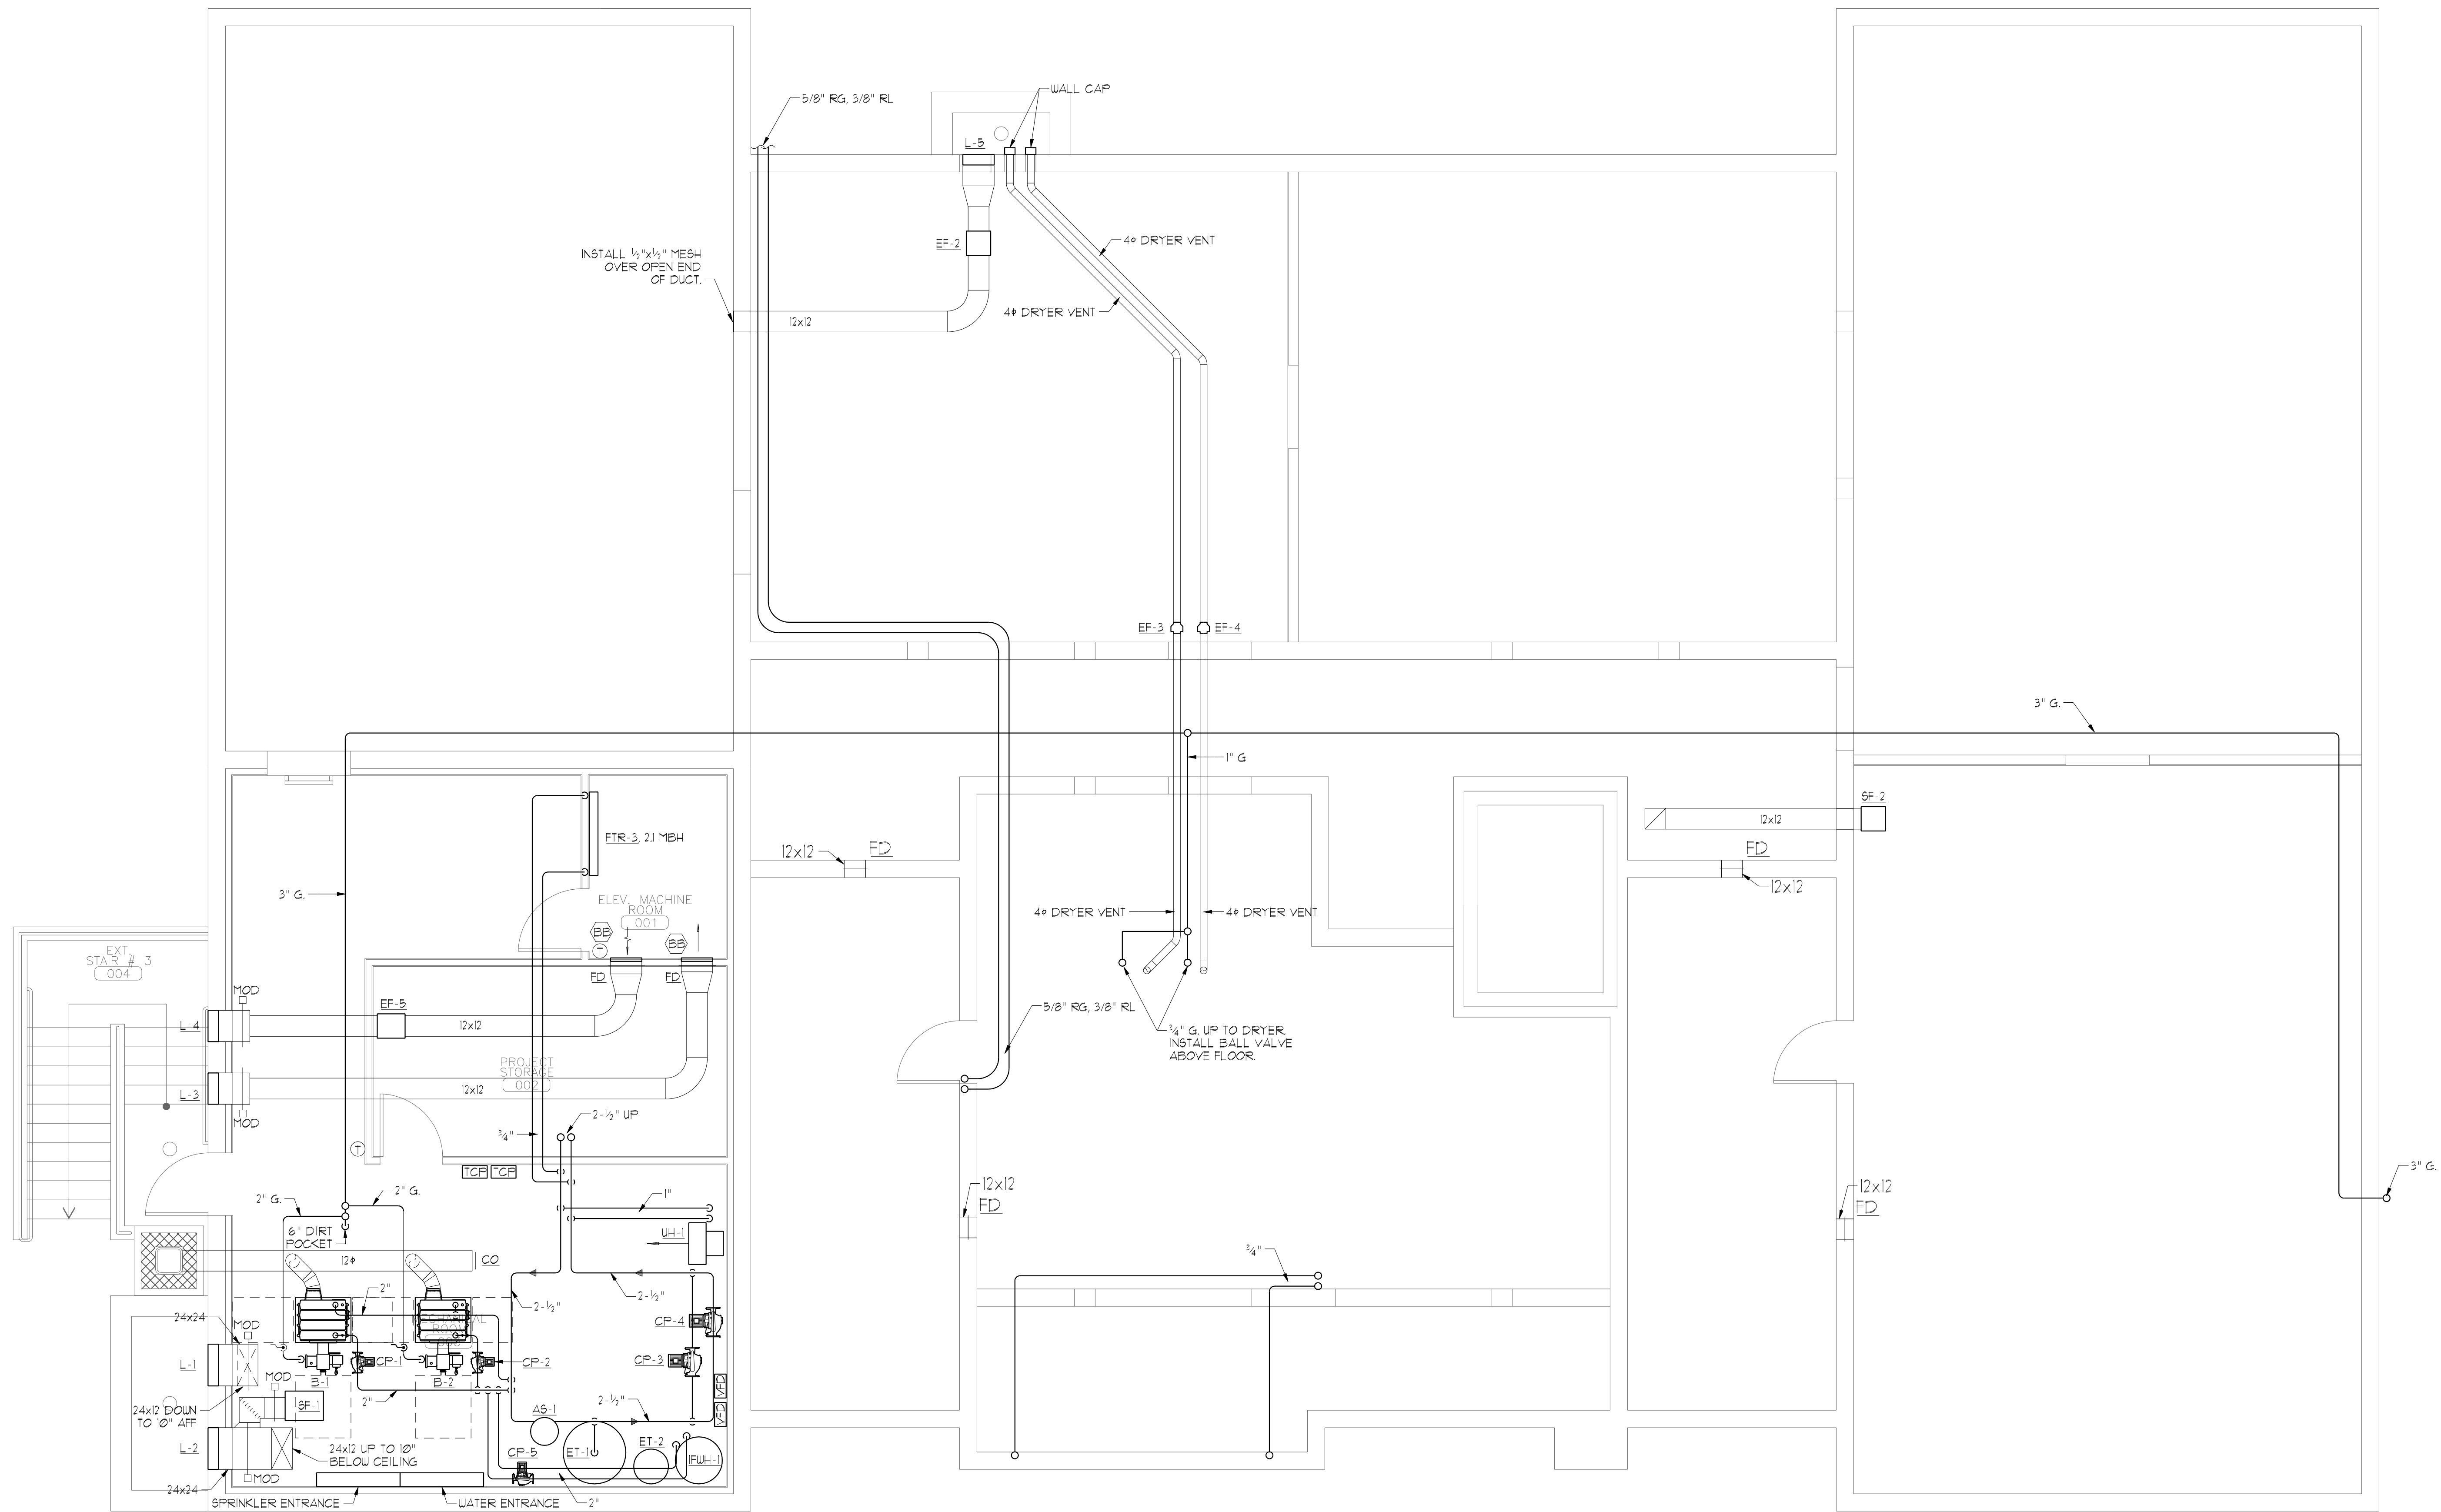

CRAWL SPACE/BASEMENT MECHANICAL PLAN
 SCALE 1/4" = 1'-0"