


- ▲
- ▲
- ▲
- ▲
- ▲
- ▲

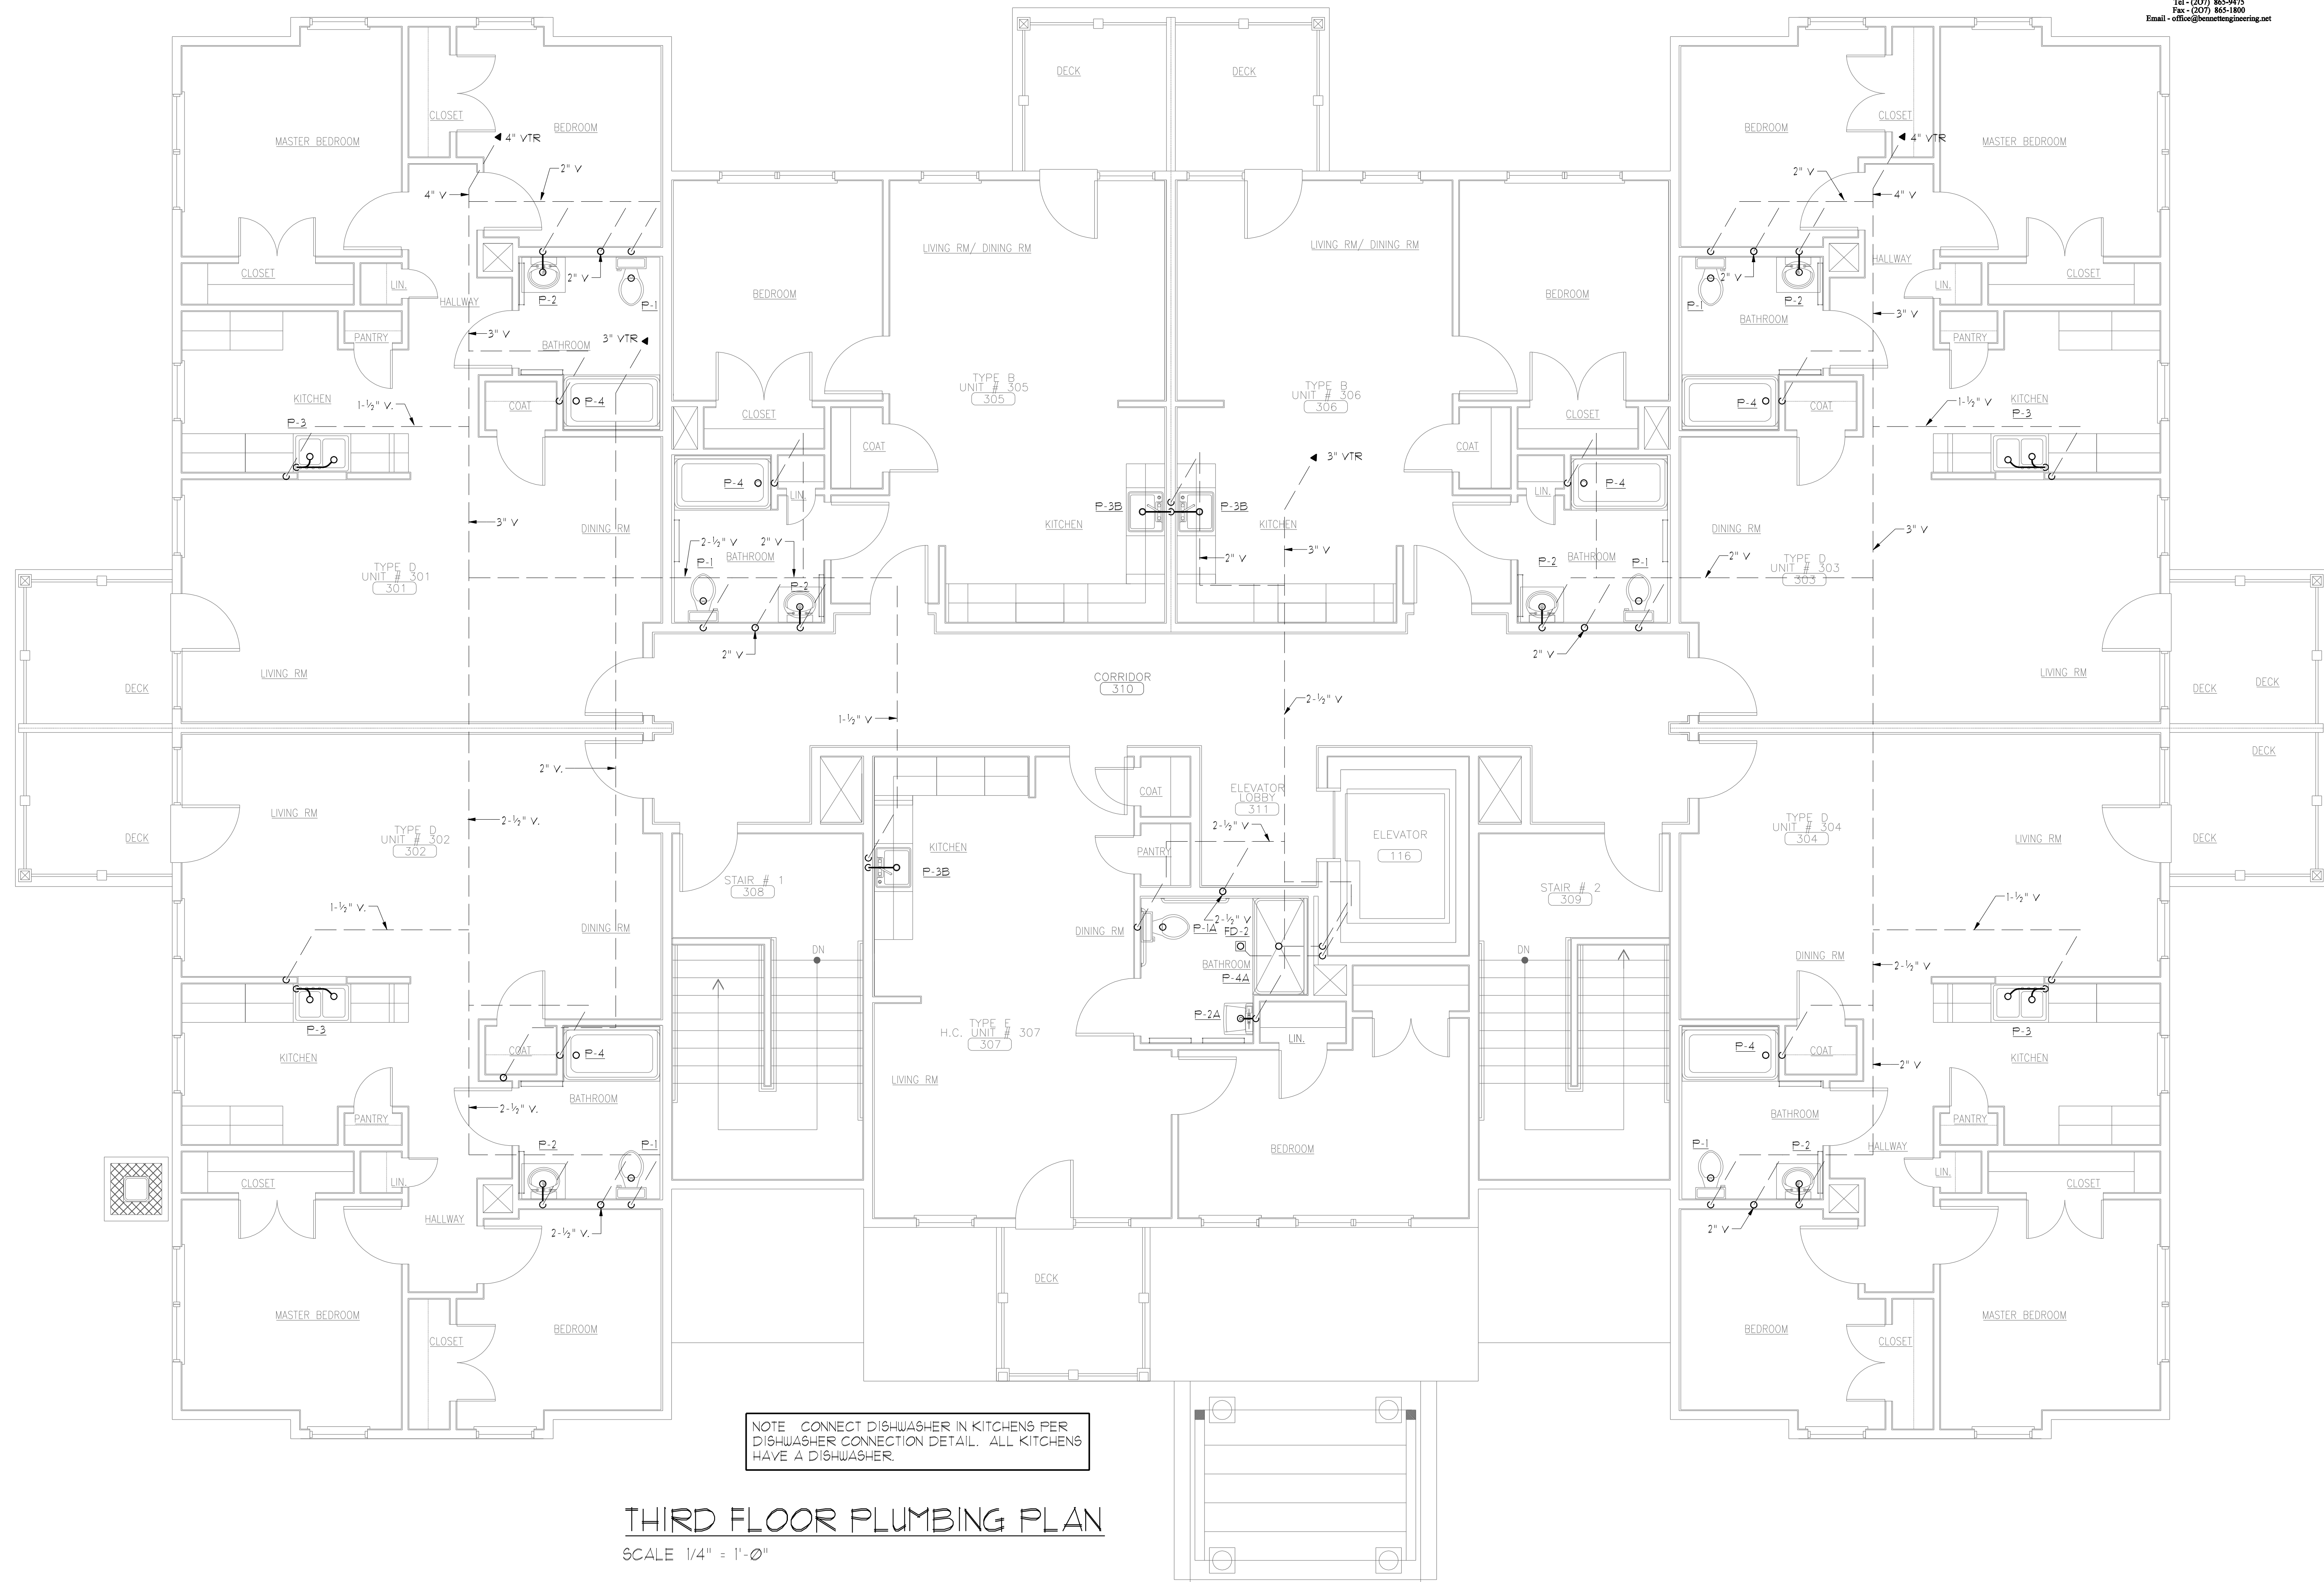

THIRD FLOOR PLUMBING PLAN

SCALE 1/4" = 1'-0"