




**ROUND/FLAT OVAL FIRE DAMPER  
 INSTALLATION DETAIL**  
 NTS

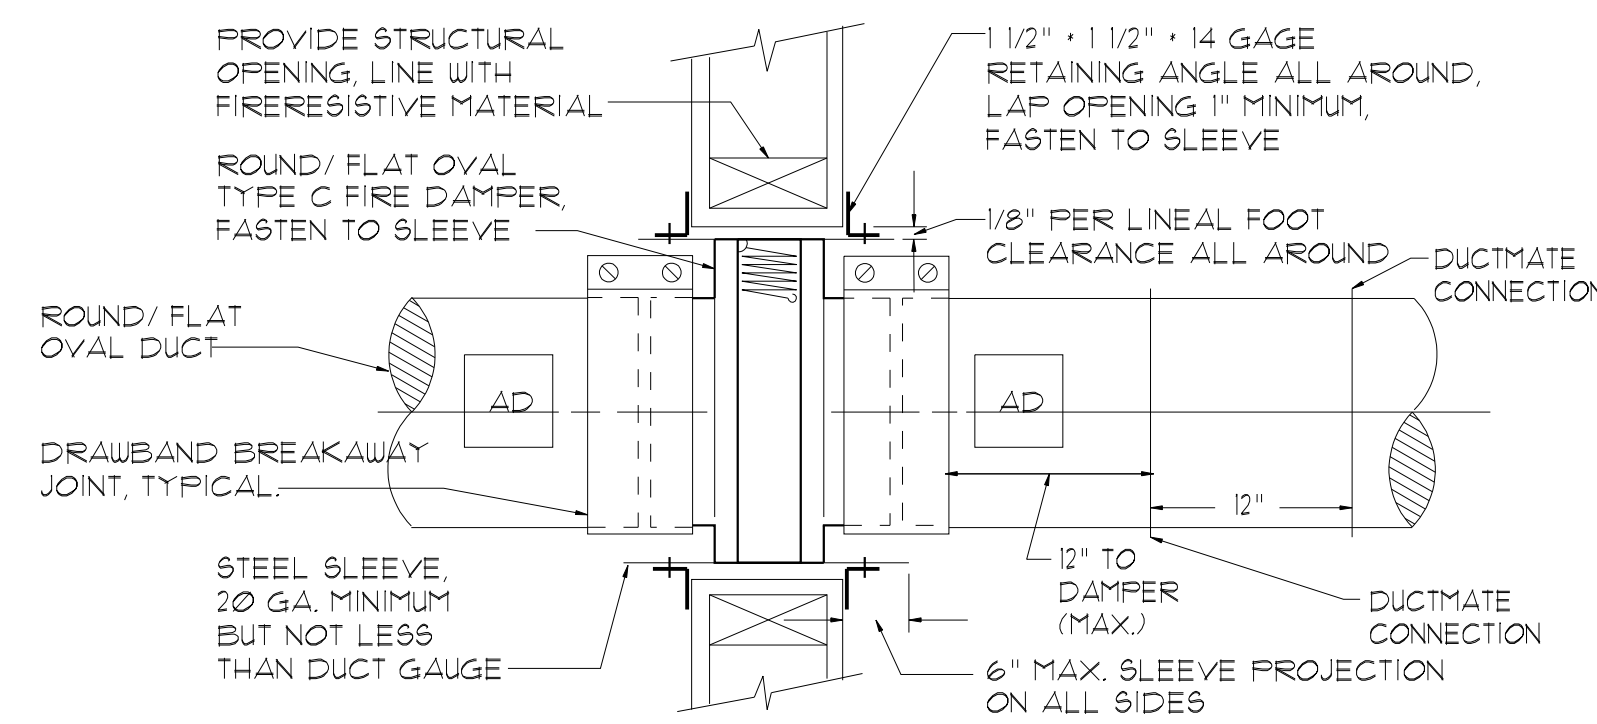


**ROUND/FLAT OVAL FIRE DAMPER INSTALLATION DETAIL  
 WHERE A 12x12 ACCESS DOOR IS NOT POSSIBLE**  
 NTS

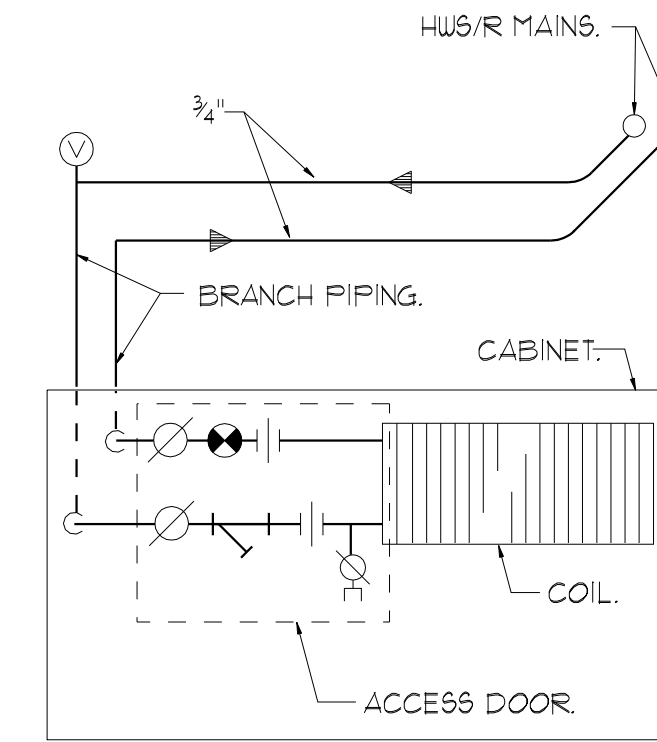

**CABINET UNIT HEATER  
 PIPING DETAIL**  
 NTS

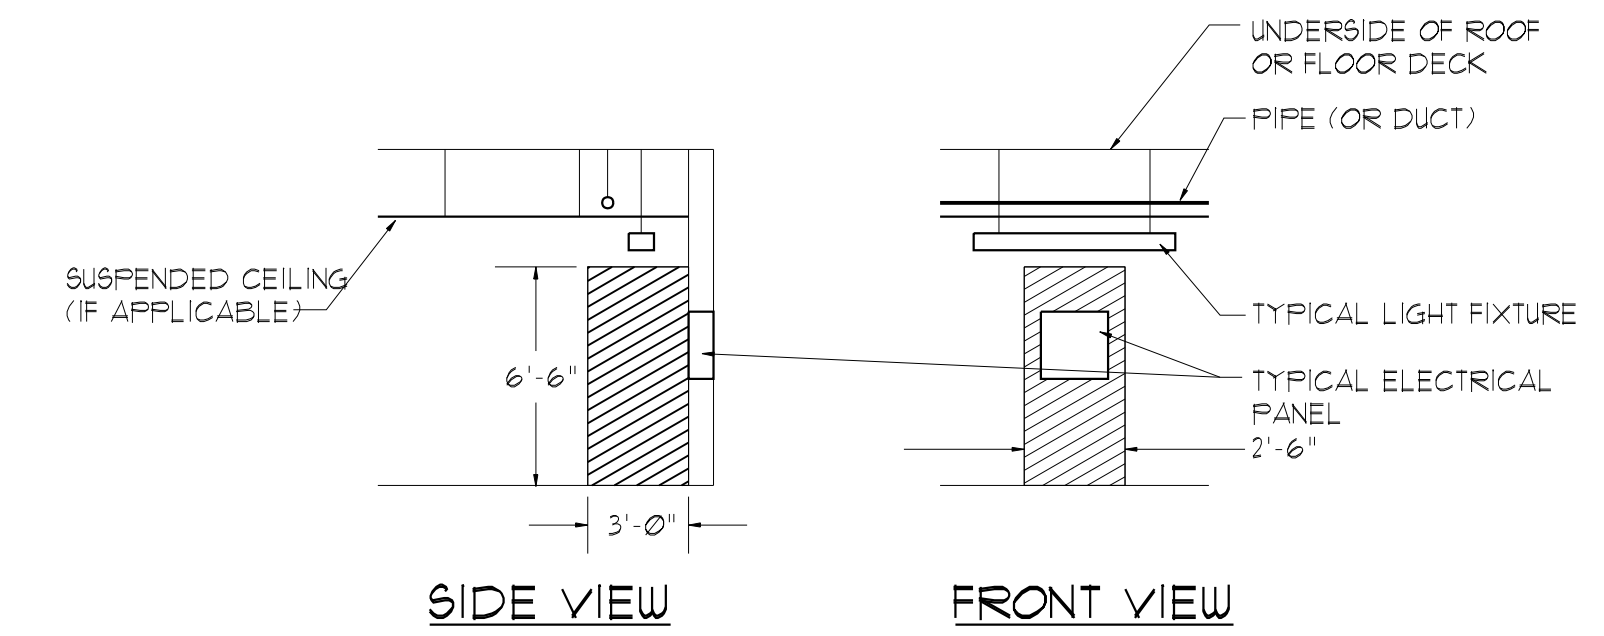


**CLEARANCES AT ELECTRICAL PANELS**  
 NTS

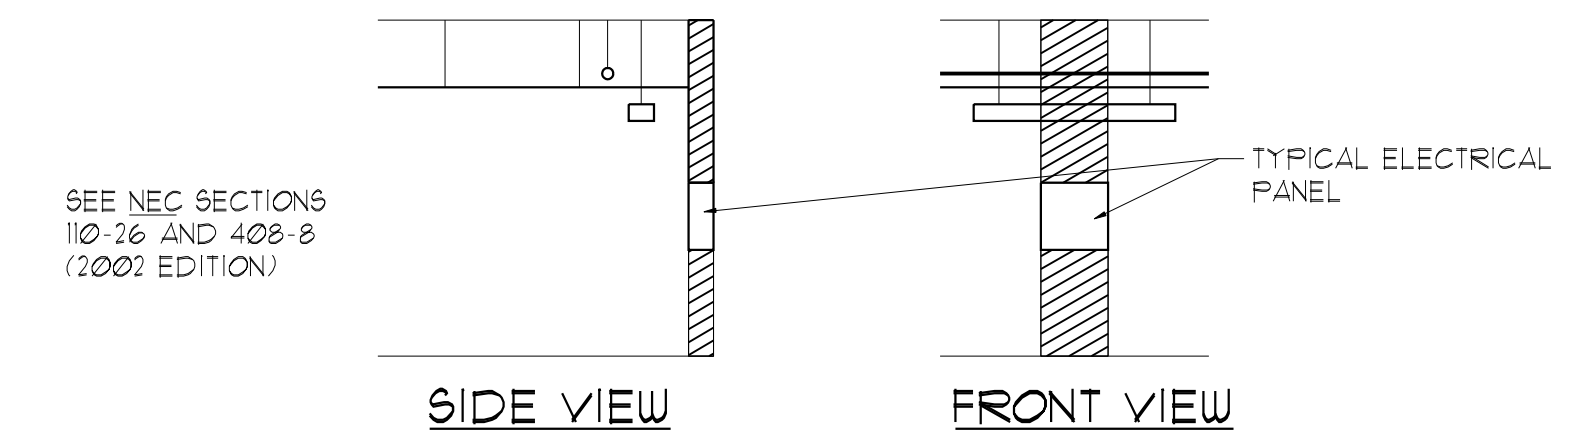


**CLEARANCES AT ELECTRICAL PANELS**  
 NTS


NOTE: NO DUCTWORK OR PIPING IS PERMITTED IN THE HATCHED AREAS.

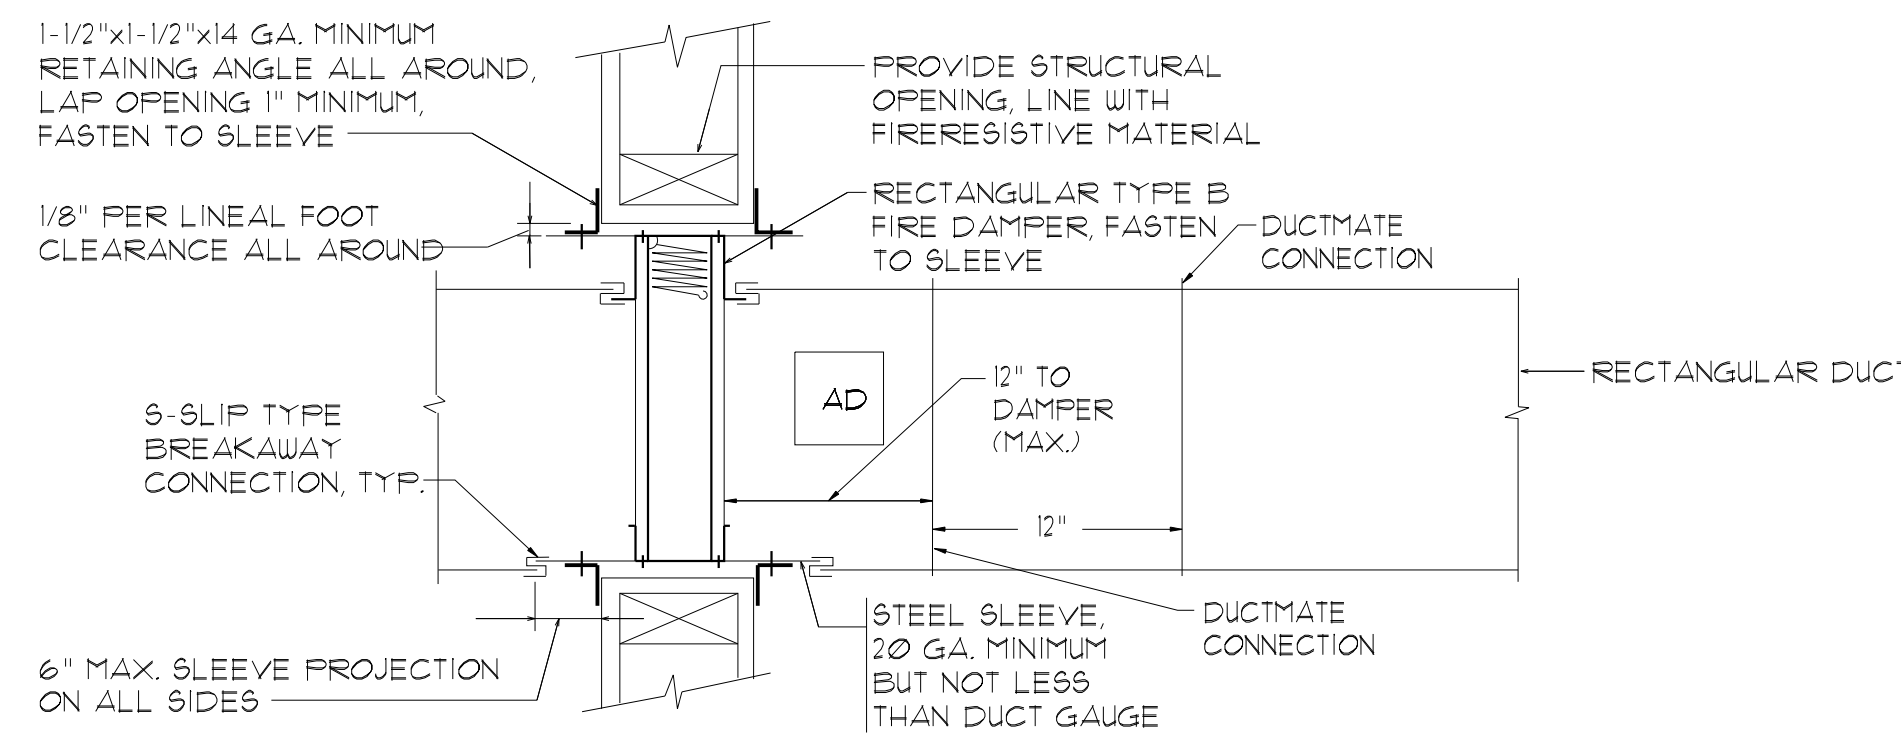


**RECTANGULAR FIRE DAMPER INSTALLATION DETAIL  
 WHERE 12x12 ACCESS DOOR IS NOT POSSIBLE**  
 NTS

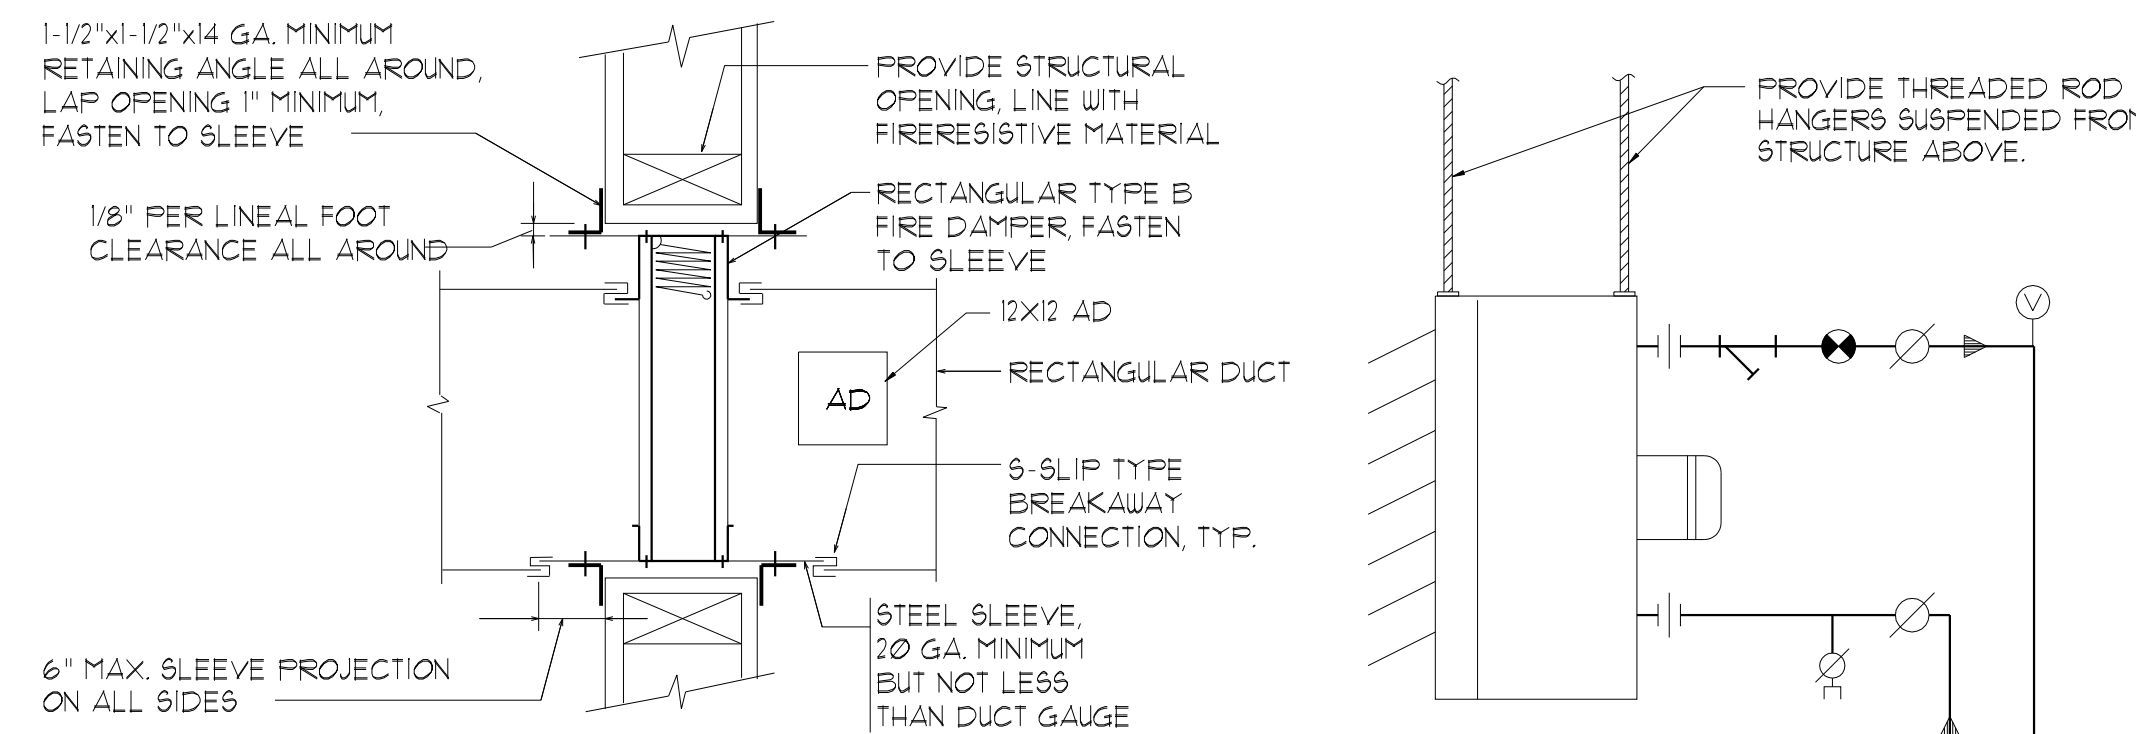


**RECTANGULAR FIRE DAMPER  
 INSTALLATION DETAIL**  
 NTS

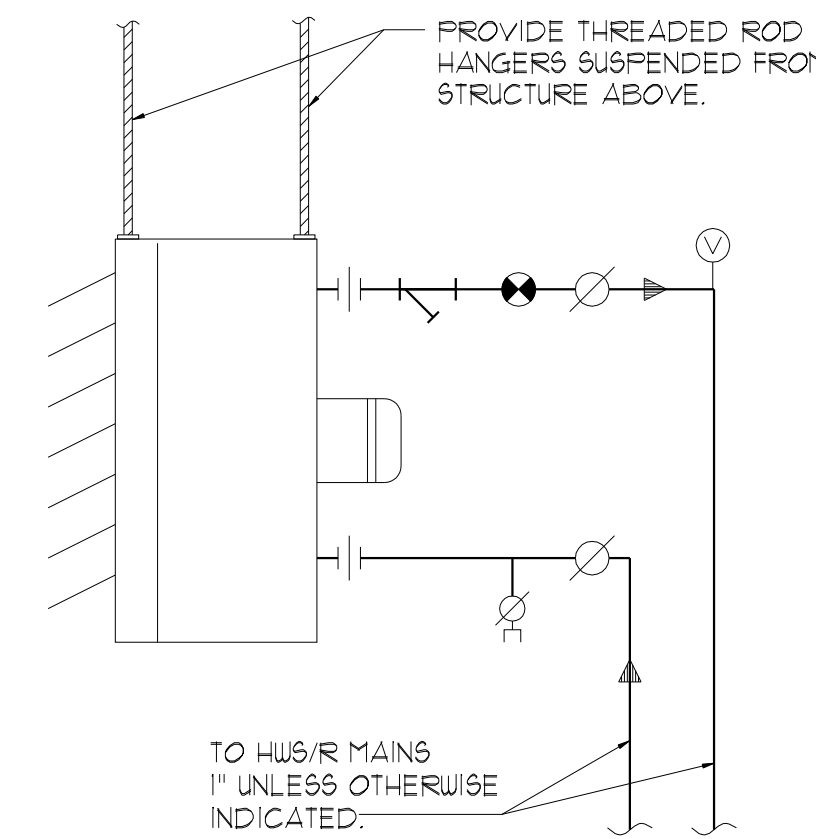

**HORIZONTAL UNIT HEATER  
 PIPING DETAIL**  
 NTS

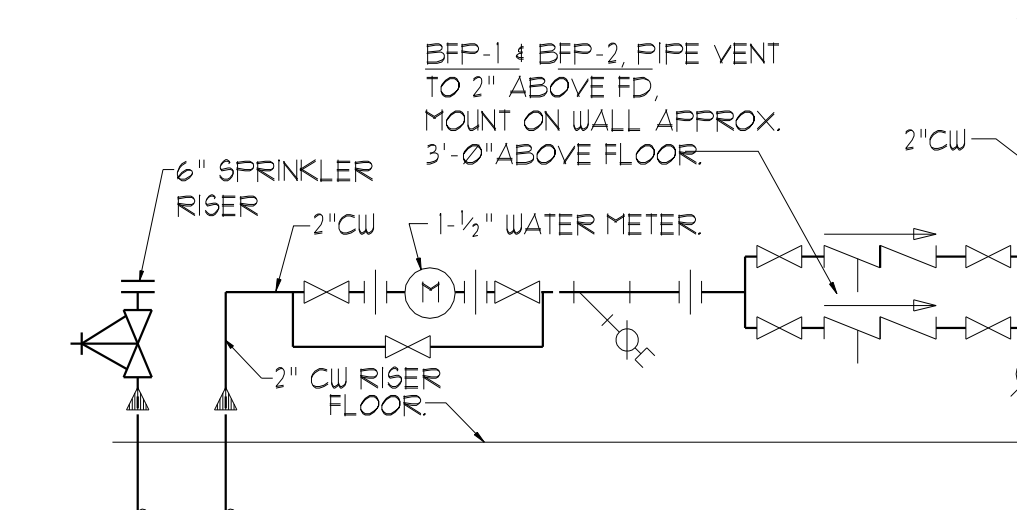


**WATER ENTRANCE DETAIL**  
 NTS

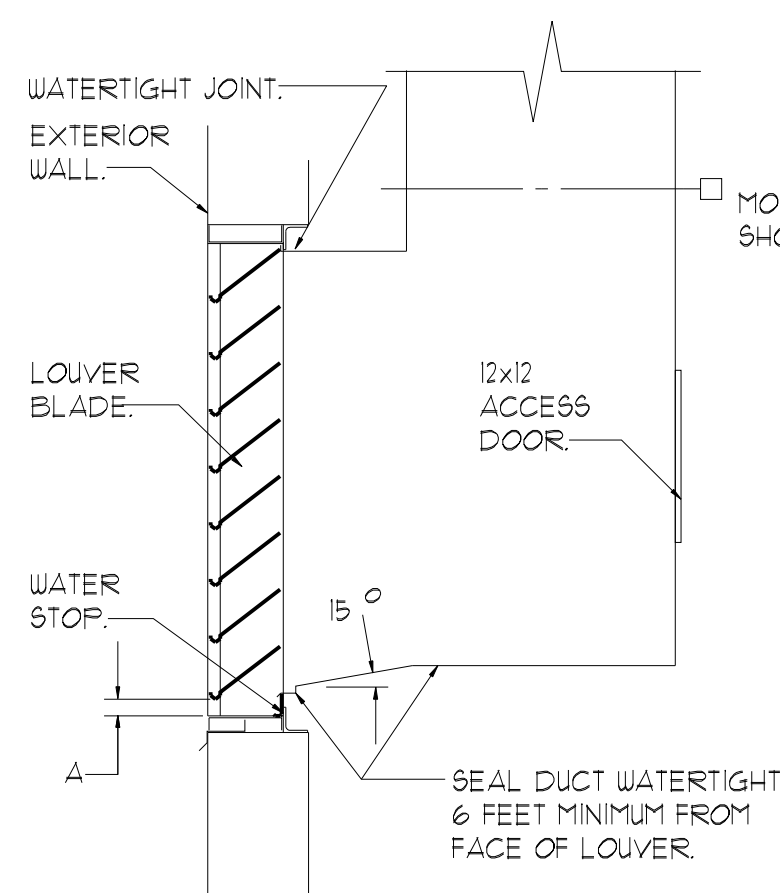


**LOUVER DETAIL WITH  
 DUCT FROM ABOVE**  
 NTS

NOTE: IF DIMENSION "A" IS LESS THAN 1 INCH SEE MODIFIED LOUVER DETAIL THIS SHEET.

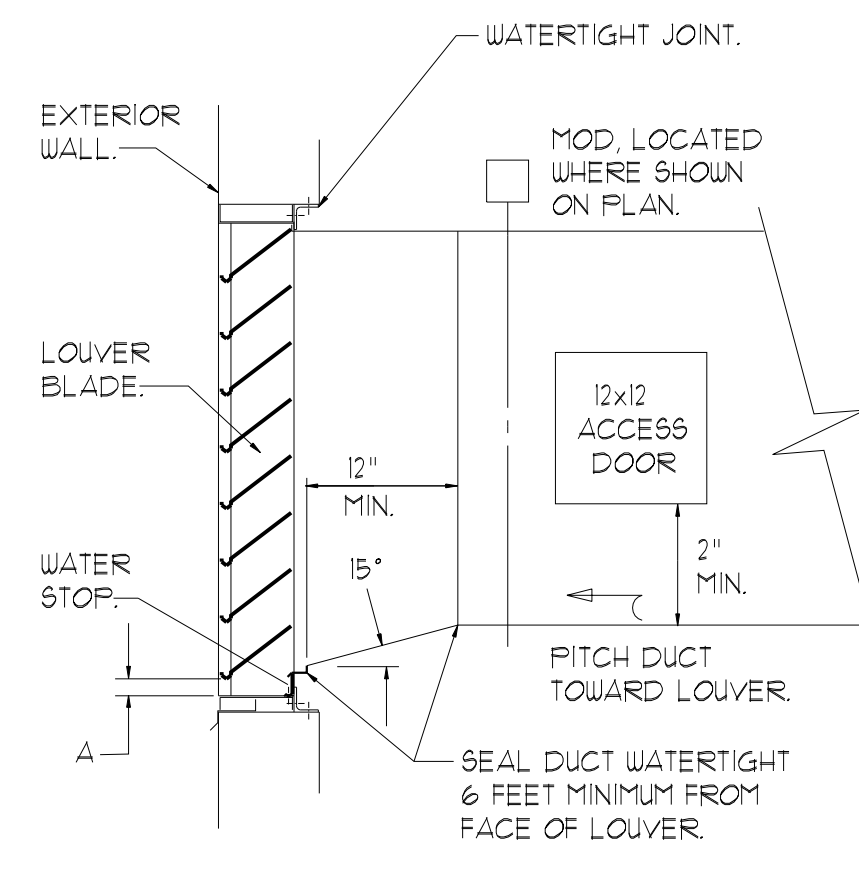


**LOUVER DETAIL WITH  
 HORIZONTAL DUCT**  
 NTS

NOTE: IF DIMENSION "A" IS LESS THAN 1 INCH SEE MODIFIED LOUVER DETAIL THIS SHEET.

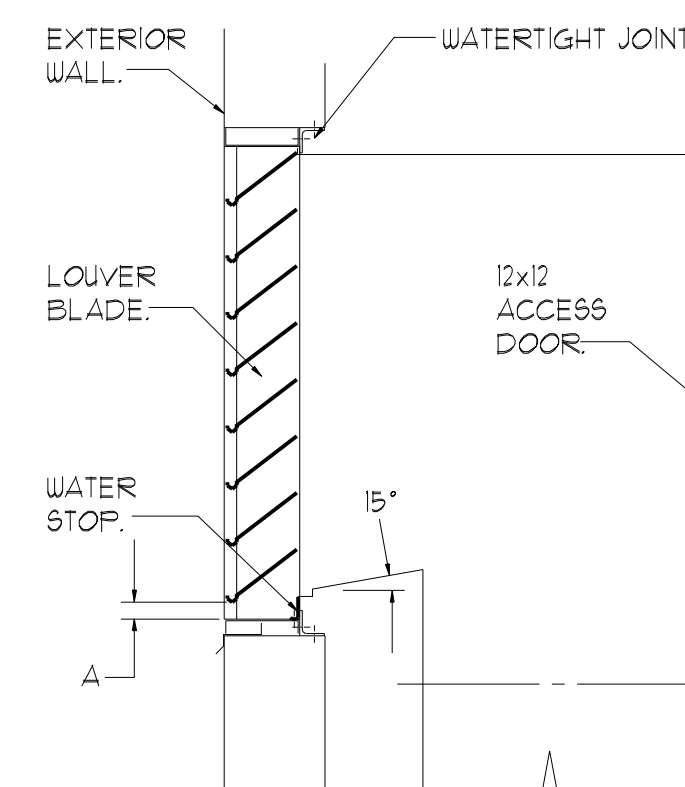


**LOUVER DETAIL WITH  
 DUCT FROM BELOW**  
 NTS

NOTE: IF DIMENSION "A" IS LESS THAN 1 INCH SEE MODIFIED LOUVER DETAIL THIS SHEET.

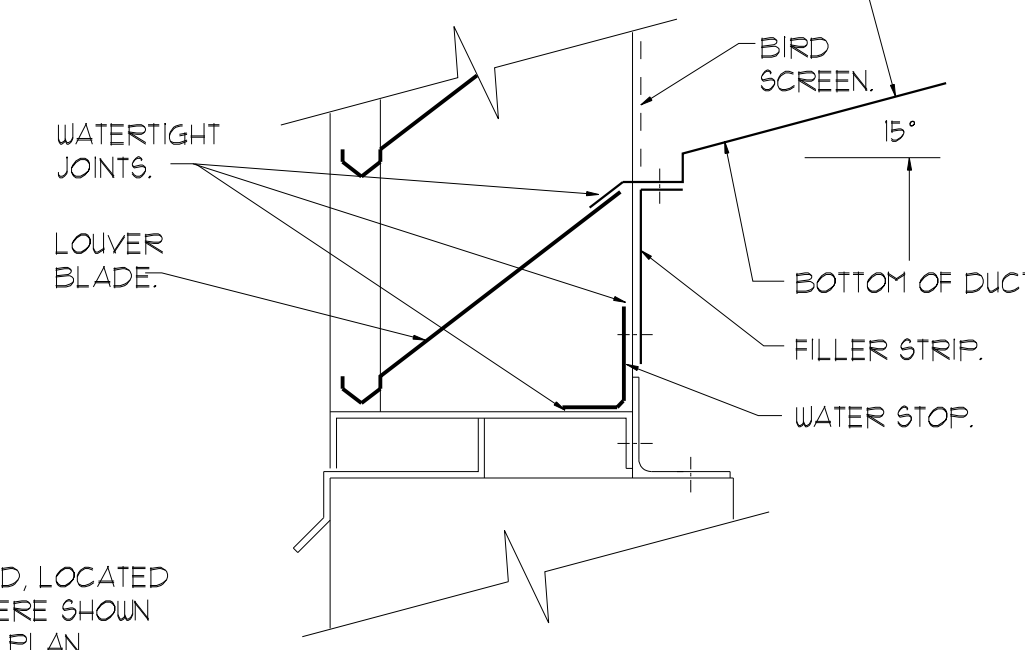


**MODIFIED LOUVER DETAIL**  
 NTS

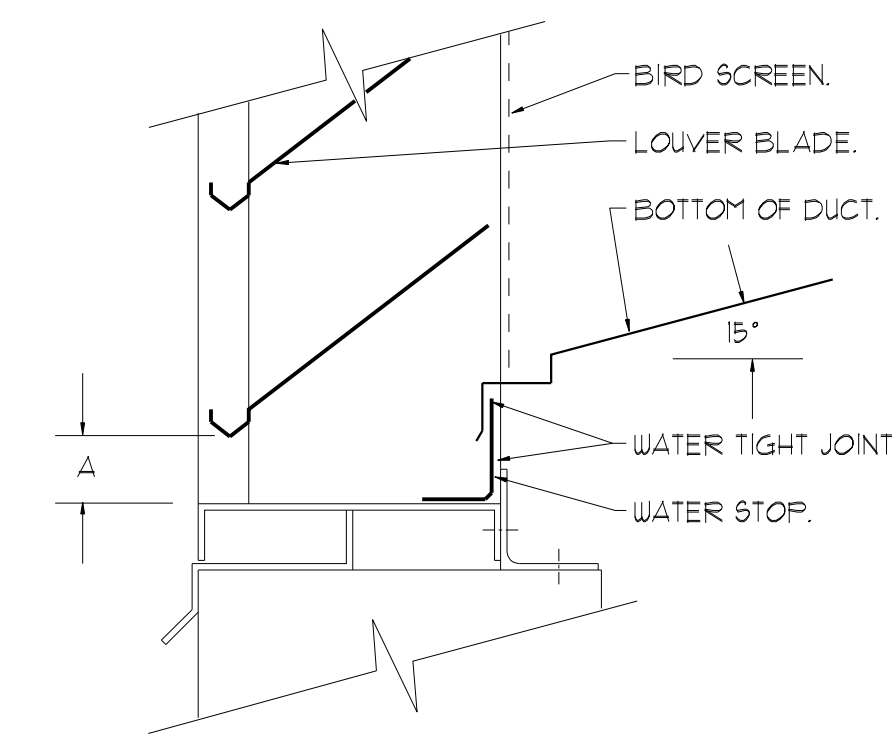

**LOUVER CONNECTION DETAIL**  
 NTS

NOTE: TYPICAL FOR LOUVERS AND BLOCK VENTS. IF DIMENSION "A" IS LESS THAN 1 INCH SEE MODIFIED LOUVER DETAIL THIS SHEET (LOUVERS ONLY).

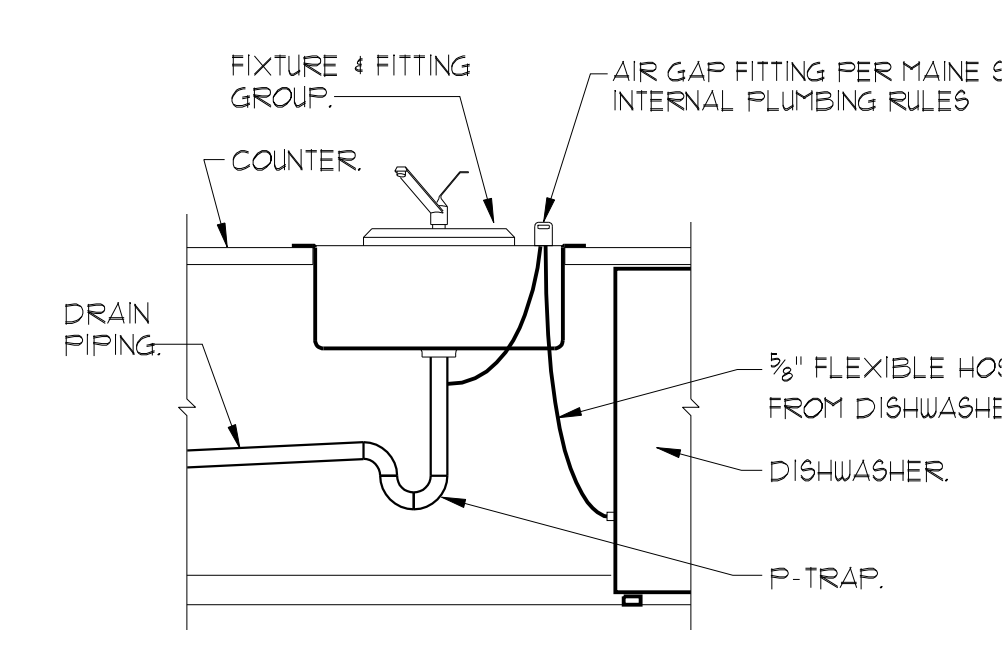

**DISHWASHER DRAIN DETAIL**  
 NTS

Owner: **FORE RIVER HOUSING LP**  
 C/O AVESTA  
 307 CUMBERLAND AVE  
 PORTLAND, MAINE 04101

**FORE RIVER APARTMENTS**  
 63 Frederic Street  
 Portland, Maine

Project No: 04416 FRA

Drawing Title:

**MECHANICAL DETAILS**

Scale: AS NOTED

Date: 02/21/2005

Revisions:

- ▲
- ▲
- ▲
- ▲
- ▲

Drawing Number:

**M3.3**