


- NOTES:
1. SIMPSON HANGERS TO BE ZMAX.
 2. FASTENERS TO BE HOT DIP GALVANIZED.

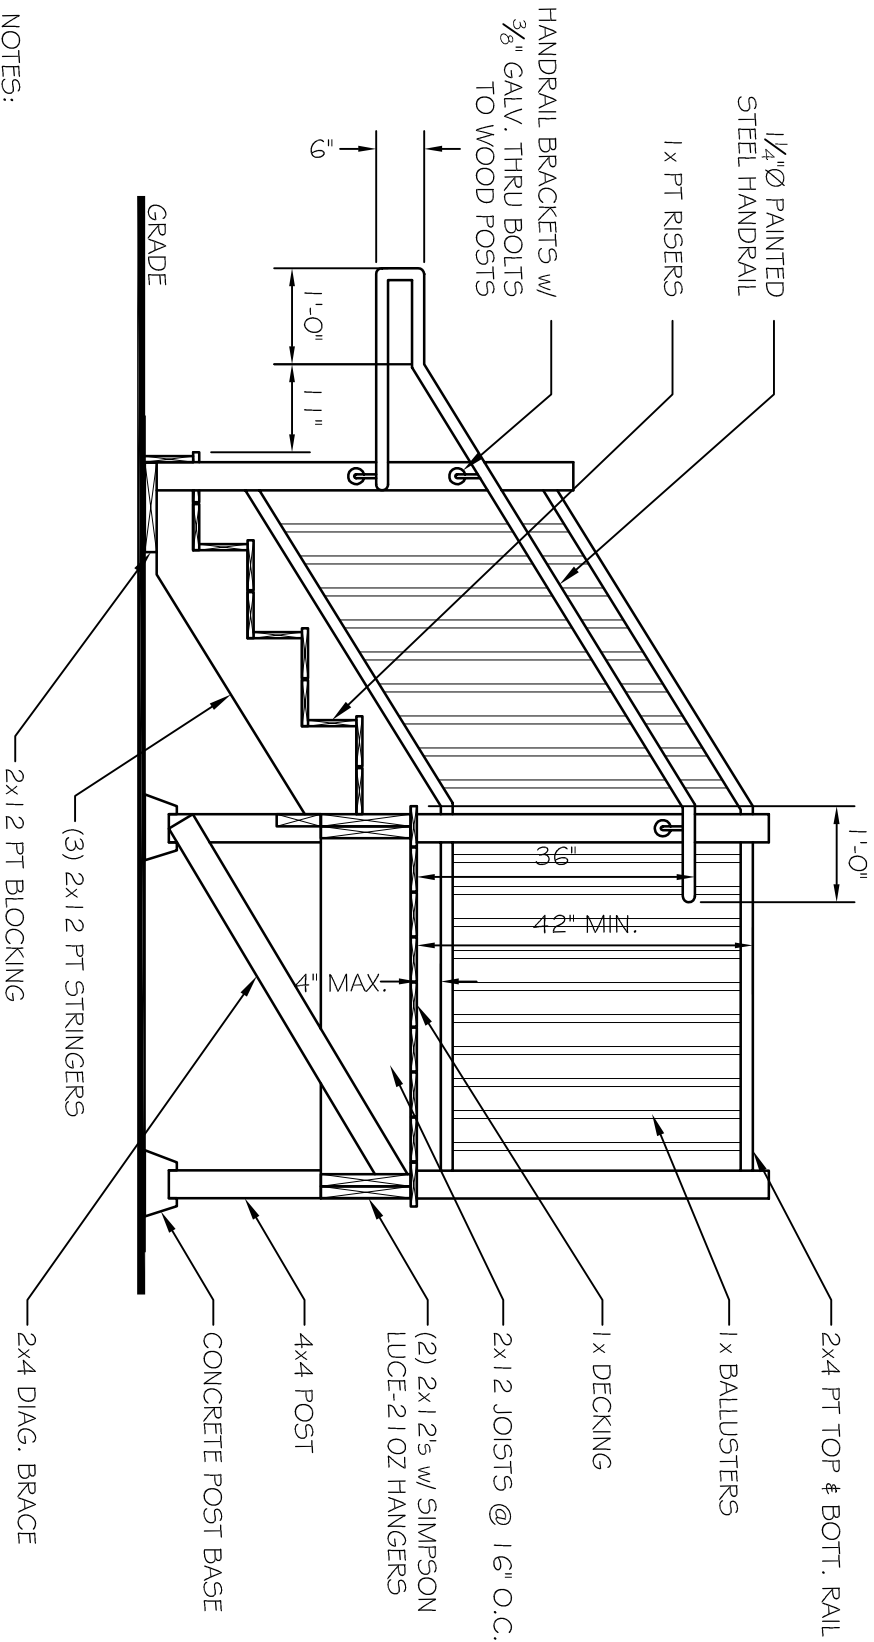

ASSOCIATED DESIGN PARTNERS INC.

80 Leighton Road
 Falmouth, Maine 04105
 Office: (207) 878-1751
 Fax: (207) 878-1788
 E-Mail: odp@odpengineering.com

THIS DRAWING, DESIGN AND ELECTRICAL PLAN ARE THE PROPERTY OF ASSOCIATED DESIGN PARTNERS INC. THE INFORMATION CONTAINED ON ANY OTHER USE OF THIS DOCUMENT WITHOUT WRITTEN CONSENT IS PROHIBITED.

PROJECT: **BARBER FOODS - TRAILER STAIRS**
PORTLAND, MAINE
 FOR: BARBER FOODS

SHEET TITLE: **STAR SECTION A**

REVISIONS

No.	BY	DESCRIPTION	DATE

DATE : 10-3-08

SCALE : 1/2"=1'-0"

DESIGN BY: ASW

DRAWN BY: RSC

FILE #: 08170-A11MG

PROJECT NUMBER:

08170

SHEET NO:

A2