


Venting / Floor Plan

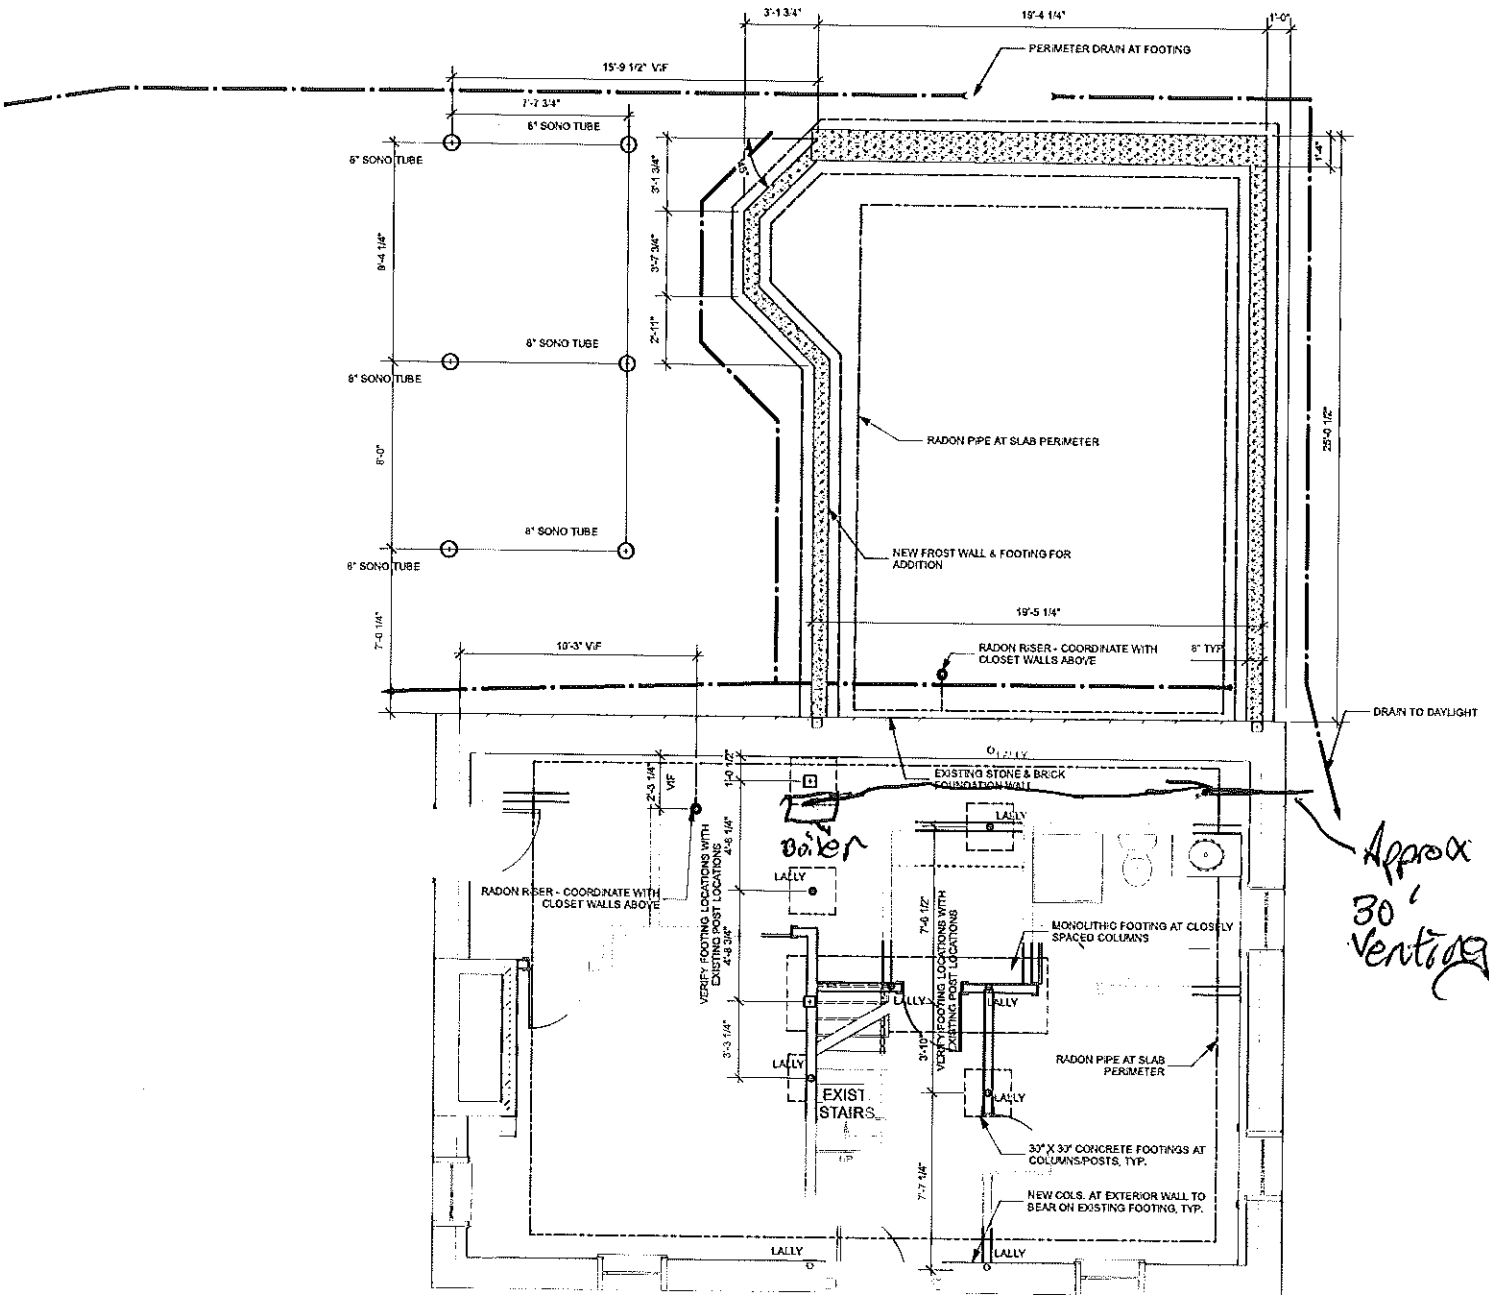

1 Foundation Plan
Scale: 1/4" = 1'-0"