

Consultant
 Civil Engineer
 Duluc-Hoffmann Associates, Inc.
 728 Main Street, Suite 806
 Harrisburg, PA 17105
 Phone: (717) 755-1211
 Fax: (717) 879-0888

Consultant
 ASPECT ARCHITECT/STRUCTURAL ENGINEER
 5000 North State St. Box 618
 Harrisburg, PA 17104
 Phone: (717) 772-2846
 Fax: (717) 772-1070

Consultant
 MECHANICAL/ELECTRICAL ENGINEER
 BIRD, BOG & ARBONAS Consulting Engineers, LLC
 311 Arsenal Street, 3rd Floor
 Harrisburg, PA 17102
 Phone: (717) 254-0012
 Fax: 617/924-9339

Consultant
 EQUIPMENT PLANNING
 Equipment Planning, Inc.
 1895 General George Patton Drive
 Franklin, Tennessee 37067
 Phone: (615) 376-3114
 Fax: (615) 376-3114

Consultant
 CONSTRUCTION MANAGER
 Construction Management
 7 Jackson Way
 Harrisburg, PA 17106
 Phone: (417) 486-8900
 Fax: (417) 486-5516

Consultant
 Interior Finish
 Innon Finishworks, LLC
 1828 West End Ave. Suite 1400
 Harrisburg, PA 17104
 Phone: (610) 321-4591
 Fax: (610) 321-5889

Owner/General Contractor and all other subcontractors shall be responsible for obtaining all necessary permits and ensuring compliance with all applicable codes before proceeding with any work.

Date: 11/10/06 FINAL - ISSUE FOR BID
 Drawn By: MAF/JUL/CLB/DJM
 Scale: AS NOTED

Francis


Coffman

Foley

Hoffmann

Francis, Coffman
 Foley Hoffmann
 Architects Ltd.
 3120 Arch Street
 Philadelphia, PA 19103
 215-568-8250

Project Title
 Mercy Health Care
 System of Maine
 FORE RIVER SHORT
 STAY HOSPITAL

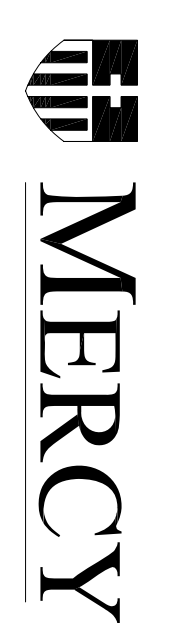

Project Number
 F05-4898

Covering The end Number
 Ground Floor Plan

A1.00A

1 GROUND FLOOR PLAN
 1/8"=1'-0"

