

1 FIRST FLOOR PLAN
A1.01B 1/8"=1'-0"

Consultant
OWNER
Bellevue-Hoffmann Associates, Inc.
726 Main Street, Suite 8
Portland, ME 04106
Phone: (207) 775-1121
Fax: (207) 879-0888

Consultant
ASSOCIATE ARCHITECT/STRUCTURAL ENGINEER
SMART
One Sheet Point Box 618
Portland, ME 04106
Phone: (207) 772-3846
Fax: (207) 772-1070

Consultant
MECHANICAL/ELECTRICAL ENGINEER
Burd, Ross + Anusca Consulting Engineers, LLC
311 Arsenal Street
Portland, ME 04102-2789
Phone: (207) 462-7299
Fax: 8179249339

Consultant
EQUIPMENT PLANNING
Equipment Planning
1805 General George Patton Drive
Franklin, Tennessee 37067
Phone: (615) 376-3114
Fax: (615) 376-3114

Consultant
CONSTRUCTION MANAGER
7 Johnson Wilsey
Portland, ME 04106
Phone: (407) 456-5516
Fax: (407) 456-5516

Consultant
FOOD SERVICES
Hoffmann Associates, LLC
1808 West End Ave Suite 1400
Portland, ME 04102
Phone: (615) 321-5591
Fax: (615) 321-5588

Drawn By
MAF/JUL/CLB/CJL
Scale
AS NOTED

Date
11/10/06 FINAL - ISSUE FOR BID


Francis

Coffman

Foley

Hoffmann

Project Title
Mercy Health Care
System of Maine
FORE RIVER SHORT
STAY HOSPITAL

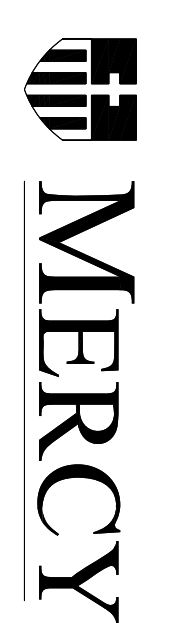

Project Number
F05-4898
Drawing Title and Number
FIRST FLOOR PLAN

A1.01B