

Consultant:
Francis, Hoffmann, Architects, Inc.
778 Main Street, Suite 8
Providence, Rhode Island 02903
Phone: (401) 775-1121
Fax: (401) 879-0886

Consultant:
ASSOCIATE ARCHITECT/STRUCTURAL ENGINEER
144 Fore Street #10, Box 618
Providence, Rhode Island 02903
Phone: (401) 772-3846
Fax: (401) 772-1070

Consultant:
MECHANICAL/ELECTRICAL ENGINEER
Bird, Roe & Associates
311 Arsenal Street
Westerly, RI 02891
Phone: (401) 824-8339
Fax: (401) 824-8339

Consultant:
EQUIPMENT PLANNING
Dodge Brothers & Associates
1000 North Main Street
Providence, Rhode Island 02907
Phone: (401) 326-3114
Fax: (401) 326-3114

Consultant:
CONSTRUCTION MANAGER
7 Jackson Mall
Providence, Rhode Island 02903
Phone: (401) 458-5816
Fax: (401) 458-5816

Consultant:
FOOD SERVICE
Francis, Hoffmann, Architects, Inc.
1808 West End Ave, Suite 1400
Providence, Rhode Island 02903
Phone: (401) 721-5591
Fax: (401) 321-5889

Notes:
1. The construction of this construction manager/designer contract and all other conditions of work shall be defined in the contract documents.
2. Proceeding with any work.


Date: 11/10/06 Find-Issued For Construction
Drawn By: ART/KD
Scale: AS NOTED

Francis
Cauffman

Foley
Hoffmann

Project Title:
Mercy Health Care
System of Maine
FORE RIVER SHORT
STAY HOSPITAL

Project Location:
2100 Main Street
Providence, Rhode Island 02903
Phone: (401) 215-5886
Fax: (401) 215-5886

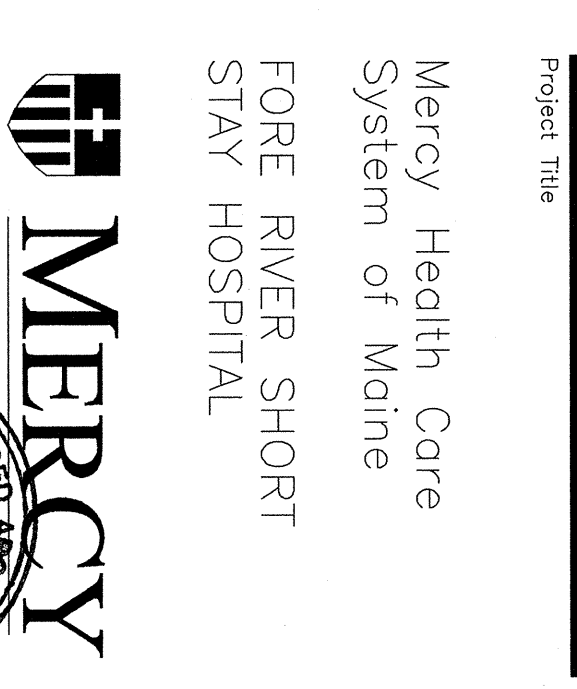

Project Number:
F05-4999
Drawing Title and Number:
Third Floor Plan 8.20.06

A1.03A

