

Consultant
 OHL ENGINEER Associates, Inc.
 778 Main Street, Suite 8
 South Portland, ME 04106
 Phone: (207) 772-3846
 Fax: (207) 879-0886

Consultant
 ASSOCIATE ARCHITECT/STRUCTURAL ENGINEER
 144 Fore Street P.O. Box 618
 Portland, ME 04101
 Phone: (207) 772-3846
 Fax: (207) 772-1070

Consultant
 WOODS BAGOT, Architectural Engineer
 1000 Main Street, Suite 200
 Portland, ME 04101
 Phone: (207) 772-3846
 Fax: (207) 772-1070

Consultant
 GARE BURTON & ASSOCIATES
 1000 Main Street, Suite 200
 Portland, ME 04101
 Phone: (207) 772-3846
 Fax: (207) 772-1070

Consultant
 CONSTRUCTION MANAGER
 WILSON BROTHERS COMPANY
 1000 Main Street, Suite 200
 Portland, ME 04101
 Phone: (207) 772-3846
 Fax: (207) 772-1070

Consultant
 FOOD SERVICE
 1000 Main Street, Suite 200
 Portland, ME 04101
 Phone: (207) 772-3846
 Fax: (207) 772-1070

It is the responsibility of the Construction Sub-Contractors to verify all dimensions and trades before proceeding with any work.

Date: 11/10/06
 Drawn By: ART/KD
 Scale: AS NOTED

Francis
 Cauffman


Foley
 Hoffmann

Project Title
 Mercy Health Core
 System of Maine
 FORE RIVER SHORT
 STAY HOSPITAL

Project Number
 05-4969

Project Name
 FORE RIVER SHORT
 STAY HOSPITAL

Project Location
 FORE RIVER SHORT
 STAY HOSPITAL

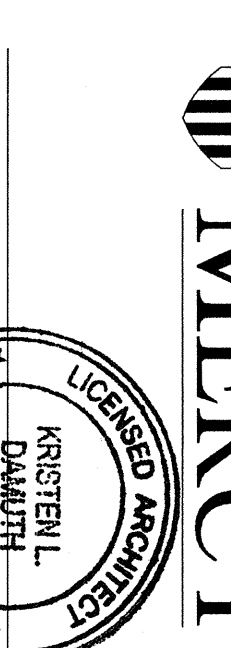

Project Number
 05-4969
 Drawing Title and Number
 Third Floor Plan
 A1.03B

Project Name
 FORE RIVER SHORT
 STAY HOSPITAL